
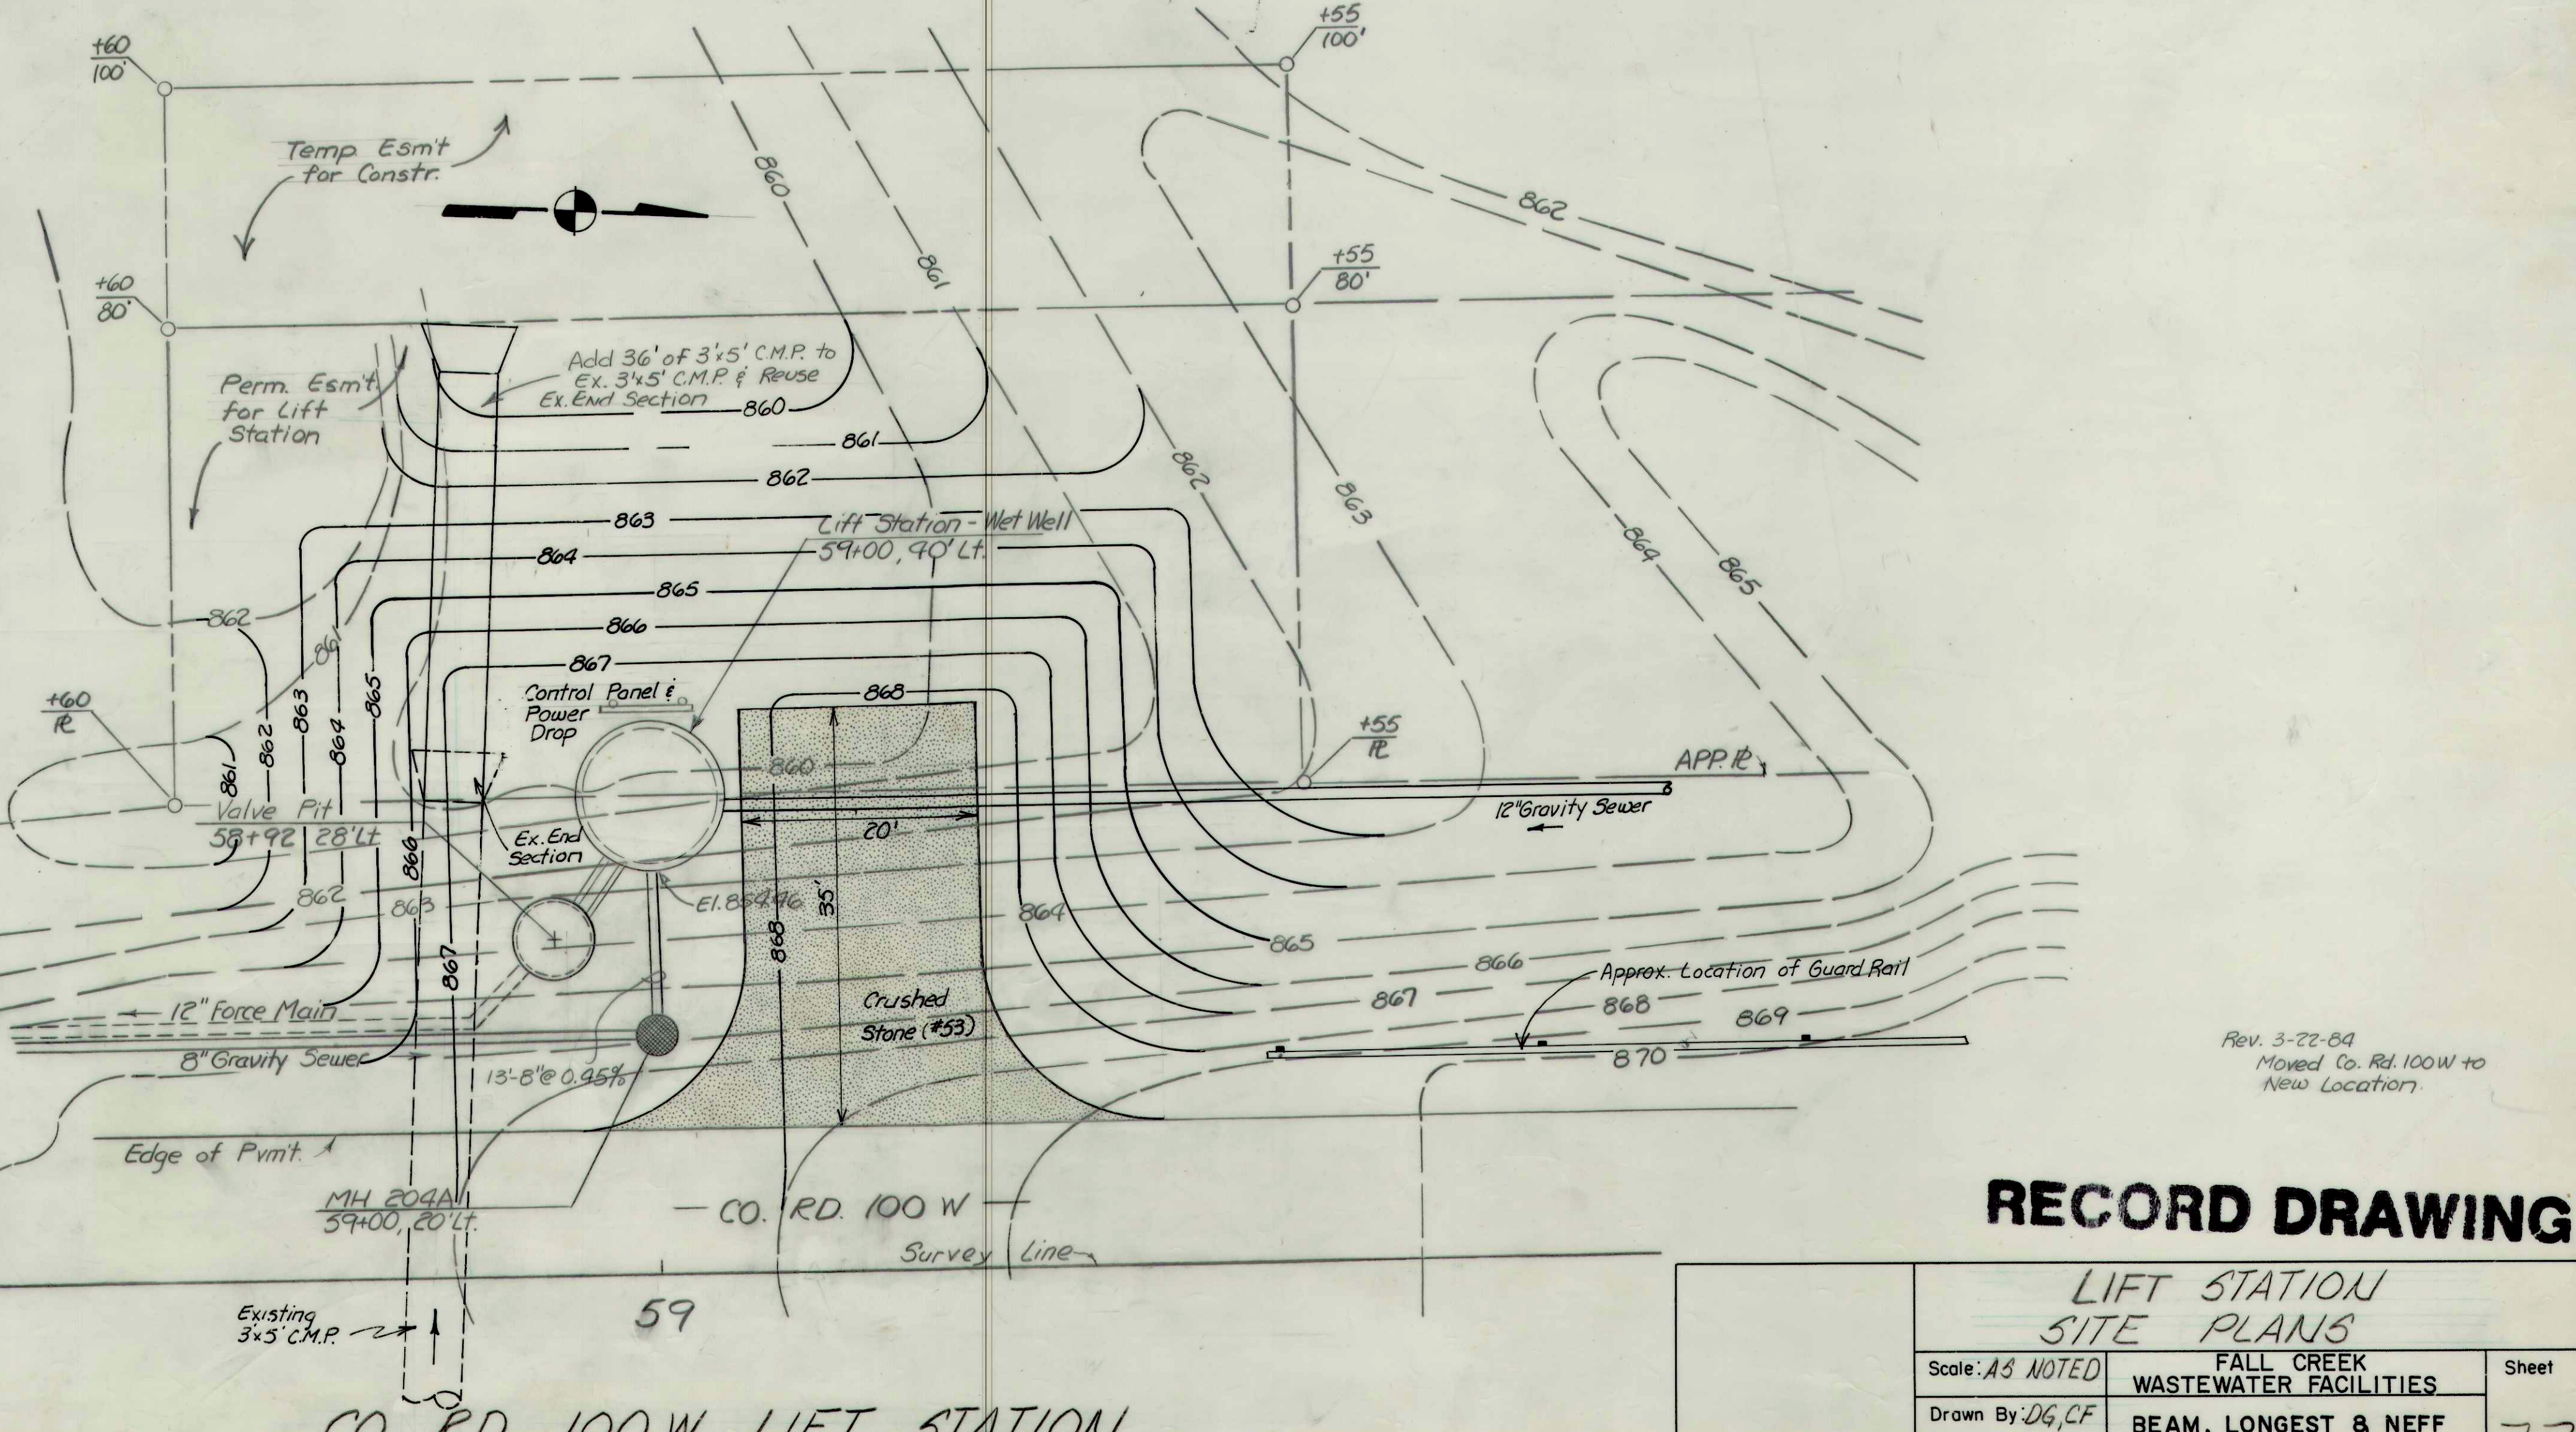
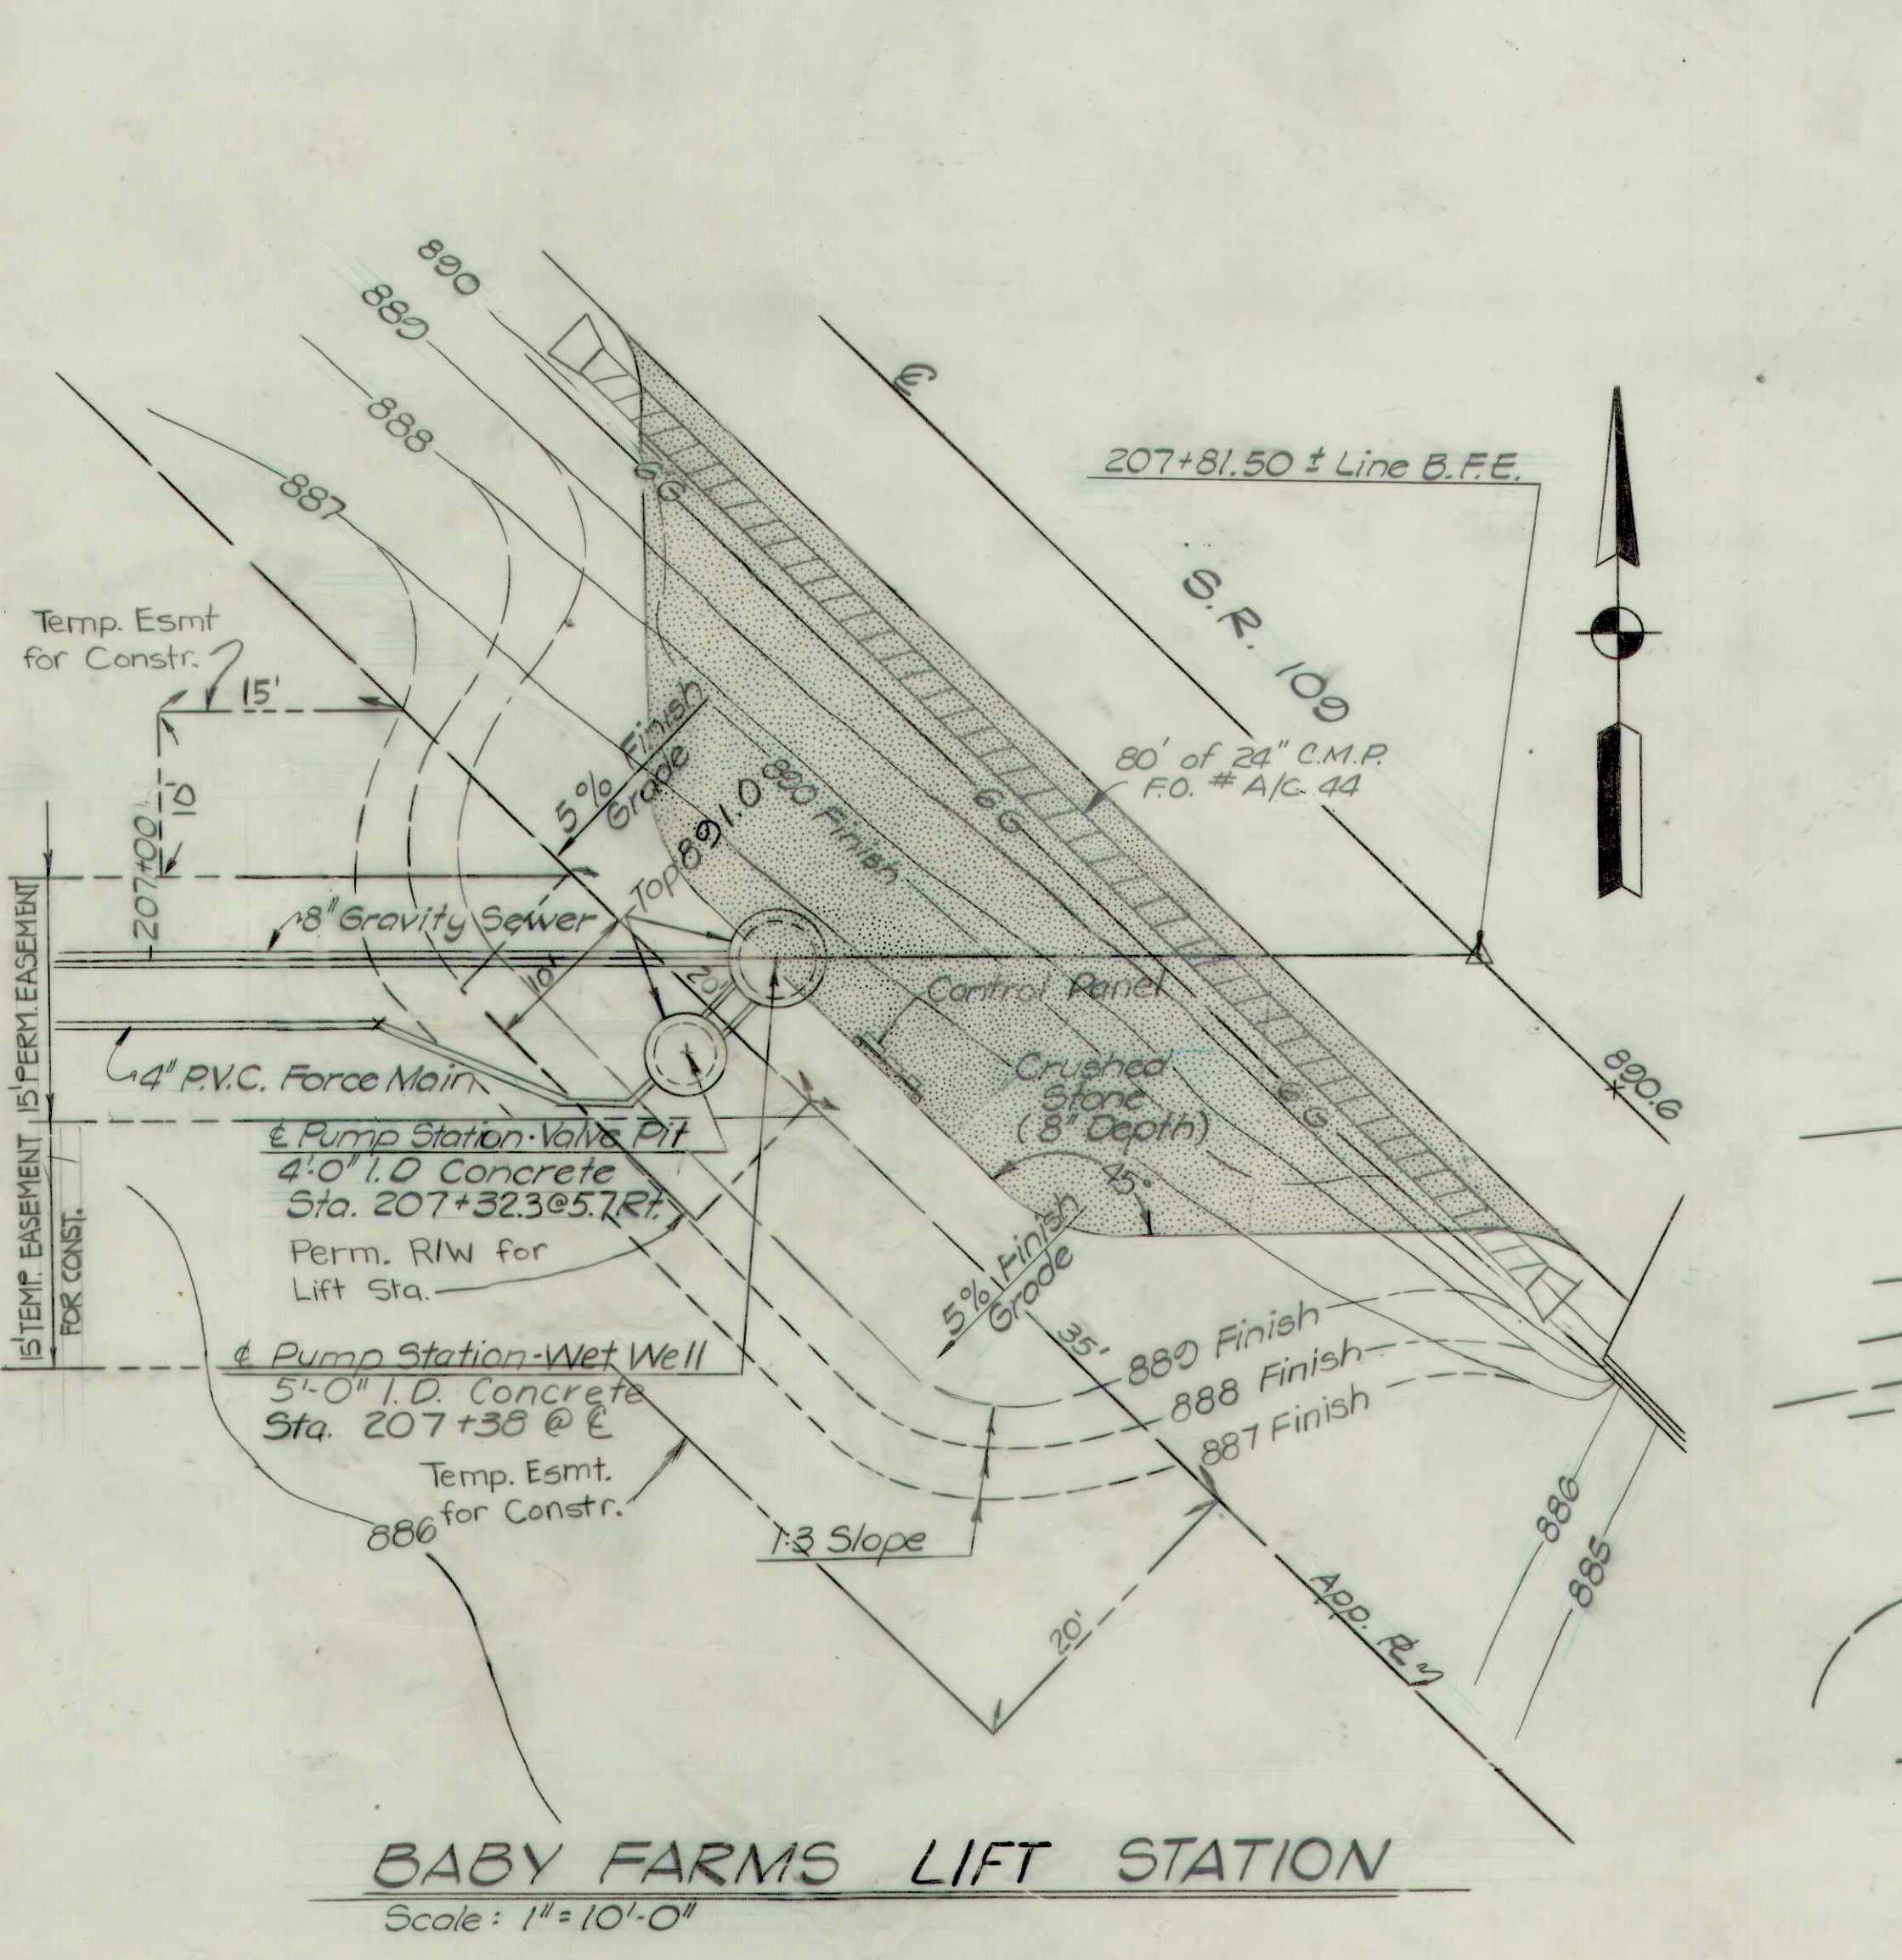
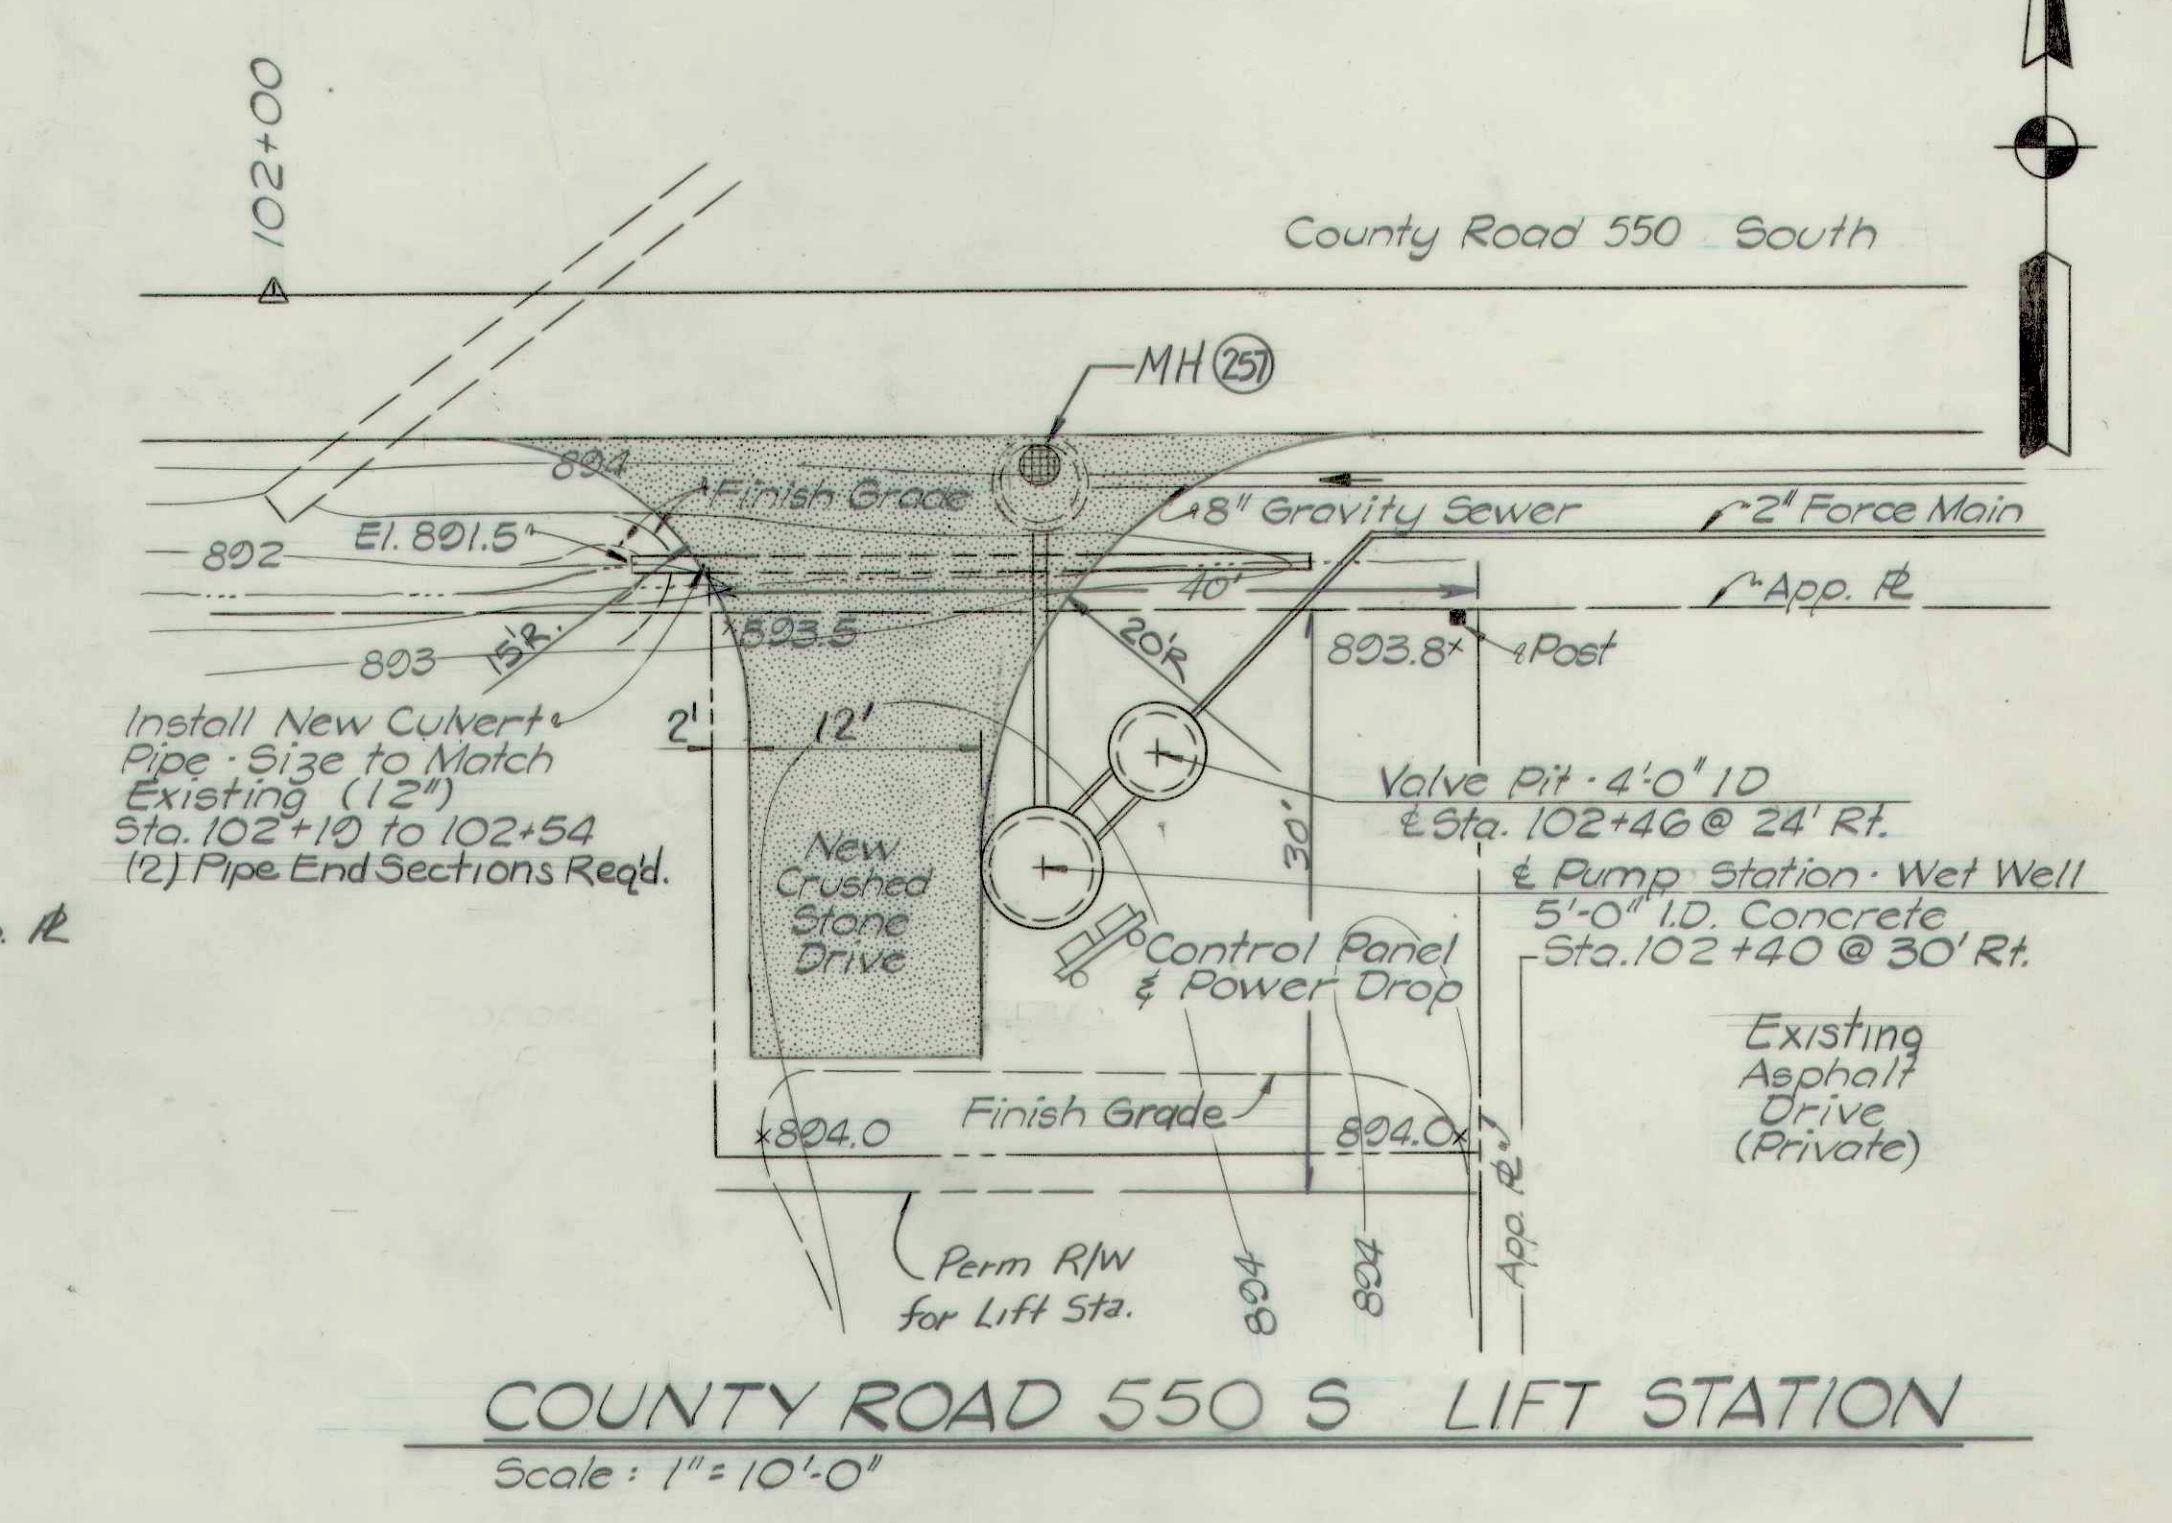
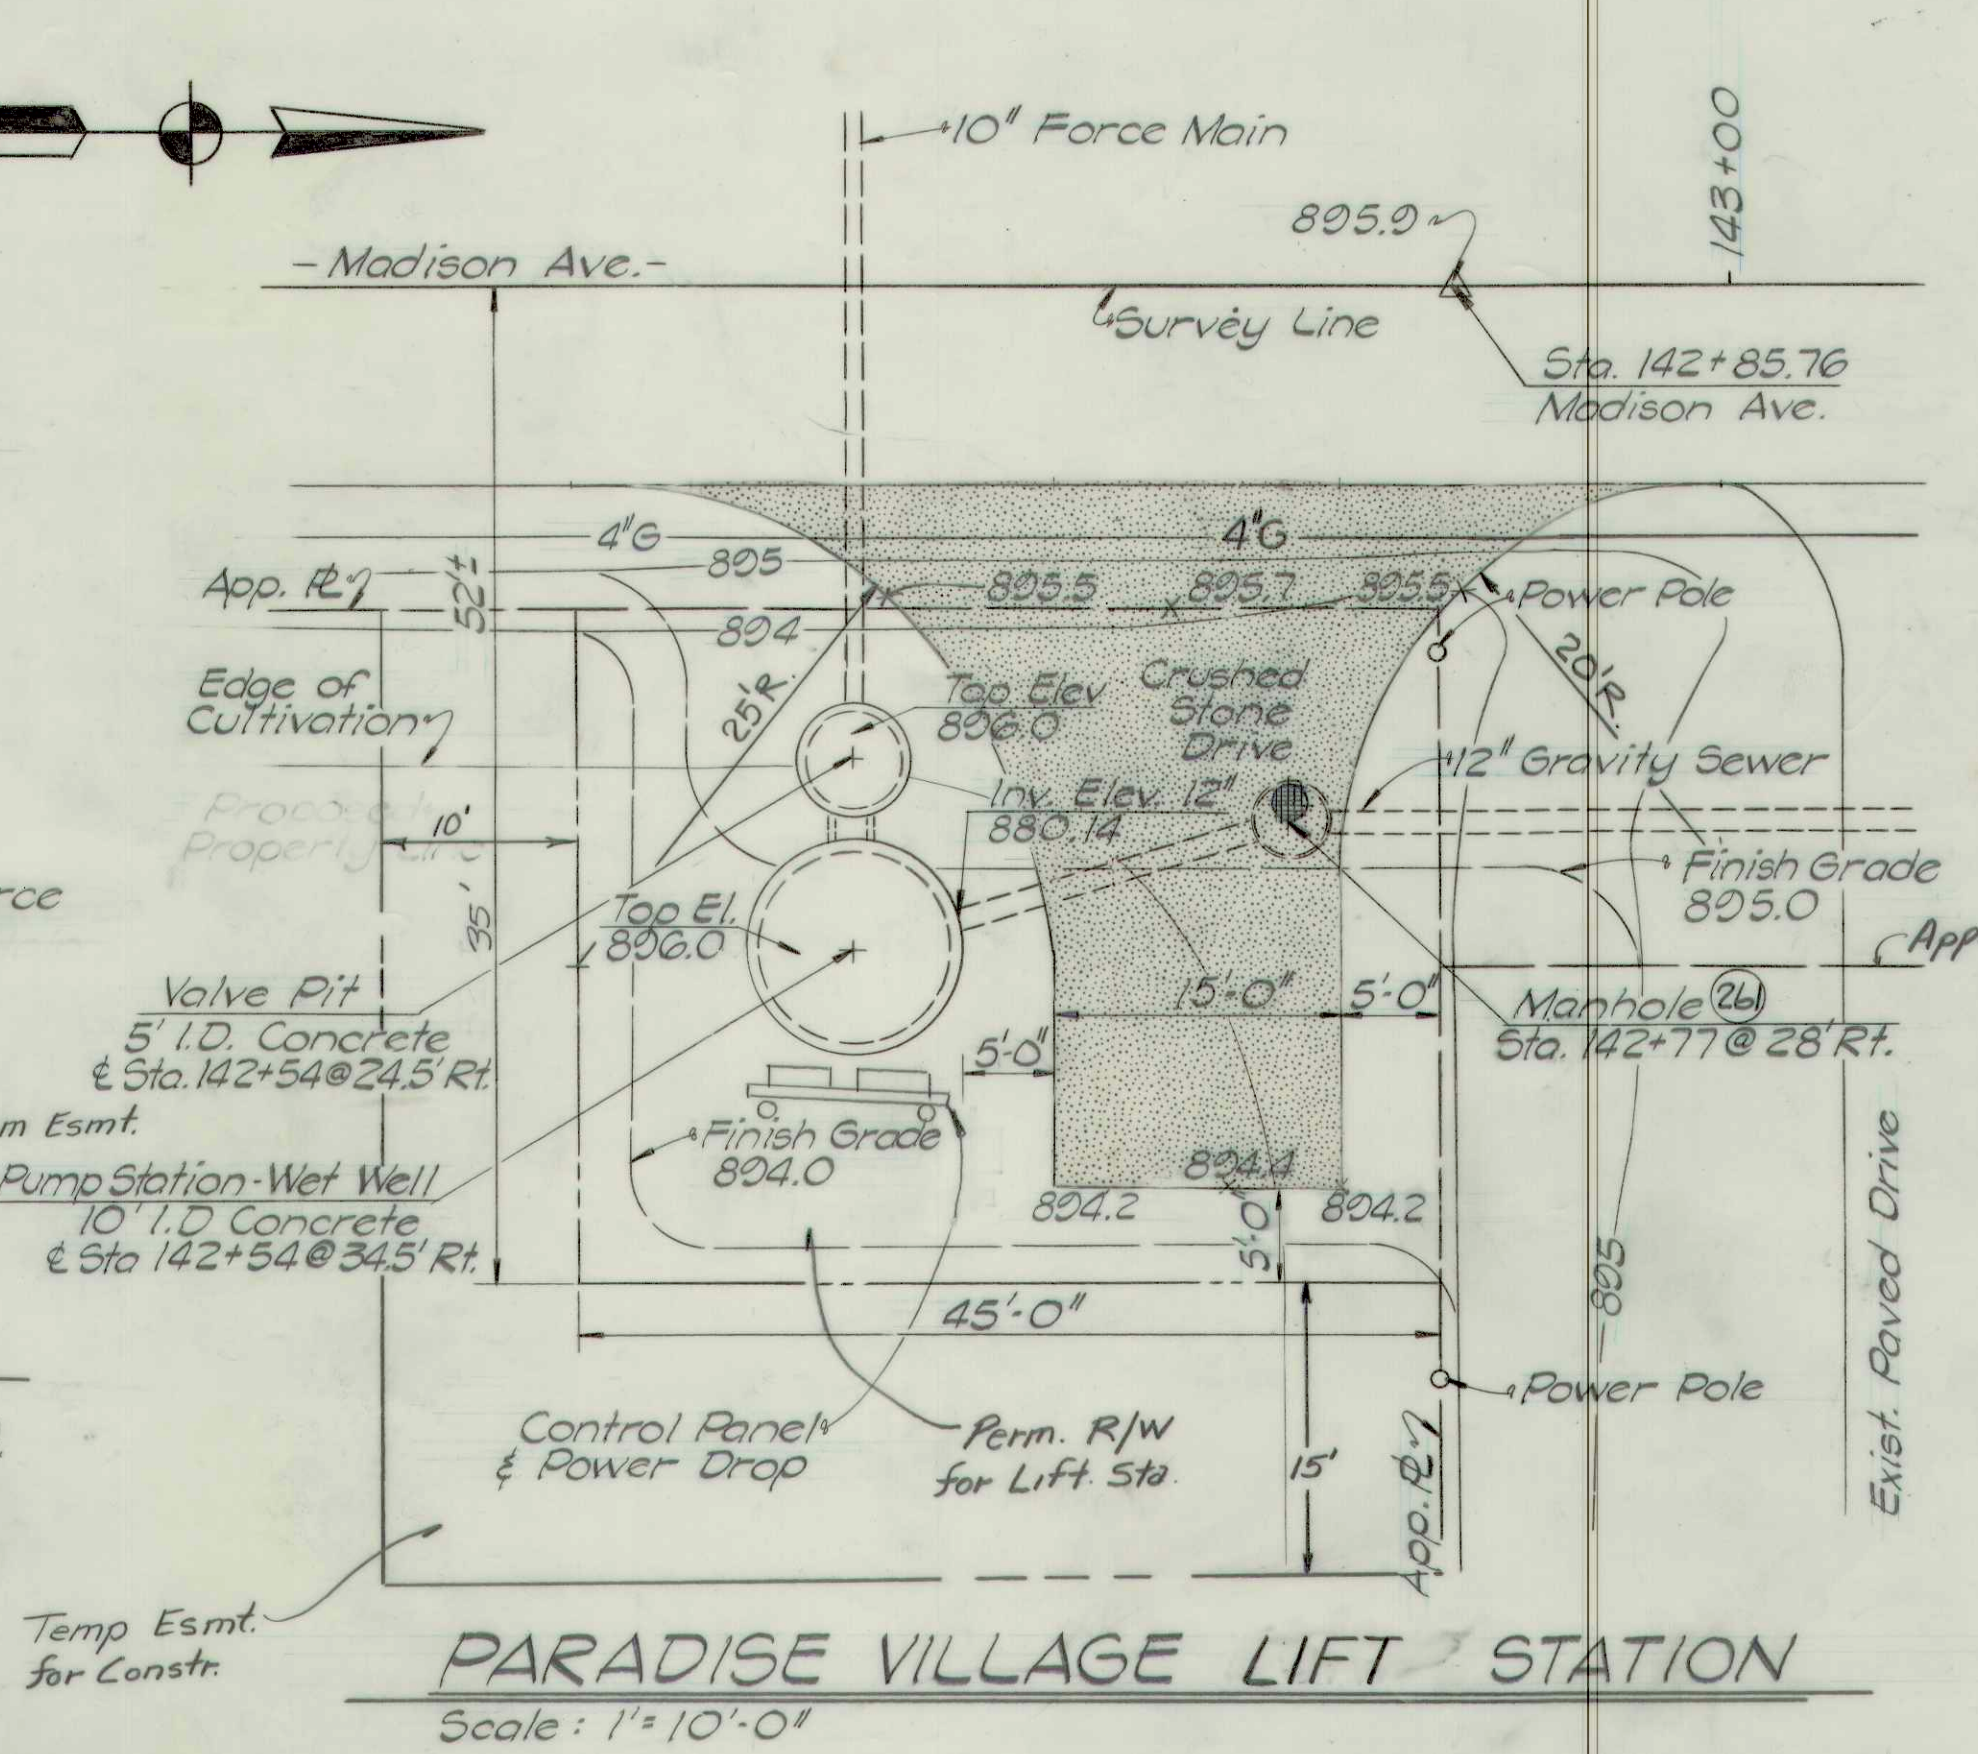


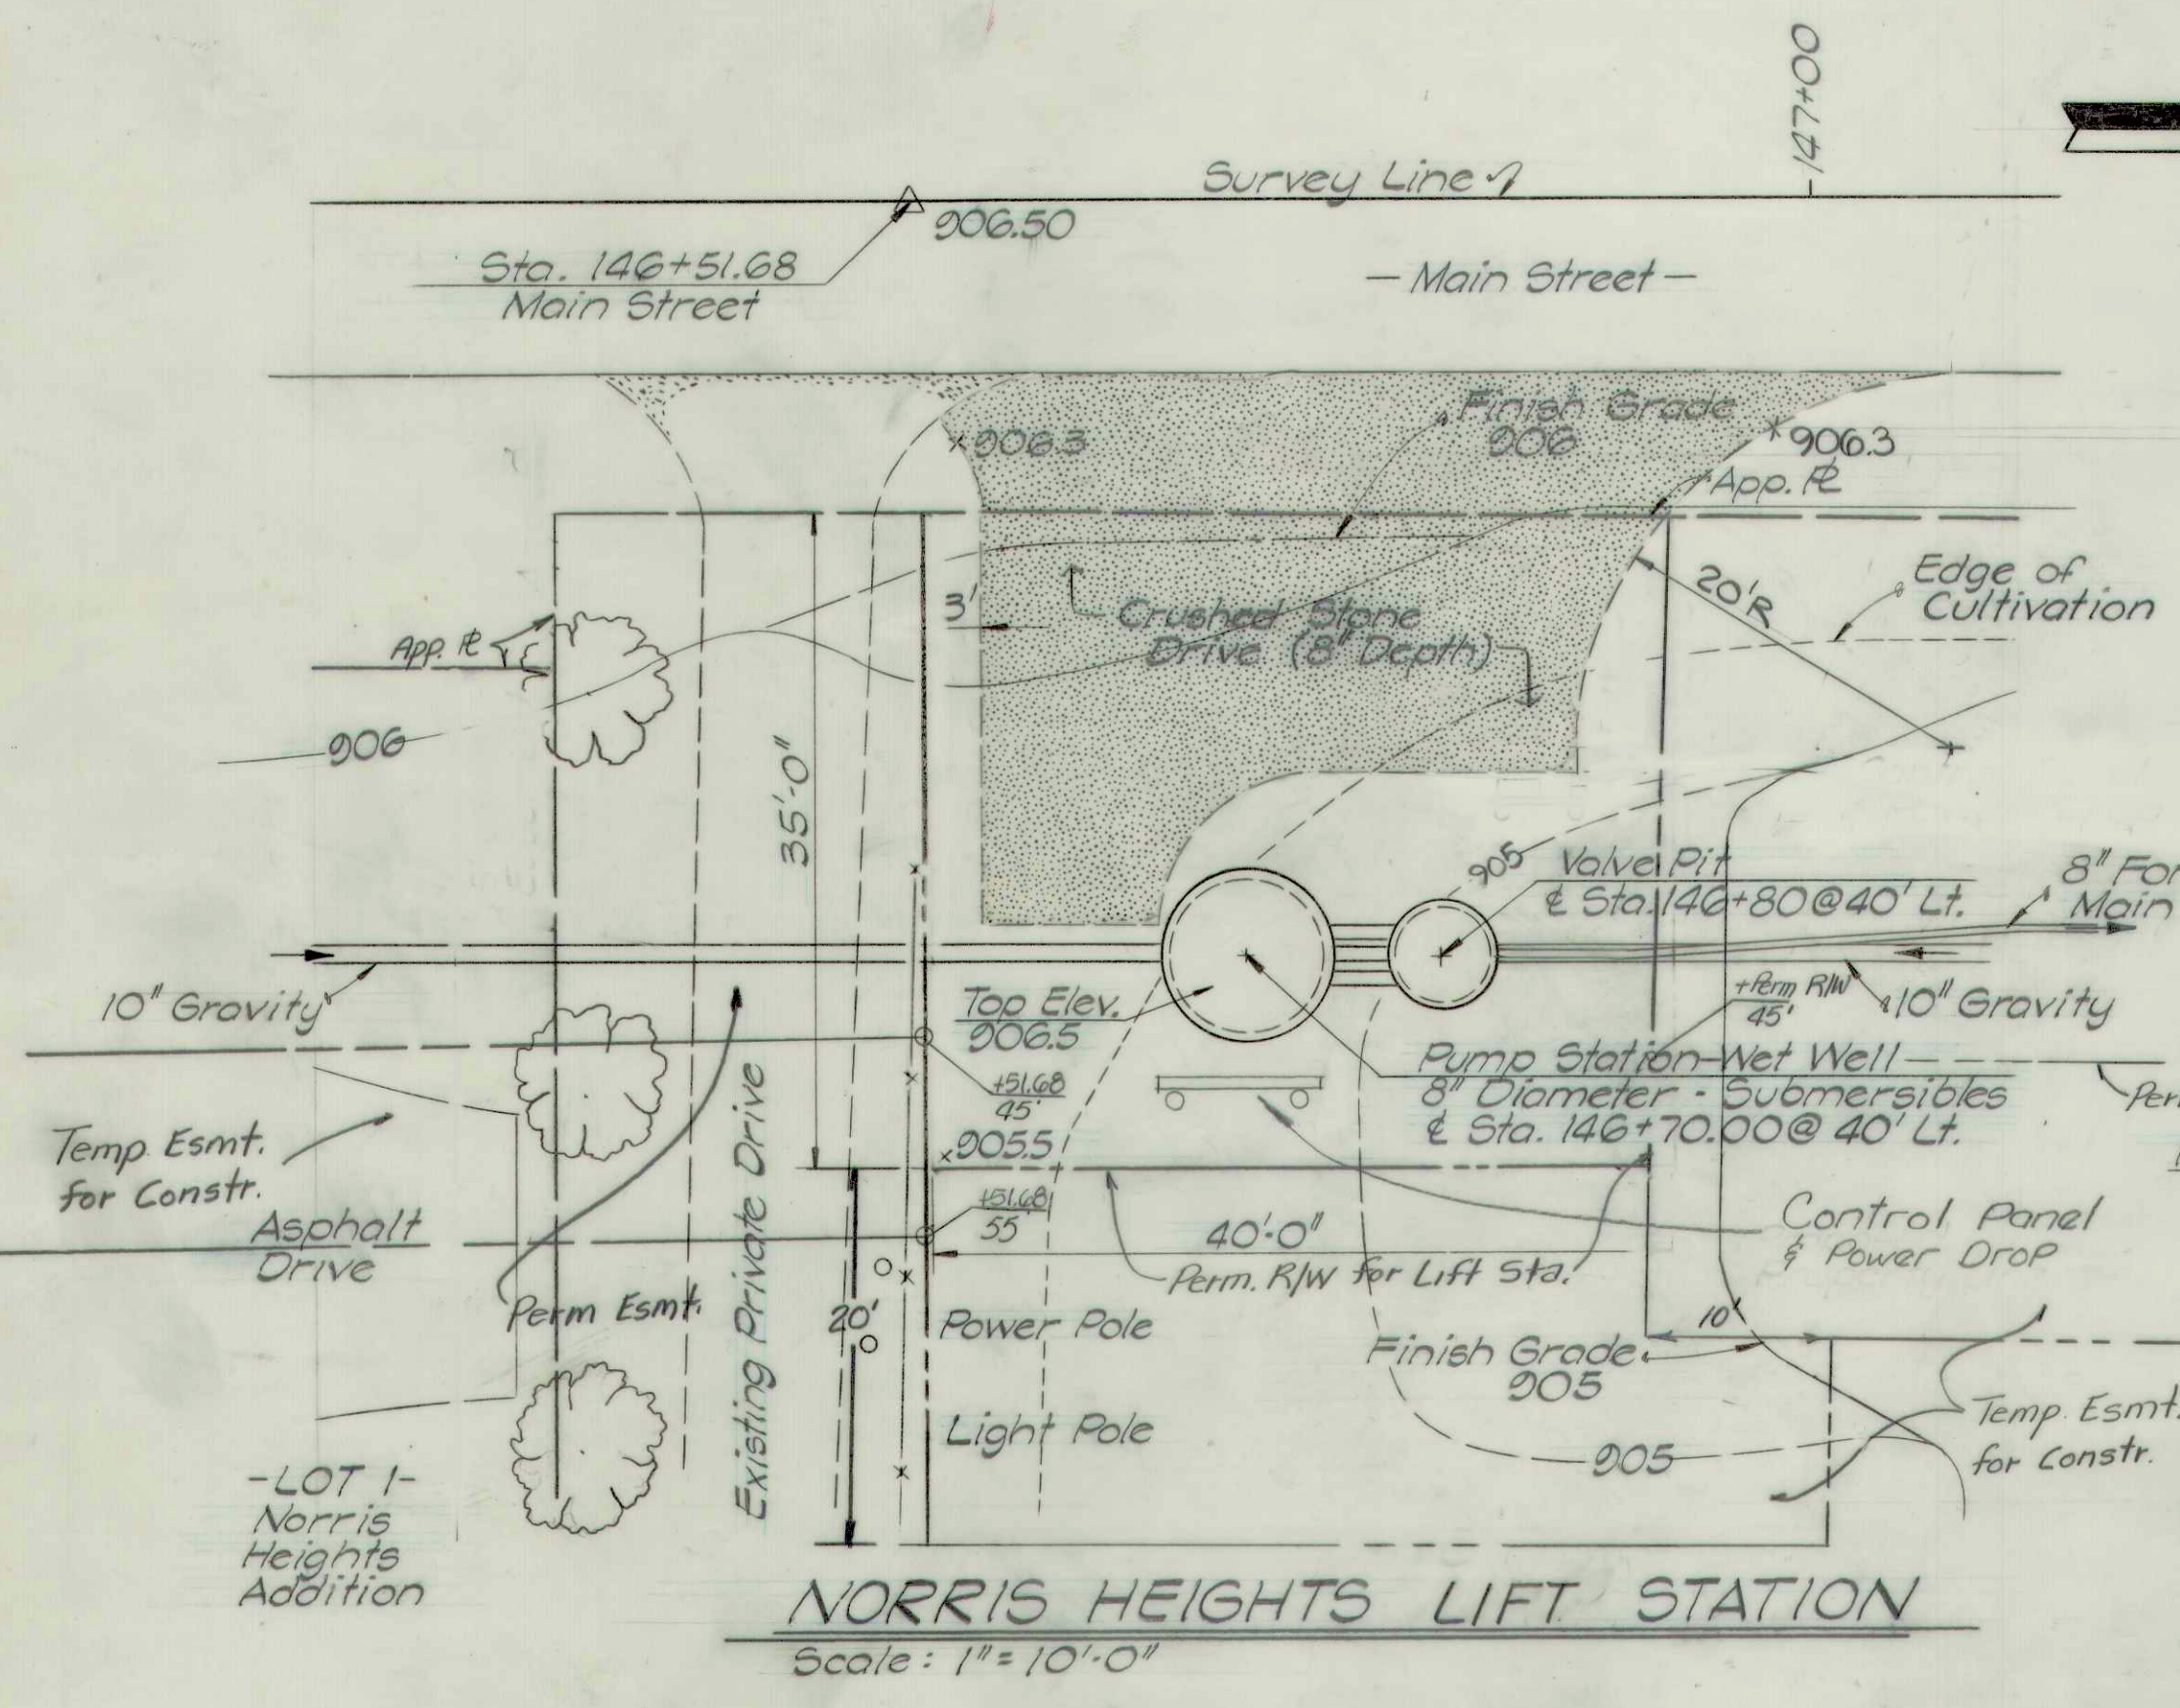

RECORD DRAWING

LIFT STATION SITE PLANS		
Scale: AS NOTED	FALL CREEK WASTEWATER FACILITIES	Sheet
Drawn By: DG, CF	BEAM, LONGEST & NEFF	77
Designed By: AC	Consulting Engineers	
Certified By: ER	8136 Castleton Road Indianapolis, IN 46250	