
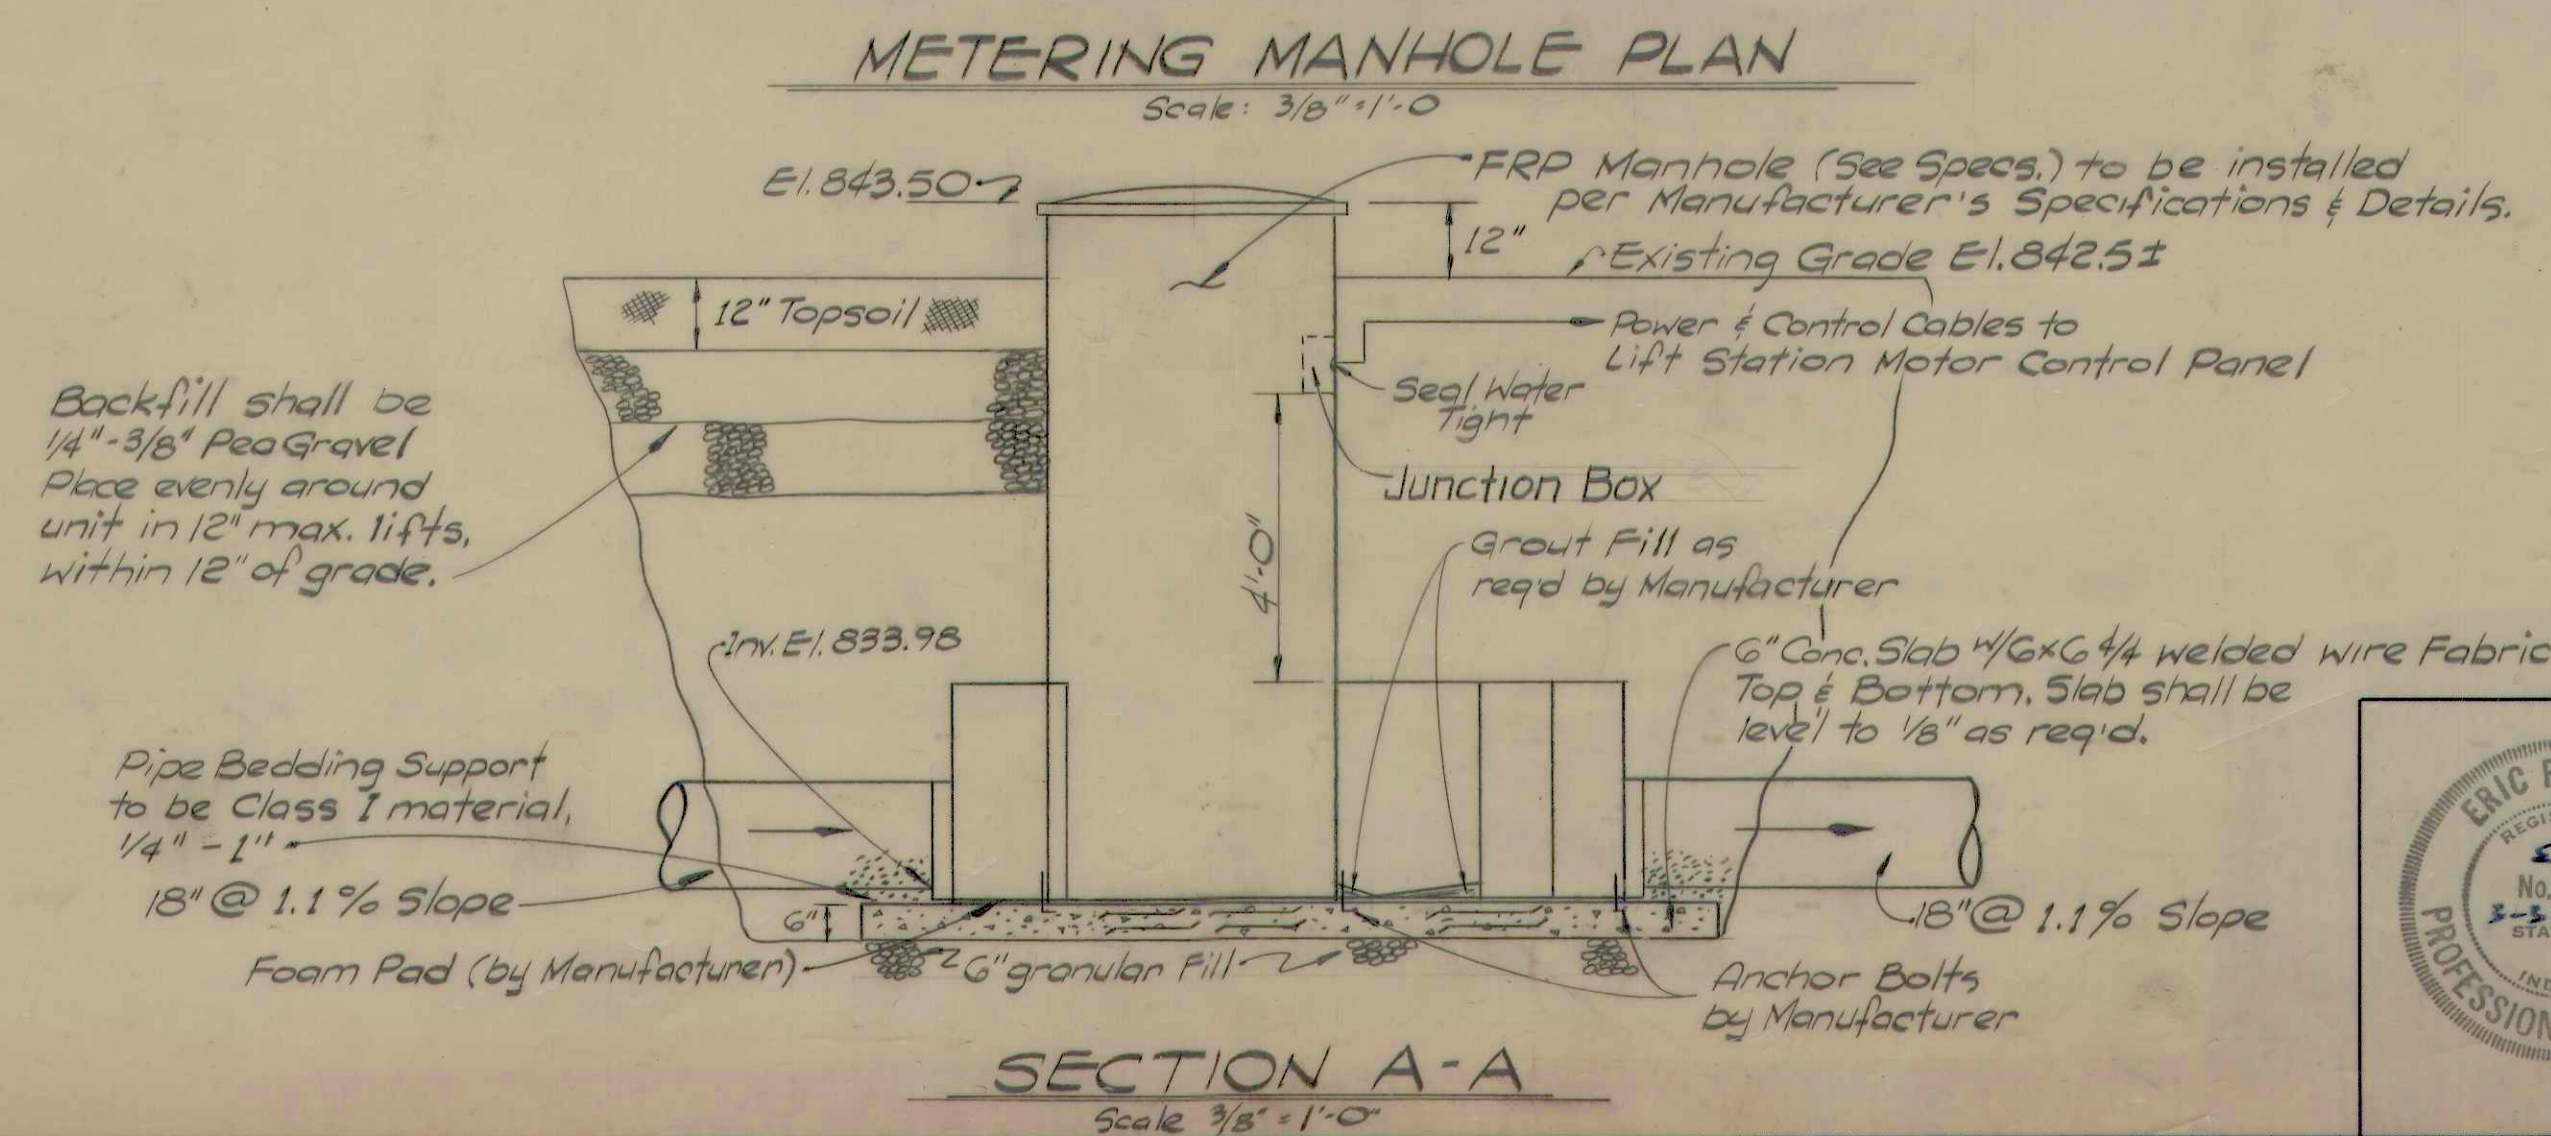
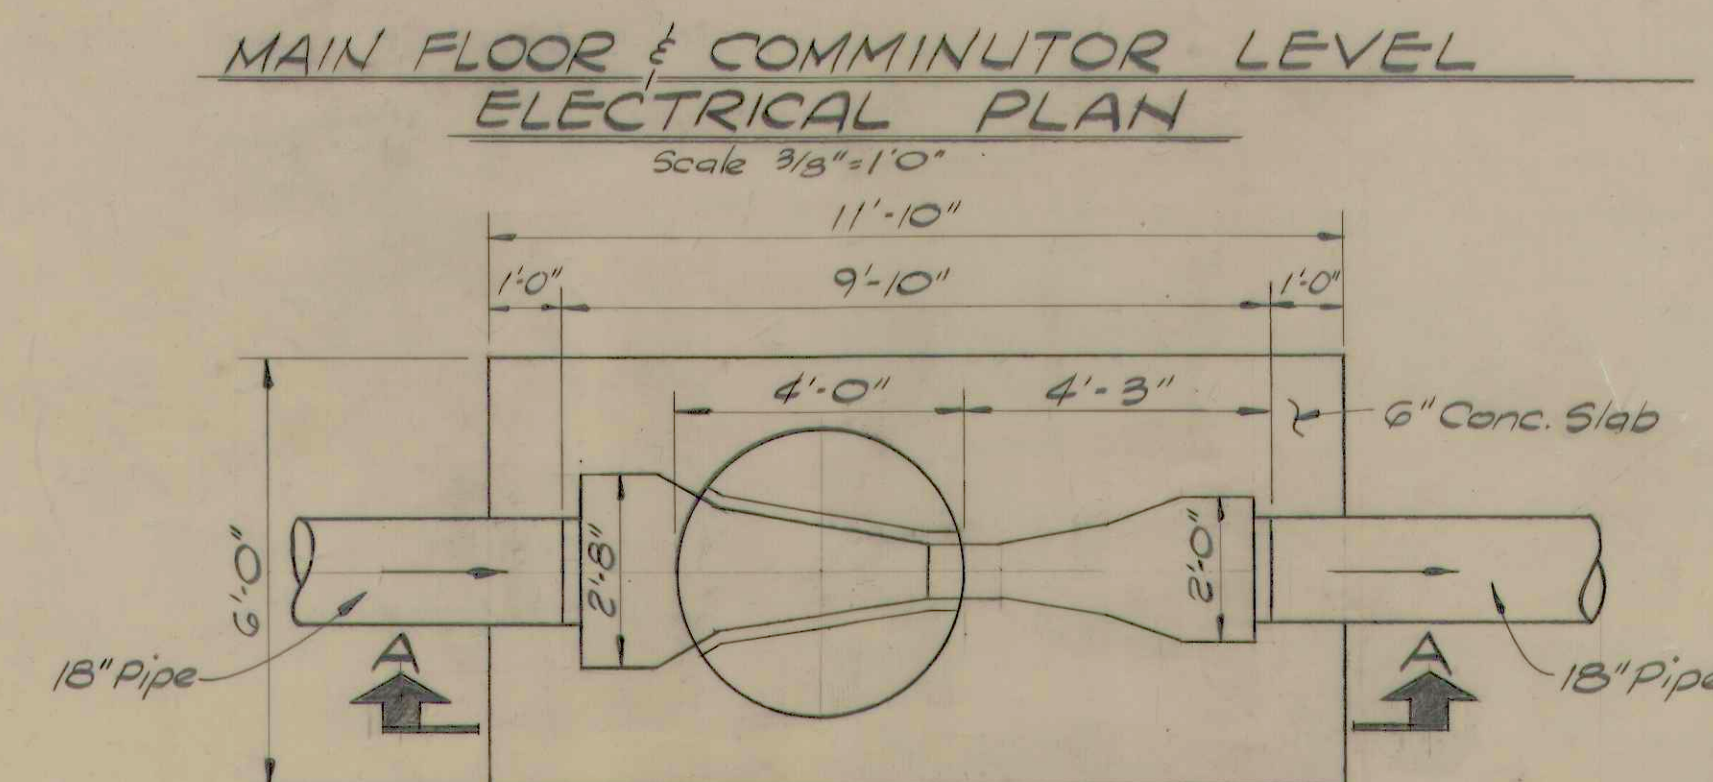
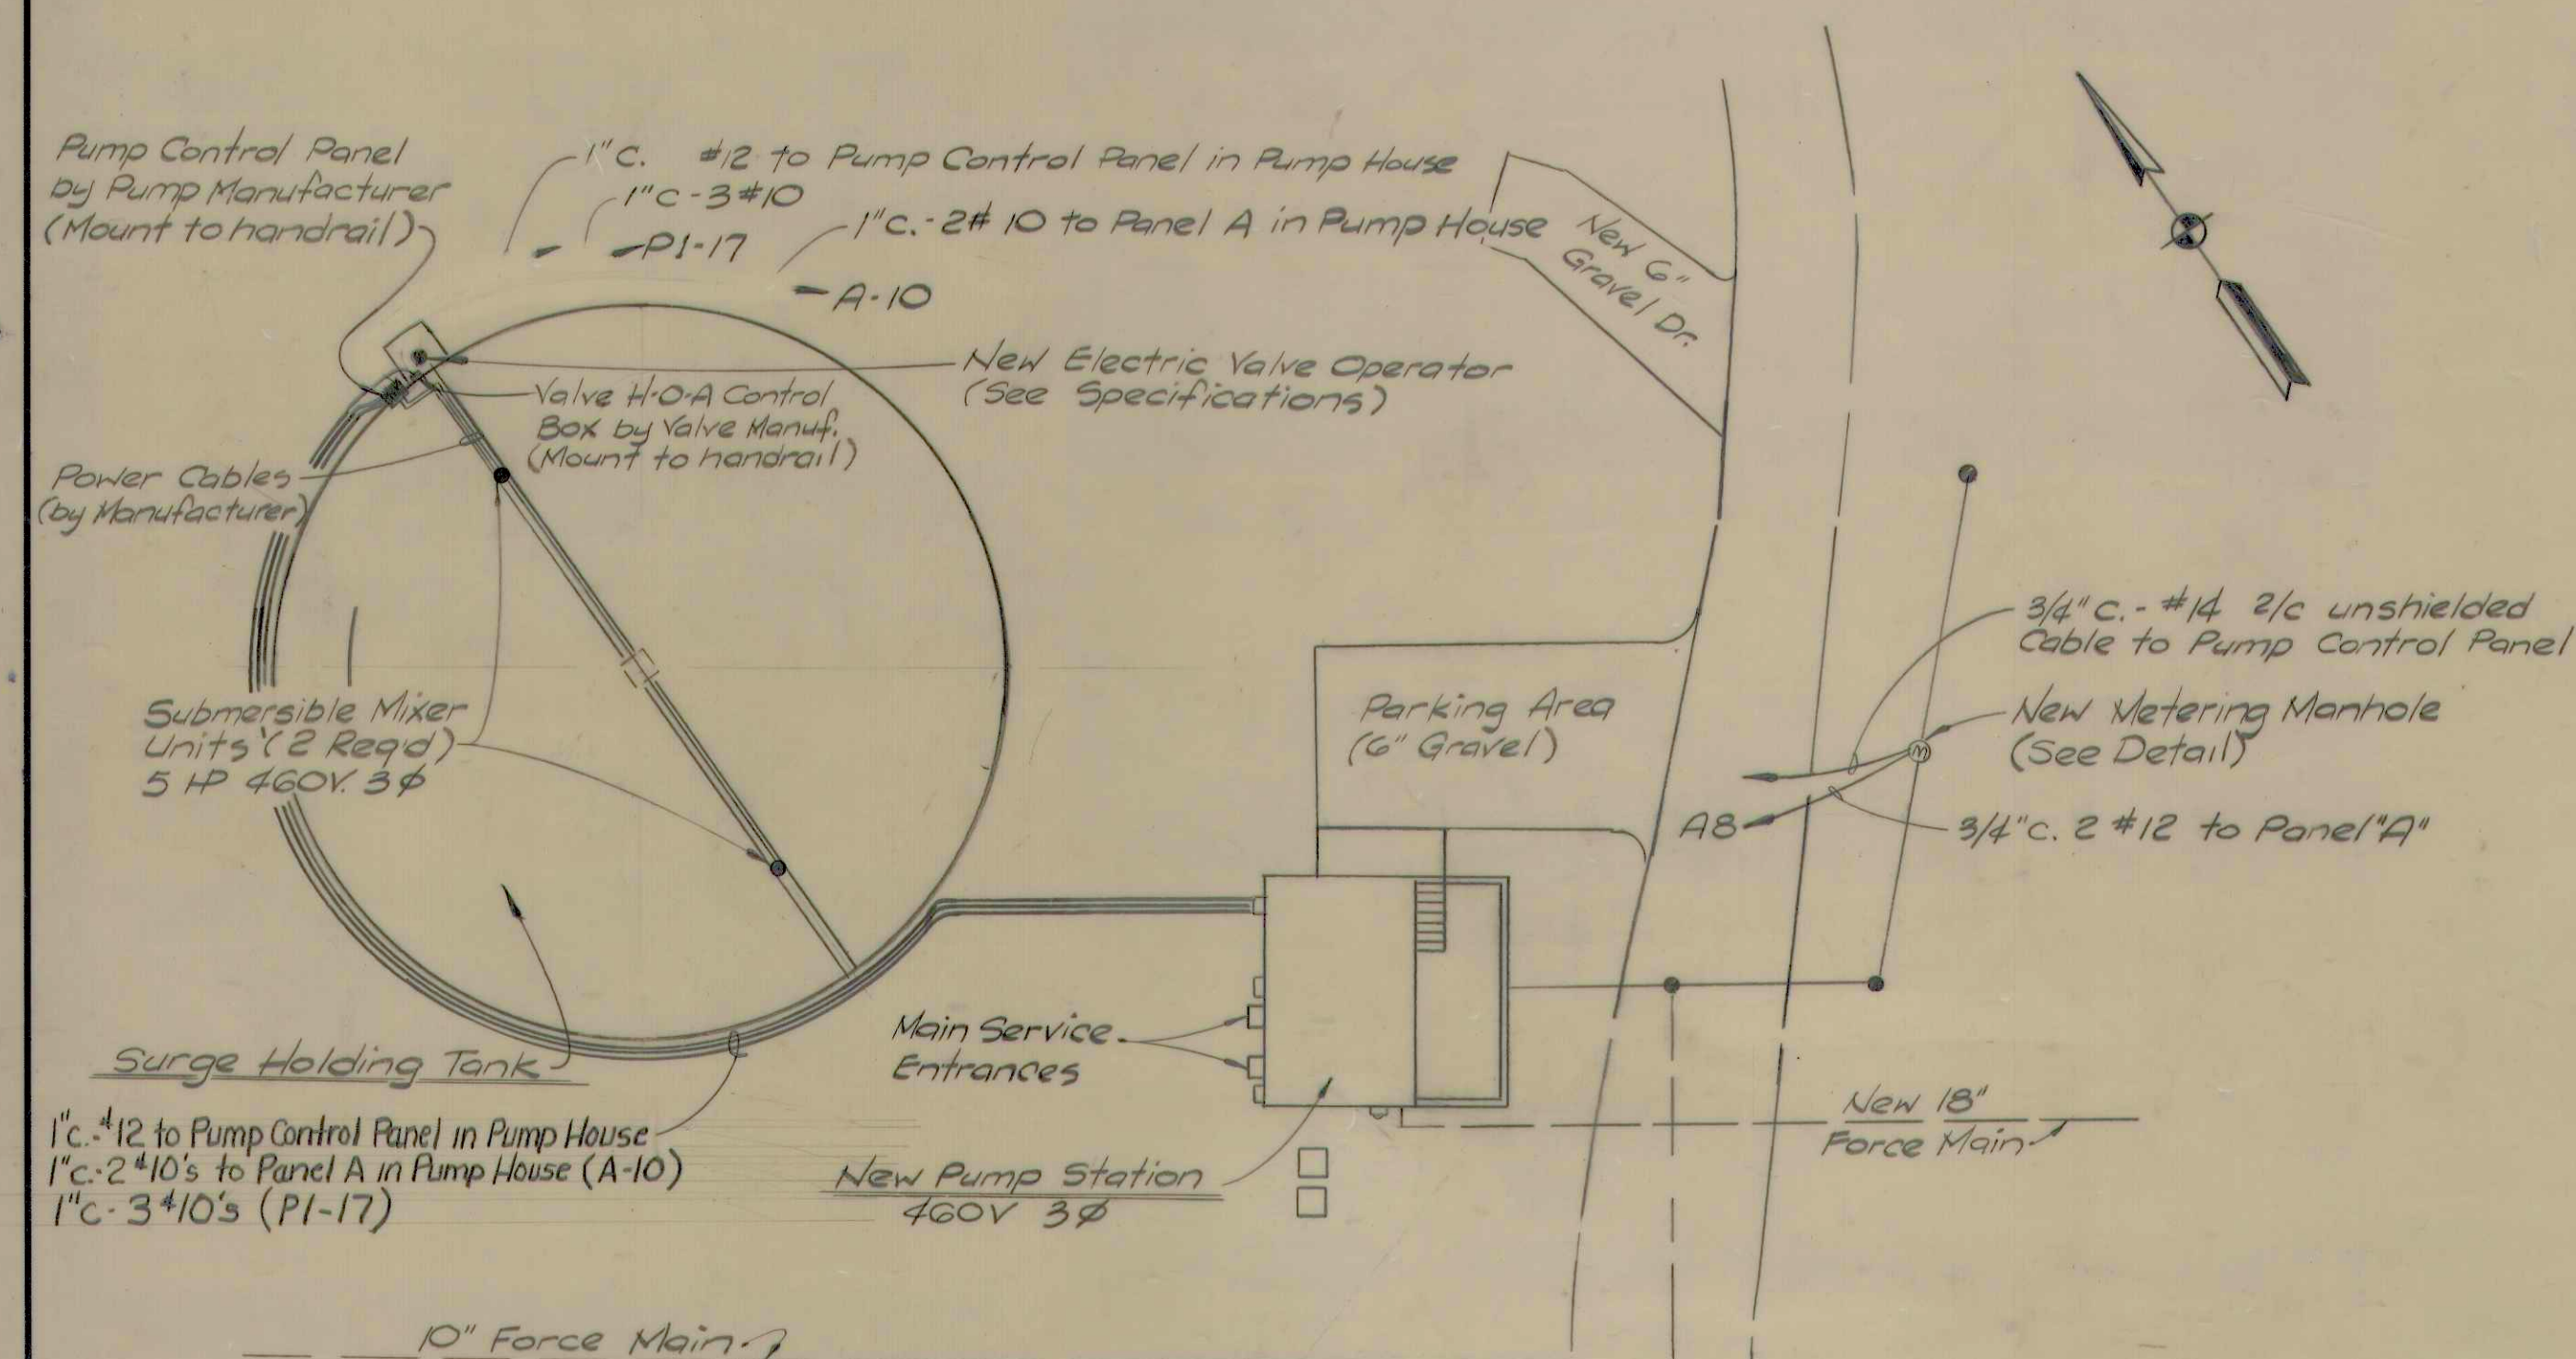
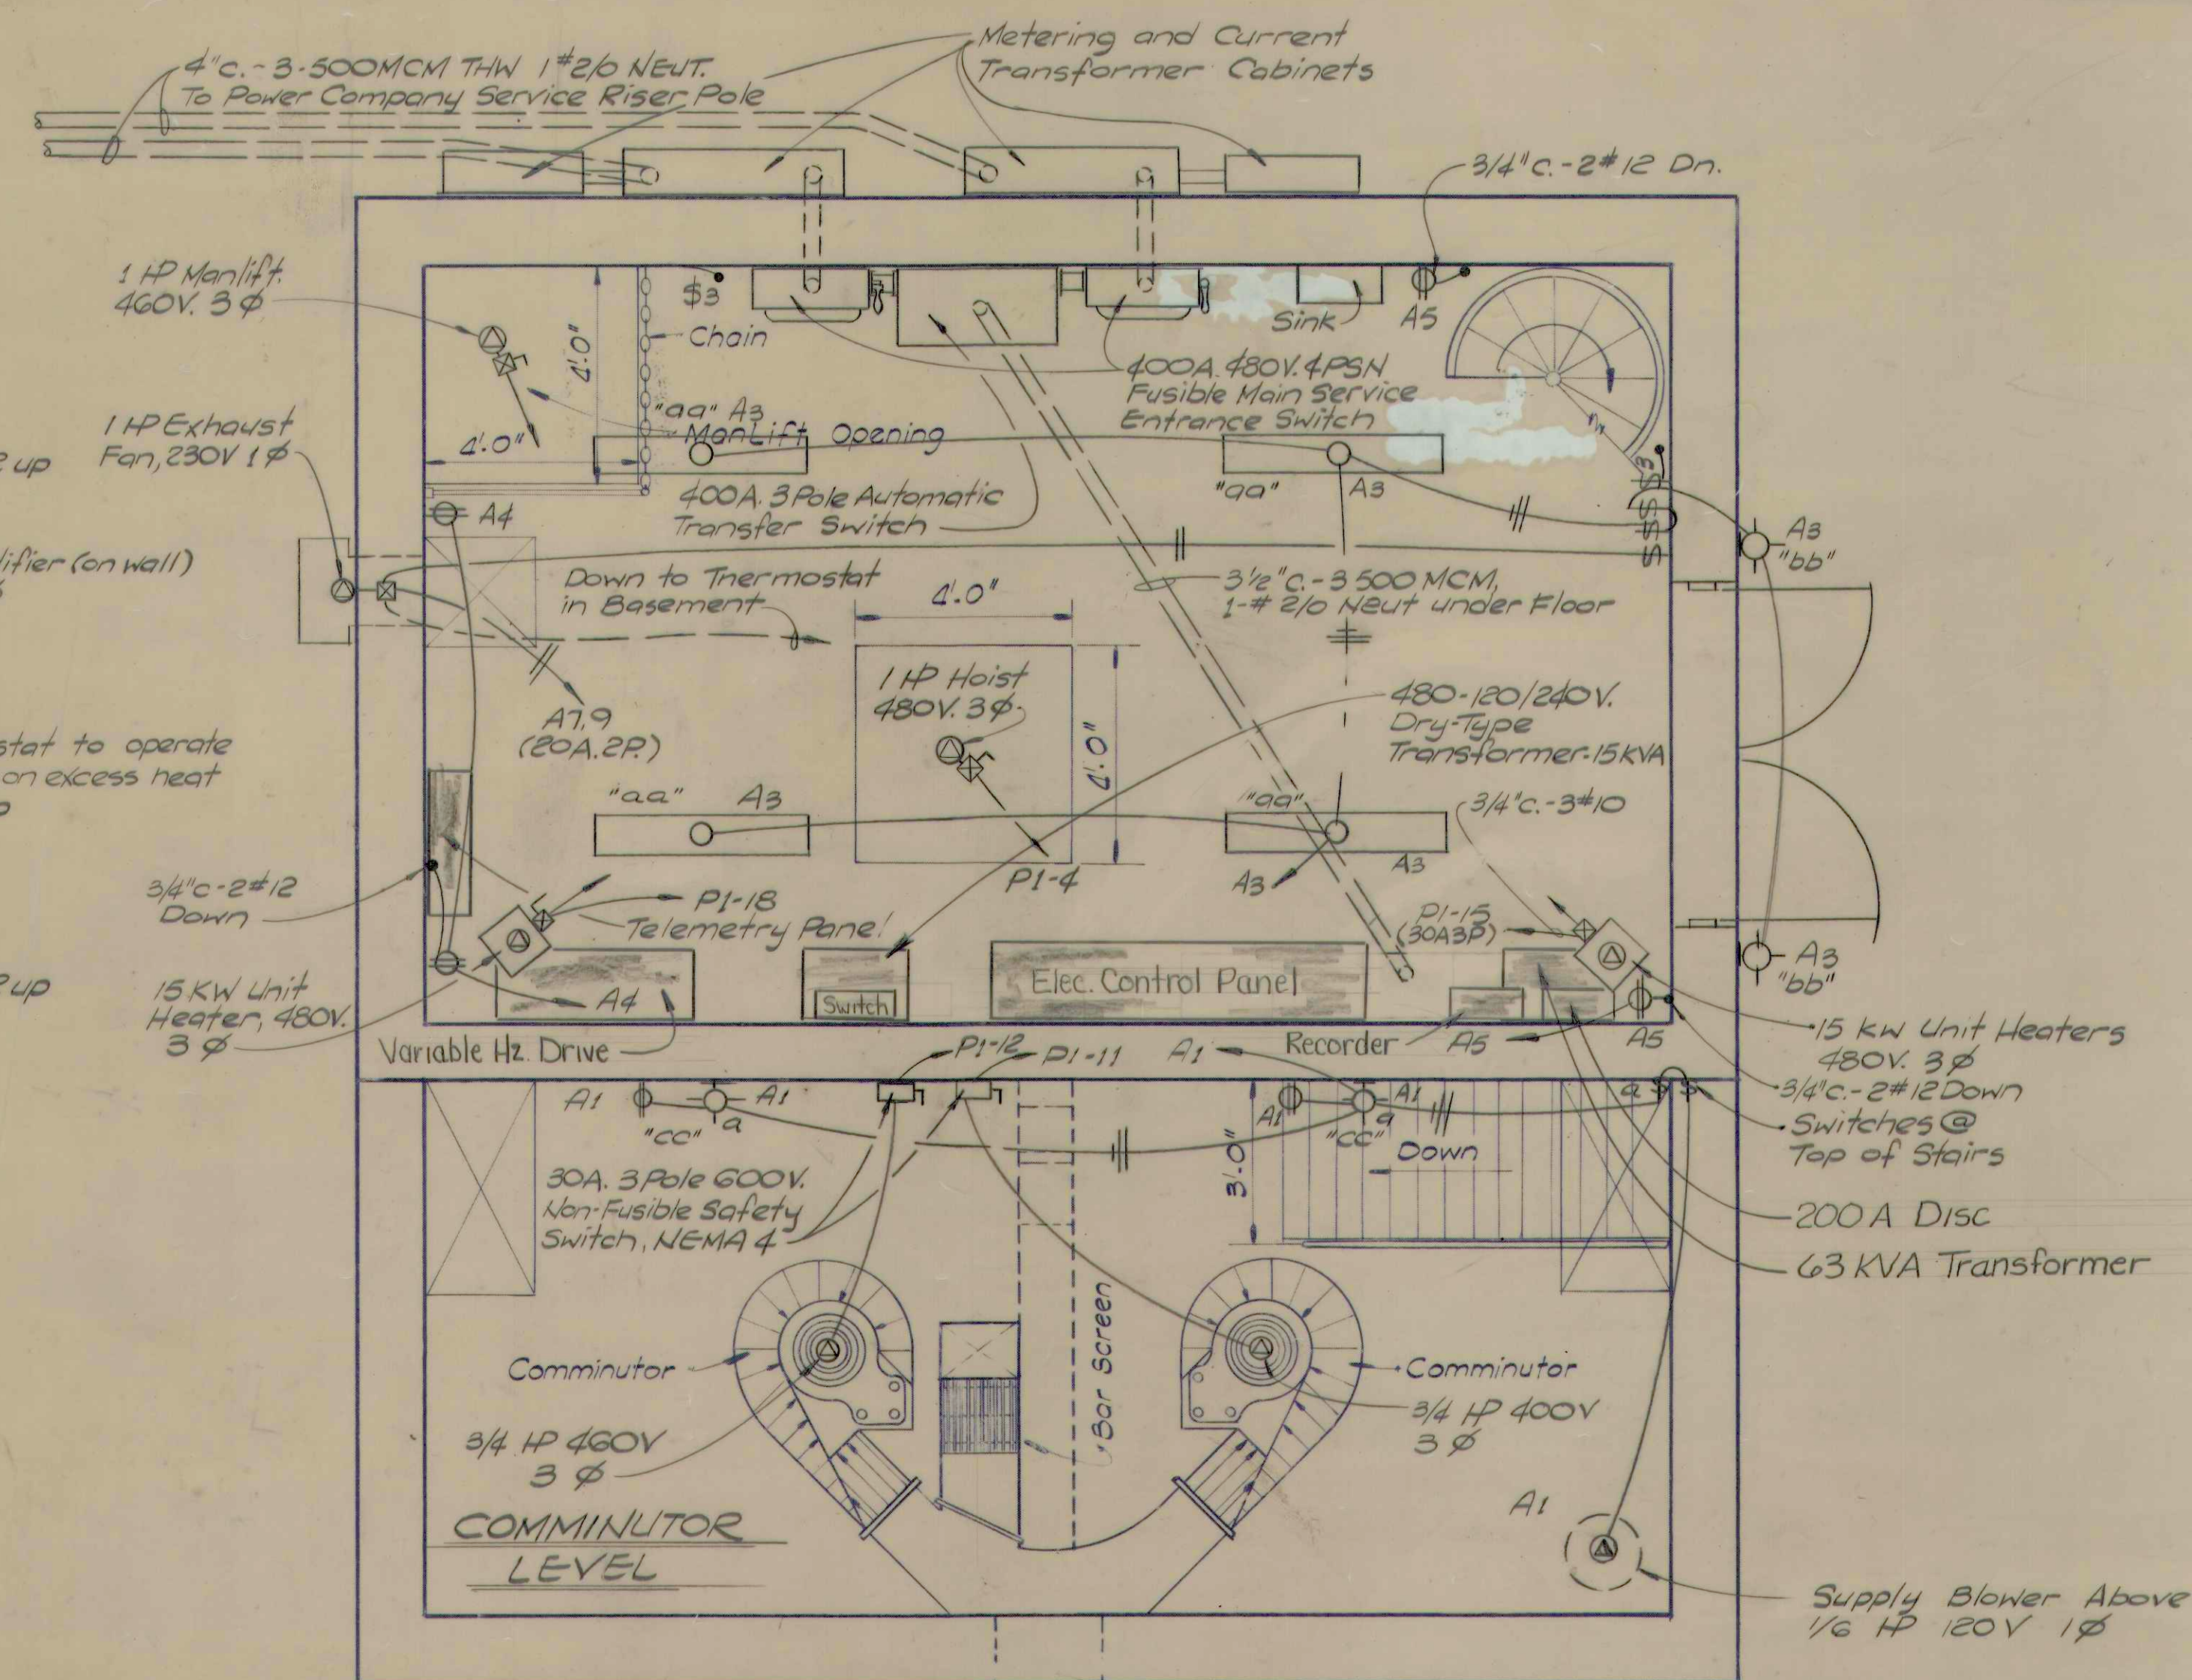


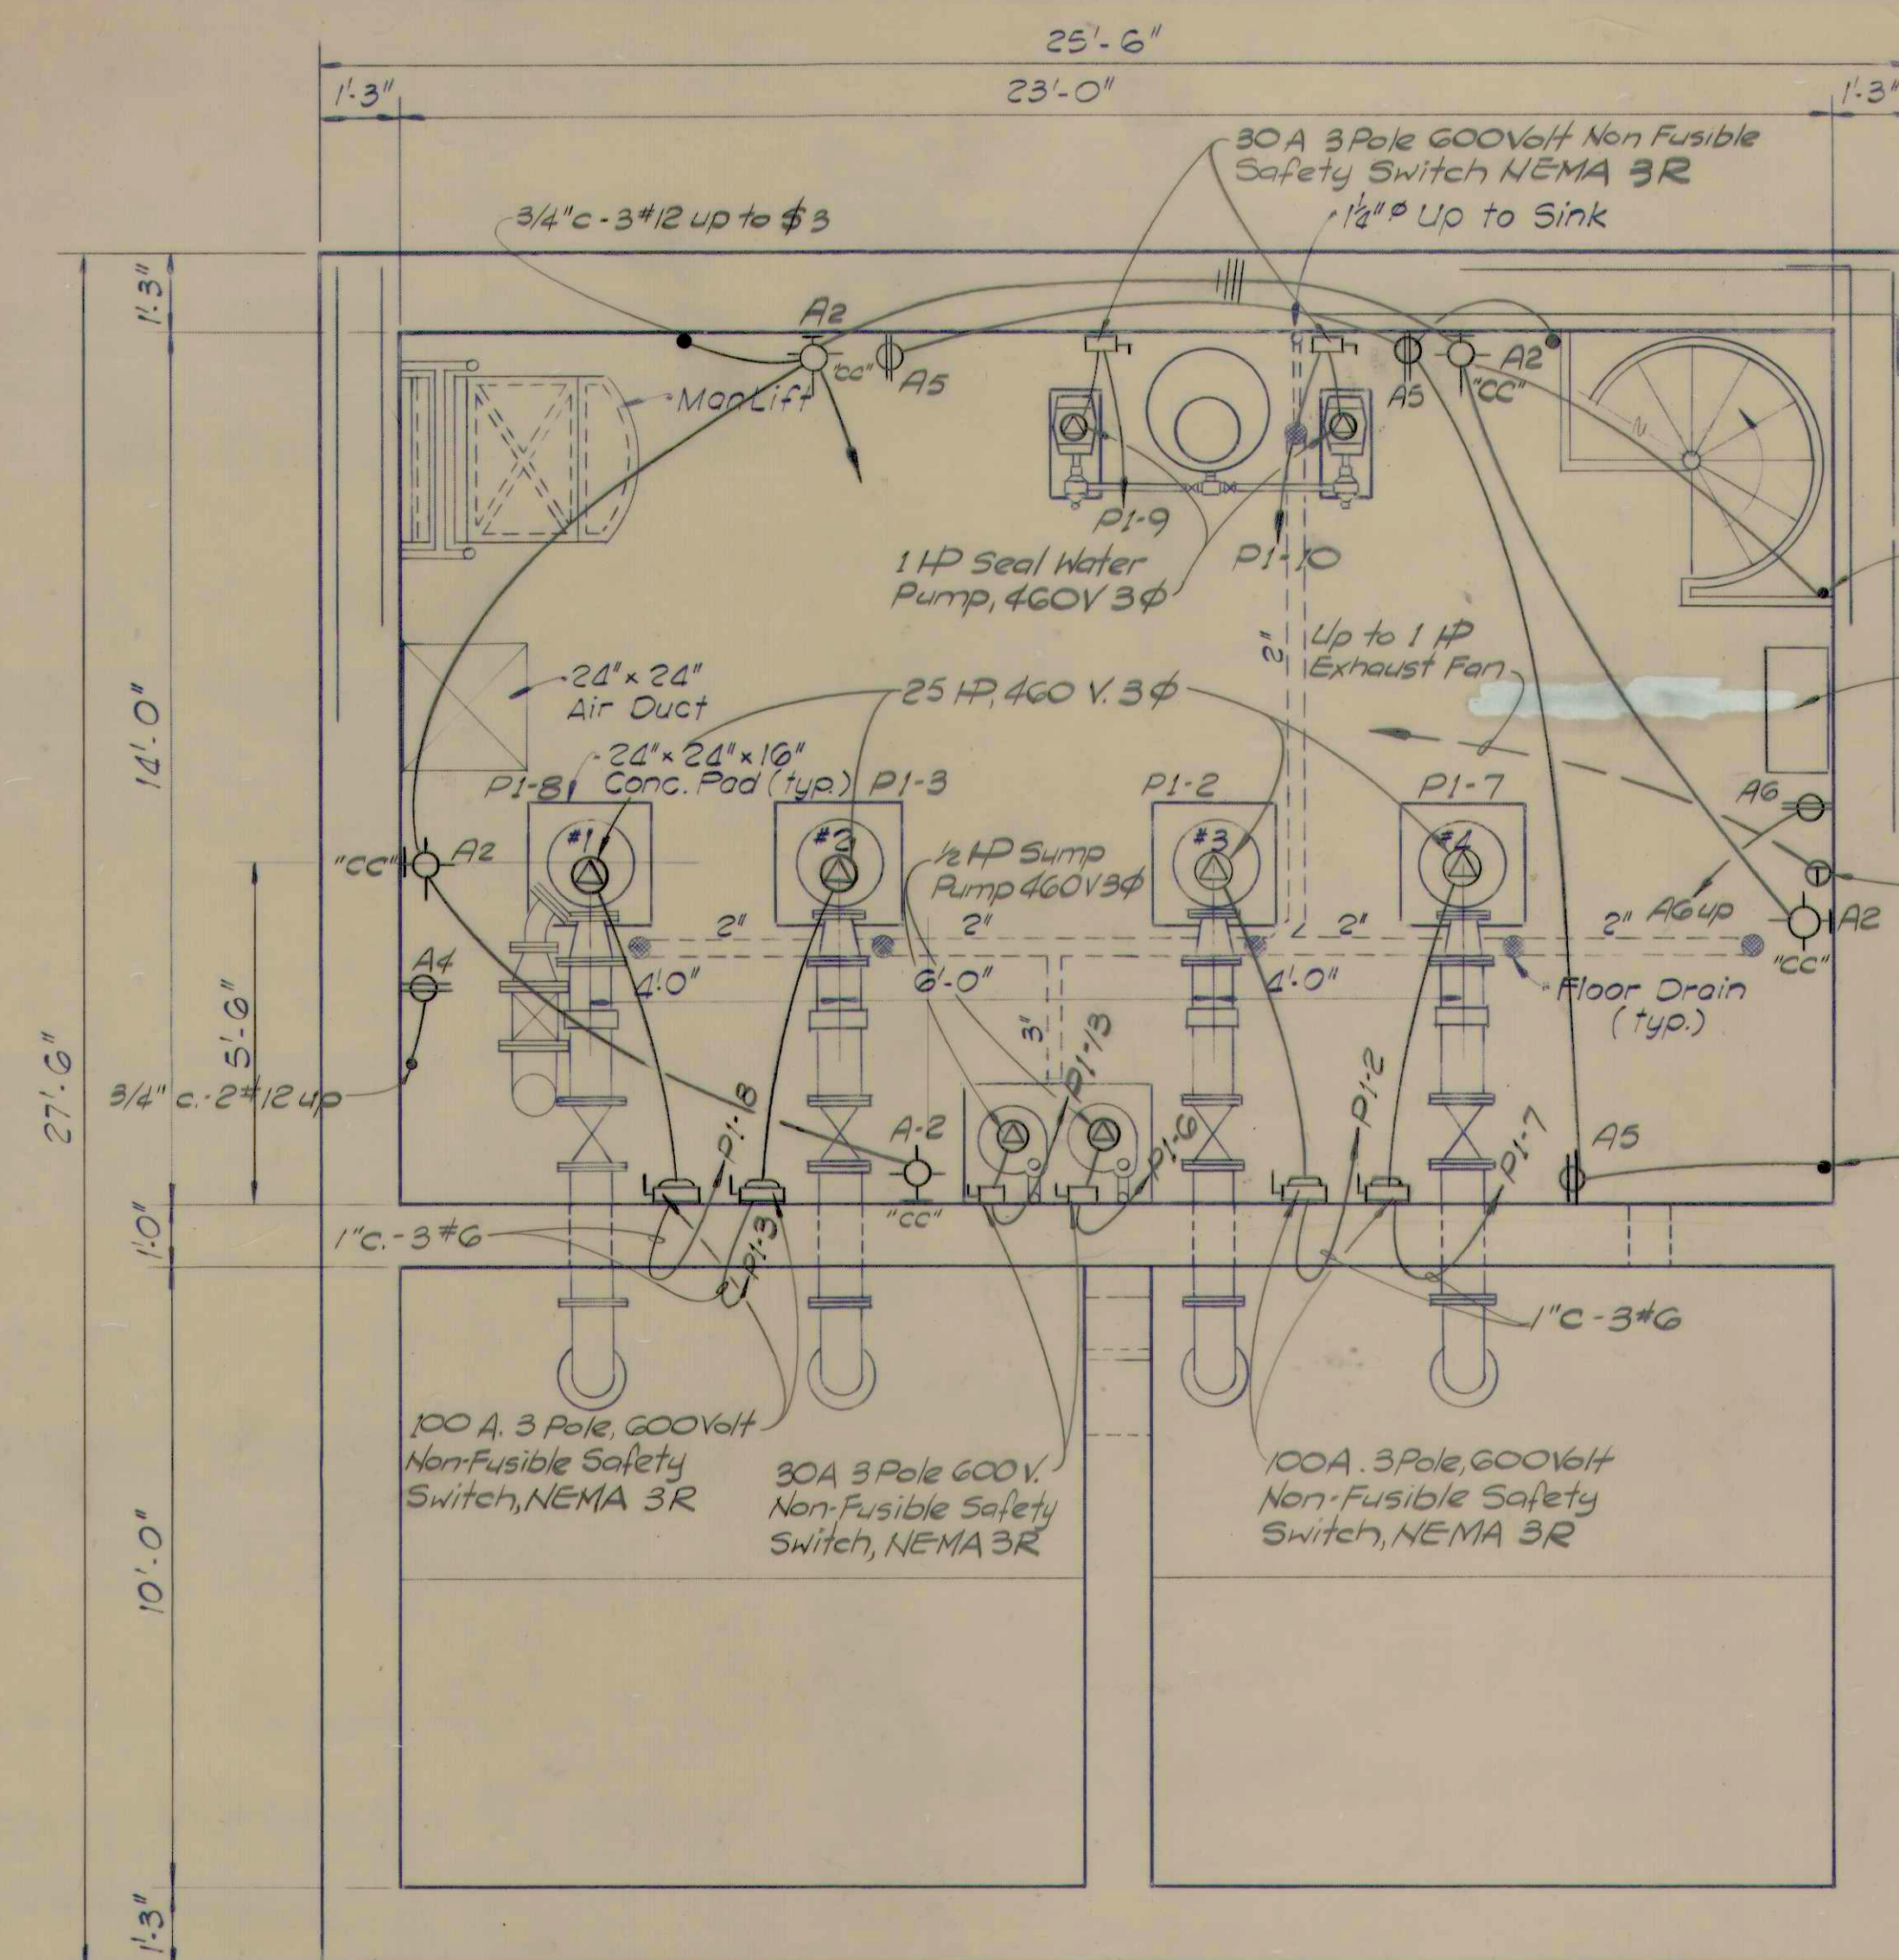

RECORD DRAWING

REFORMATORY MAIN LIFT STATION
ELECTRICAL PLANS & METERING
MANHOLE DETAIL

Scale: <i>As Shown</i>	FALL CREEK R.W.D.
Drawn By: <i>VM54 J.B.</i>	BEAM, LONGEST & NEFF
Designed By: <i>J.P.</i>	Consulting Engineers 8136 Castleton Road Indianapolis In. 46250
Certified By: <i>ER</i>	

Drawn By: *YMS*
J.B.

Designed By: *J.P.*

Certified By: *ER*

Consulting Engineers
8136 Castleton Road
Indianapolis In. 46250