


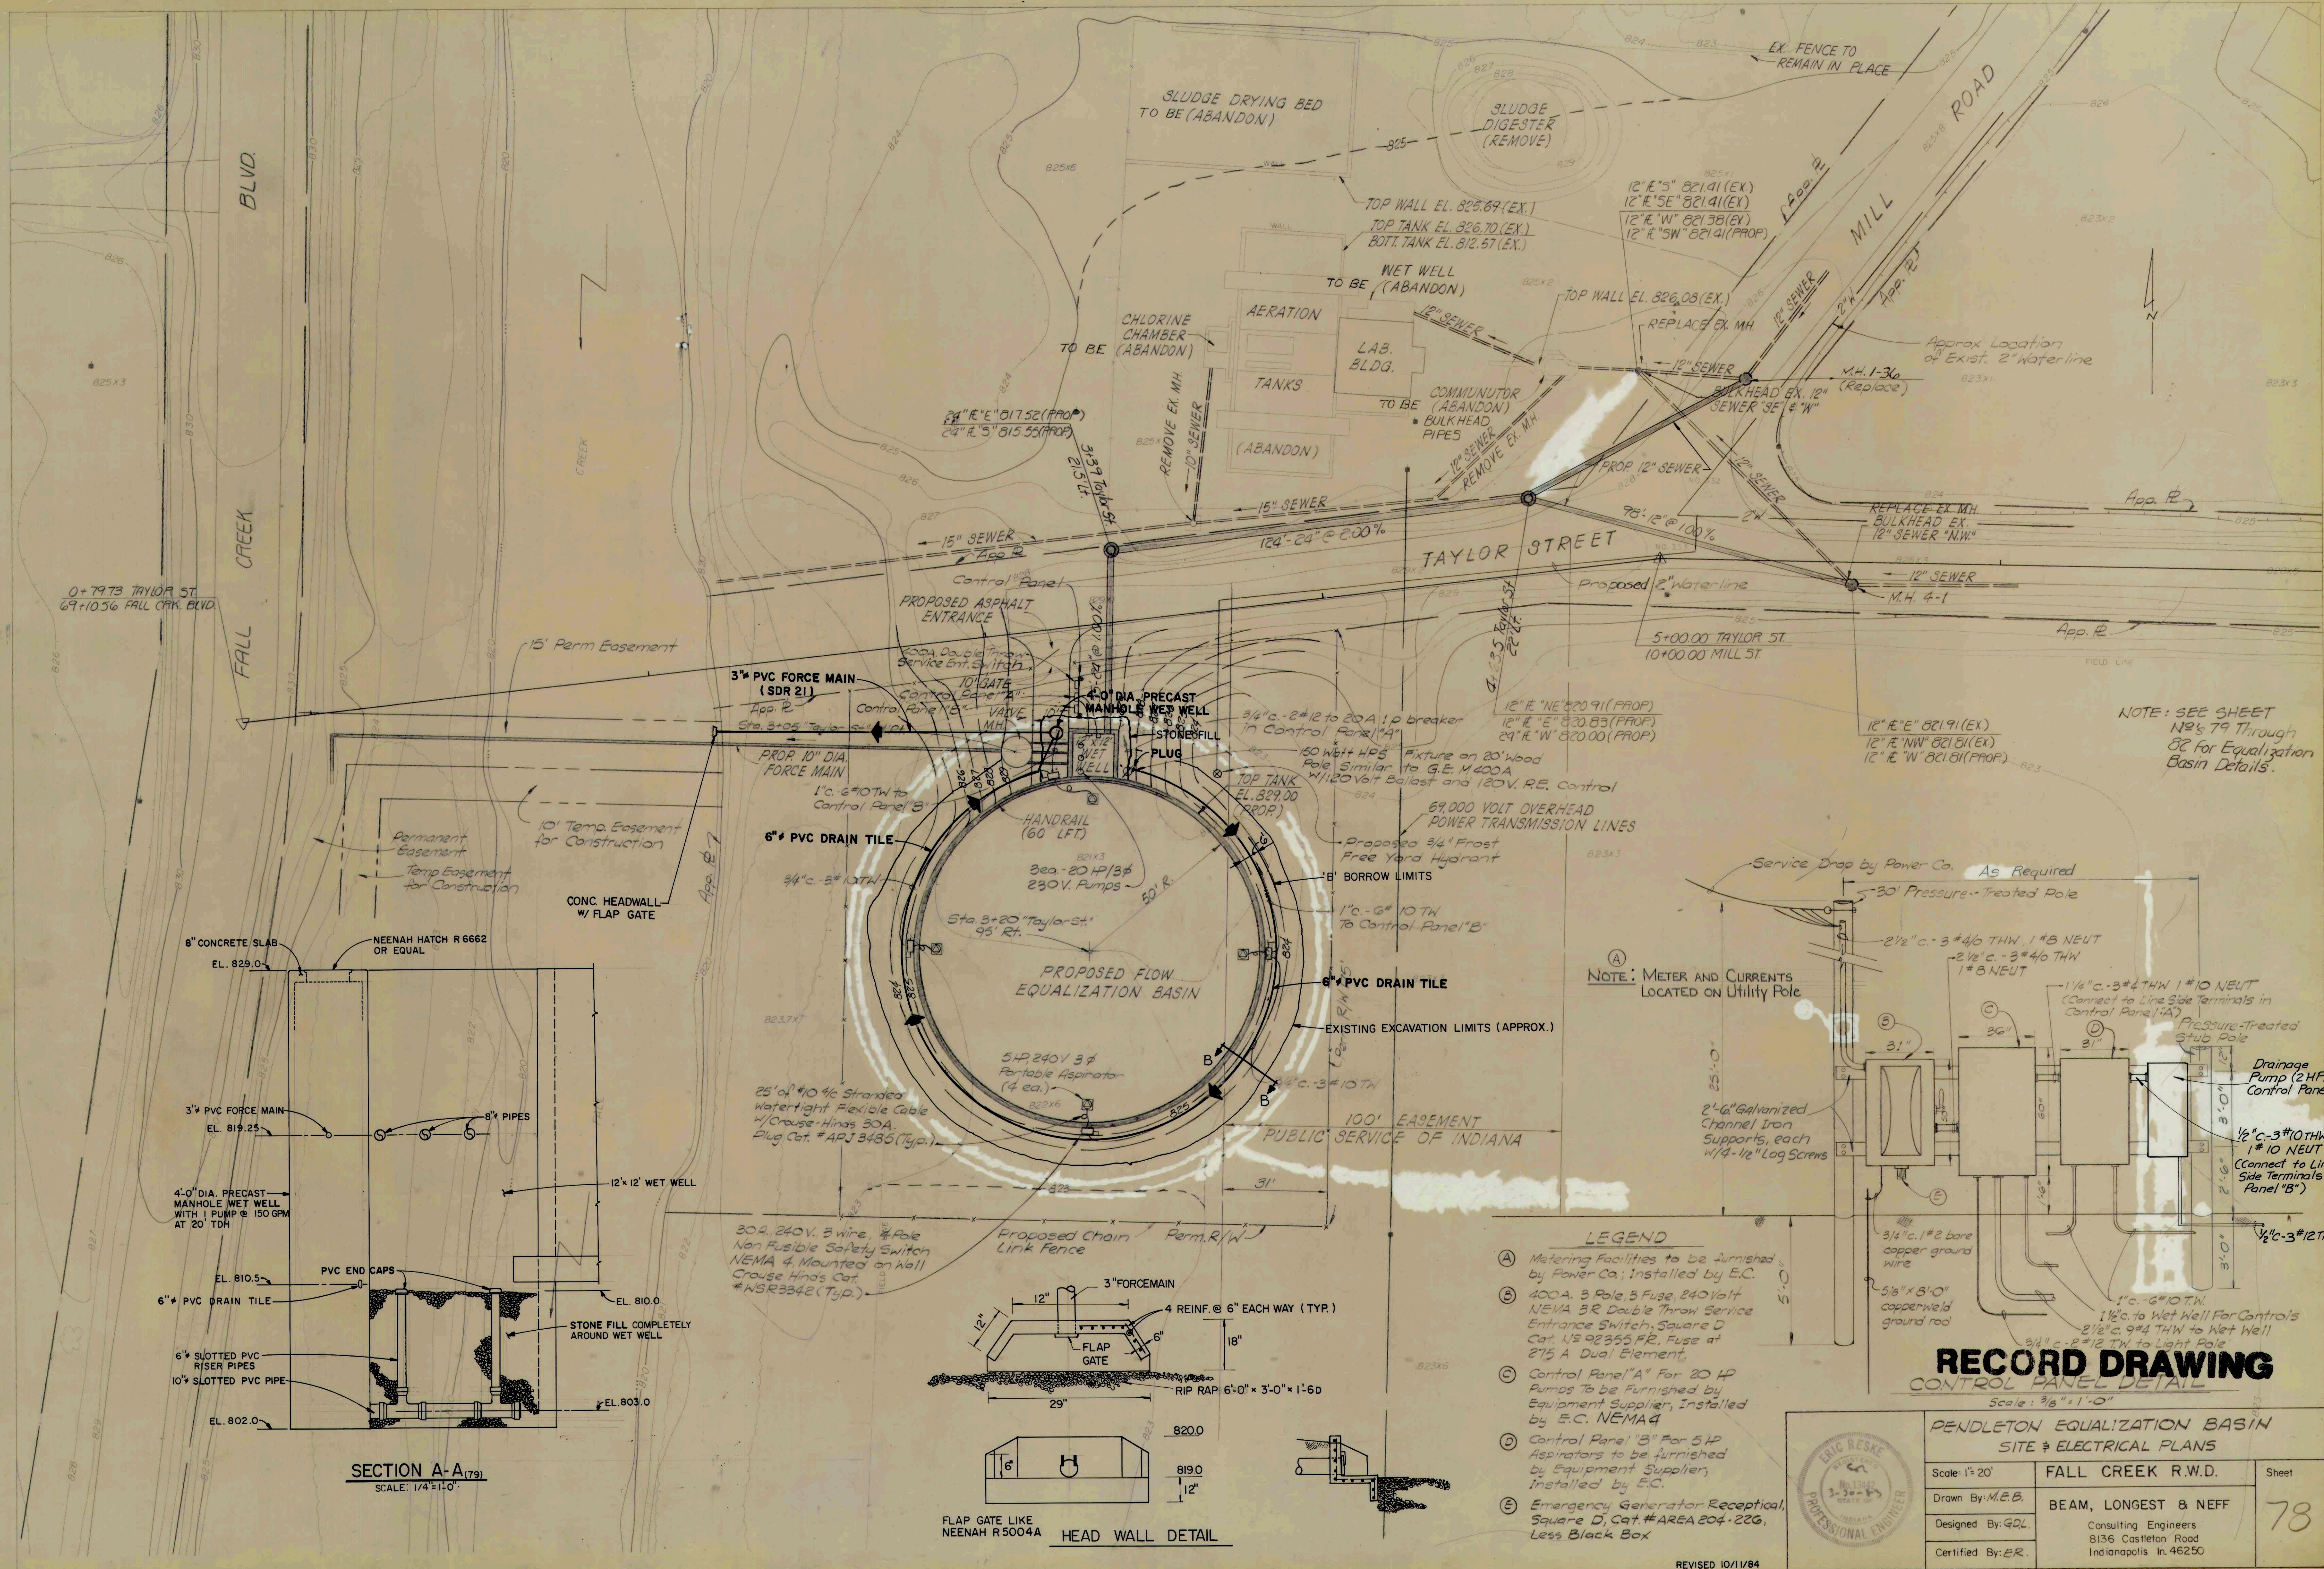

SECTION A-A (79)
SCALE: 1/4"=1'-0"

FLAP GATE LIKE
NEENAH R5004A
HEAD WALL DETAIL

LEGEND

- (A) Metering Facilities to be furnished by Power Co.; installed by E.C.
- (B) 400A, 3 Pole, 5 Fuse, 240 Volt NEMA 3R Double Throw Service Entrance Switch, Square D Cat. #S92355FR, Fuse at 275 A Dual Element.
- (C) Control Panel "A" For 20 HP Pumps to be furnished by Equipment Supplier, installed by E.C. NEMA 4
- (D) Control Panel "B" For 5 HP Aspirators to be furnished by Equipment Supplier, installed by E.C.
- (E) Emergency Generator Receptical, Square D, Cat. #AREA 204-22G, Less Black Box

RECORD DRAWING
CONTROL PANEL DETAIL

Scale: 3/8"=1'-0"

PENDLETON EQUALIZATION BASIN SITE & ELECTRICAL PLANS		
Scale: 1"=20'	FALL CREEK R.W.D.	Sheet
Drawn By: M.E.B.	BEAM, LONGEST & NEFF	78
Designed By: GDL	Consulting Engineers 8136 Castleton Road Indianapolis, IN 46250	
Certified By: ER.		

REVISED 10/11/84

REVISER 78