


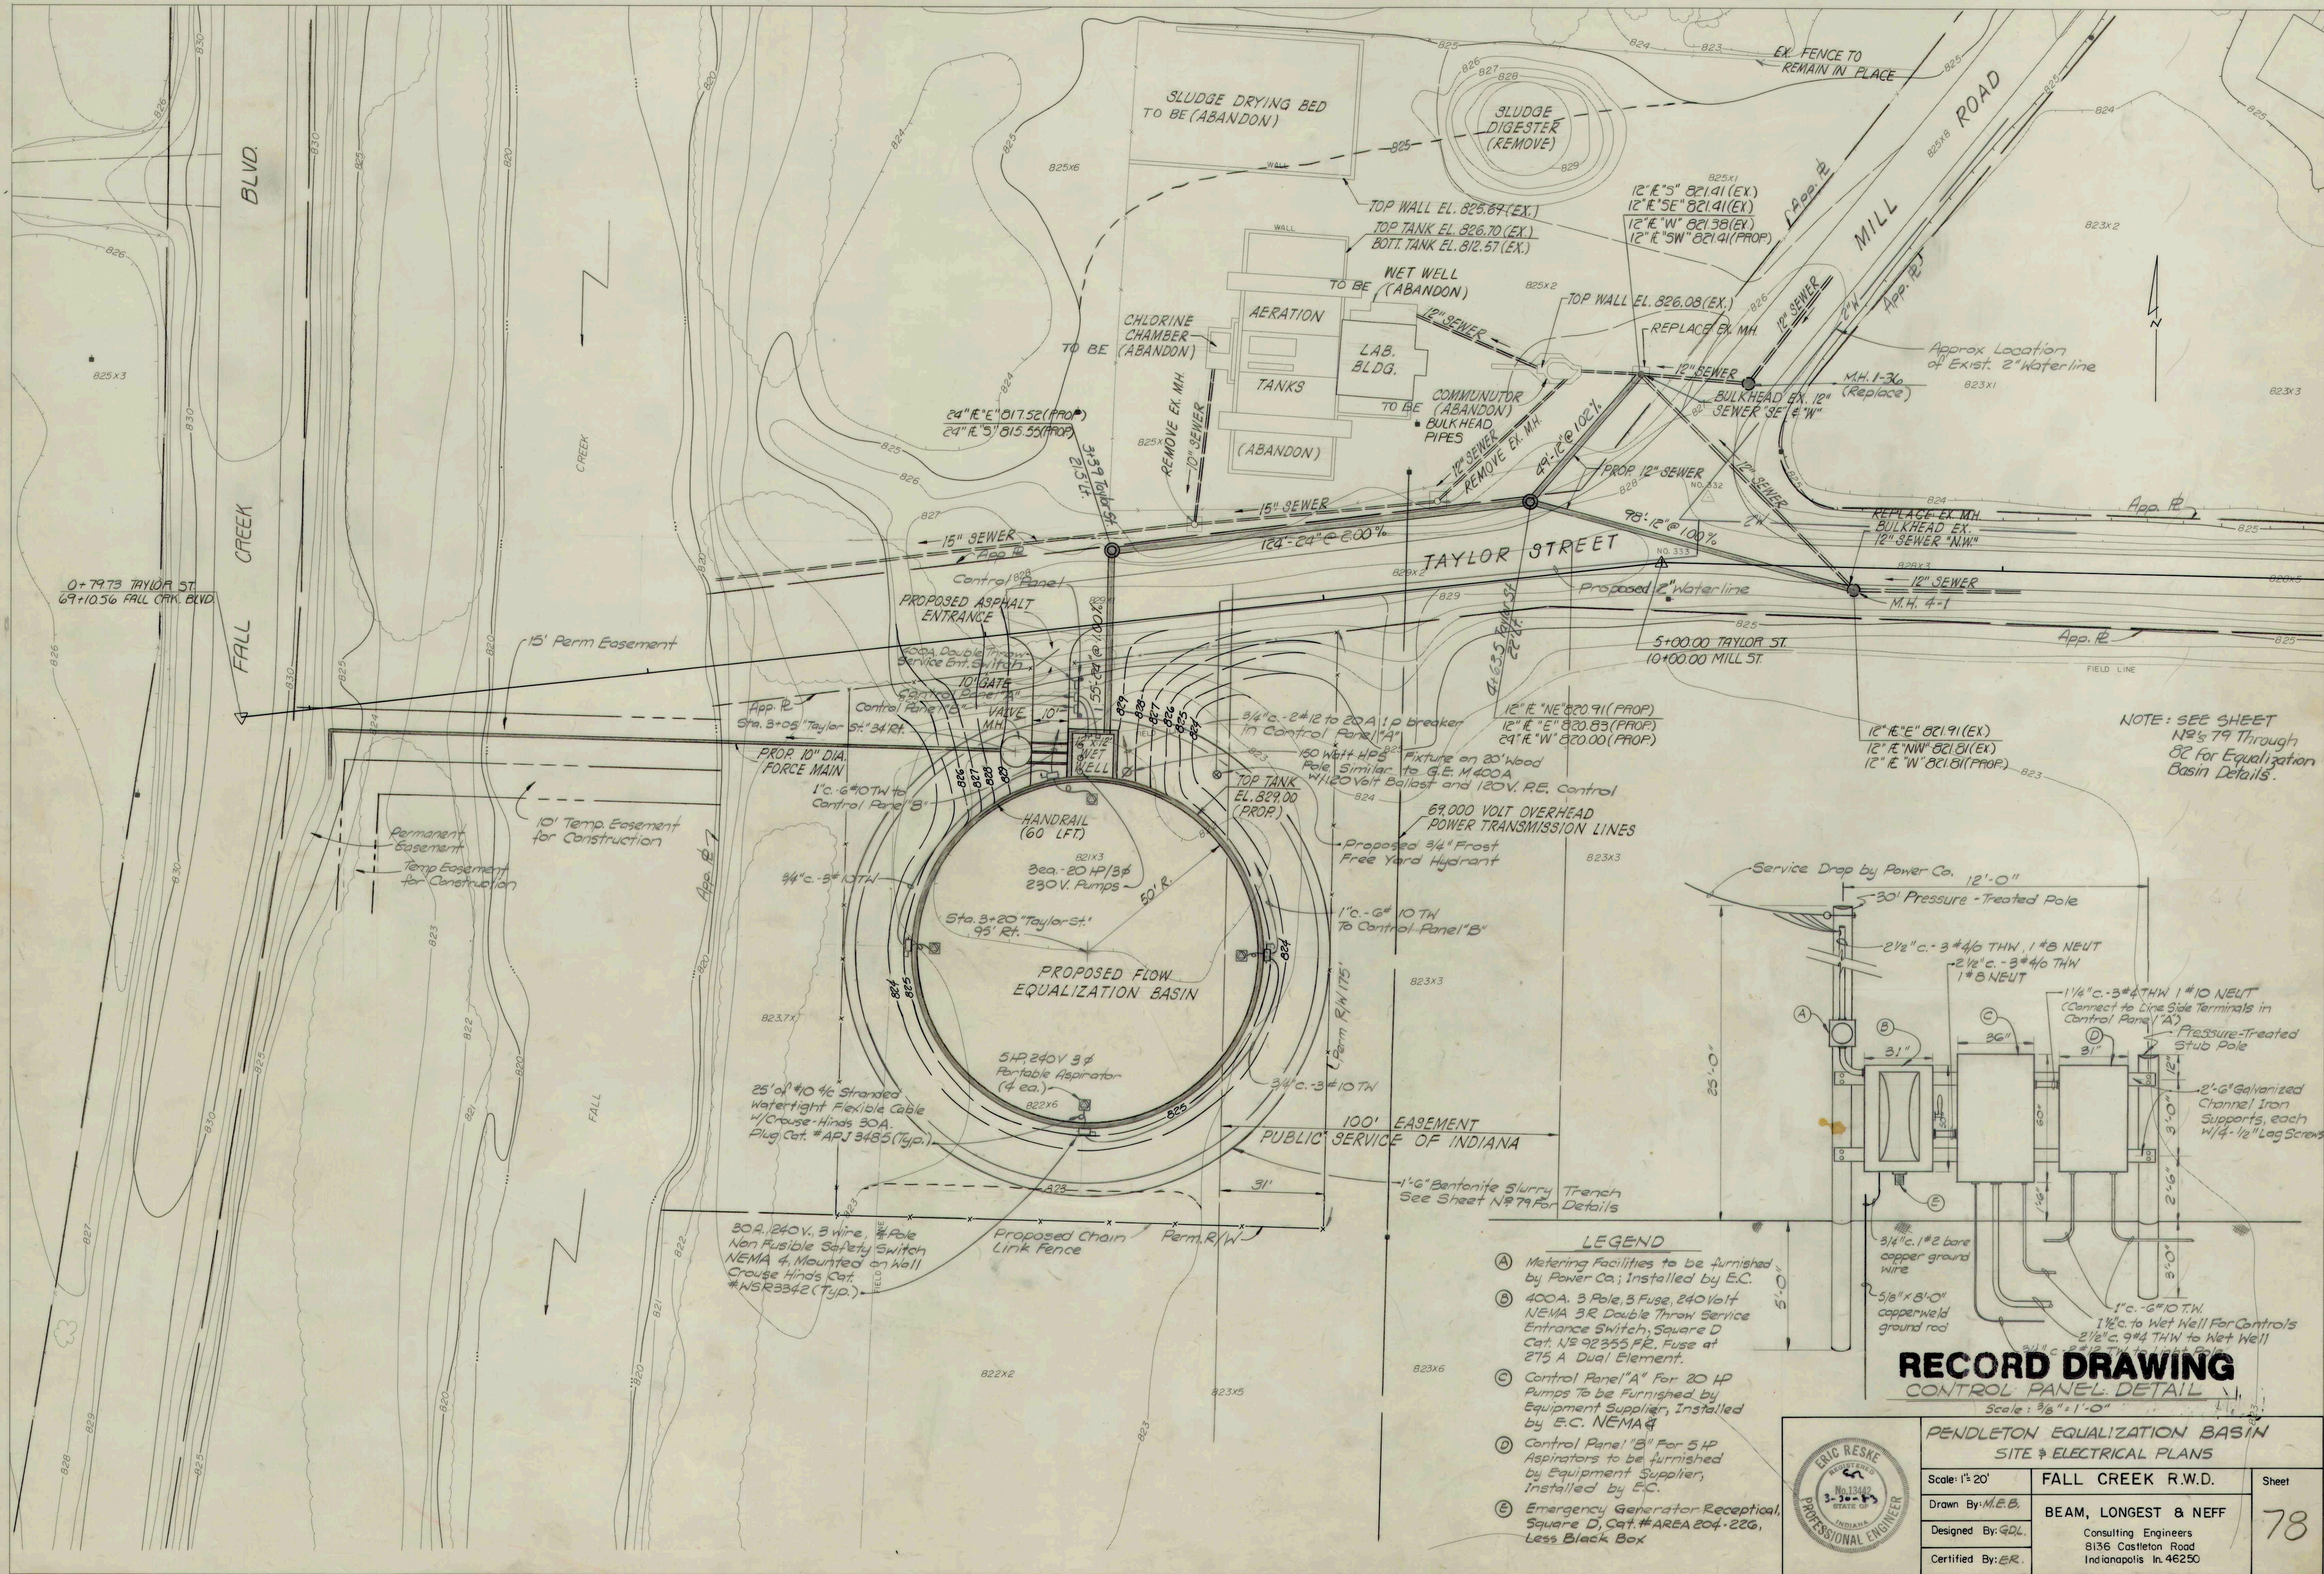

PENDLETON EQUALIZATION BASIN SITE & ELECTRICAL PLANS		
Scale: 1"=20'	FALL CREEK R.W.D.	Sheet
Drawn By: M.E.B.	BEAM, LONGEST & NEFF Consulting Engineers 8136 Castleton Road Indianapolis, IN 46250	
Designed By: GDL		
Certified By: ER		