


FCRW ADMIN REF Plans

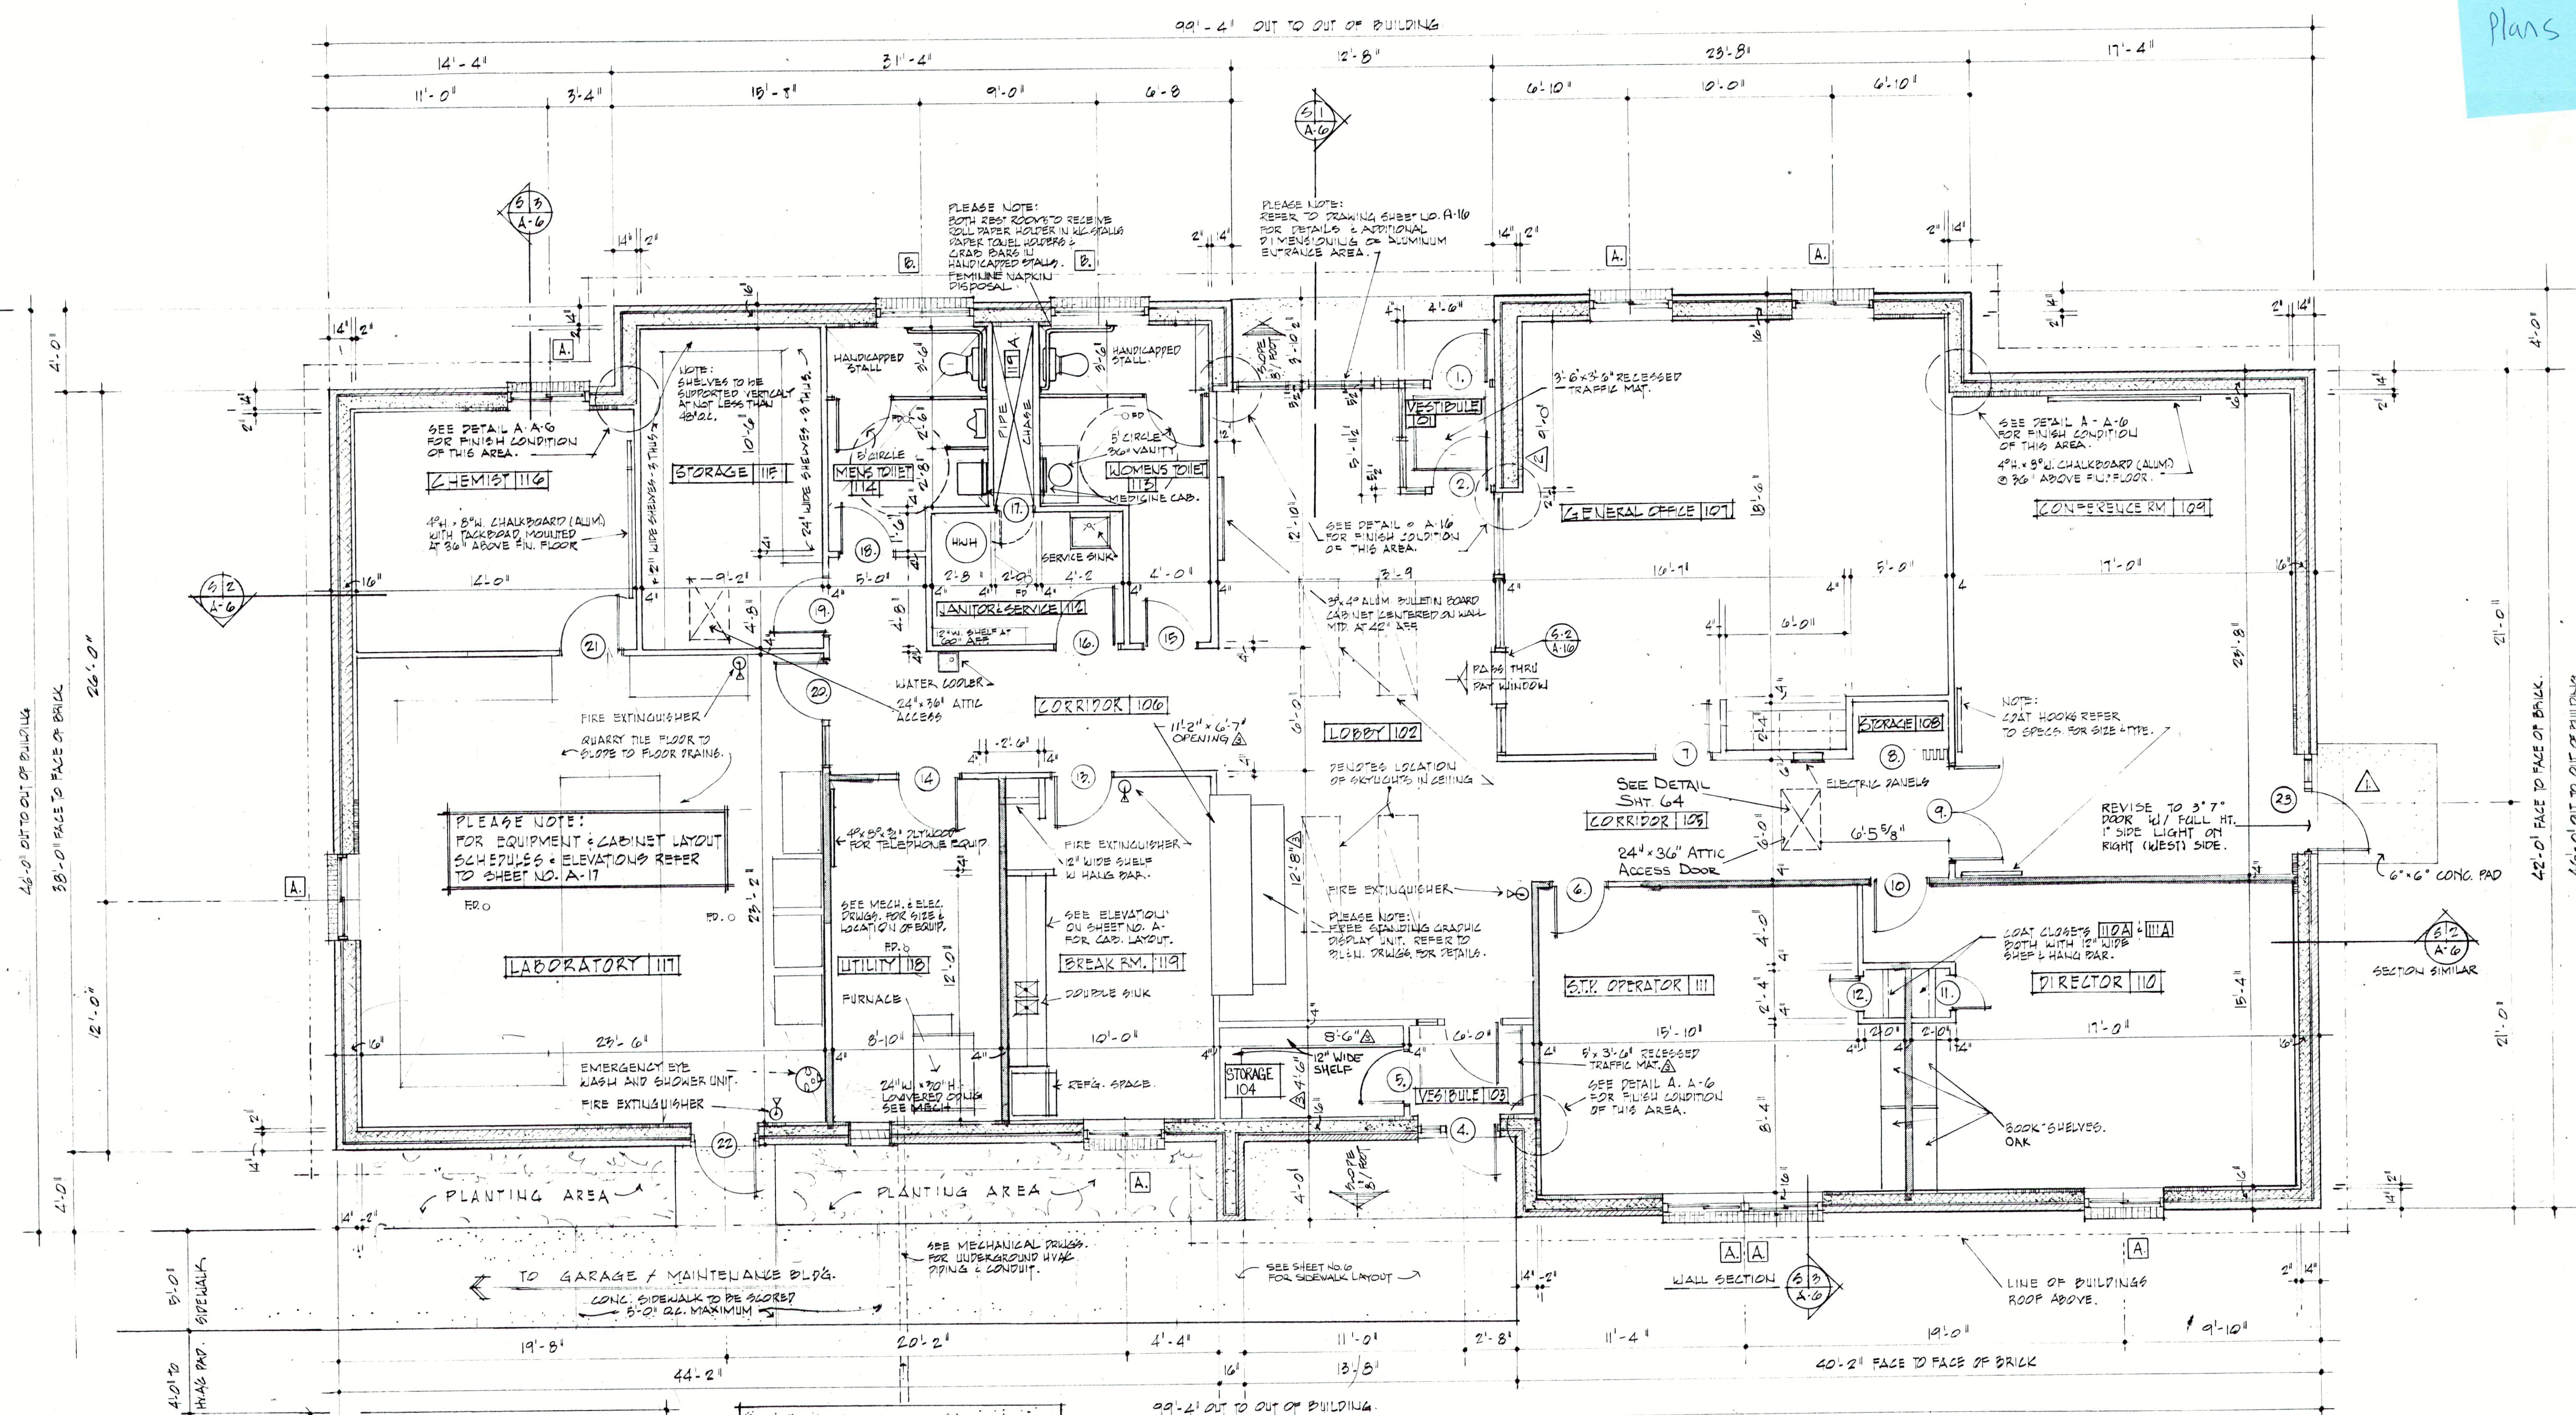

ADMINISTRATION / LABORATORY
FLOOR PLAN
SCALE: 1/4" = 1'-0"

INDICATES SOUND RETARDANT WALL

RECORD DRAWING

REVISIONS REV. 6-29-83 ELN REV. 8-24-84 B.O. REV. 10-15-84 BLN	edgibson and associates ARCHITECTS INCORPORATED INDIANAPOLIS, INDIANA DRAWN BY R10 CHECKED BY EAG DATE 3-30-89 CERTIFIED BY <i>Carrie C. Gibson</i>	Edwin A. Gibson REGISTERED ARCHITECT No. 720 STATE OF INDIANA	FALL CREEK REGIONAL WASTE DISTRICT WASTEWATER FACILITIES PENDLETON, INDIANA	SHEET NO. A-1
				ACCT. NO.
				DATE
				CERTIFIED BY
				38