
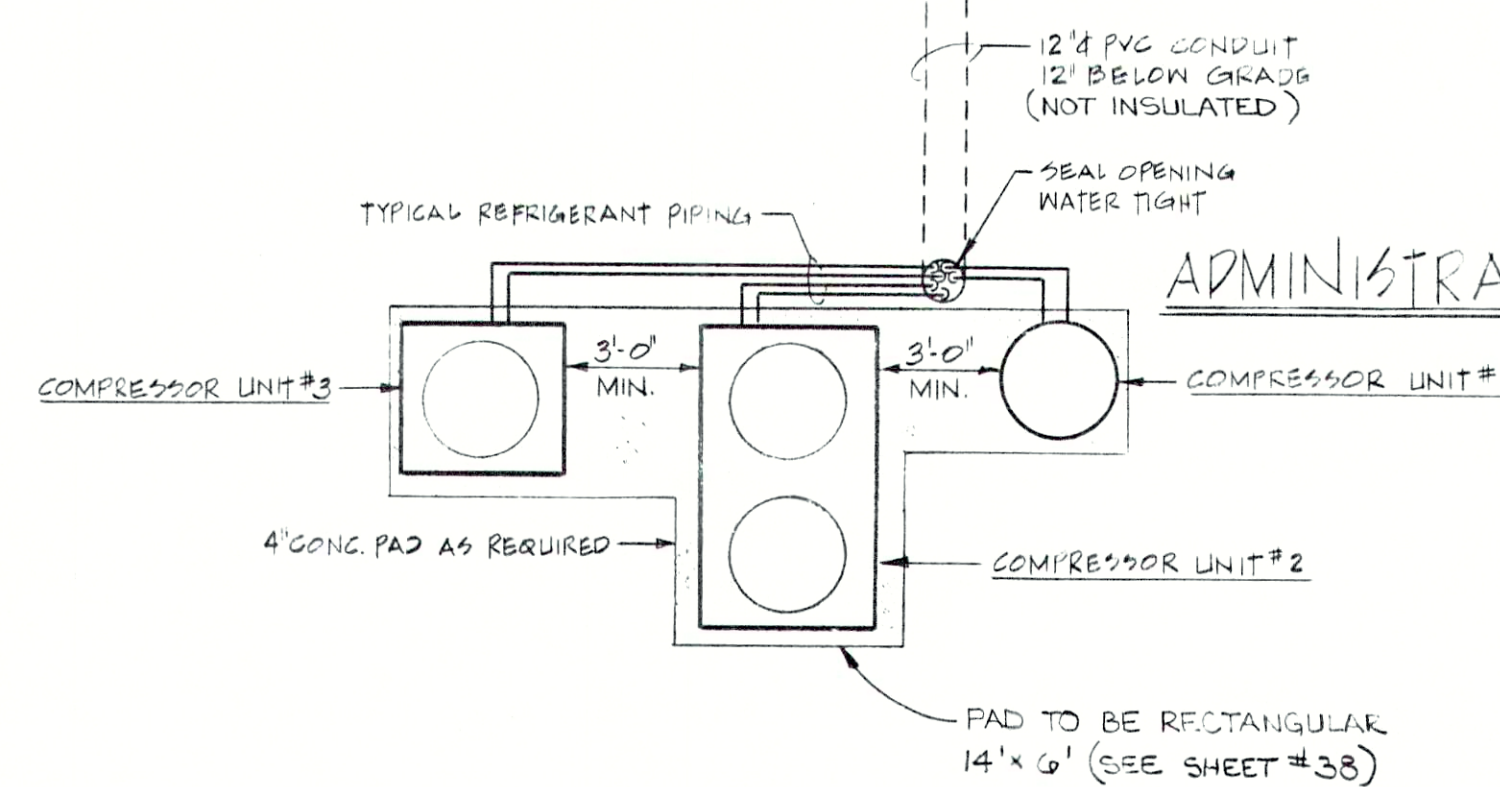



GENERAL NOTES:

1. ALL DUCTWORK SHOWN DIAGRAMMATIC AND MUST BE FIELD COORDINATED WITH BUILDING'S STRUCTURE, PLUMBING, LIGHTING AND ELECTRICAL CONSTRUCTION. ANY TRUSS MODIFICATIONS MUST BE APPROVED BY ARCHITECT/ENGINEER.
2. DIFFUSER AND GRILLE LOCATIONS SHALL BE FIELD COORDINATED WITH CEILING GRID AND LIGHTING.
3. GRILLES TO BE SPACED EVENLY IN CEILING TILE IN A WORKMAN LIKE MANNER.
4. EXACT EQUIPMENT LOCATIONS MUST BE COORDINATED WITH ELECTRICAL, PLUMBING AND GENERAL CONSTRUCTION.

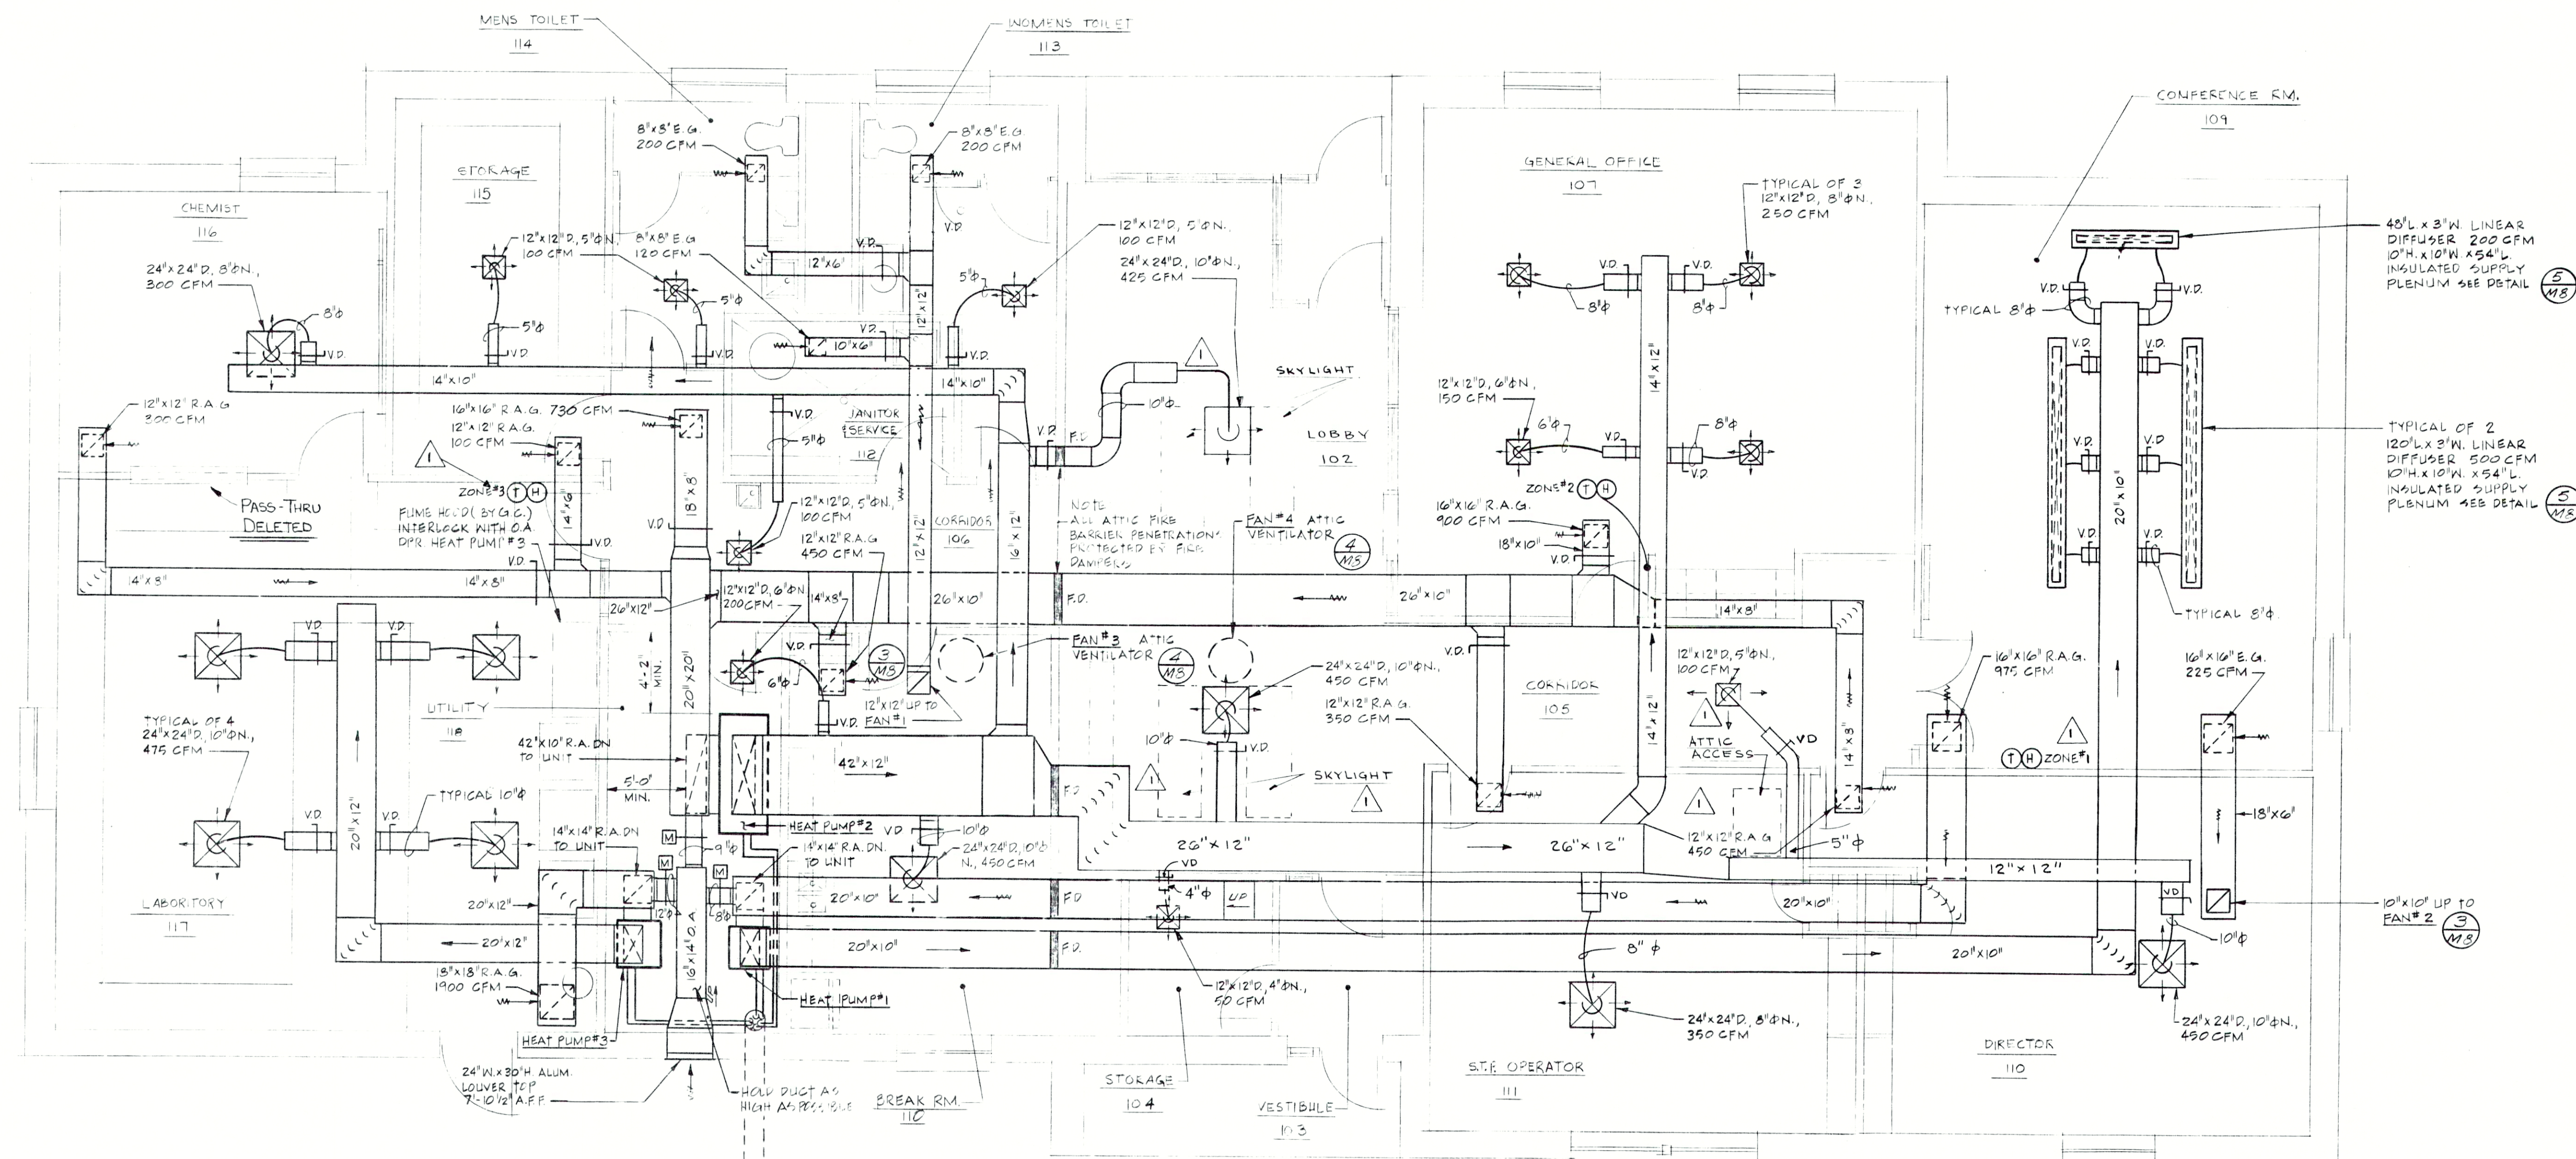

ADMINISTRATION/LABORATORY H.V.A.C. FLOOR PLAN

SCALE: 1/4" = 1'-0"

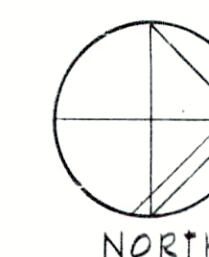

RECORD DRAWING

ADMINISTRATION/LABORATORY BLDG.

REVISIONS

FALL CREEK REGIONAL
WASTE DISTRICT
PENDLETON, INDIANA



edgibson and associates
INCORPORATED
ARCHITECTS
INDIANAPOLIS, INDIANA
DRAWN BY: ELAIE, B.
CHECKED BY: DATE: 8/202
CERTIFIED BY: *Ed Gibson*

SHEET NO.

M-1

55

OF