



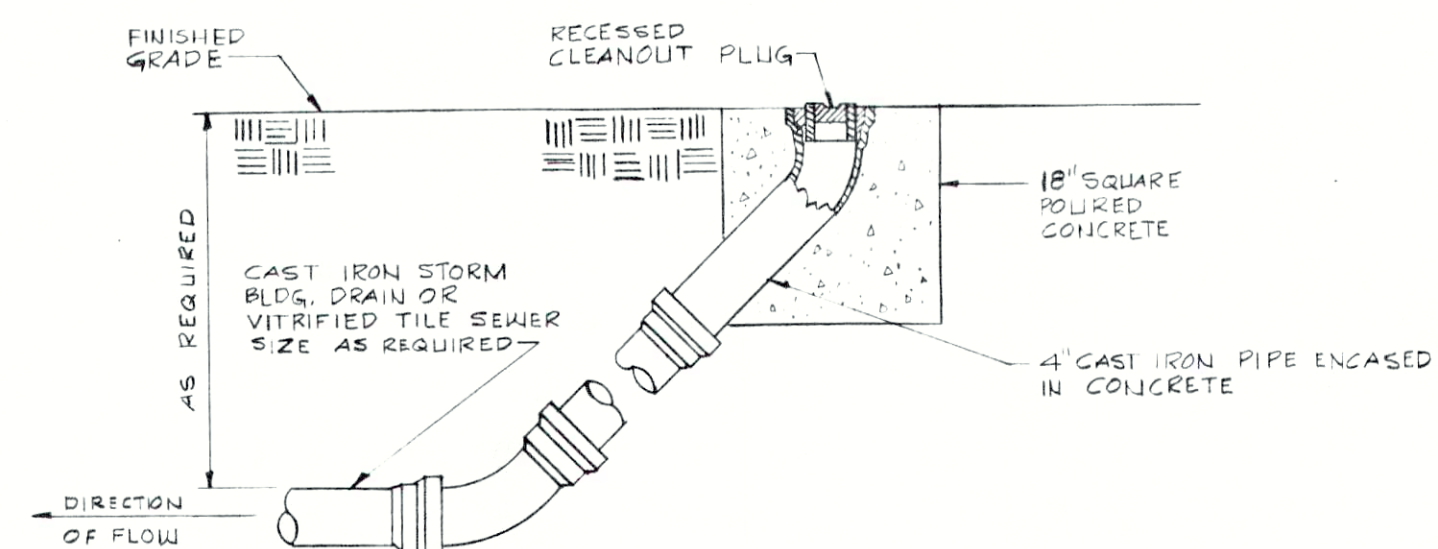

TYPICAL OUTSIDE CLEANOUT DETAIL
NO SCALE

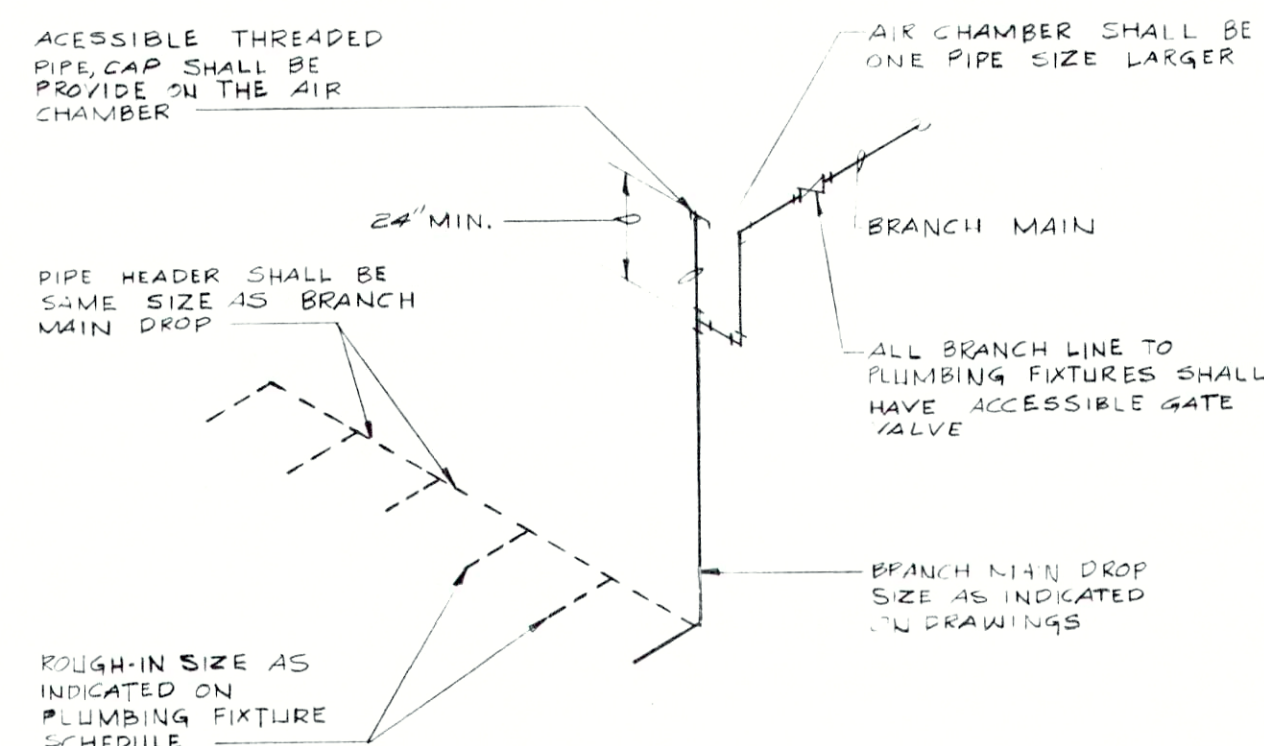


(PIPING TO FIXTURES BELOW WATER MAIN)
WATER HAMMER CONTROL DETAIL
NO SCALE

PLUMBING FIXTURE SCHEDULE							
ITEM	FIXTURE	ROUGH-IN		FINAL CONNECTION		MOUNTING HEIGHT	NOTE
		WASTE	VENT	C.W.	H.W.		
P-1	WATER CLOSET	4"	2"	1/2"	—	15"	1
P-2	WATER CLOSET (H.C.)	4"	2"	1/2"	—	19"	1
P-3	URINAL	2"	1 1/2"	3/4"	—	24"	1
P-4	LAVATORY (WALL MOUNTED)	1 1/2"	1 1/2"	1 1/2"	1 1/2"	31"	1
P-5	LAVATORY (WALL MOUNTED) (H.C.)	1 1/2"	1 1/2"	1 1/2"	1 1/2"	34"	1
P-6	COUNTERTOP LAVATORY (H.C.)	1 1/2"	1 1/2"	1 1/2"	1 1/2"	34"	1
P-7	SHOWER	S.D.	—	3/4"	3/4"	72"	1
P-8	SERVICE SINK	3"	1 1/2"	3/4"	3/4"	26"	1
P-9	ELECTRIC WATER COOLER (H.C.)	1 1/4"	1 1/4"	1 1/2"	—	36"	1
P-10	EMERGENCY EYE & SHOWER STA.	F.D.	—	3/4"	—	FLOOR MOUNTED	1
P-11	KITCHEN SINK TRIM.	1 1/2"	1 1/2"	1 1/2"	1 1/2"	—	1
P-12	ELECTRIC WATER COOLER	1 1/4"	1 1/4"	1 1/2"	—	40"	1
P-13	LABORATORY SINK TRAY	1 1/2"	1 1/2"	1 1/2"	1 1/2"	—	1
P-14	SHOWER FLOOR	—	—	—	—	—	—


SCHEDULE NOTES:

1. ROUGH-IN OF WATER SUPPLIES SHALL BE SAME SIZE AS BRANCH MAIN DROP AS SHOWN ON PLANS, ALSO SEE WATER HAMMER CONTROL DETAIL ON THIS SHEET.

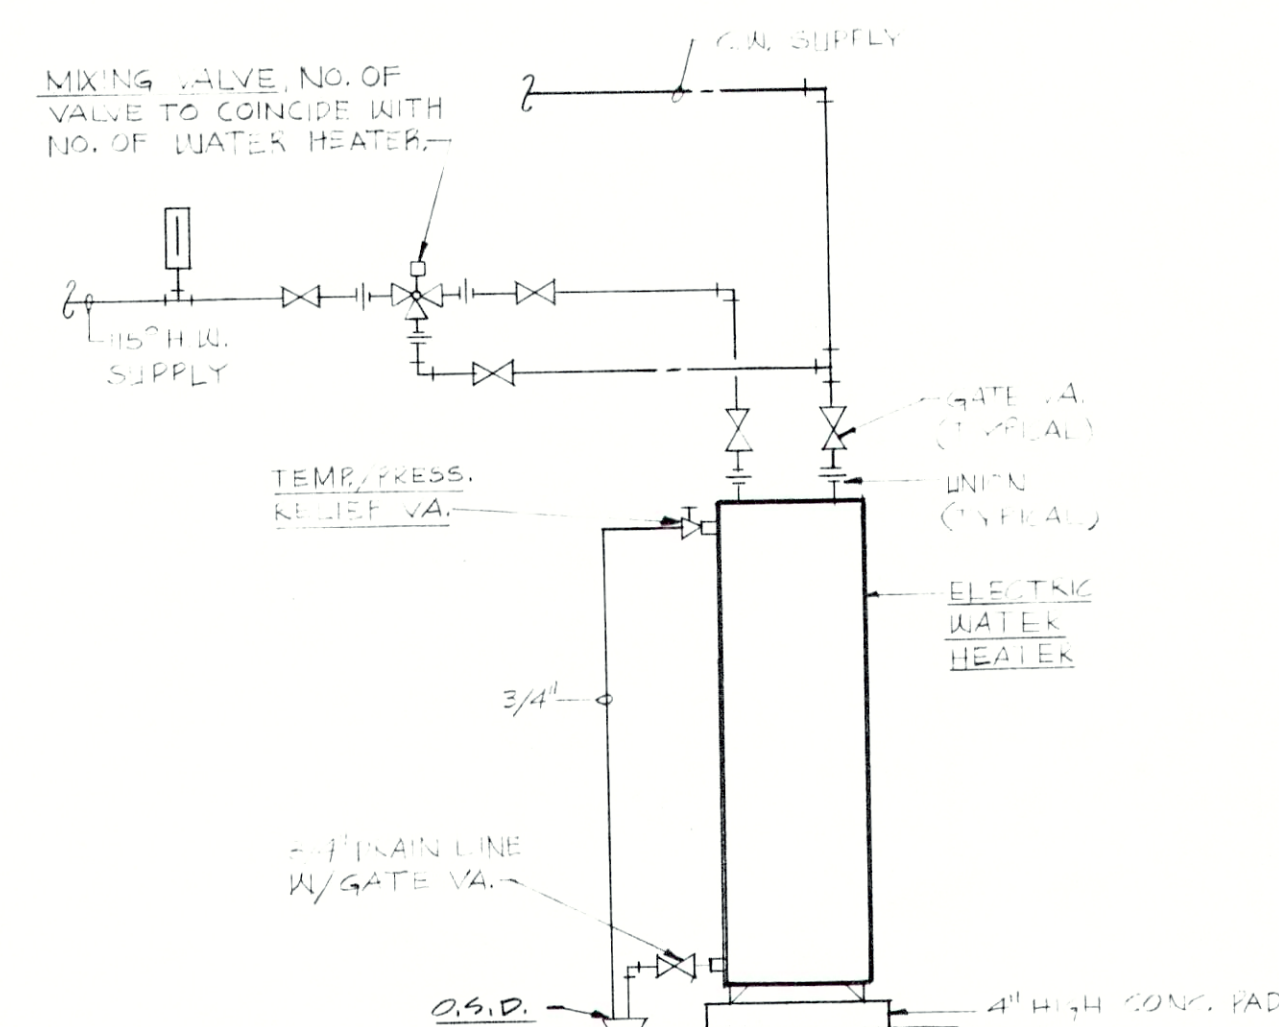

DOMESTIC HOT WATER HEATER DETAIL
TYPICAL
NO SCALE

LEGEND OF SYMBOLS	
NAME	SYMBOL
COLD WATER	---
HOT WATER	---
CAST IRON-BURIED	---
CAST IRON-SUSPENDED	---
VITRIFIED TILE BURIED	---
PLUMBING VENT	---
CONDENSATE DRAIN	---
WATER CLOSET	W.C.
URINAL	UR.
LAVATORY	LAV.
ELECTRIC WATER COOLER	E.W.C.
FIRE EXTINGUISHER CABINET	F.E.C.
SHOWER	SH.
MOP SERVICE BASIN	M.S.B.
ROOF DRAIN	R.D.
OPEN SIGHT DRAIN	O.S.D.
FLOOR DRAIN	F.D.
ROOF CONDUCTOR	R.C.
SHOWER DRAIN	SH. DR.
CLEAN OUT	C.O.
THERMOSTAT	TH.
WALL HYDRANT	W.H.
GATE VALVE	— — OR — —
CHECK VALVE	— —
BALANCING VALVE	— —
GLOBE VALVE	— —
STRAINER	— —
UNION	— —
VOLUME DAMPER	— —
THERMOMETER	— —
PRESSURE GAUGE	— —
AIR OUTLET	— —
VACUUM OUTLET	— —
GAS OUTLET	— —

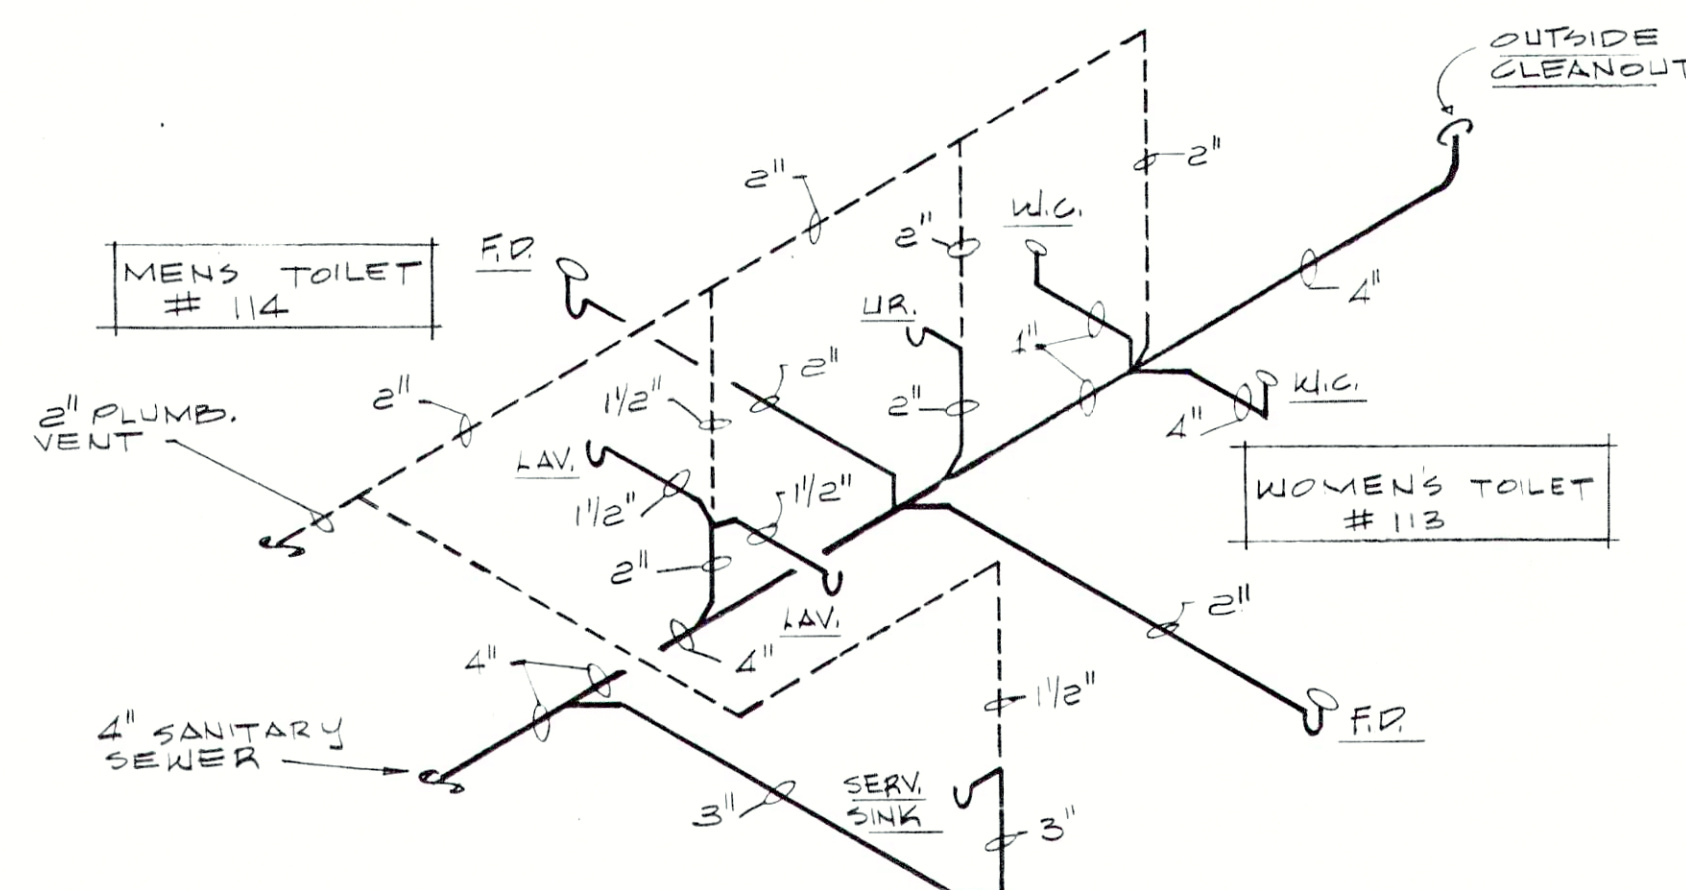

WASTE & VENT DIAGRAM
(ADMIN./LAB BUILDING)
NO SCALE

RECORD DRAWING

DETAILS & SCHEDULES

REVISIONS		edgibson and associates		SHEET NO.
		ARCHITECTS INCORPORATED		M-9
		INDIANAPOLIS, INDIANA		
		DRAWN BY: DKB, R.T. ACCT. NO. 2302		
		CHECKED BY: DATE		
		CERTIFIED BY: [Signature]		
		FALL CREEK REGIONAL WASTE DISTRICT WASTEWATER FACILITIES PENDLETON, INDIANA		
				63