

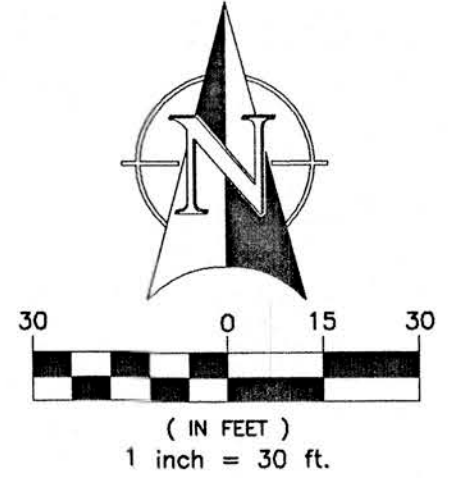


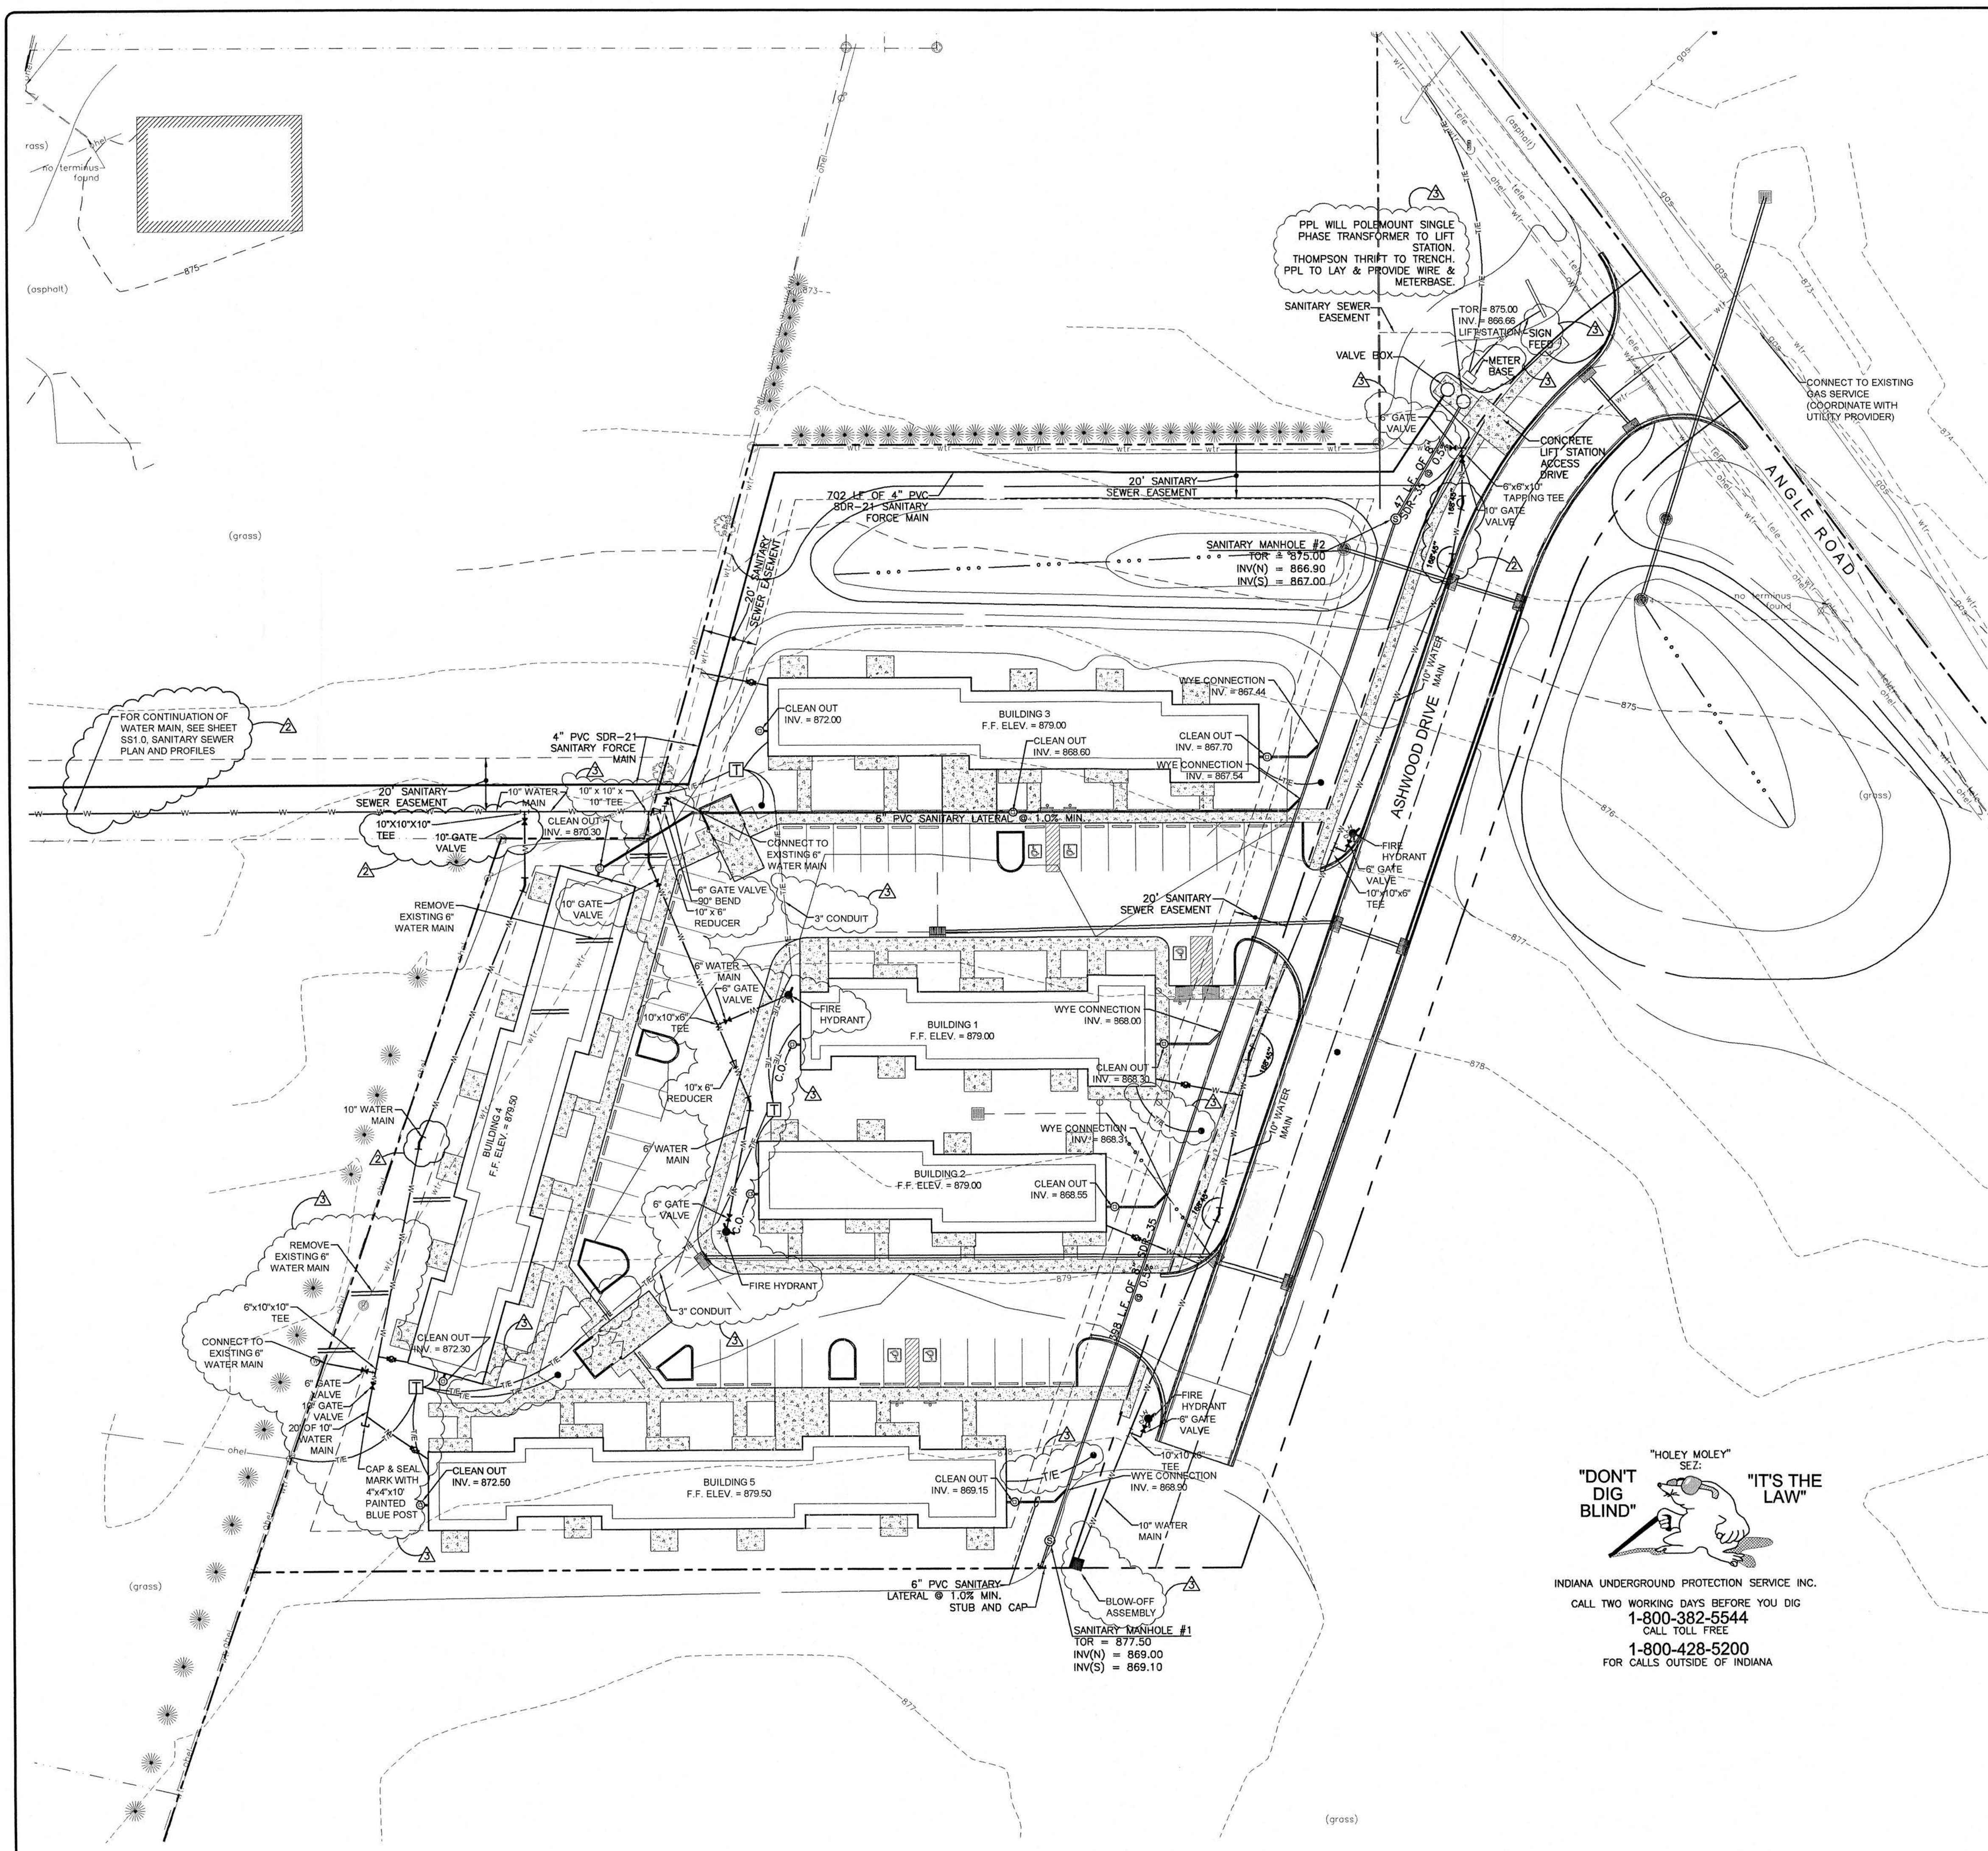


LEGEND:	
DESCRIPTION:	DESCRIPTION:
EXISTING ASPHALT	WATER VALVE
EXISTING STONE	FIRE HYDRANT
EXISTING CONCRETE	WATER METER
TEMPORARY BENCH MARK	STAND PIPE
REBAR FOUND/REBAR SET	INLET
MONUMENT	METAL END SECTION
IRON PIPE FOUND	DECIDUOUS TREE
POWER POLE	CONIFEROUS TREE
GUY WIRE	OVERHEAD ELECTRIC LINE
TELEPHONE PEDESTAL	UNDERGROUND ELECTRIC
SANITARY MANHOLE	WATER LINE
GAS VALVE	GAS LINE
GAS METER	FENCE
SIGN	
GUARD POST	

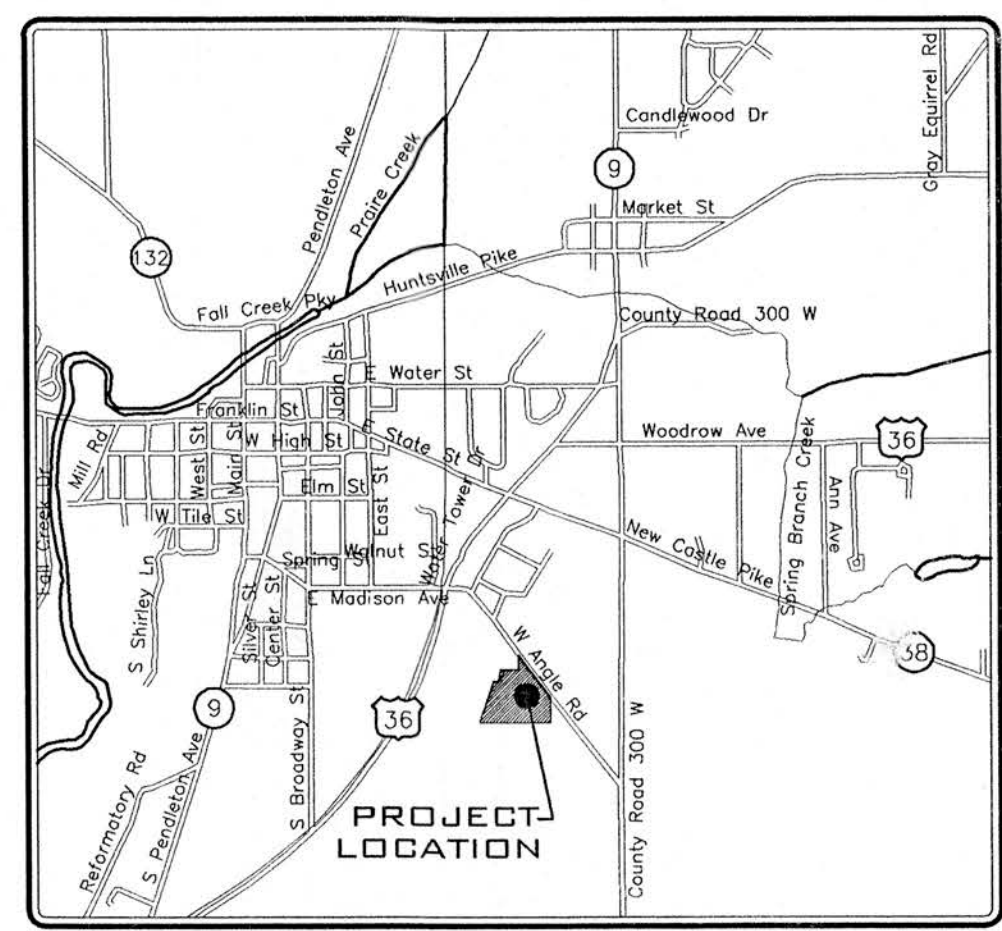

PROPOSED UTILITY LEGEND:	
DESCRIPTION:	DETAIL #/SH. #
PROPOSED SANITARY MANHOLE	DETAIL 01/C7.1
PROPOSED CLEAN OUT	DETAIL 02/C7.1
PROPOSED FIRE HYDRANT	DETAIL 03/C7.1
PROPOSED WATER VALVE	DETAIL 04/C7.1
PROPOSED THRUST BLOCK	DETAIL 05/C7.1
PROPOSED ELECTRIC LINE	
PROPOSED TELEPHONE LINE	
PROPOSED WATER LINE	
PROPOSED GAS LINE	
PROPOSED FIRE PROTECTION LINE	
PROPOSED TELEPHONE & ELECTRIC LINE	

UTILITY STATEMENT:
The underground utilities shown have been located from field survey information and existing drawings. The surveyor makes no guarantees that the underground utilities comprise all such utilities in the area, either in-service or abandoned. The surveyor further does not warrant that the underground utilities shown are in the exact location indicated although the surveyor does certify that they are located as accurately as possible from information available. The surveyor has not physically located the underground utilities.

- REV. 1 - 02/23/04 - ROLLED CURB @ LIFT STATION ENTRANCE
REV. 2 - 03/15/04 - REVISED SETBACKS TO 15'; MOVED BLDGS 1, 2, 3, & 5, & PARKING TO NORTH; EMBODIED WATER LINES; ADDED NOTES AND SYMBOLS FOR 2 TEES; ADDED FITTINGS FOR BENDS IN THE 10" WATER MAIN NOT PREVIOUSLY SHOWN; REVISED 6" GATE VALVE TO 10" GATE VALVE; ADDED NOTE TO SEE SHEET SS1.0 FOR CONTINUATION OF WATER MAIN; ADDED REVISION NOTE 1 TO THIS SHEET
REV. 3 - 03/31/04 - REVISED WATER LINE: REMOVED 10" LOOP SOUTH OF BUILDING 5; REMOVED 8" LINES TO INTERIOR HYDRANTS & ADDED 10" LINE TO INTERIOR HYDRANTS; REVISED WATER CONNECTION TO EXISTING 6" LINE AT WEST PROPERTY LINE; ADDED METER BASE AT LIFT STATION; ADDED NOTE FOR TRANSFORMER AT LIFT STATION; CHANGED POWER REQUIREMENT FROM 3-PHASE TO SINGLE PHASE; UPDATED TRANSFORMER LOCATION AND ELECTRIC/TELEPHONE CONNECTIONS TO BUILDINGS.

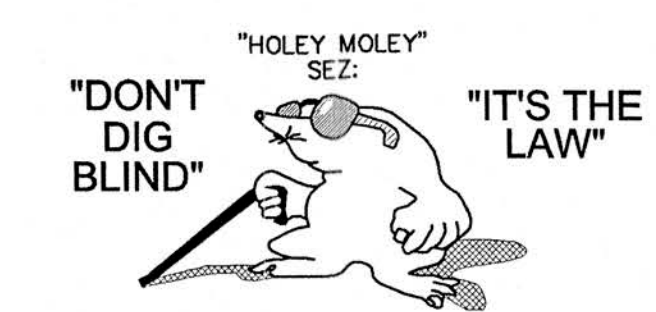

INDIANA UNDERGROUND PROTECTION SERVICE INC.
CALL TWO WORKING DAYS BEFORE YOU DIG
1-800-382-5544
CALL TOLL FREE
1-800-428-5200
FOR CALLS OUTSIDE OF INDIANA

BROAD RIPPLE DESIGN ASSOCIATES, L.L.C.
660 EAST 62ND STREET
INDIANAPOLIS, IN 46220-1870

CIVIL DESIGNS, LLP
2415 DIRECTORS ROW, SUITE E
INDIANAPOLIS, INDIANA 46241
PHONE: 317-244-1988
FAX: 317-244-1989

DATE: 04/23/04

ASHBURY POINTE APARTMENTS
ASHWOOD DRIVE
PENDLETON, INDIANA

UTILITY PLAN

DWN BY: KRC
CHKD. BY: JMP
SCALE: 1" = 30'
DATE: 02/23/04

PROJECT NUMBER
03-159

DESIGN PHASE
CONSTRUCTION

PLAN NUMBER
C5.0
SHEET OF