



PLOTTED BY: jhlmson

PRINTED: 1/12/2018 @ 8:05AM

FILE NAME: G:\4625-FORWARD-BFLS\Working Drawings\AutoCAD\4625-C-05.dwg


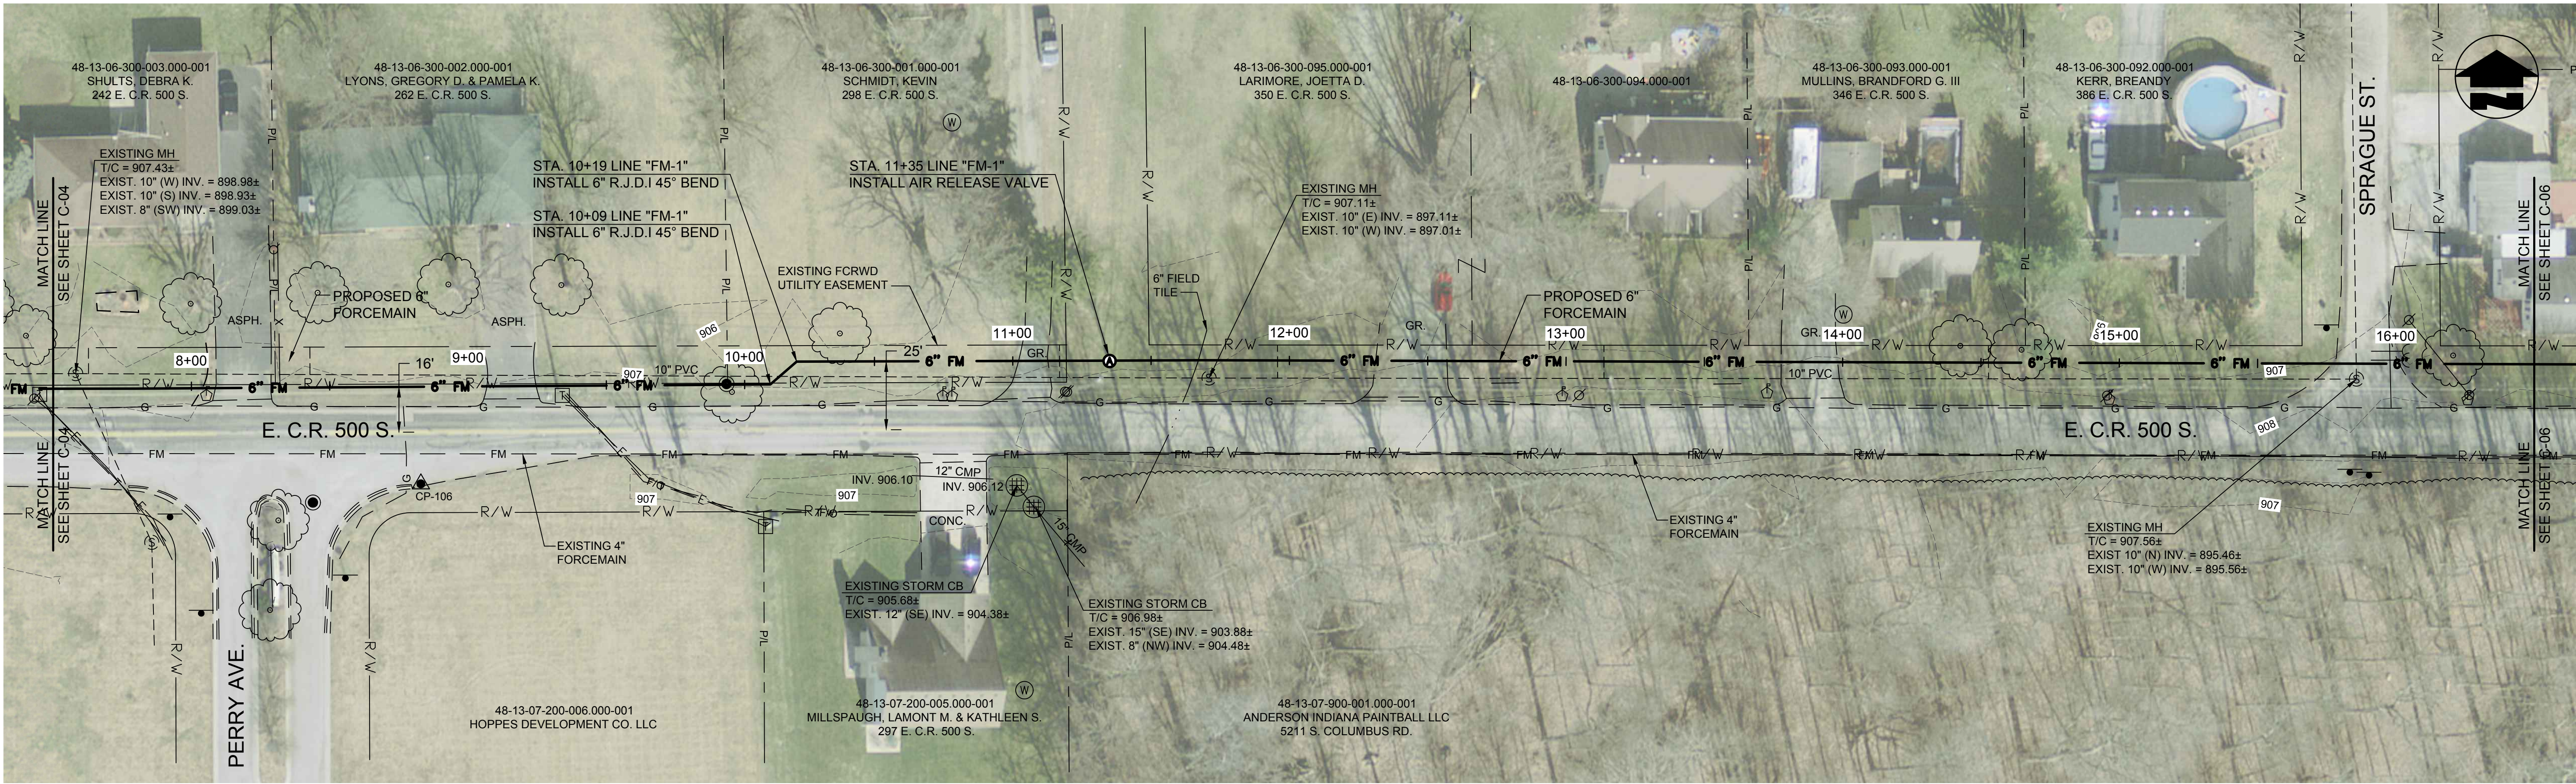


PLAN VIEW - STA. 7+50 TO STA. 16+50 LINE "FM-1"

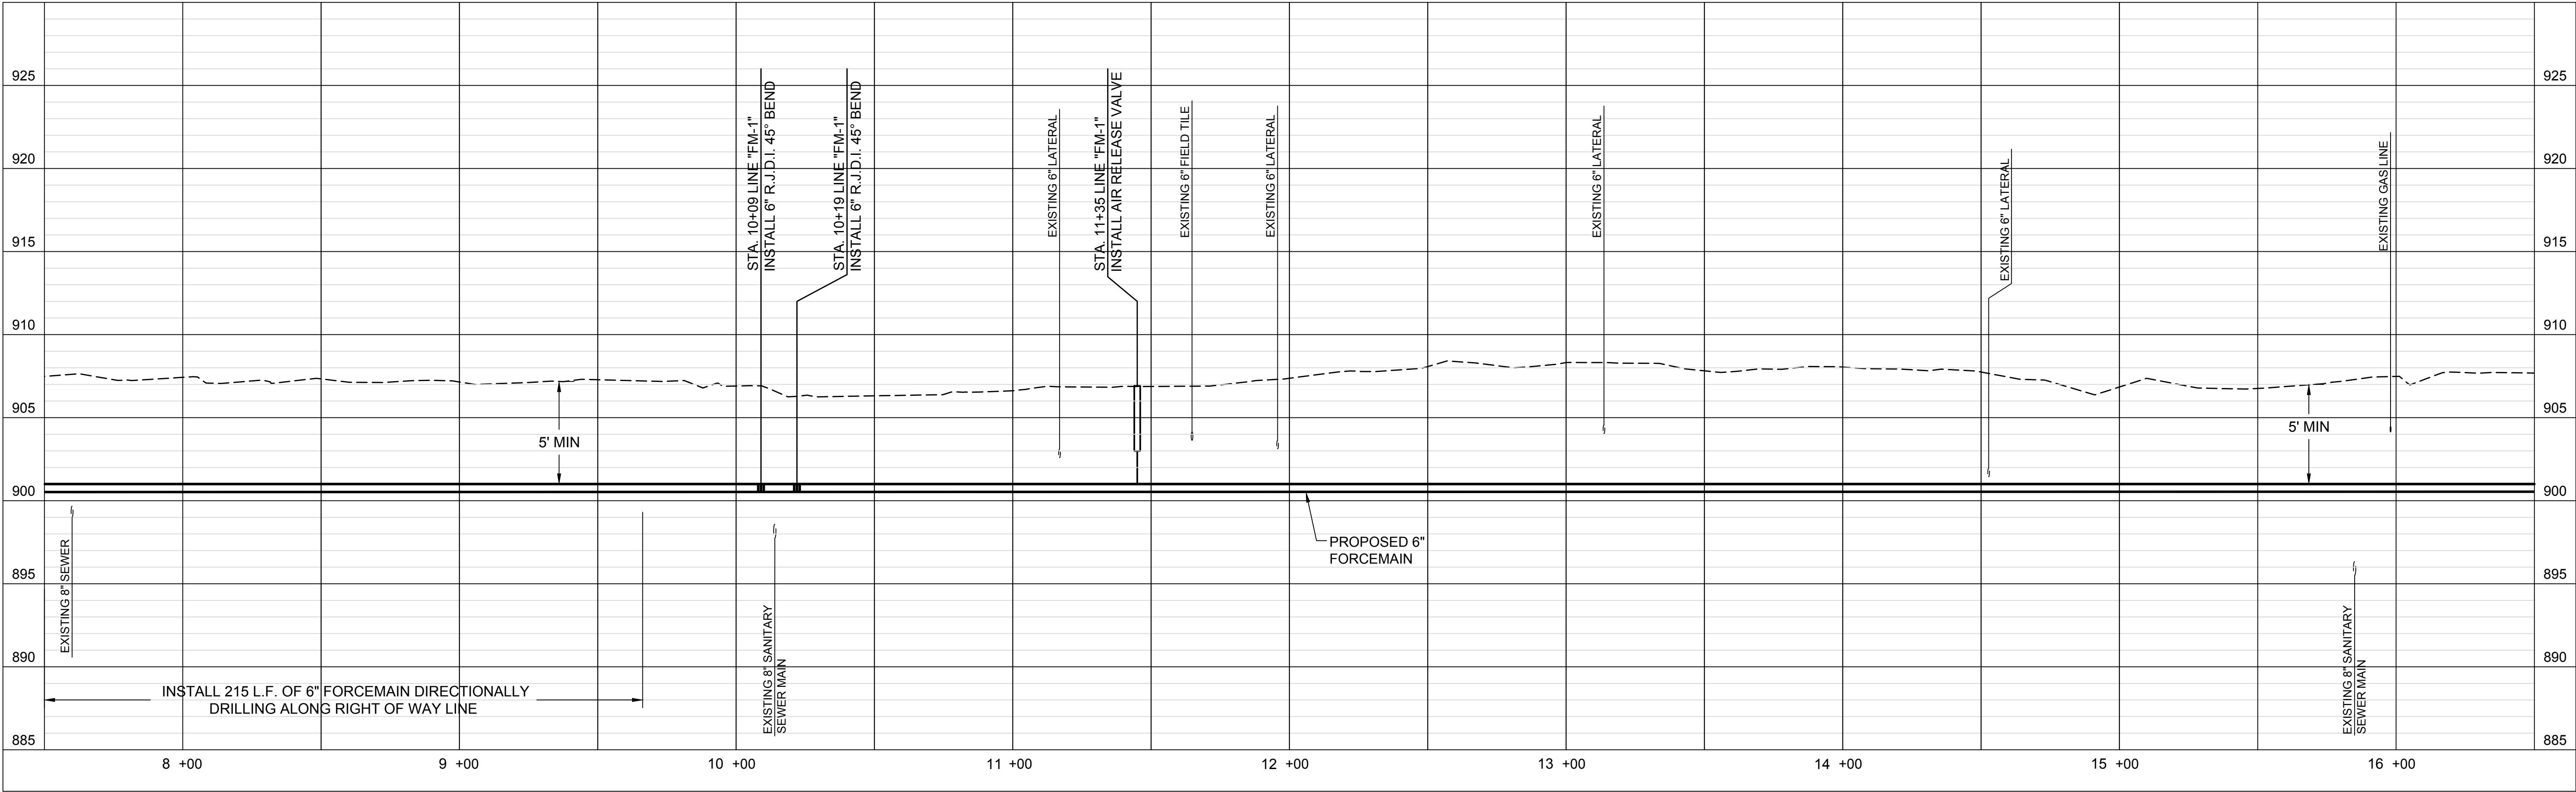


PROFILE VIEW - STA. 7+50 TO STA. 16+50 LINE "FM-1"

NOTE:
1. INSTALL FORCEMAIN FROM STA. 0+00 TO 21+50
AT CONSISTENT TOP OF PIPE ELEVATION = 901.00
TO AVOID CREATING HIGH POINTS

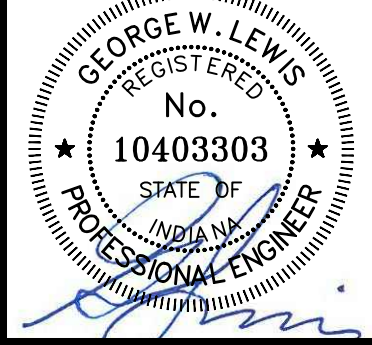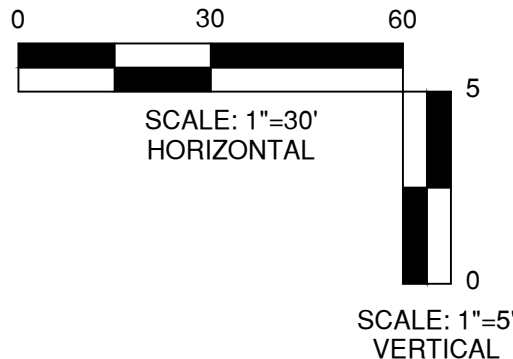

GRW PROJECT NO. 4625
CLIENT PROJECT NO. -
ALL RIGHTS RESERVED.
THIS DOCUMENT IS THE PROPERTY OF
GEORGE W. LEWIS & ASSOCIATES, INC.
IT IS TO BE USED ONLY FOR THE PROJECT
SPECIFICALLY IDENTIFIED HEREIN.
OTHER THAN THIS SPECIFIC PROJECT
WITHOUT WRITTEN PERMISSION.

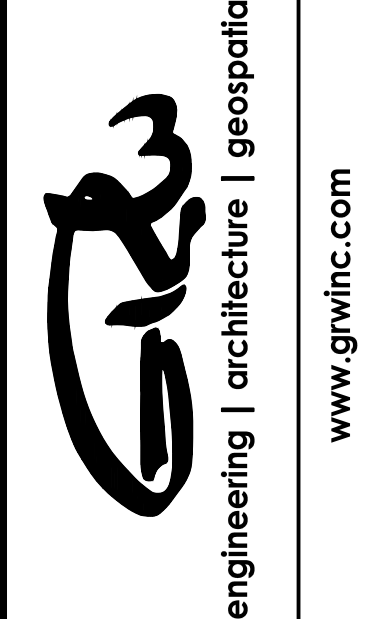

PLAN AND PROFILE
BABY FARMS LIFT STATION AND FORCE MAIN IMPROVEMENTS
FALL CREEK REGIONAL WASTE DISTRICT

DESIGNED	BY	DATE	DESCRIPTION
GWL	JAU	JPT	GWL

NO.	DATE	DESCRIPTION
1		ISSUED FOR PERMIT
2		FOR CONSTRUCTION
3		AS BUILT

DATE: NOVEMBER 2017
SCALE: H: 1"=30' V: 1"=5'
SHEET NO.

C-05