
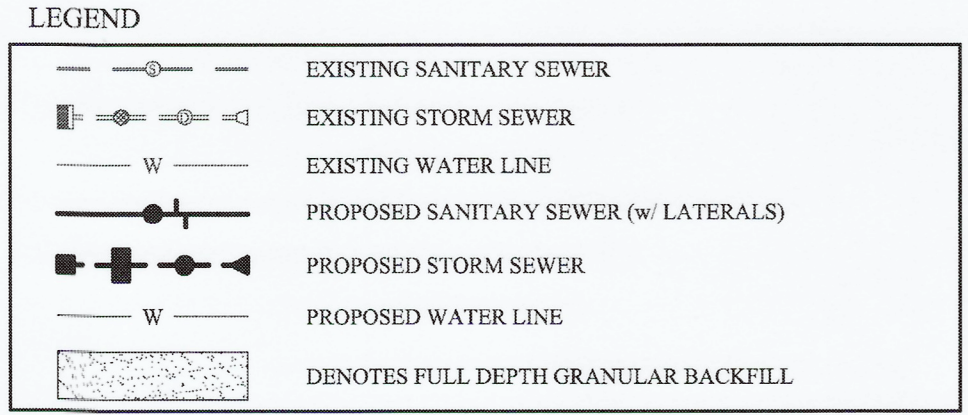
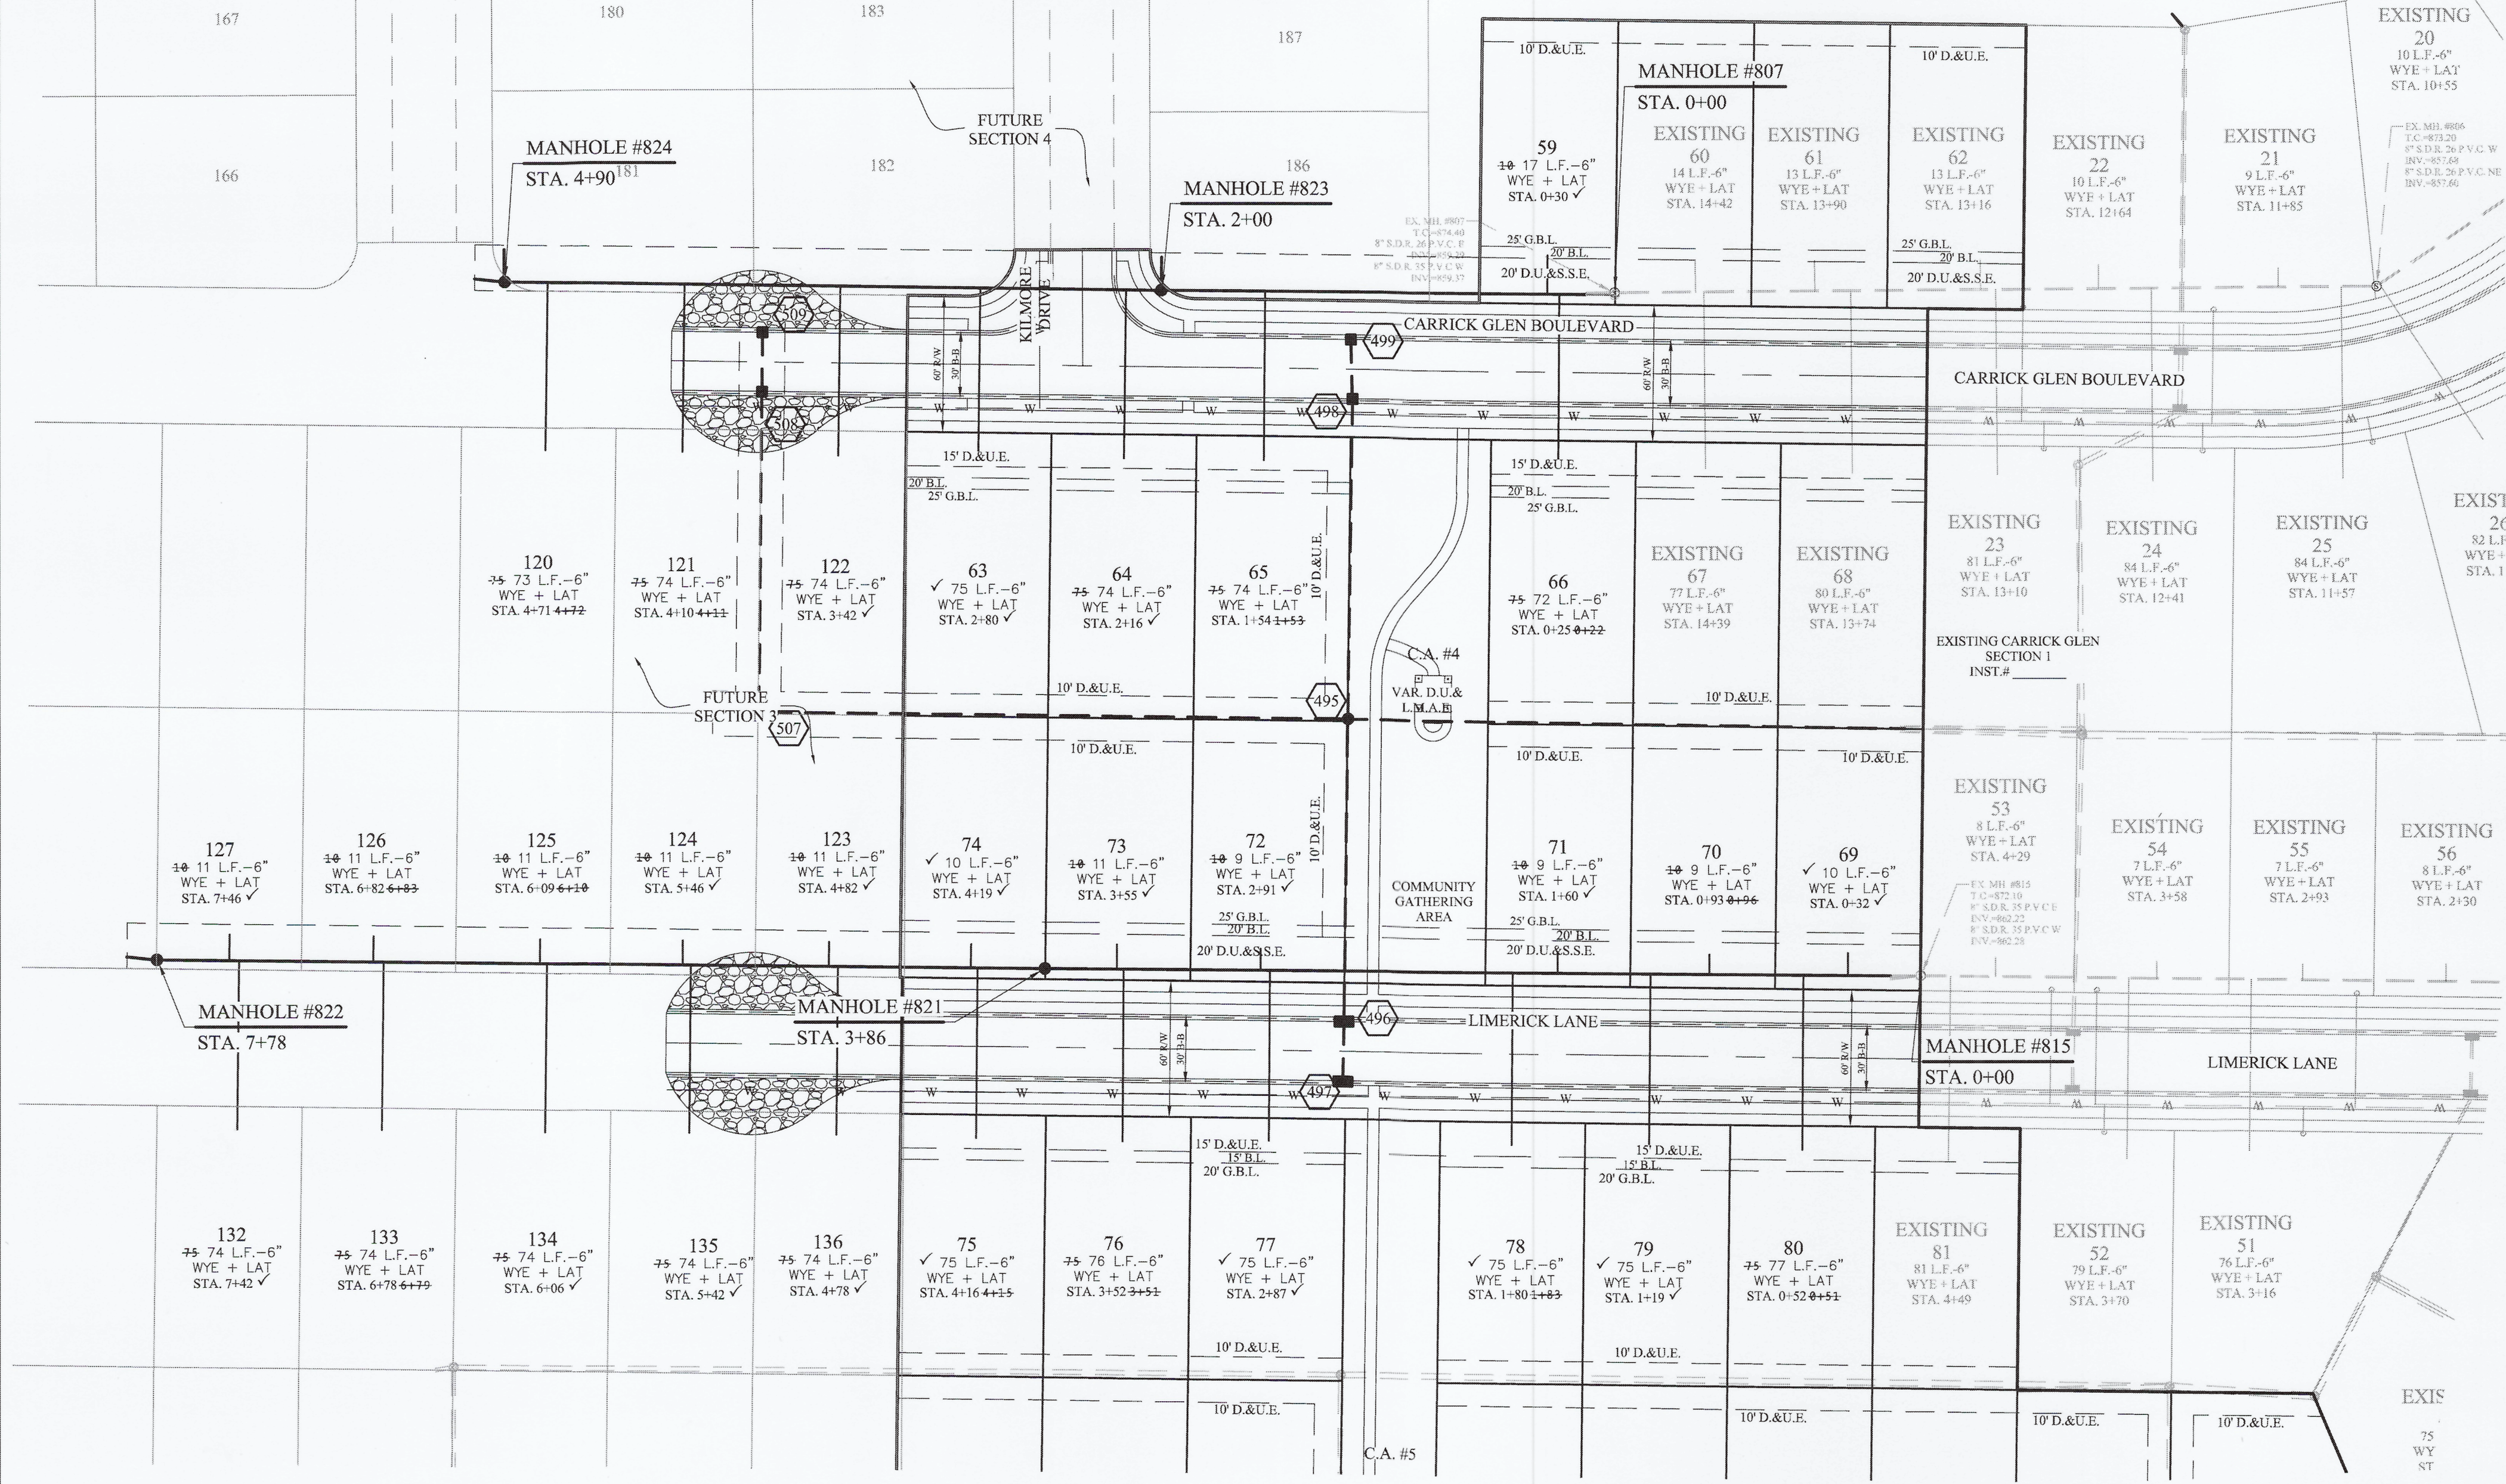


File Name: S:\8449DRH-S2DWG\C500 - Sanitary Plan & Profile.dwg - C500
Modified / By: February 1, 2021 9:12:06 AM / mevens
Plotted / By: February 1, 2021 9:13:32 AM / Michael Evans

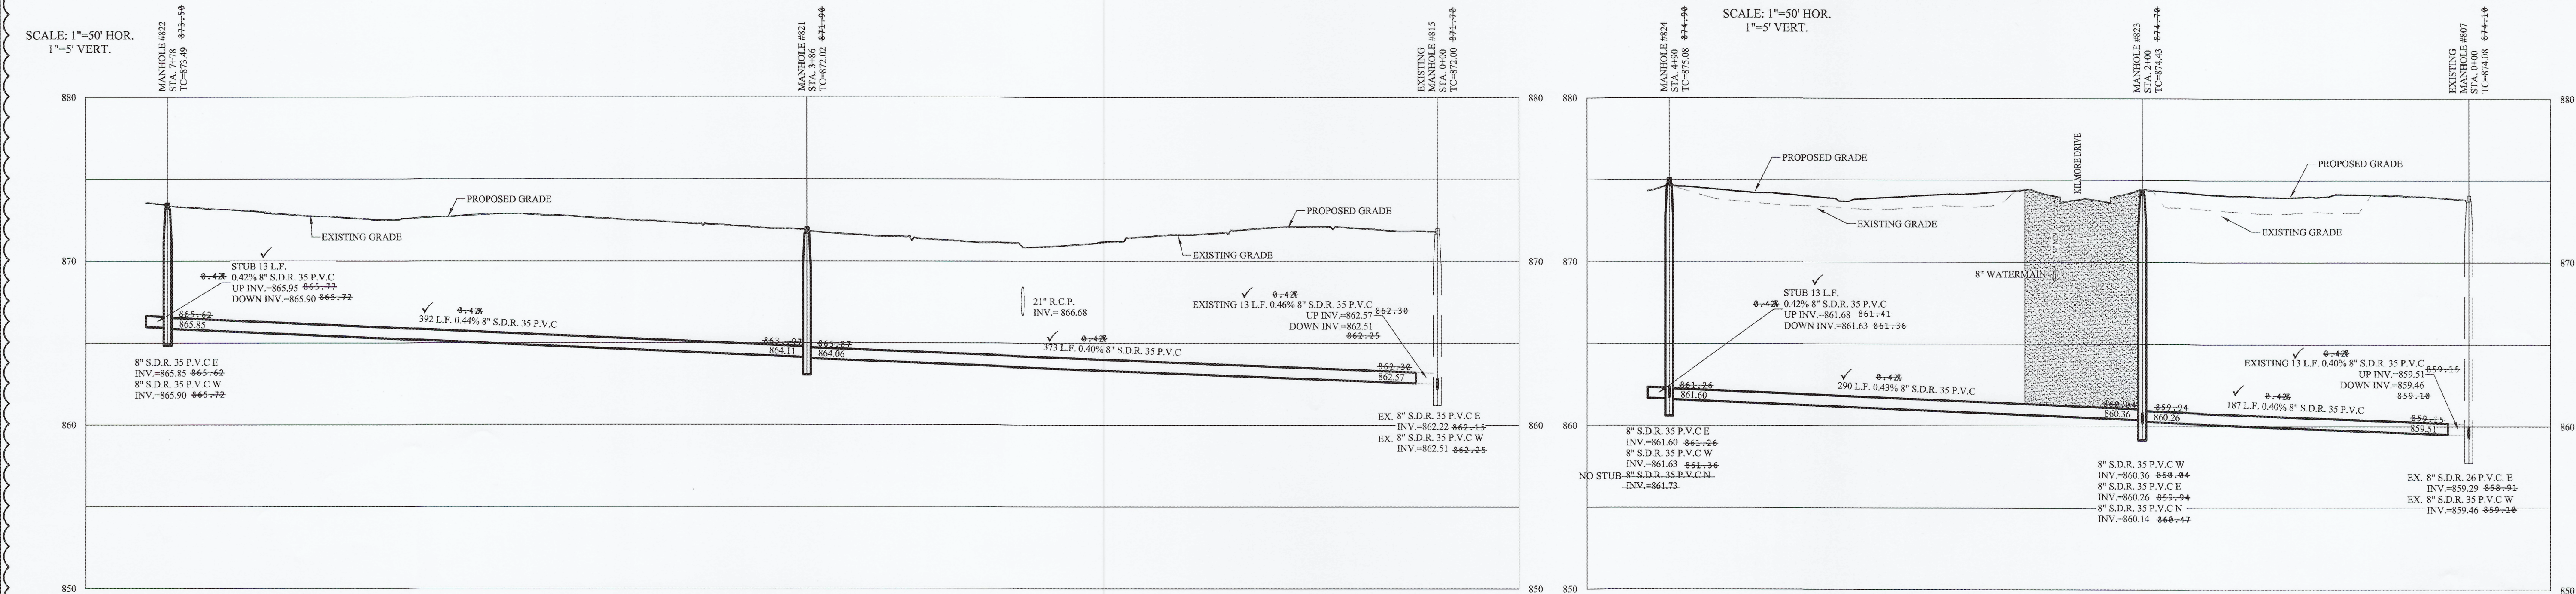

UTILITY CROSSINGS

CONTRACTOR SHALL VERIFY DEPTHS OF ALL EXISTING ON-SITE UTILITIES PRIOR TO CONSTRUCTION TO CONFIRM THERE IS NOT ANY CONFLICTS WITH OTHER UTILITIES, STORM SEWERS OR STREETS. CONFLICTS AFTER CONSTRUCTION BEGINS ARE SOLELY THE CONTRACTOR'S RESPONSIBILITY.

NOTES

ALL LATERALS TO BE INSTALLED WITH #10 GREEN TONE WIRE, STARTING FROM THE MAIN.

ALL MANHOLE INLETS AND OUTLETS NEED TO BE SEALED WITH HYDRAULIC CEMENT, BOTH INSIDE AND OUTSIDE.

RECORD DRAWING

Dennis D. Olmstead
Registered Land Surveyor
No. 900012



STOEPPELWERTH
ALWAYS ON
7945 East 106th Street, Fishers, IN 46038-2505
phone: 317.849.5935 fax: 317.849.5942

SANITARY SEWER PLAN & PROFILES
CARRICK GLEN
SECTION 2
PENDLETON, FALL CREEK TOWNSHIP
MADISON COUNTY, INDIANA

DRAWN BY: AEC
CHECKED BY: KRG
SHEET NO. C500
S & A JOB NO. 84449DRH-S2

THIS DRAWING IS NOT INTENDED TO BE REPRODUCED AS A RETRACTION OF ANY PREVIOUS SURVEY OR A SURVEYOR LOCATION REPORT.

CERTIFIED: 12/09/19
David J. Stoepelwerth
REGISTERED PROFESSIONAL ENGINEER
No. 19358
STATE OF INDIANA

DATE	MARKS	REVISIONS	BY
02/01/21		AS BUILT	MUE
09/01/20		REVISED SAN. INV. AND SAN. TABLE	AEC
08/04/20		ADDED SAN. INV. TO THE NORTH OF ST. 4 AND REVISED SAN. TABLE	AEC
07/15/20		REVISED PER I.D.M. COMMENTS	KRG
01/09/20		REVISED PER COMMENTS	GEM