



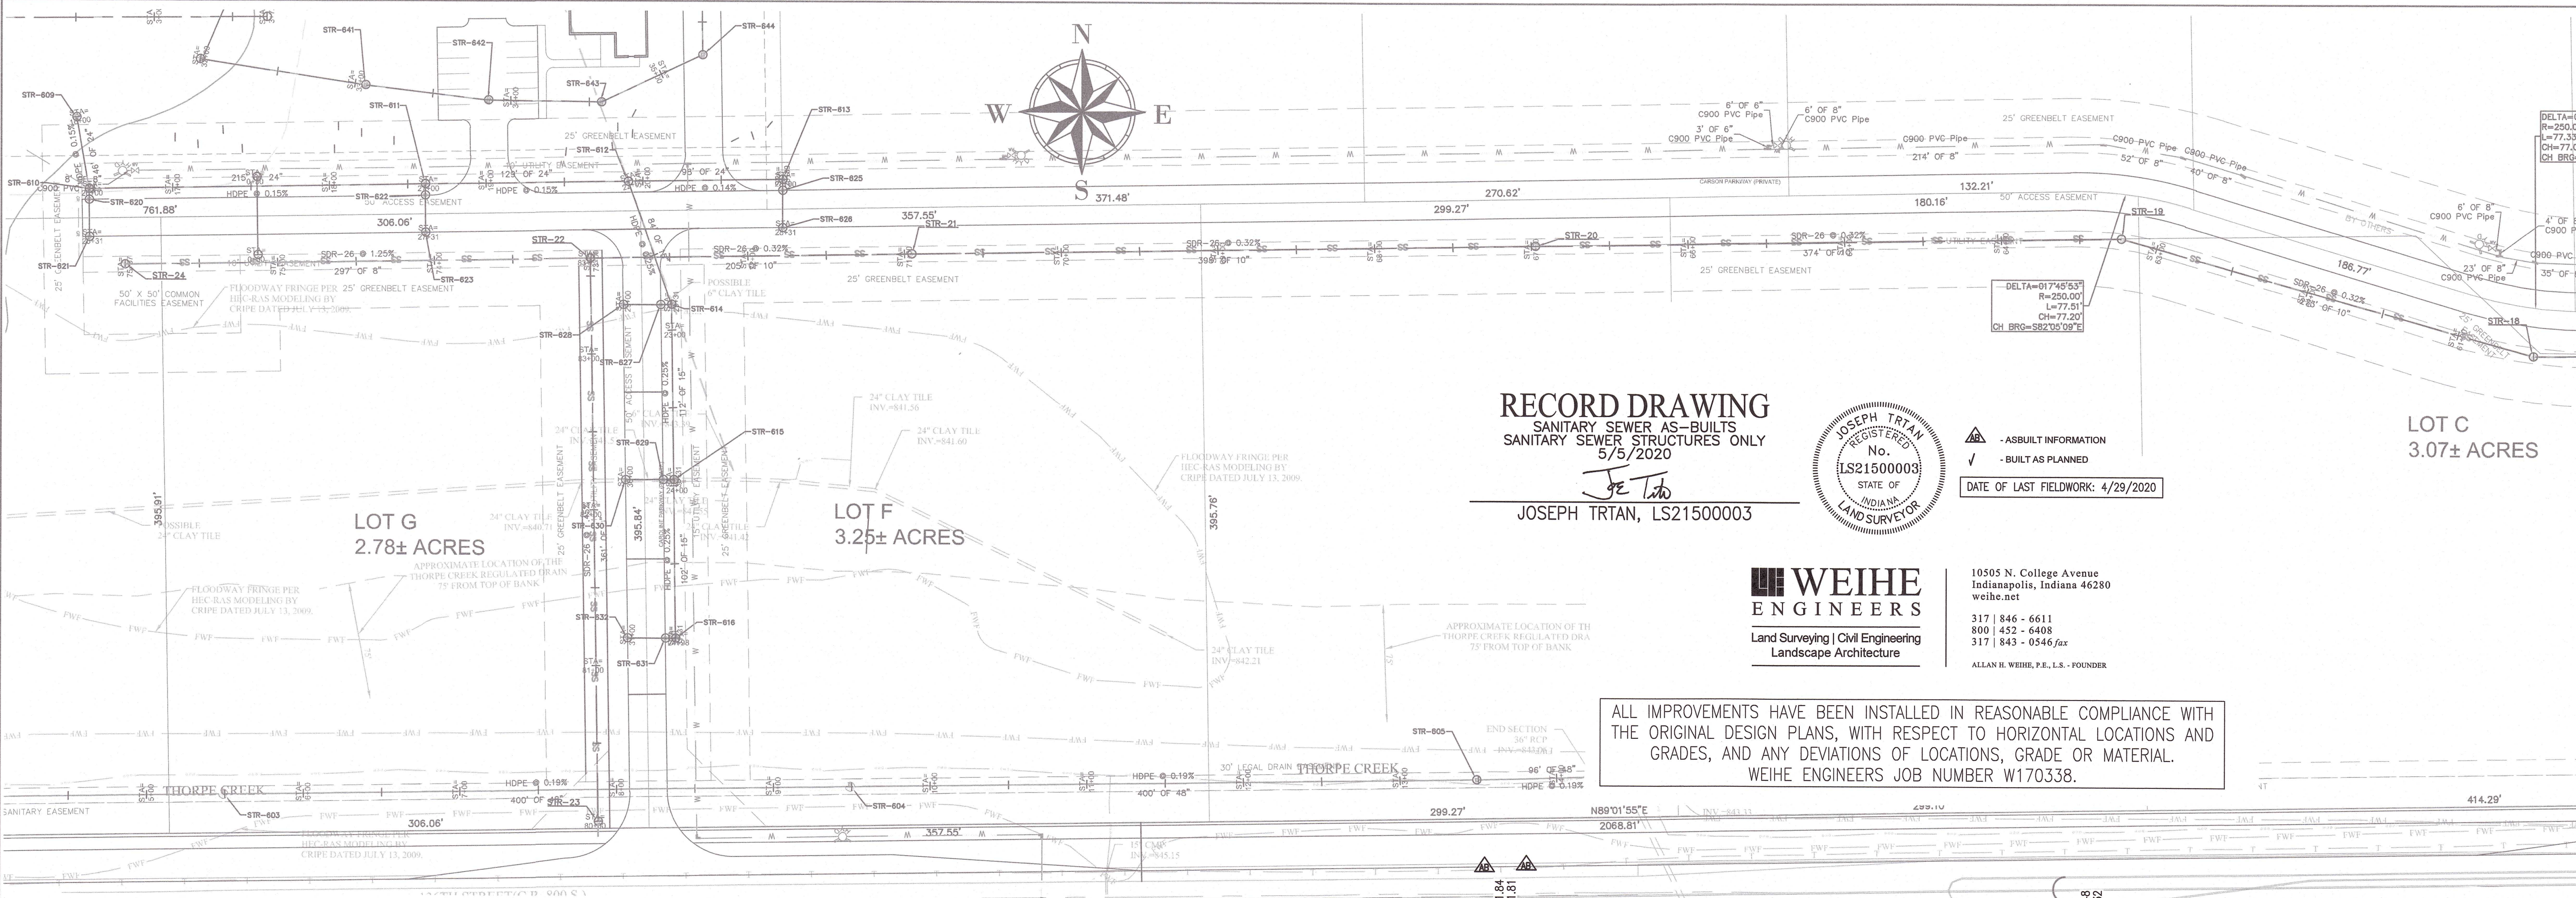

RECORD DRAWING
SANITARY SEWER AS-BUILTS
SANITARY SEWER STRUCTURES ONLY
5/5/2020
Joe Tolo
JOSEPH TRTAN, LS21500003

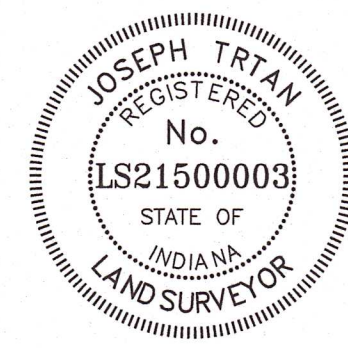


AS-BUILT INFORMATION
BUILT AS PLANNED
DATE OF LAST FIELDWORK: 4/29/2020

WEIHE ENGINEERS
Land Surveying | Civil Engineering
Landscape Architecture

10505 N. College Avenue
Indianapolis, Indiana 46280
weihe.net
317 | 846 - 6611
800 | 432 - 6408
317 | 843 - 0546 fax
ALLAN H. WEIHE, P.E., L.S. - FOUNDER

ALL IMPROVEMENTS HAVE BEEN INSTALLED IN REASONABLE COMPLIANCE WITH THE ORIGINAL DESIGN PLANS, WITH RESPECT TO HORIZONTAL LOCATIONS AND GRADES, AND ANY DEVIATIONS OF LOCATIONS, GRADE OR MATERIAL. WEIHE ENGINEERS JOB NUMBER W170338.

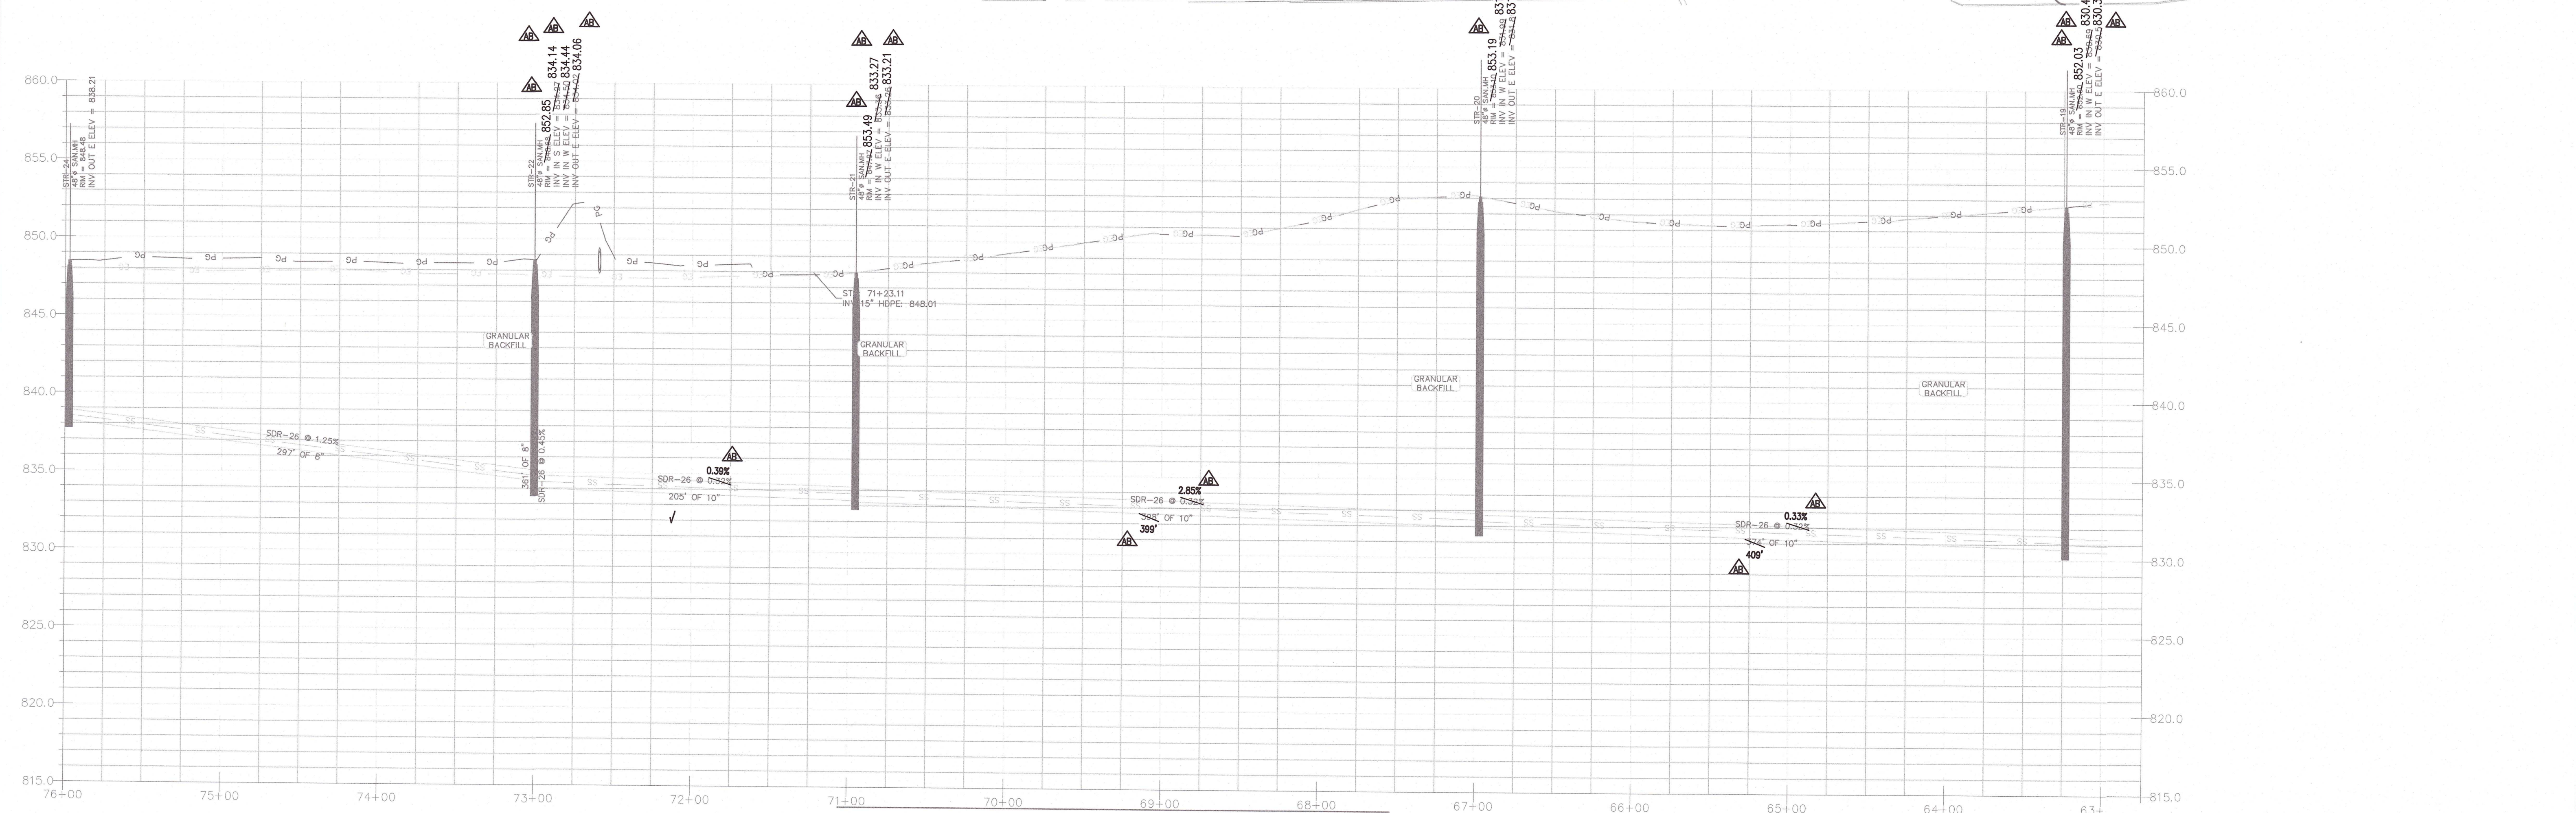


SANITARY PLAN & PROFILE
SCALE: 1" = 50'

REVISIONS		DATE	NO.
1.	03/22/19	REROUTE SANITARY CONNECTION TO LIFT STATION	
2.	04/08/19	ADJUST DEPTH OF SEWER RUN.	

DATE:	SCALE: 1"=50'
DR BY: CDA	CHKD: SDS

SERVIES
ENGINEERING & SURVEYING, LLC
725 NORTHSORE BLVD
ANDERSON INDIANA 46011
(765) 425-4944
servies@comcast.net

DC-CONSTRUCTION SERVICES
INGALLS, INDIANA

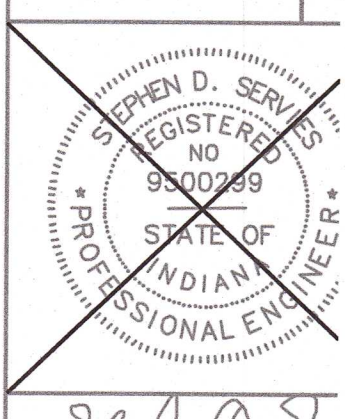

BY: *Stephen D. Servies*
DATE: 06-07-17
SHEET NO C4.4