

+00(4'RT.), STR.NO. 10
LIFT STATION & 110 LFT.
OF 2" FORCE MAIN REQ'D.
CONNECT TO EXISTING
FORCE MAIN (SEE DETAIL
SHEET 5)

BORING REQUIRED UNDER
U.S. 36 (SEE DETAIL
SHEET 5)

APPROXIMATE LOCATION
6" FORCE MAIN

+04(4'LT.), STR.NO. 11
MANHOLE TYPE "A-8" &
354 LFT. OF 8" PIPE
REQ'D.

+64.5(5.65'LT.), STR.NO. 14
MANHOLE TYPE "A-8" &
50 LFT. OF 8" PIPE
REQ'D.
COUNTY ROAD 25 E.

+08.5(4'LT.), STR.NO. 17
CLEANOUT & 300 LFT.
8" PIPE REQ'D.

 
+46(4'LT.), STR.NO. 12
MANHOLE TYPE "A-8" &
50 LFT. OF 8" PIPE
(8" STUB) REQ'D.

+10.5(4'LT.), STR.NO. 13
MANHOLE TYPE "A-8" &
406.50 LFT. OF 8" PIPE
REQ'D.

+08.5(4'LT.), STR.NO. 15
MANHOLE TYPE "A-8" &
148 LFT. OF 8" PIPE
(8" STUB) REQ'D.


+08.5(4'LT.), STR.NO. 16
MANHOLE TYPE "A-8" &
400 LFT. OF 8" PIPE
(8" STUB) REQ'D.

Note: See Revision 1 for
Grade for Structures No. 11 & 10



LEGEND

- SANITARY SEWER
- STORM SEWER
- LEGAL DRAIN
- GRANULAR BACKFILL
- EXISTING CONTOURS
- PROPOSED CONTOURS
- PROPOSED MANHOLE
- PROPOSED LIFT STATION
- FLOW DIRECTION

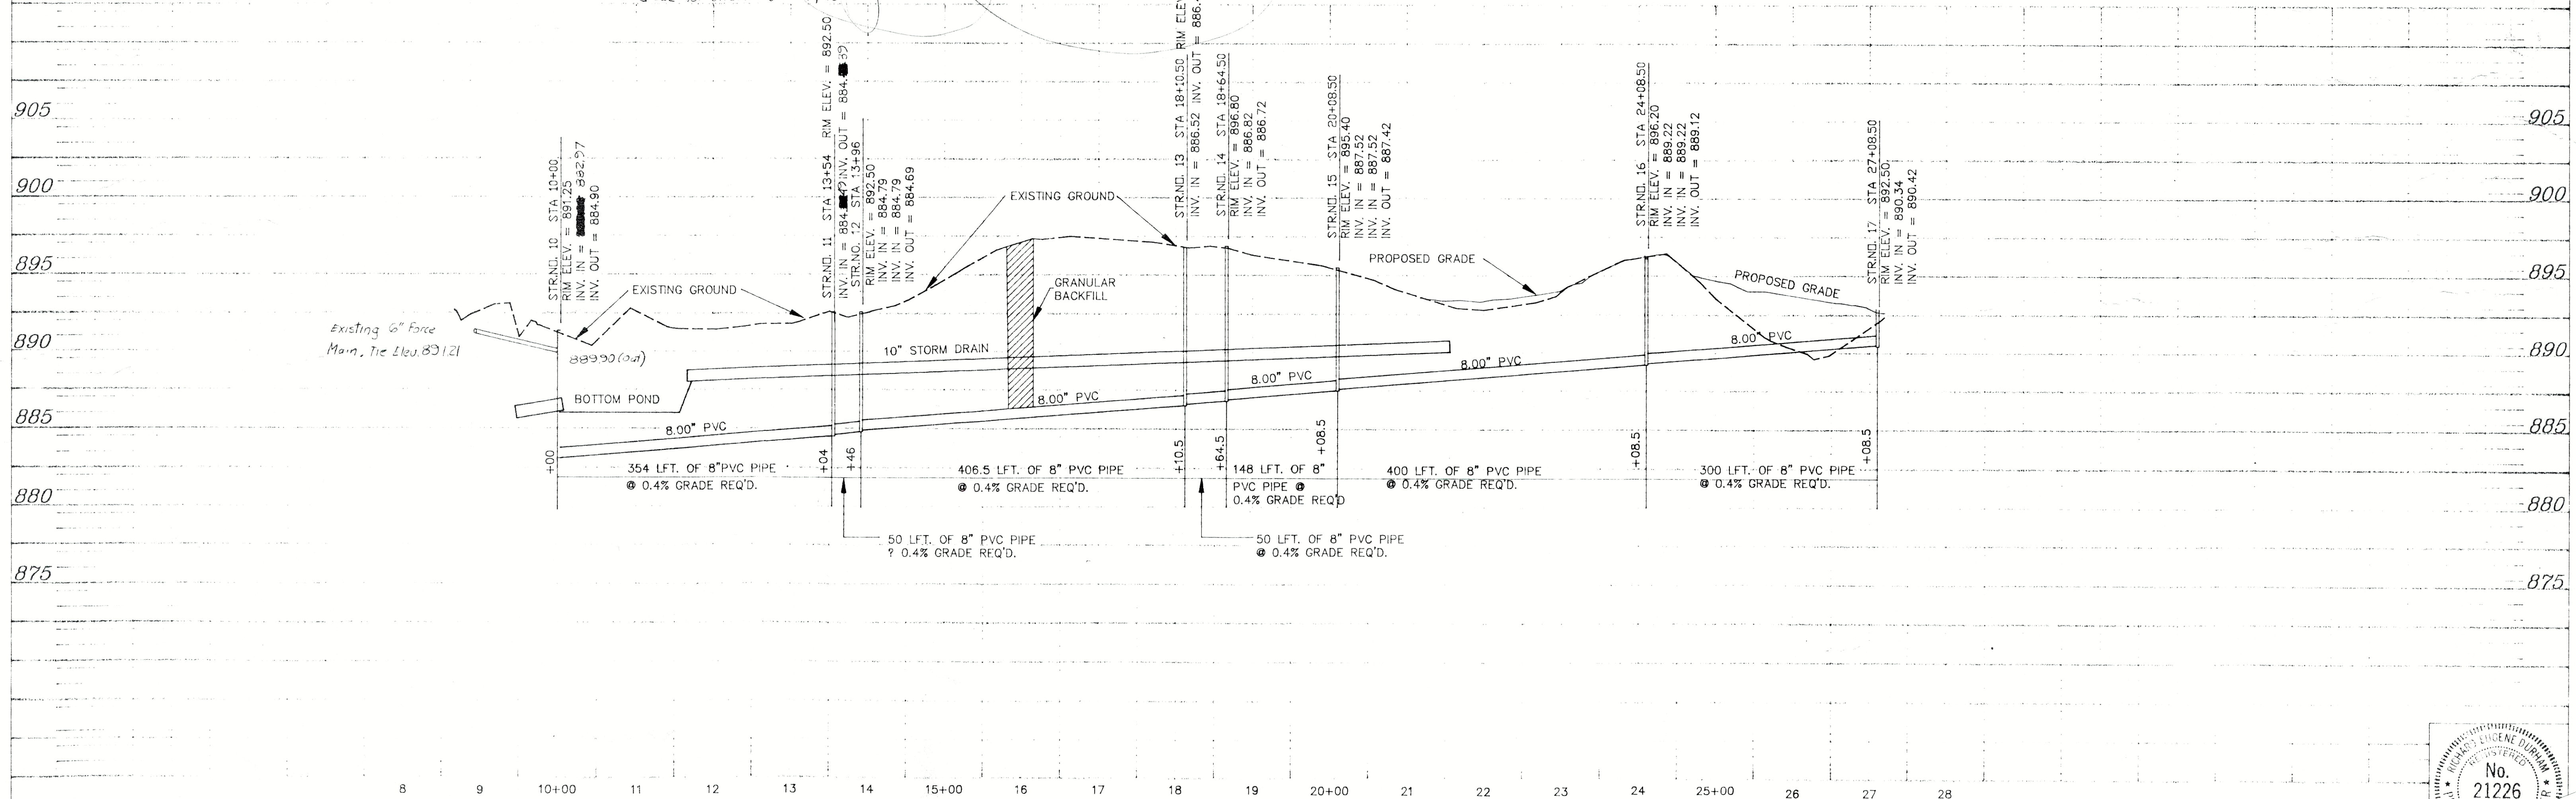

AS BUILTS EAST KNOLL UTILITY PLAN

	1/10/92	JOB NO. 9116	MG
	3/20/92	UTILITY PLAN	MG
①	4-4-92	Grade Revisions str #11 & 10	RED
	2-4-92	AS BUILTS	MG
NO.	DATE	DESCRIPTION	BY

DURHAM Engineering
12 W. 8th STREET ANDERSON, INDIANA
(317)644-3833

SCALE HOR 1"=100'
VER 1"=5'

SHEET NO. 4 of 6

