



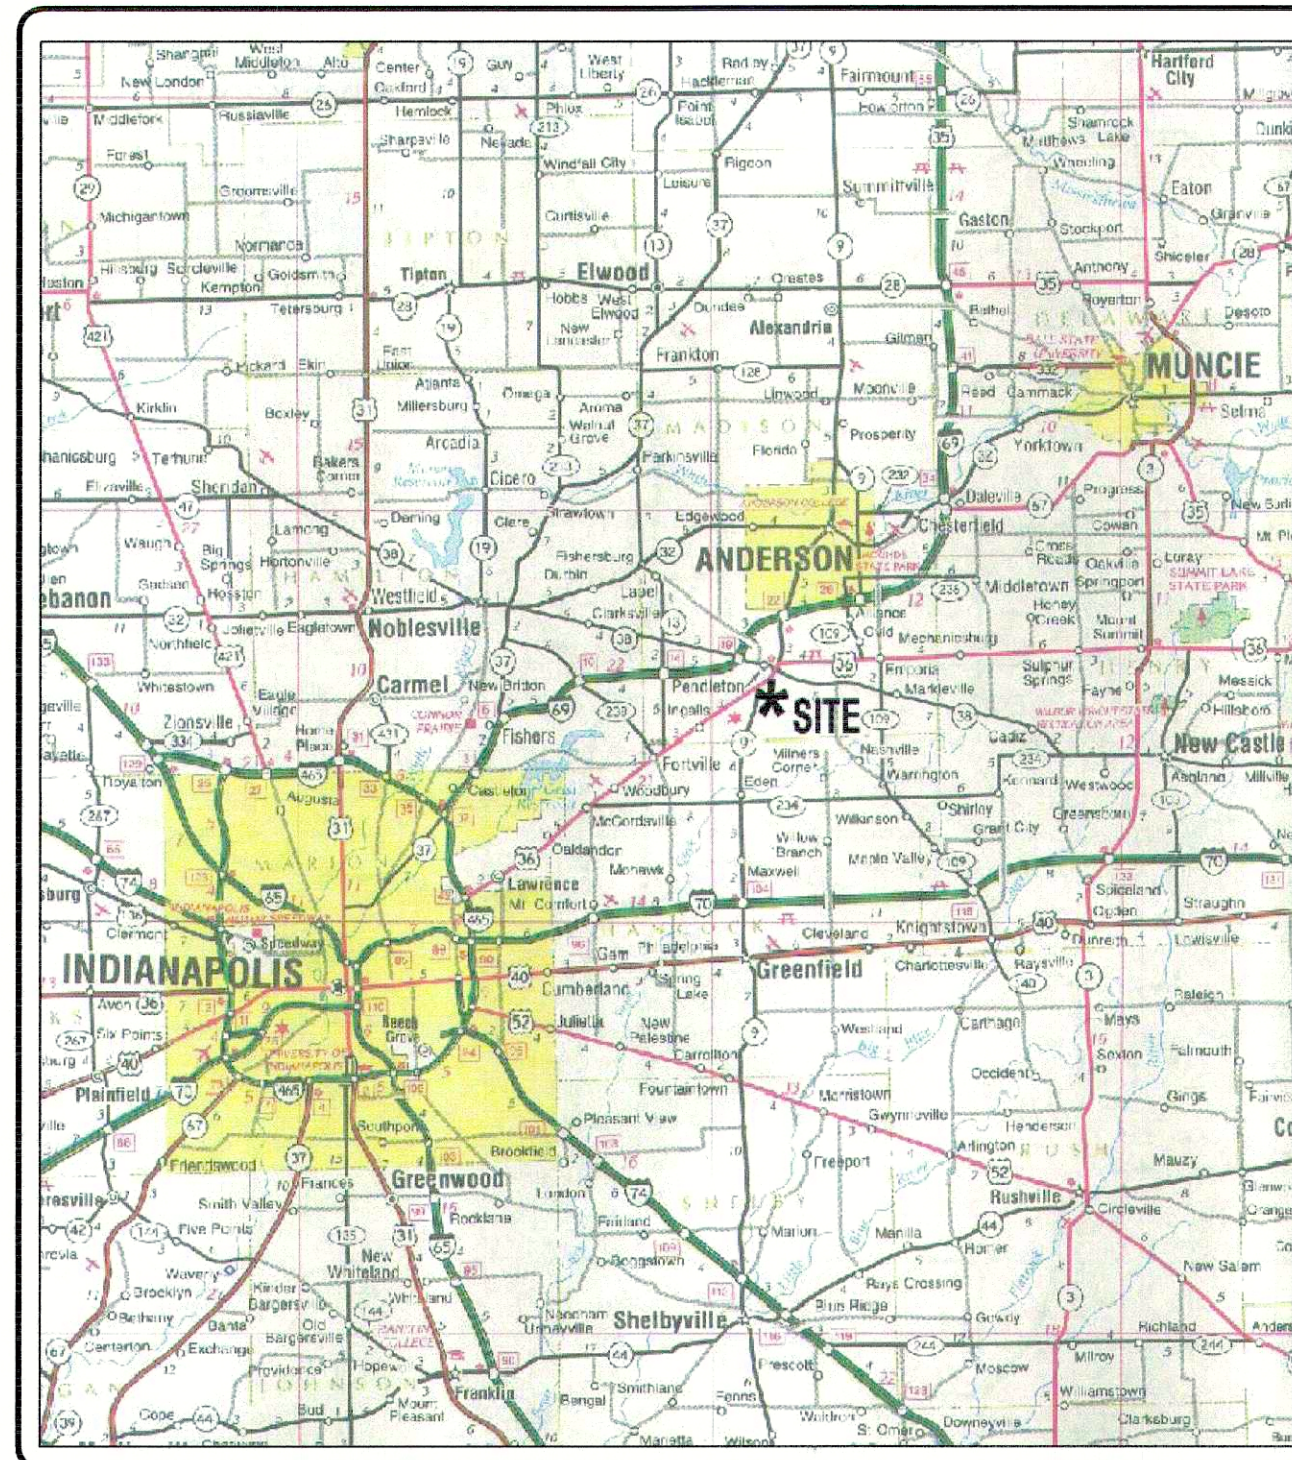

Location Map
State of Indiana Highway Map

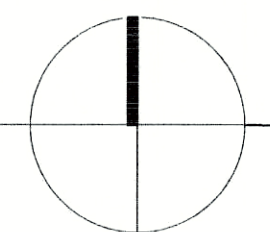

INDEX OF DRAWINGS	
Sheet No.	Description
1	Title Sheet
2	Standard-Specifications
3	Grading Plan
4	Street Plan-Profile, Line "HBLvd"
5	Street Plan-Profile, Line "CSDr", "FGLn"
6	Intersection Details-Profile, Line "SSD"
7	Sanitary Plan-Profile, Line "SSD"
8	Sanitary Plan-Profile, Line "SSD" and "SS"
9	Storm Drainage Plan-Profile, Structure Series 100, 500
10	Storm Drainage Plan-Profile, Structure Series 200, 300
11	Waterline Plan
12	Standard-Details-Street / Waterline
13	Standard-Details-Drainage
14	Standard-Details-Sanitary
15	Erosion Control-Plan-1
16	Erosion Control-Details
Waterline Plan Contractors Notes	



REVISIONS		
Sheet #	Date	Description
3-11, 15	8/10/04	Revised per comments of client, remove pond, modify storm system (Strs Series 100-300).
3-11, 15	5/16/05	Revised per comments of client to remove pond, add storm system Series 700.
3-11, 15	5/19/05	Revised per client for new pond limits, connecting pipe between ponds.
3-11, 15	9/23/05	Revised per client for lot numbers, lot line adjust.

NOTES:

1. The construction standards for the Town of Pendleton (for streets, storm sewers and waterline) and Fall Creek Regional Waste District (for sanitary sewers) shall be used for all parts of this project.


Asbuilt Plans FarmGate, Section 1 Huntzinger Farms PUD

Part of the Northwest & Southwest 1/4s, Section 28, Southeast & Northeast 1/4s,
Section 29, Township 18 North, Range 7 East
Town of Pendleton, Fall Creek Township, Madison County, Indiana

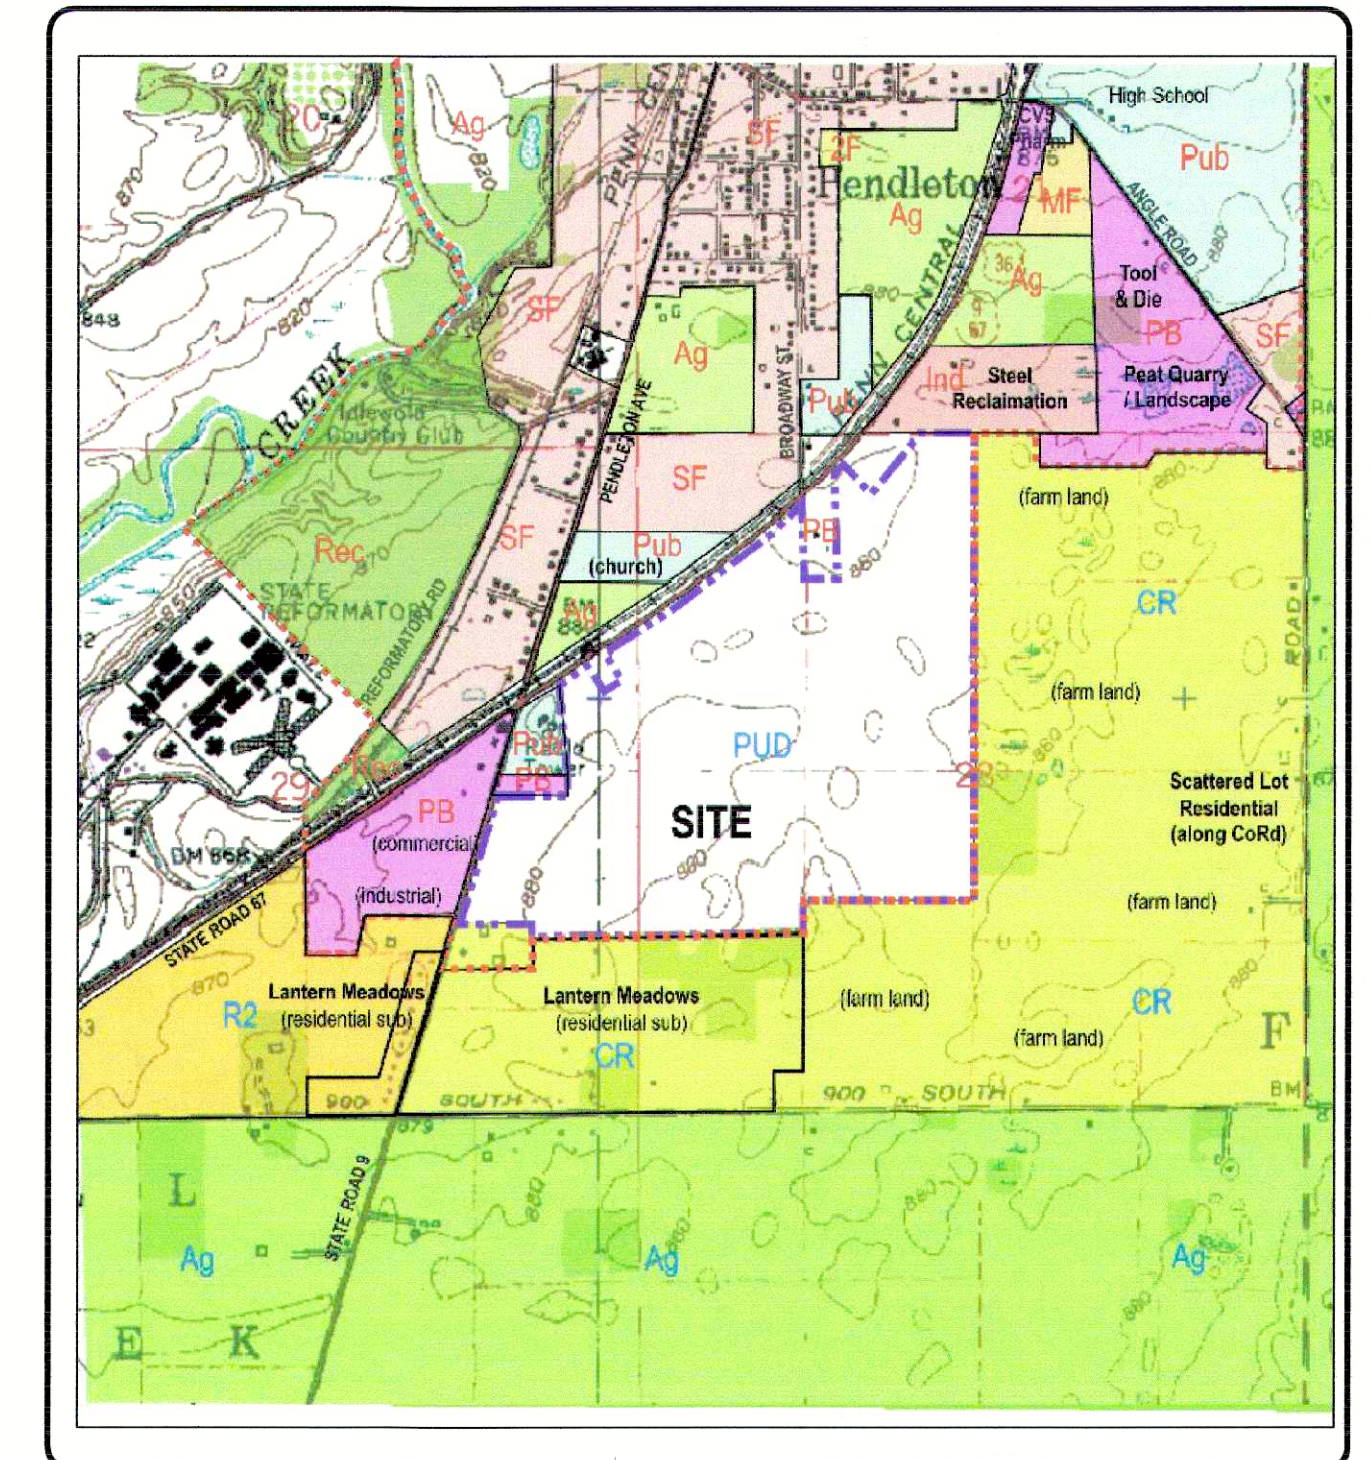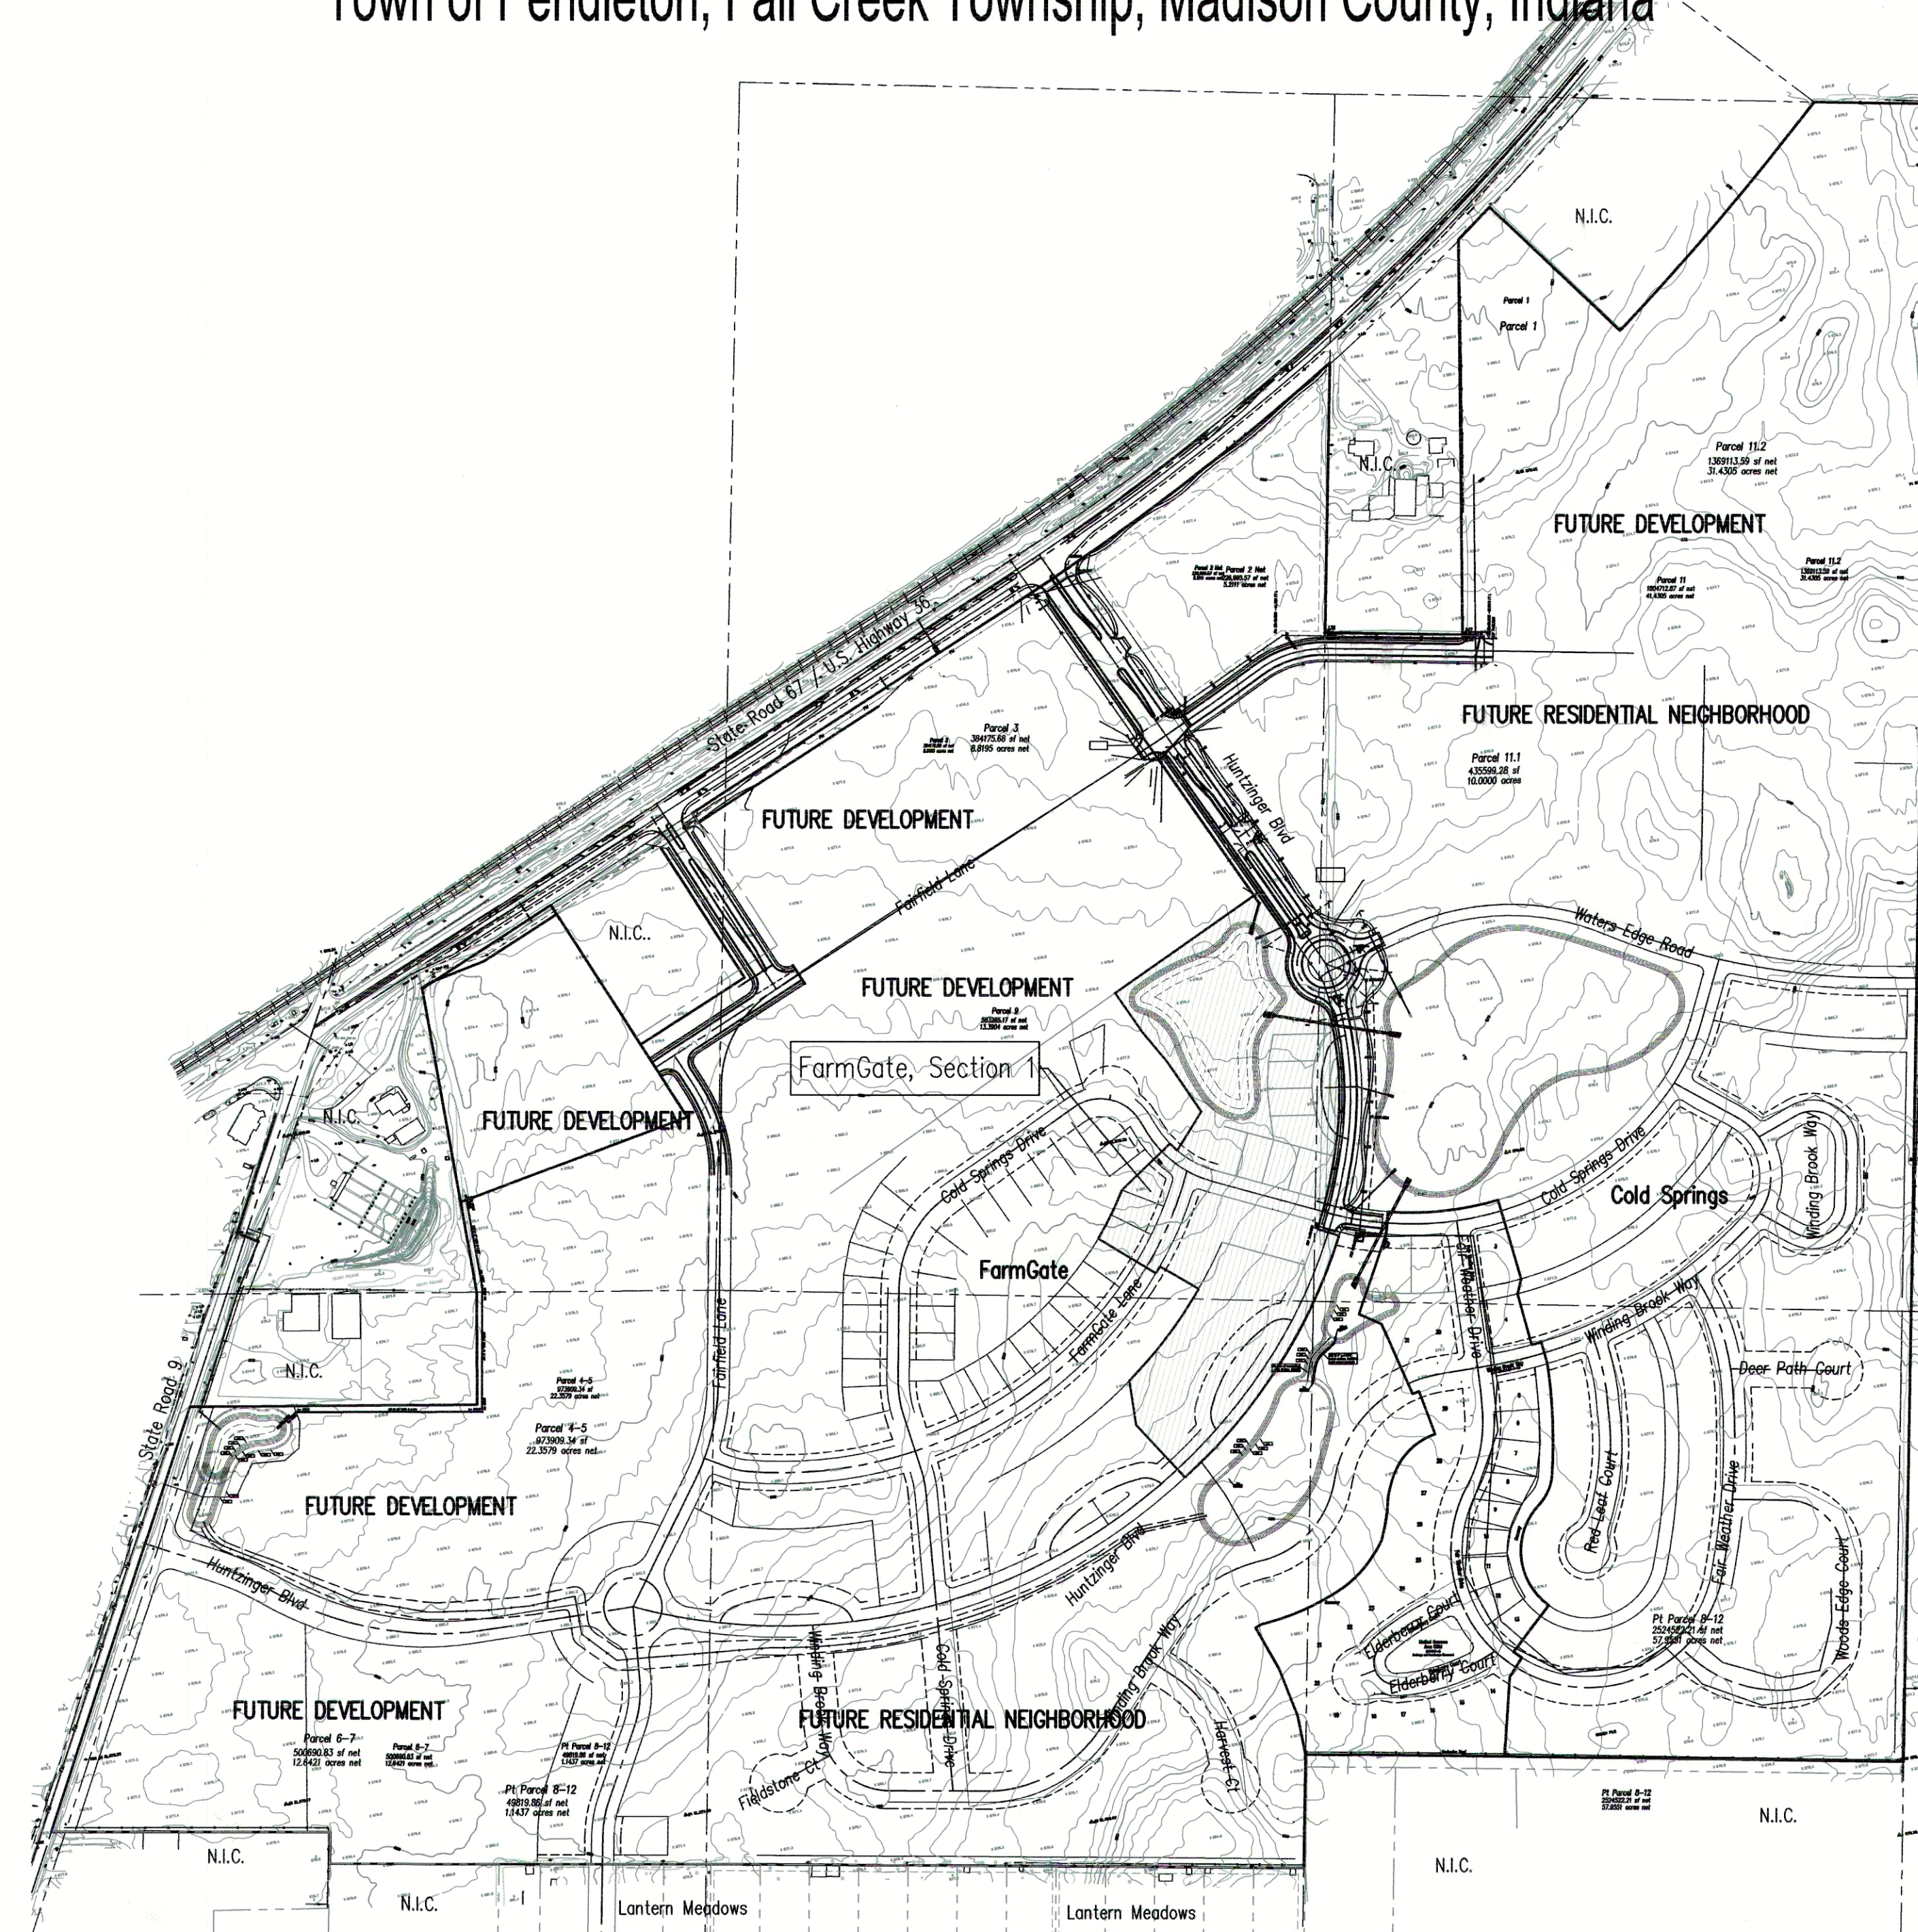

Area Map

USGS Quadrangle Maps:
Anderson North / Gilman / Middletown / Anderson South

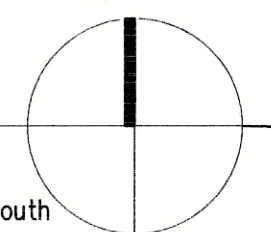

Project Data

Dedicated Street Lengths	
Huntzinger Blvd (Line "HBLvd"):	646.28 lft
FarmGate Lane (Line "FGLn"):	233.46 lft
Cold Springs Drive (Line "CSDr"):	401.22 lft
Cul-de-loop 1 (Line "CDL1"):	279.60 lft
Cul-de-loop 2 (Line "CDL2"):	336.78 lft
Total:	1,897.34 lft

prepared for: **Pendleton Land Company, LLC**
9449 Priority Way West Drive
Suite 120
Indianapolis, Indiana 46240
Tel: 317.705.2063
Fax: 317.705.2069

prepared by:

Pendleton Consulting

P.O.Box 67 Pendleton, Indiana 46064
Phone (765) 778-4540 Fax 765-778-3571 email pendcon@netdirect.net

certified by:

Stephen E. Bourquein
Indiana Registered Professional Land Surveyor #S0441

