

Denotes approximate limits of granular backfill. Refer to respective specifications for exact limits and acceptable backfill materials.


NOTES:

1. Maintain a minimum of 18" of vertical separation per IDEM requirements.
2. Laterals are to be extended to the lot side edge of the utility easement.


'HBlvd' denotes Huntzinger Blvd
'CSDr' denotes Cold Springs Drive
'FGLn' denotes FarmGate Lane
'SSC' denotes Sanitary Sewer Line "C"
'SSH' denotes Sanitary Sewer Line "H"
'SSI' denotes Sanitary Sewer Line "I"

Scale:
Hor: 1"=50'
Ver: 1"=5'

Line "SSI"

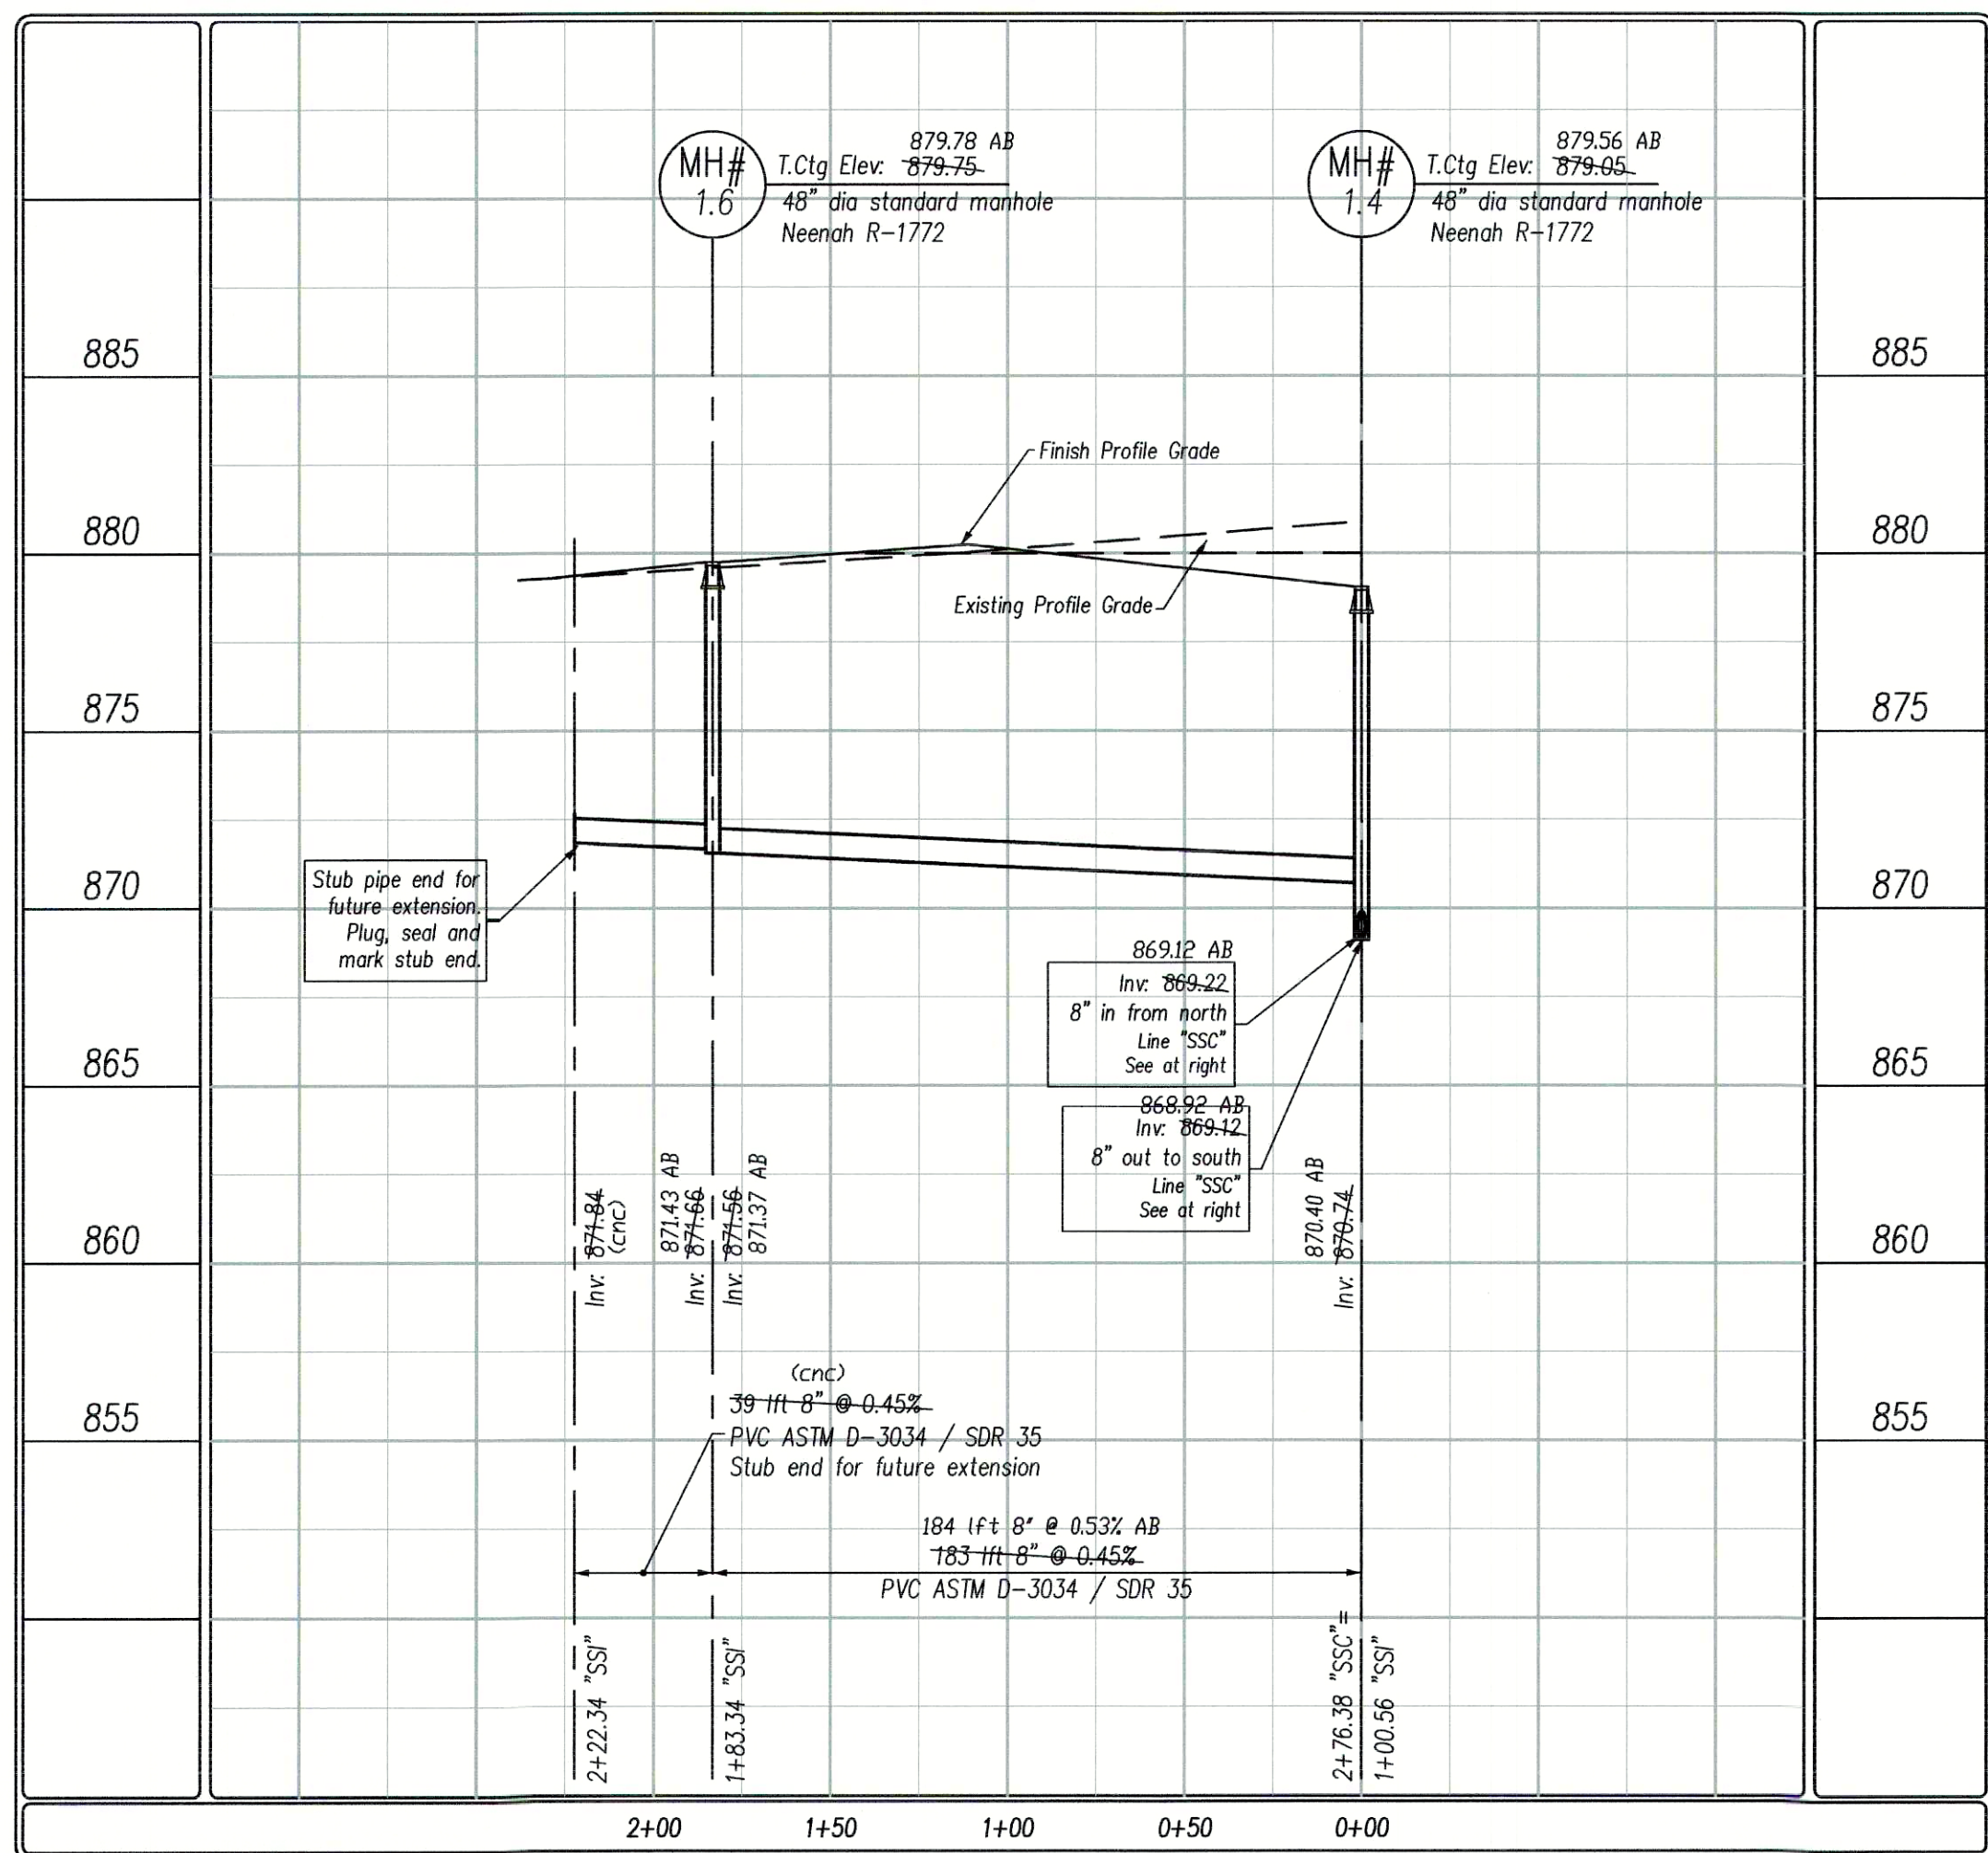

Line "SSC"

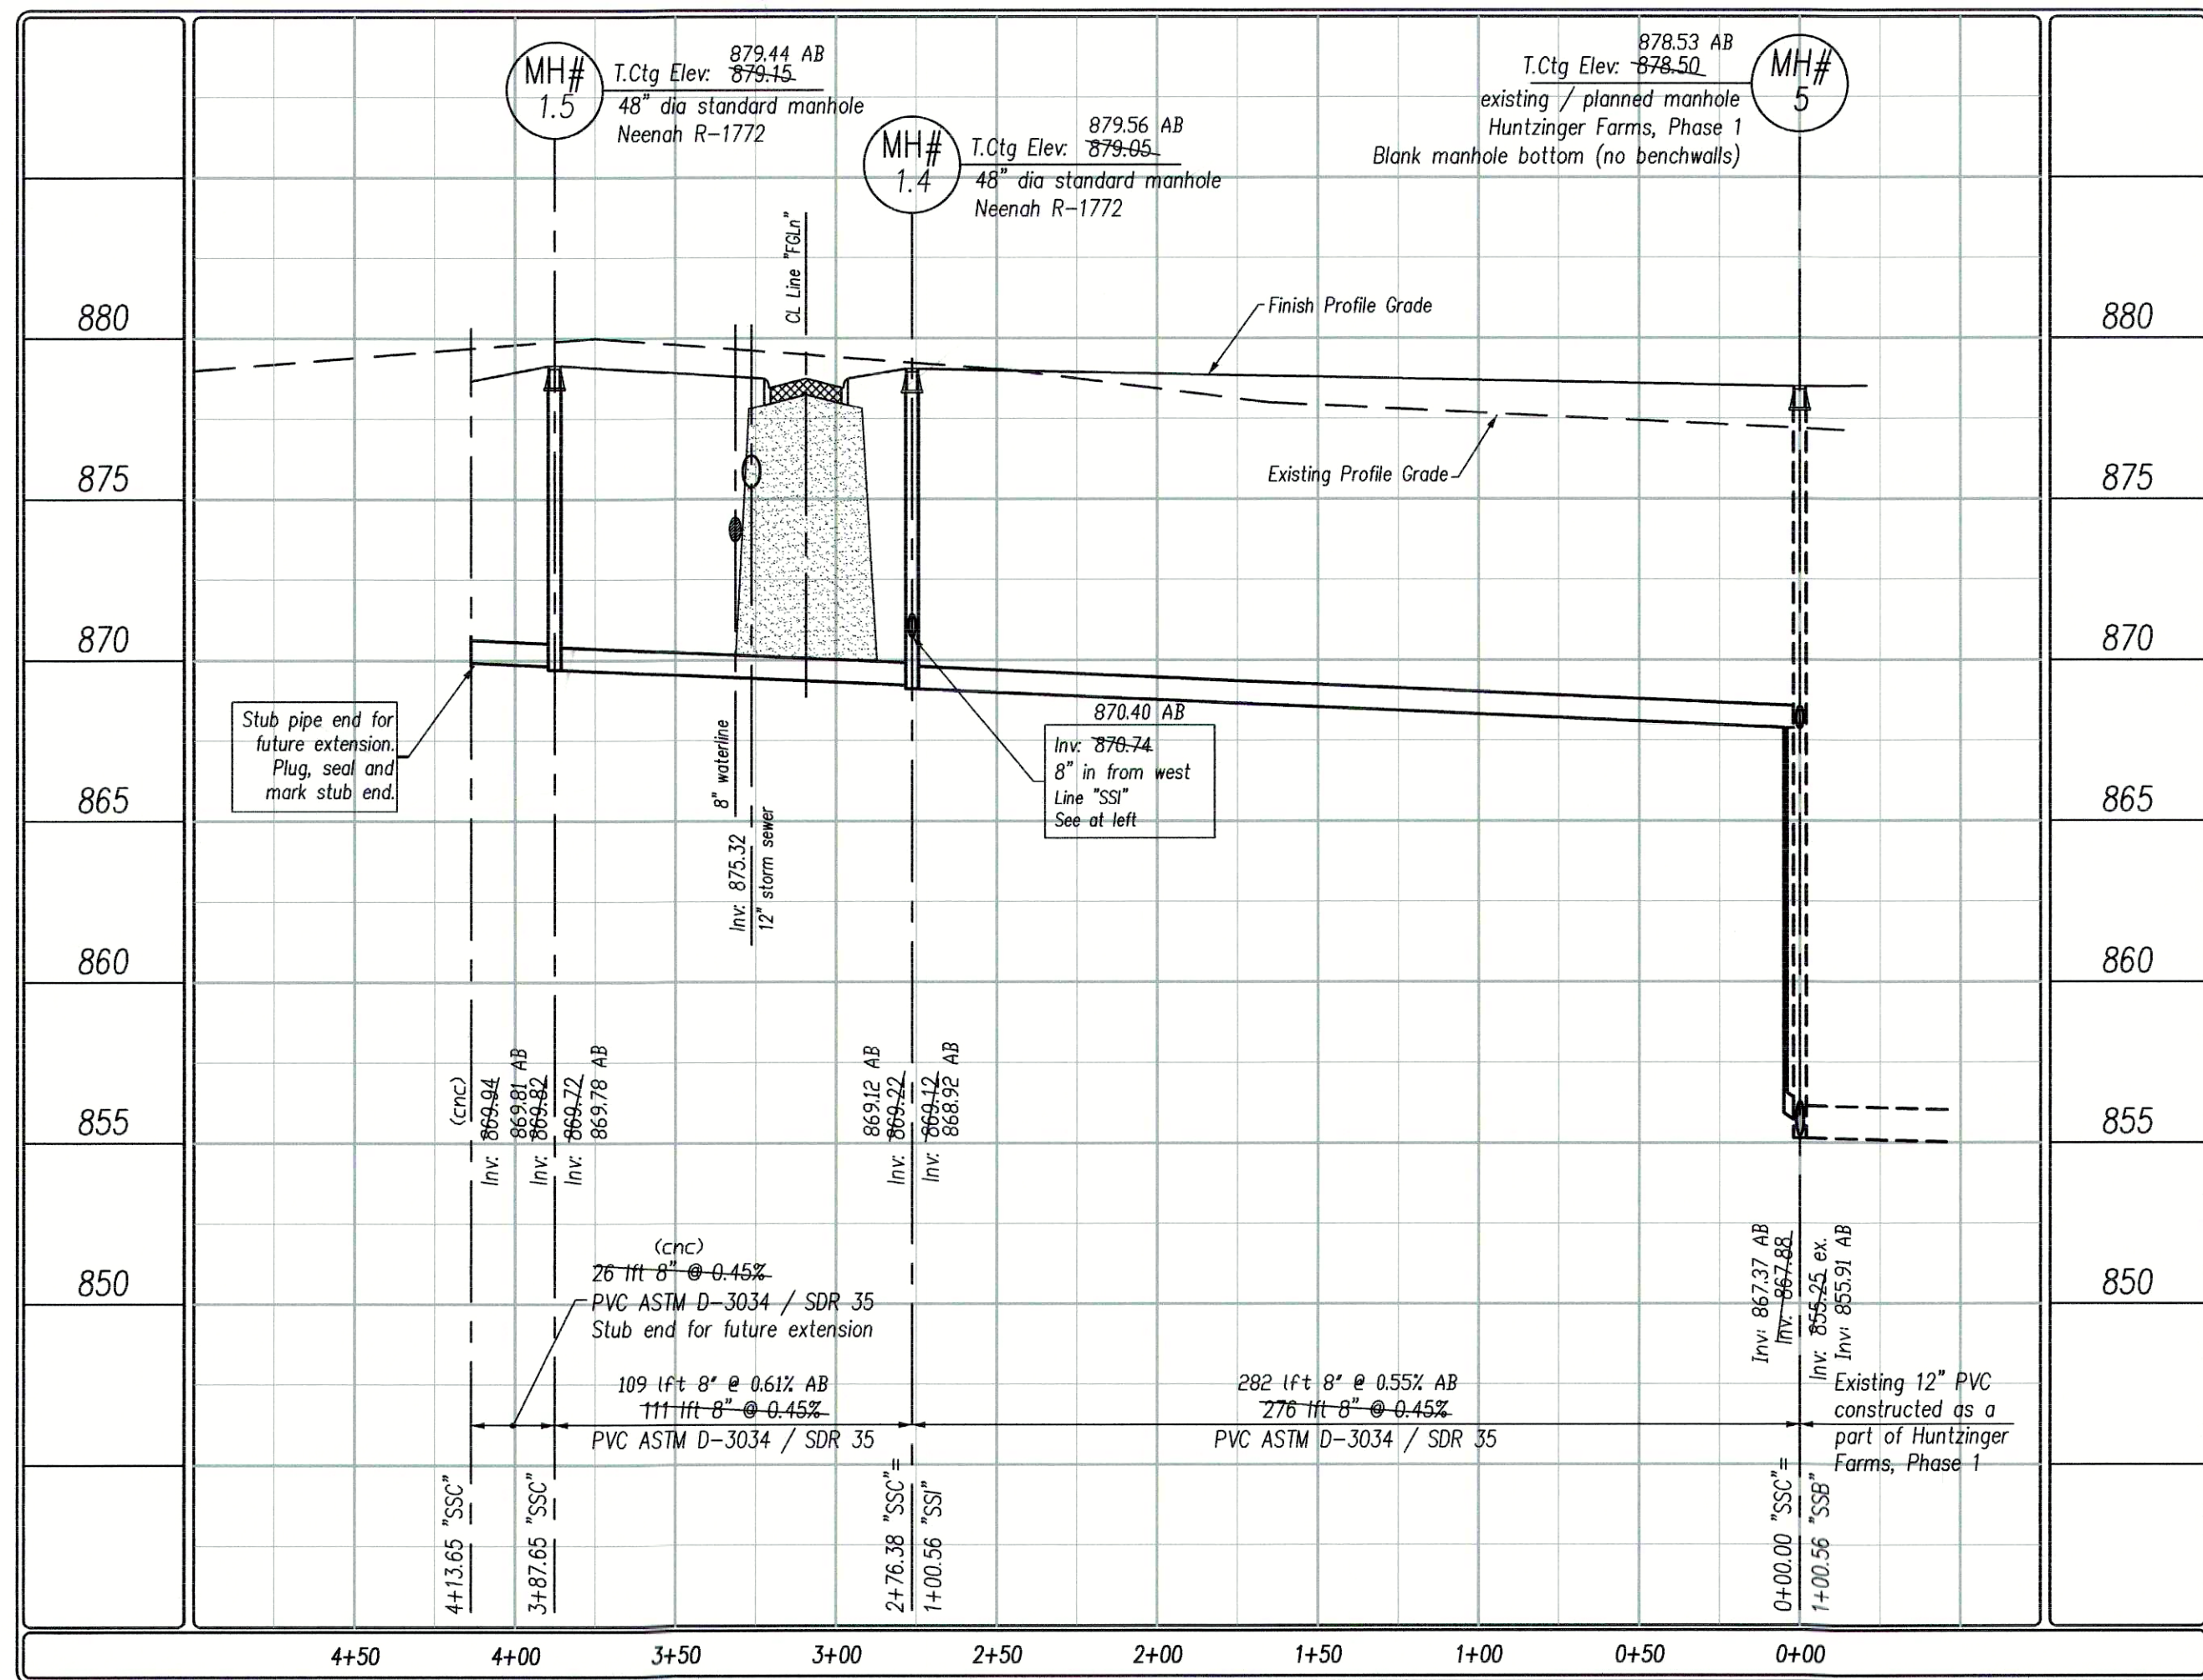

PER INDIANA STATE LAW IS-69-1991, IT IS AGAINST THE LAW TO EXCAVATE WITHOUT NOTIFYING THE UNDERGROUND LOCATION SERVICE TWO (2) WORKING DAYS BEFORE COMMENCING WORK.

WITHIN INDIANA: 1-800-382-5544
FROM OUTSIDE INDIANA: 1-800-428-5200


ELECTRIC RED
GAS-OIL YELLOW
COMMUNICATIONS ORANGE
WATER BLUE
SEWER GREEN
PROPOSED WHITE

THE INFORMATION NEEDED WHEN CALLING INDIANA UNDERGROUND PLANT PROTECTION SERVICES, INC. IS AS FOLLOWS:

COUNTY AND TOWNSHIP
STREET ADDRESS
TYPE OF WORK
EXTENT OF WORK
NAME OF CALLER AND TITLE
PHONE NUMBER
BEST TIME TO CALL
START DATE AND START TIME
CONTRACTOR NAME AND ADDRESS

AS-BUILT NOTES:

- X SANLAT denotes field location of sanitary lateral markers
- X SANMHCSXX denotes field location of a manhole in Cold Springs XX denotes the manhole number
- As-built locations of the sanitary lateral tees are denoted as distances from the downstream manhole, in line with the next upstream manhole.
- X WV denotes field location of water valve.
- X BDV denotes field location of blow-off valve
- X FH denotes field location of Fire Hydrant
- See As-built Plan notes from contractor for measured locations of tees, ells, valves, hydrants and other fittings from street centerline intersections.
- X STCSSxxx denotes field location of storm structure in Cold Springs xxx denotes the structure number.
- (cnc) denotes "could not confirm"

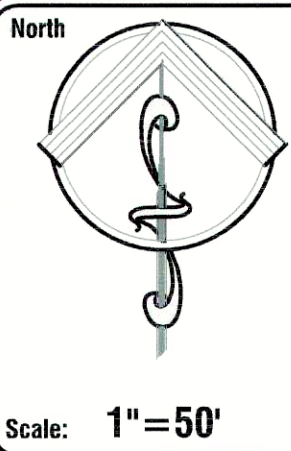

North

Scale: 1"=50'

Pendleton Consulting
P.O. Box 67 Pendleton, Indiana 46064
Phone: 765-776-4540
email: pendcon@earthlink.net

Pendleton Land Company, LLC
9449 Priority Way, West Drive
Suite 120
Indianapolis, Indiana 46240
Tel: 317.705.2063
Fax: 317.705.2069

Date: 7/31/04

Revised per comments of client, remove pond, modify storm system (Srs Series 100-300).
Revised per client lot lines / numbering.

Project: FarmGate at Huntzinger Farms
Section 1
Pendleton, Madison County, Indiana
Sheet Title: Sanitary Plan - Profile
Lines "SSC" - "SSI"



Sheet No.

8

17 Sheets

As-built Plans