

Denotes approximate limits of granular backfill. (Refer to respective specifications for exact limits and acceptable backfill materials).

NOTES:

1. Maintain a minimum of 18" of vertical separation per IDEM requirements.
2. Laterals are to be extended to the lot side edge of the utility easement.

"HBlvd" denotes Huntzinger Blvd
"CSDr" denotes Cold Springs Drive
"FGLn" denotes FarmGate Lane
"SSC" denotes Sanitary Sewer Line "C"
"SSB" denotes Sanitary Sewer Line "B"
"SSI" denotes Sanitary Sewer Line "I"

AS-BUILT NOTES:

X SANLAT denotes field location of sanitary lateral markers
X SANMHCSXX denotes field location of a manhole in Cold Springs XX denotes the manhole number

As-built locations of the sanitary lateral tees are denoted as distances from the downstream manhole, in line with the next upstream manhole.

X WV denotes field location of water valve.

X BOV denotes field location of blow-off valve


X FH denotes field location of Fire Hydrant

See As-built Plan notes from contractor for measured locations of tees, ells, valves, hydrants and other fittings from street centerline intersections.


X STCSXXX denotes field location of storm structure in Cold Springs xxx denotes the structure number.

(cnc) denotes "could not confirm"


Structure Series 100

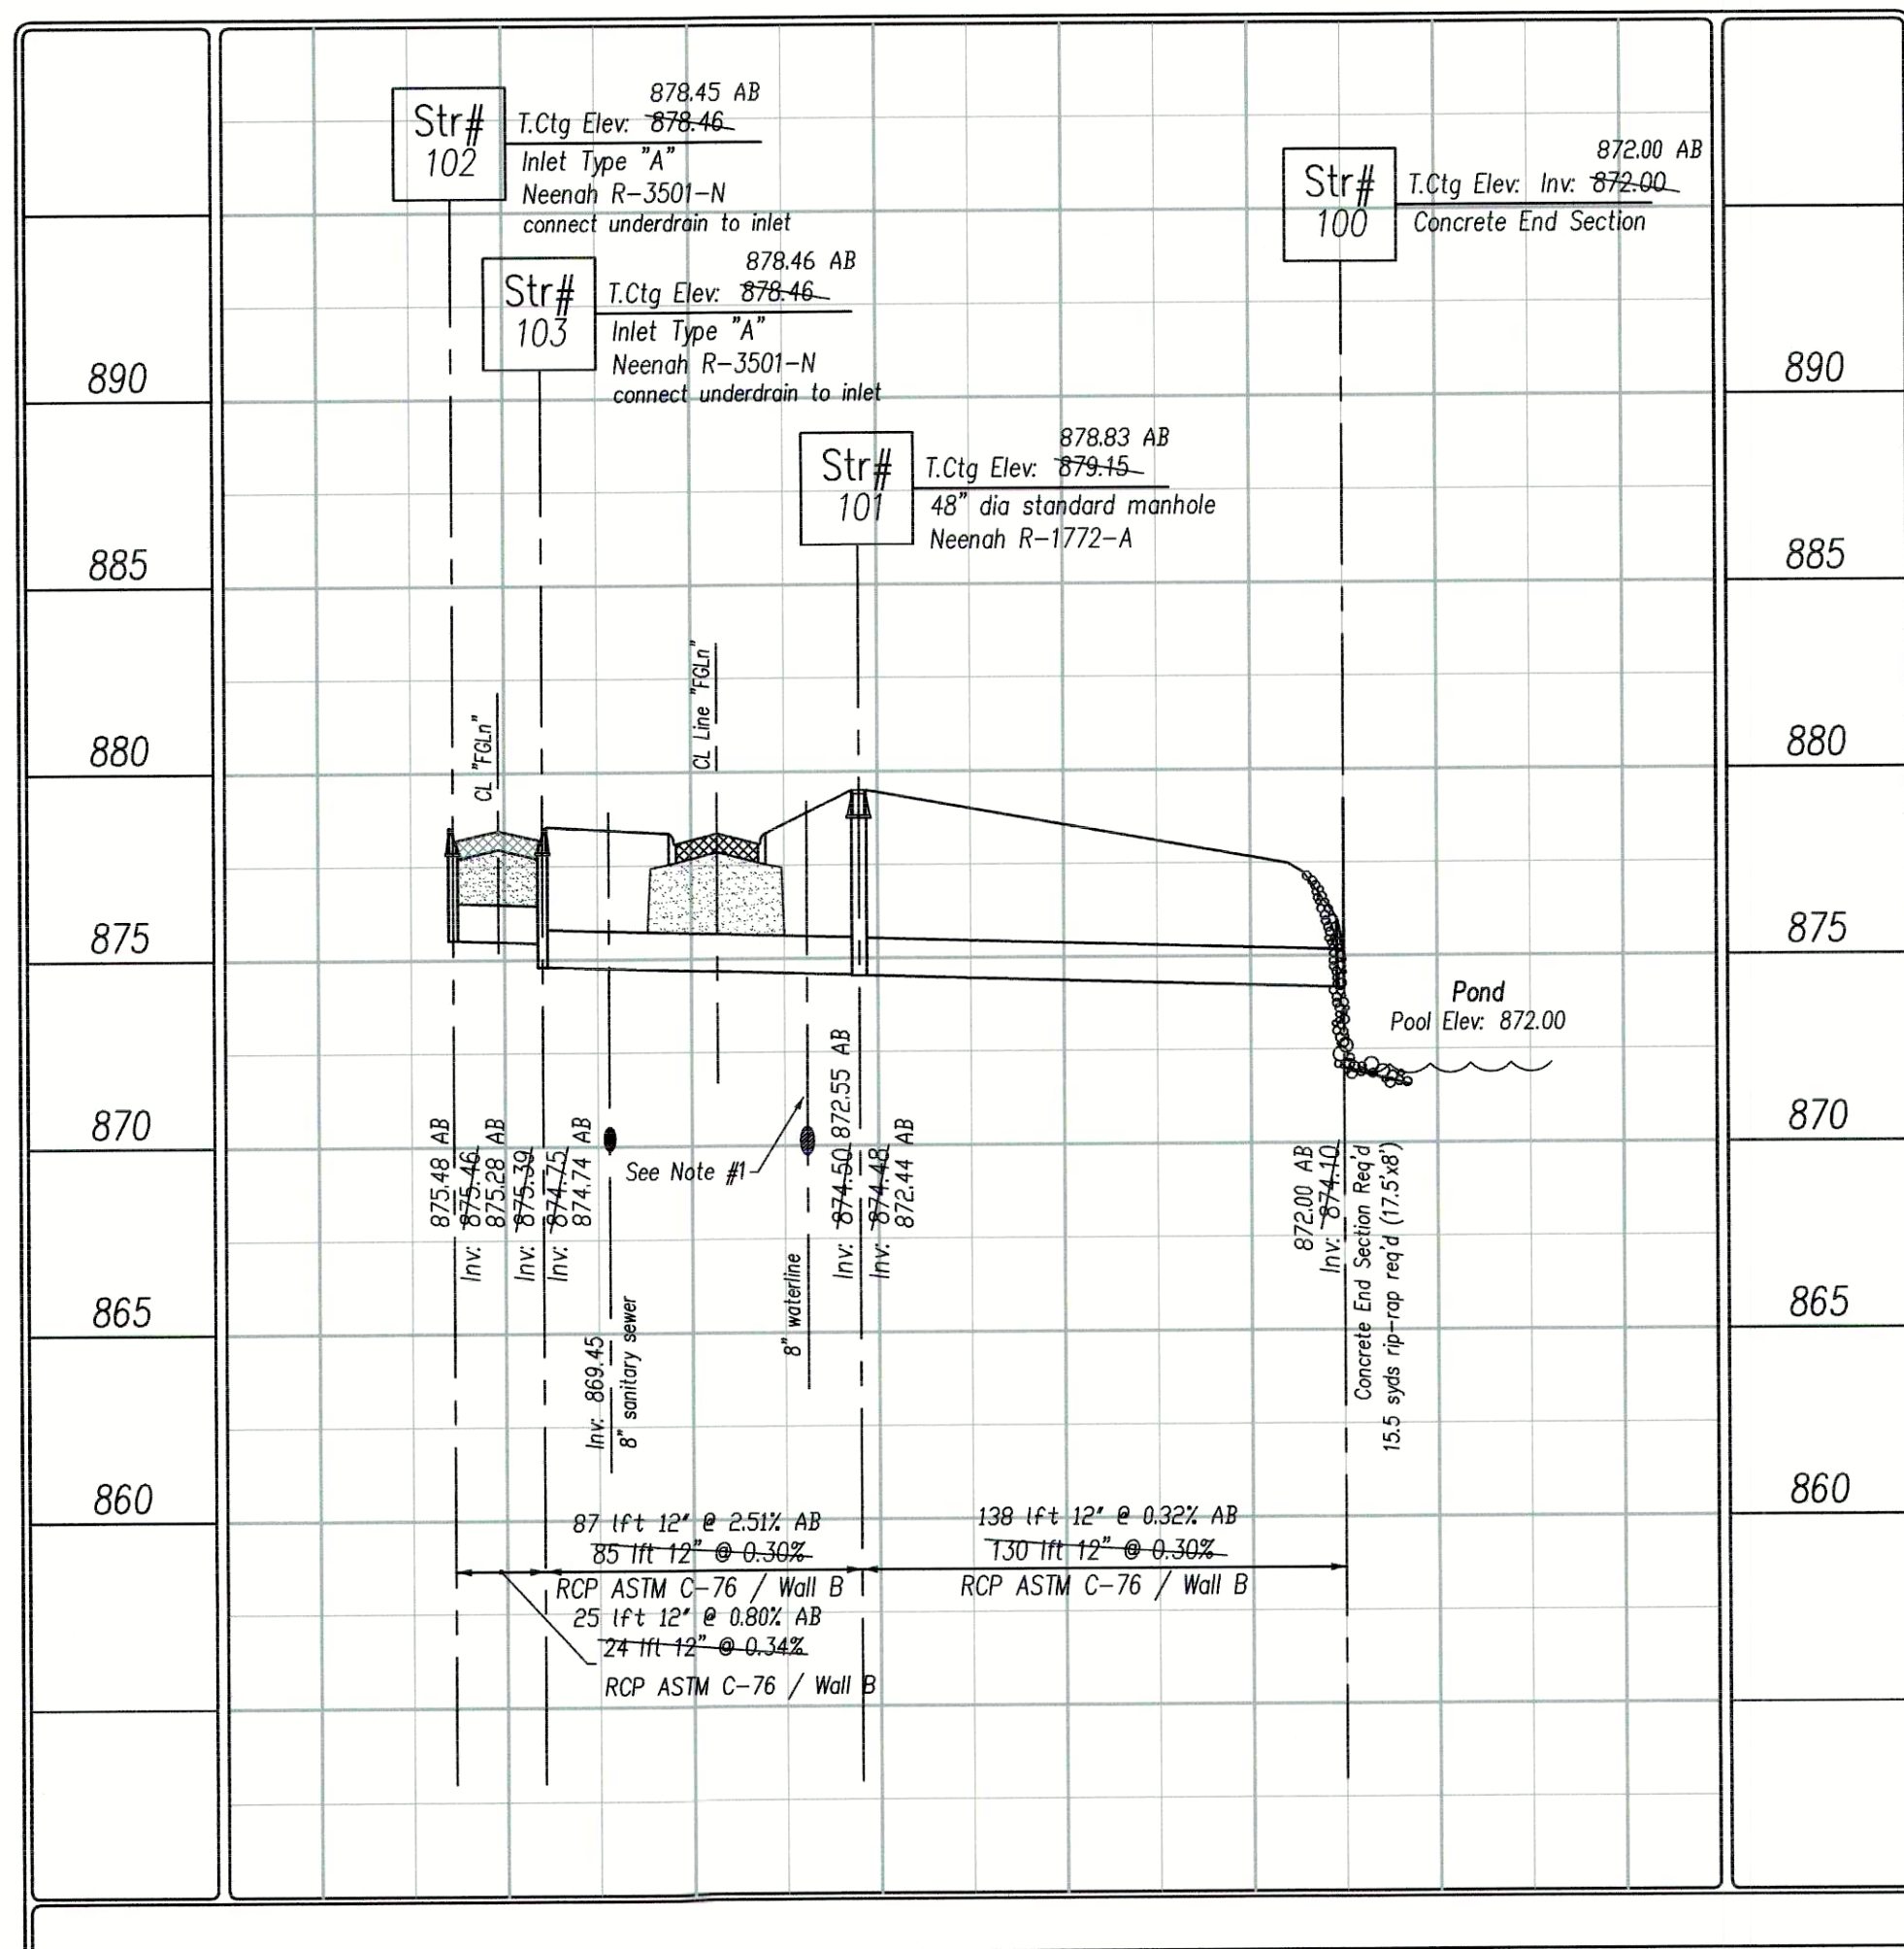

Structure Series 700

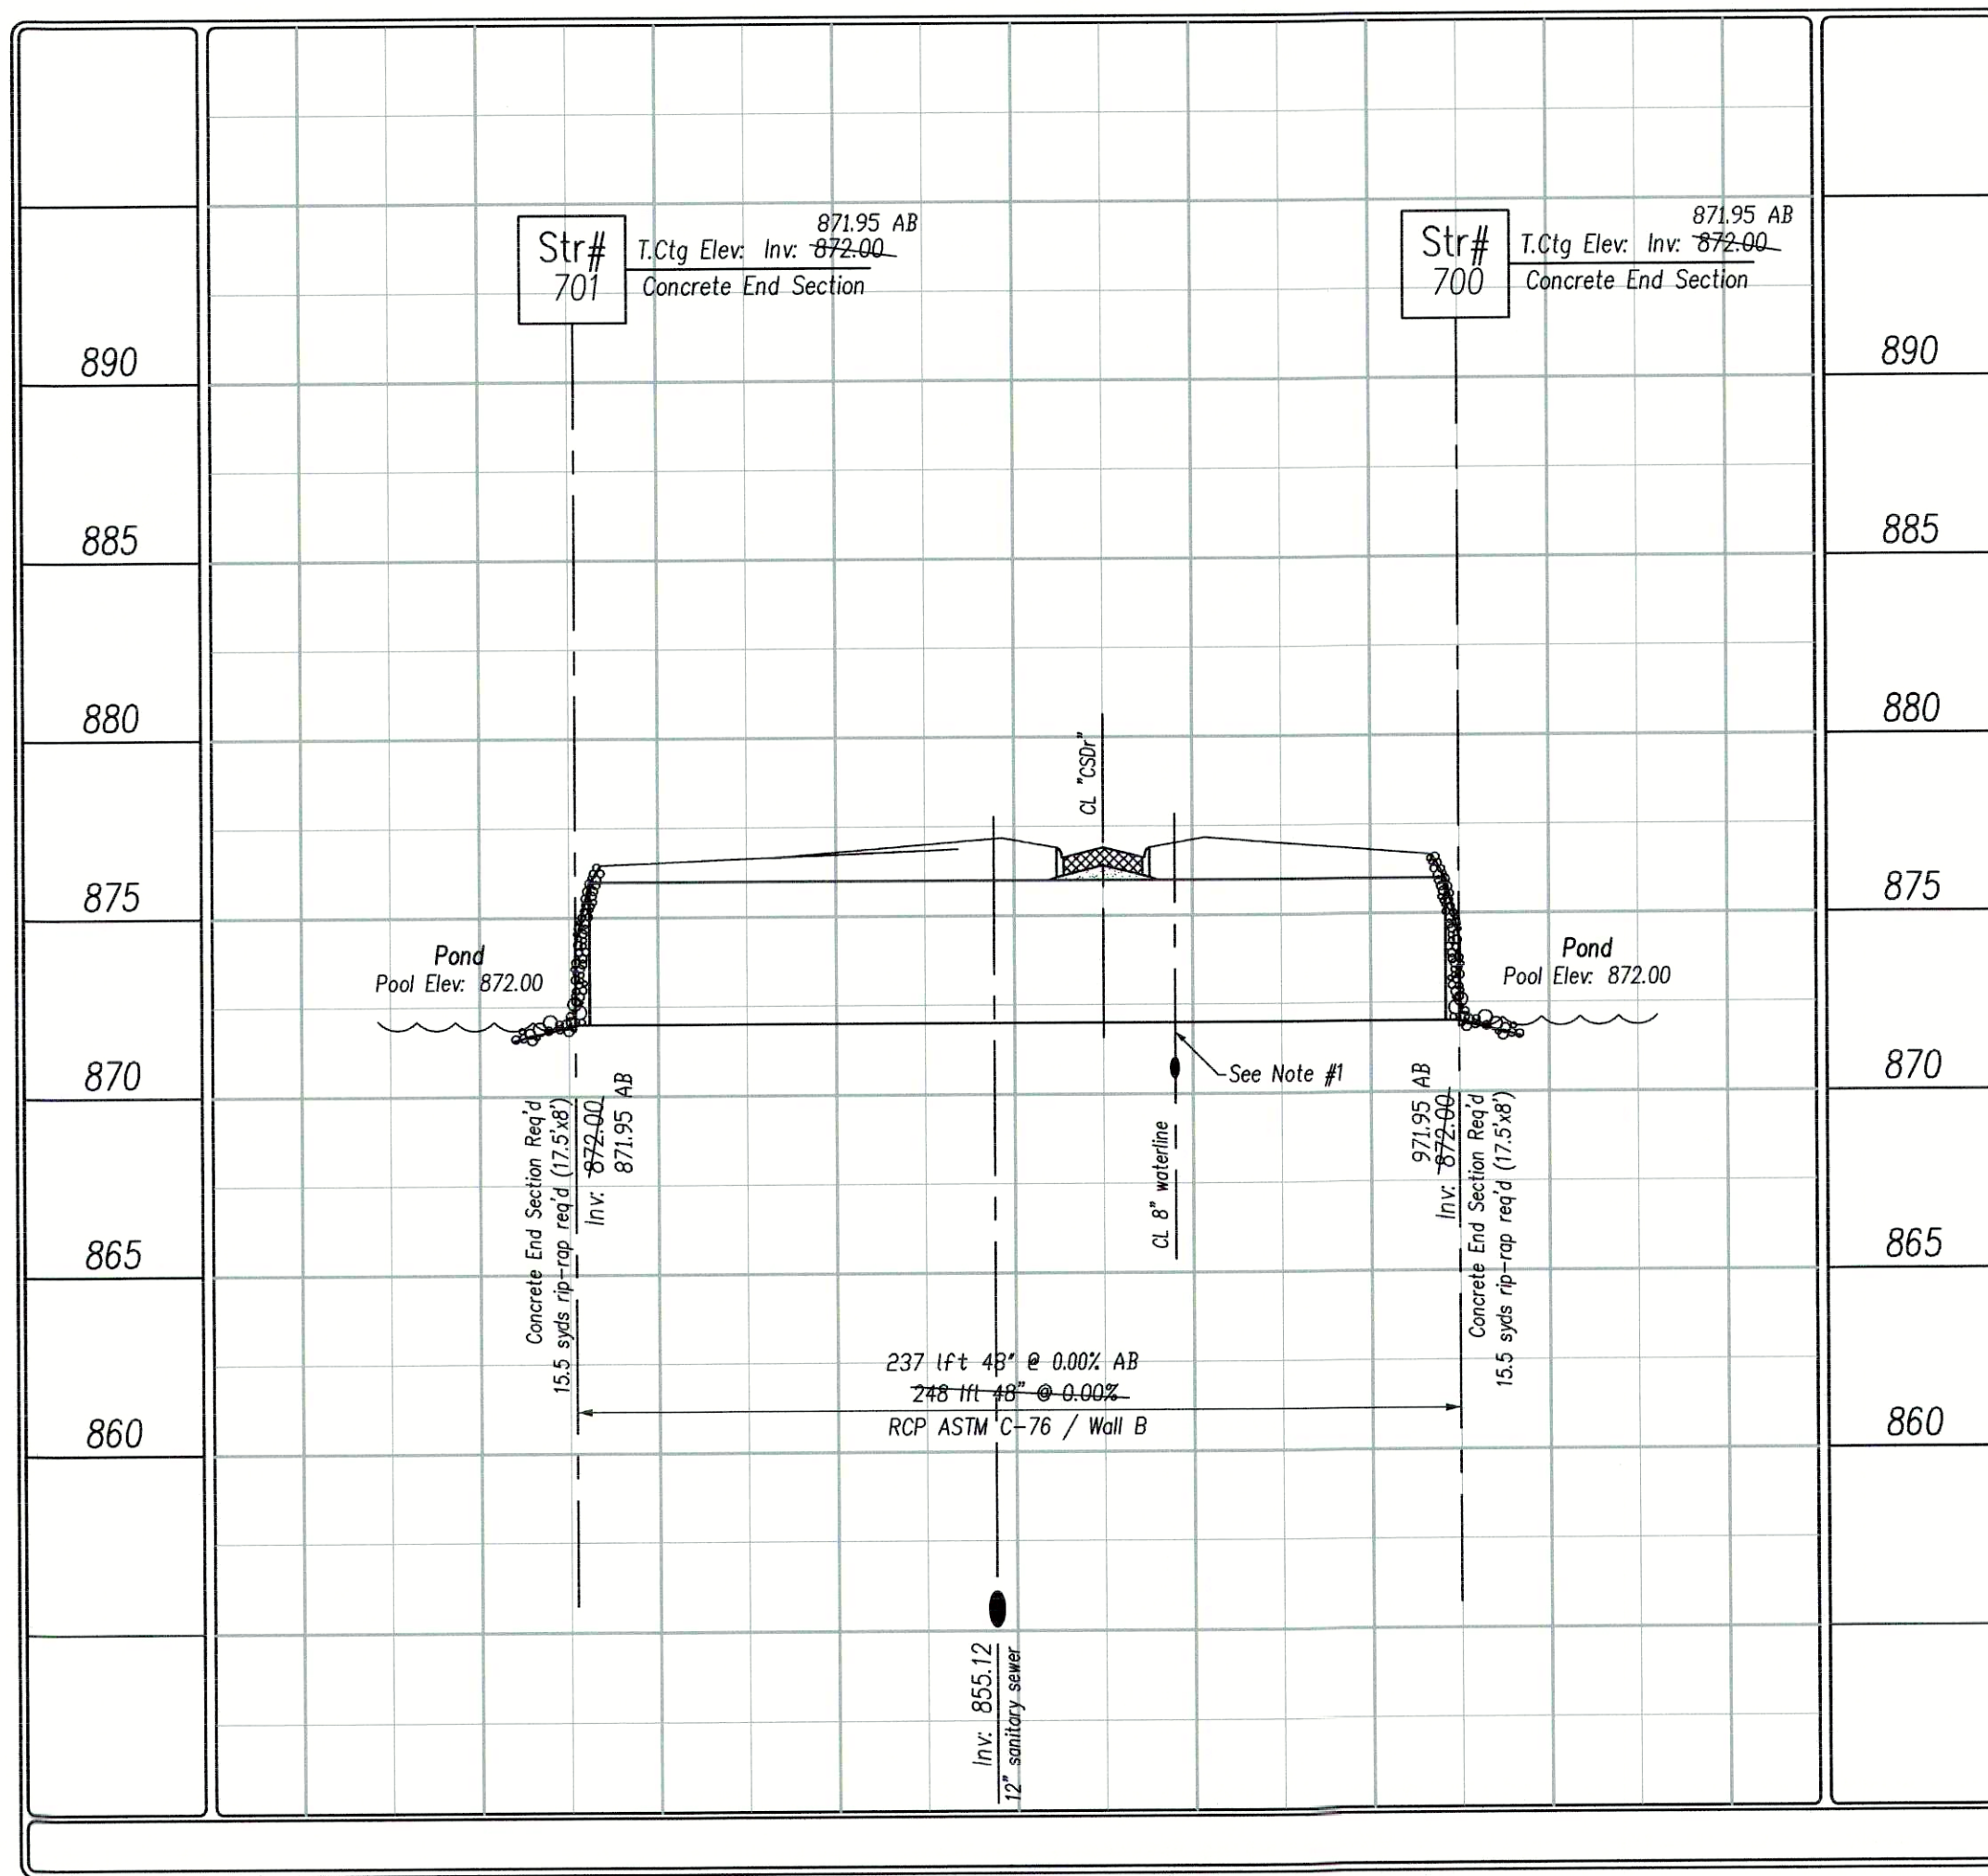

Structure Series 500

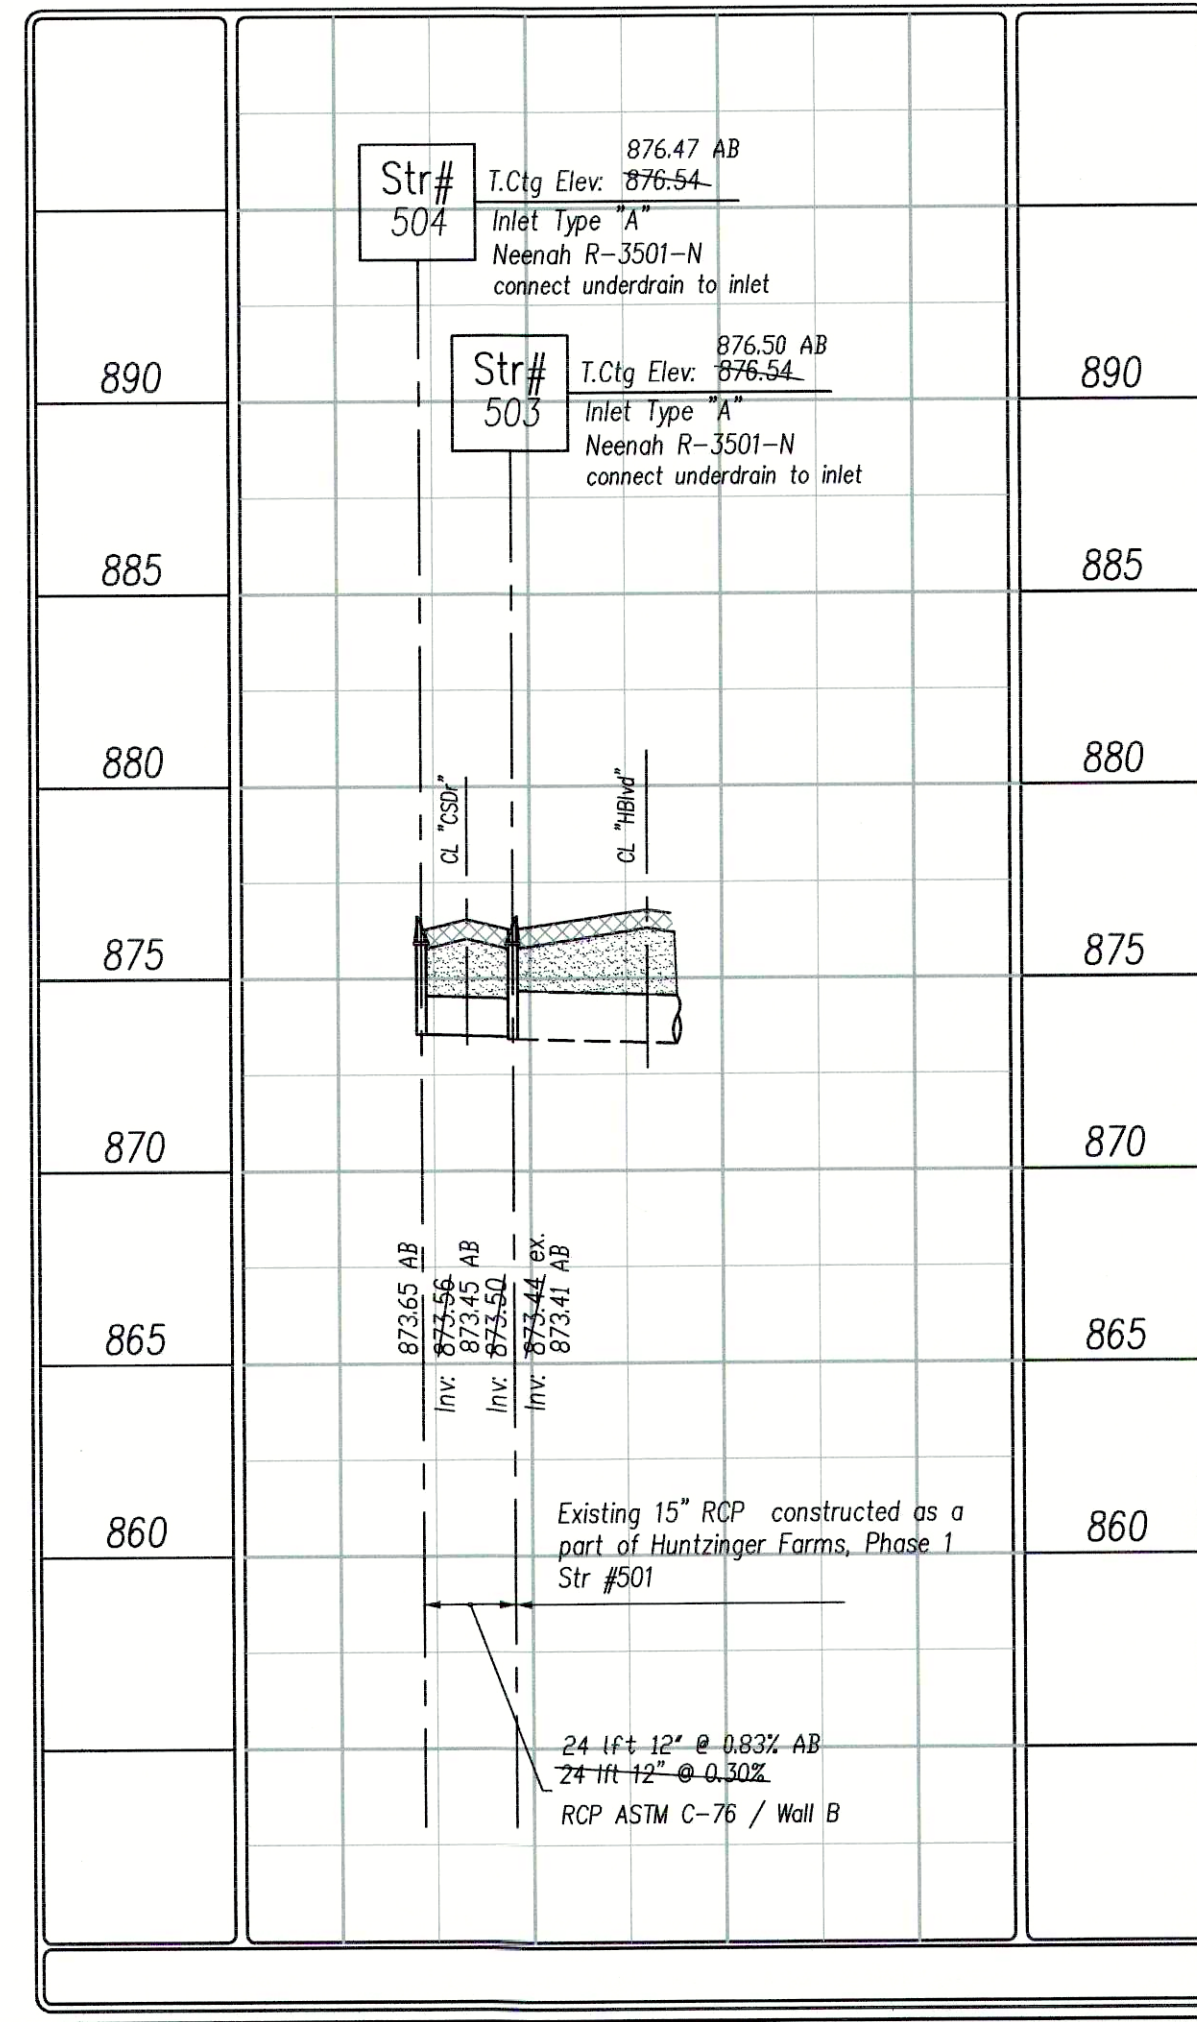

Scale:
Hor: 1"=50'
Ver: 1"=5'

PER INDIANA STATE LAW 15-69-1991, IT IS AGAINST THE LAW TO EXCAVATE WITHOUT NOTIFYING THE UNDERGROUND LOCATION SERVICE TWO (2) WORKING DAYS BEFORE COMMENCING WORK.

WITHIN INDIANA:
1-800-362-5044
FROM OUTSIDE INDIANA:
1-800-428-5200

ELECTRIC: RED
GAS-OIL: YELLOW
COMMUNICATIONS: ORANGE
WATER: BLUE
SEWER: GREEN
PROPOSED EXCAVATION: WHITE

THE INFORMATION NEEDED WHEN CALLING INDIANA UNDERGROUND PLANT PROTECTION SERVICES, INC. IS AS FOLLOWS:
COUNTY AND TOWNSHIP
STREET ADDRESS
TYPE OF WORK
EXTENT OF WORK
NAME OF CALLER AND TITLE
TELEPHONE NUMBER
BEST TIME TO CALL
START DATE AND START TIME
CONTRACTOR NAME AND ADDRESS

North

Scale: 1"=50'

Pendleton Consulting
P.O. Box 87 Pendleton, Indiana 46064
Phone: 765-778-4540 Fax: 765-778-3571
email: pendcns@midwestnet.net

Pendleton Land Company, LLC
9449 Priority Way West Drive
Suite 120
Indianapolis, Indiana 46240
Tel: 317.762.2883 Fax: 317.762.2885

Date	7/31/04
Revision	Revised per comments of client, remove pond, modify storm system (S/S Series 100-300), remove pond, add storm system Series 700, revised per client for new pond limits, connecting pipe between ponds, revised per client lot lines / numbering
Date	8/10/04
Revision	5/16/05
Date	5/19/05
Revision	9/23/05

FarmGate at Huntzinger Farms
Section 1
Pendleton, Madison County, Indiana
Sheet Title
Storm Plan - Profile
Storm Series 100, 500

STEFAN E. BOGARDUS
No. S0441
STATE OF INDIANA
LAND SURVEYOR

Sheet No.
9
17 Sheets

As-built Plans