


Denotes approximate limits of granular backfill. (Refer to respective specifications for exact limits and acceptable backfill materials).

NOTES:



1. Maintain a minimum of 18" of vertical separation per IDOT requirements.
2. Laterals are to be extended to the lot side edge of the utility easement.

"HBlvd" denotes Huntzinger Blvd
"CSDr" denotes Cold Springs Drive
"FGLn" denotes FarmGate Lane
"SSC" denotes Sanitary Sewer Line "C"
"SSB" denotes Sanitary Sewer Line "B"
"SSI" denotes Sanitary Sewer Line "I"

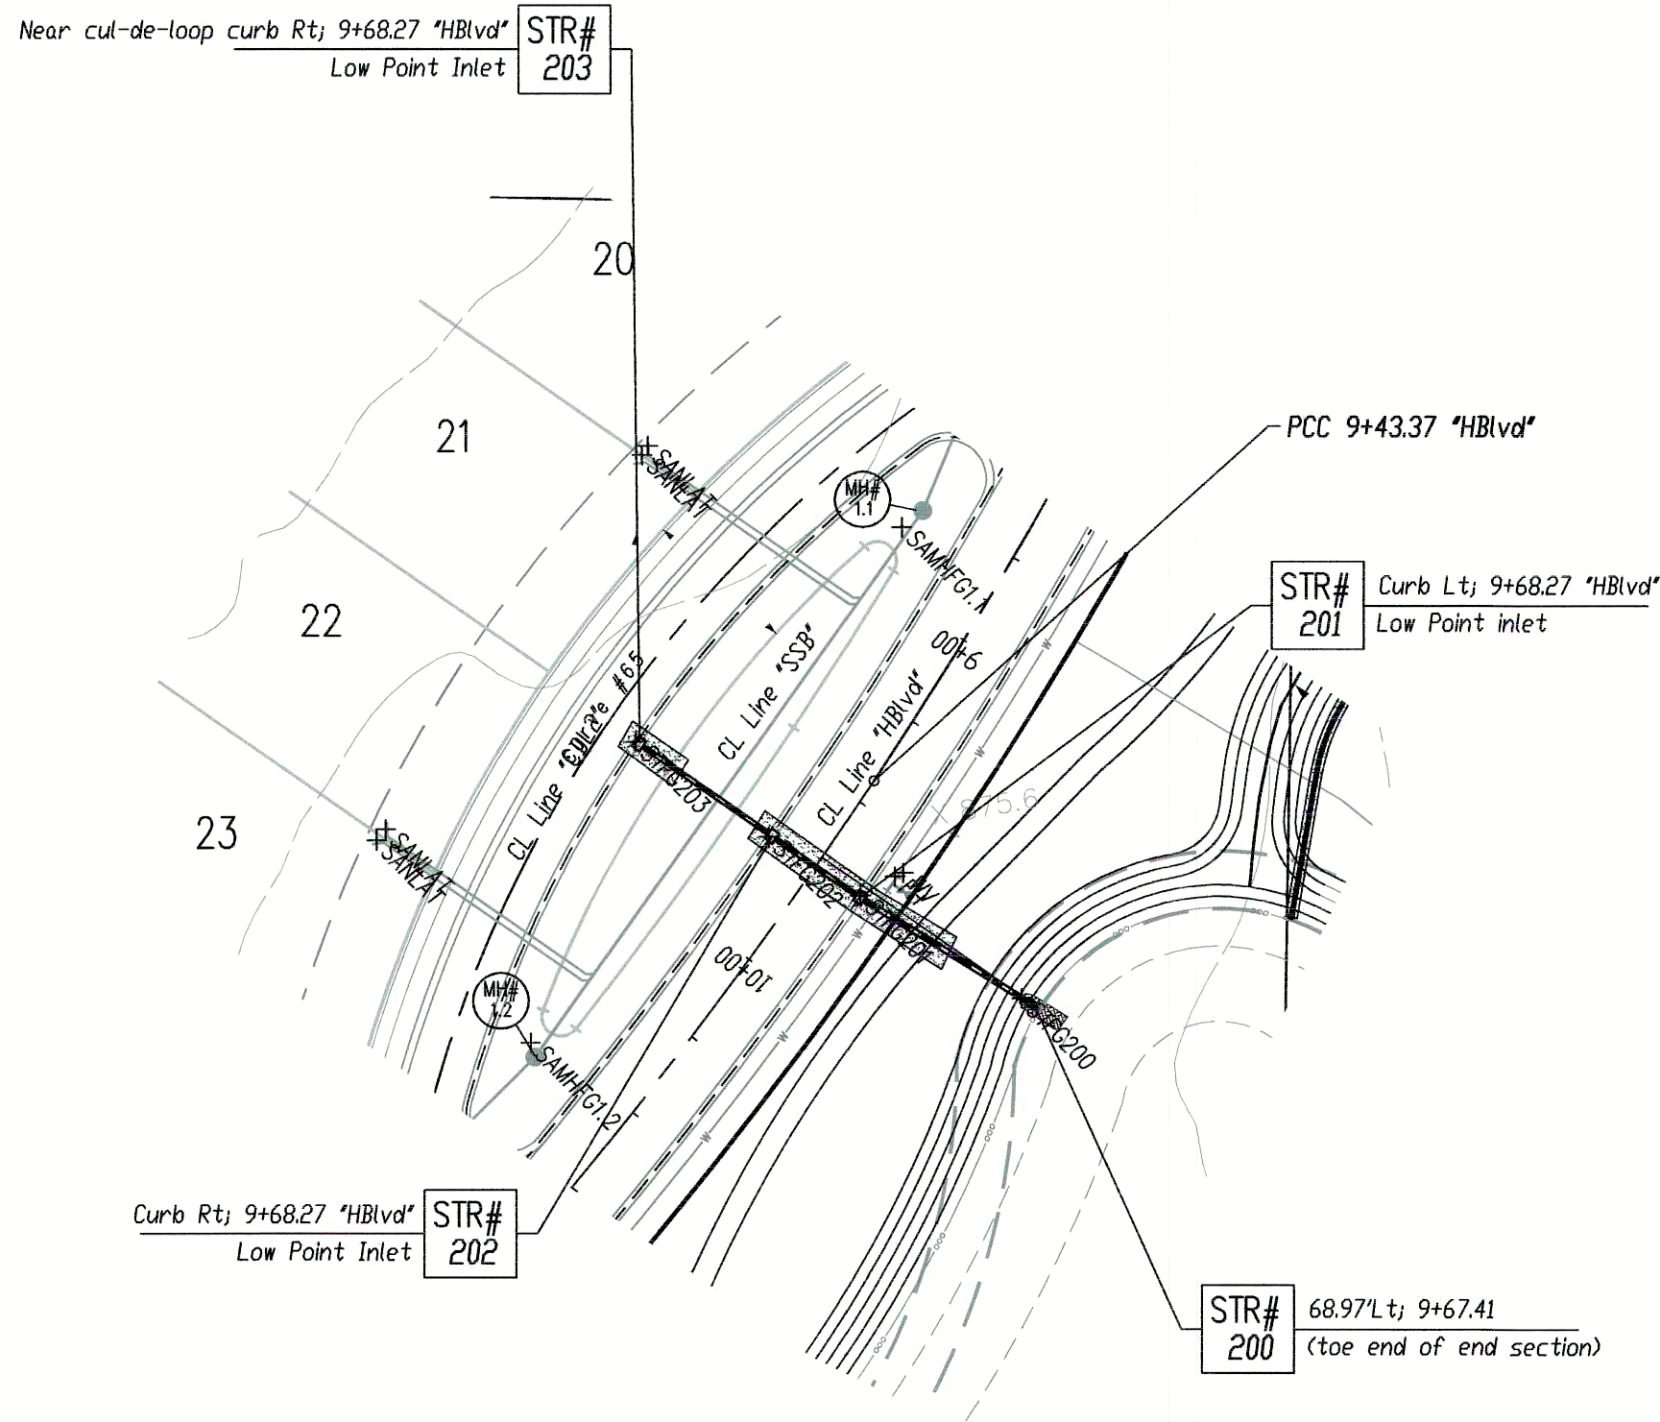


Scale:
Hor: 1"=50'
Ver: 1"=5'

Structure Series 200

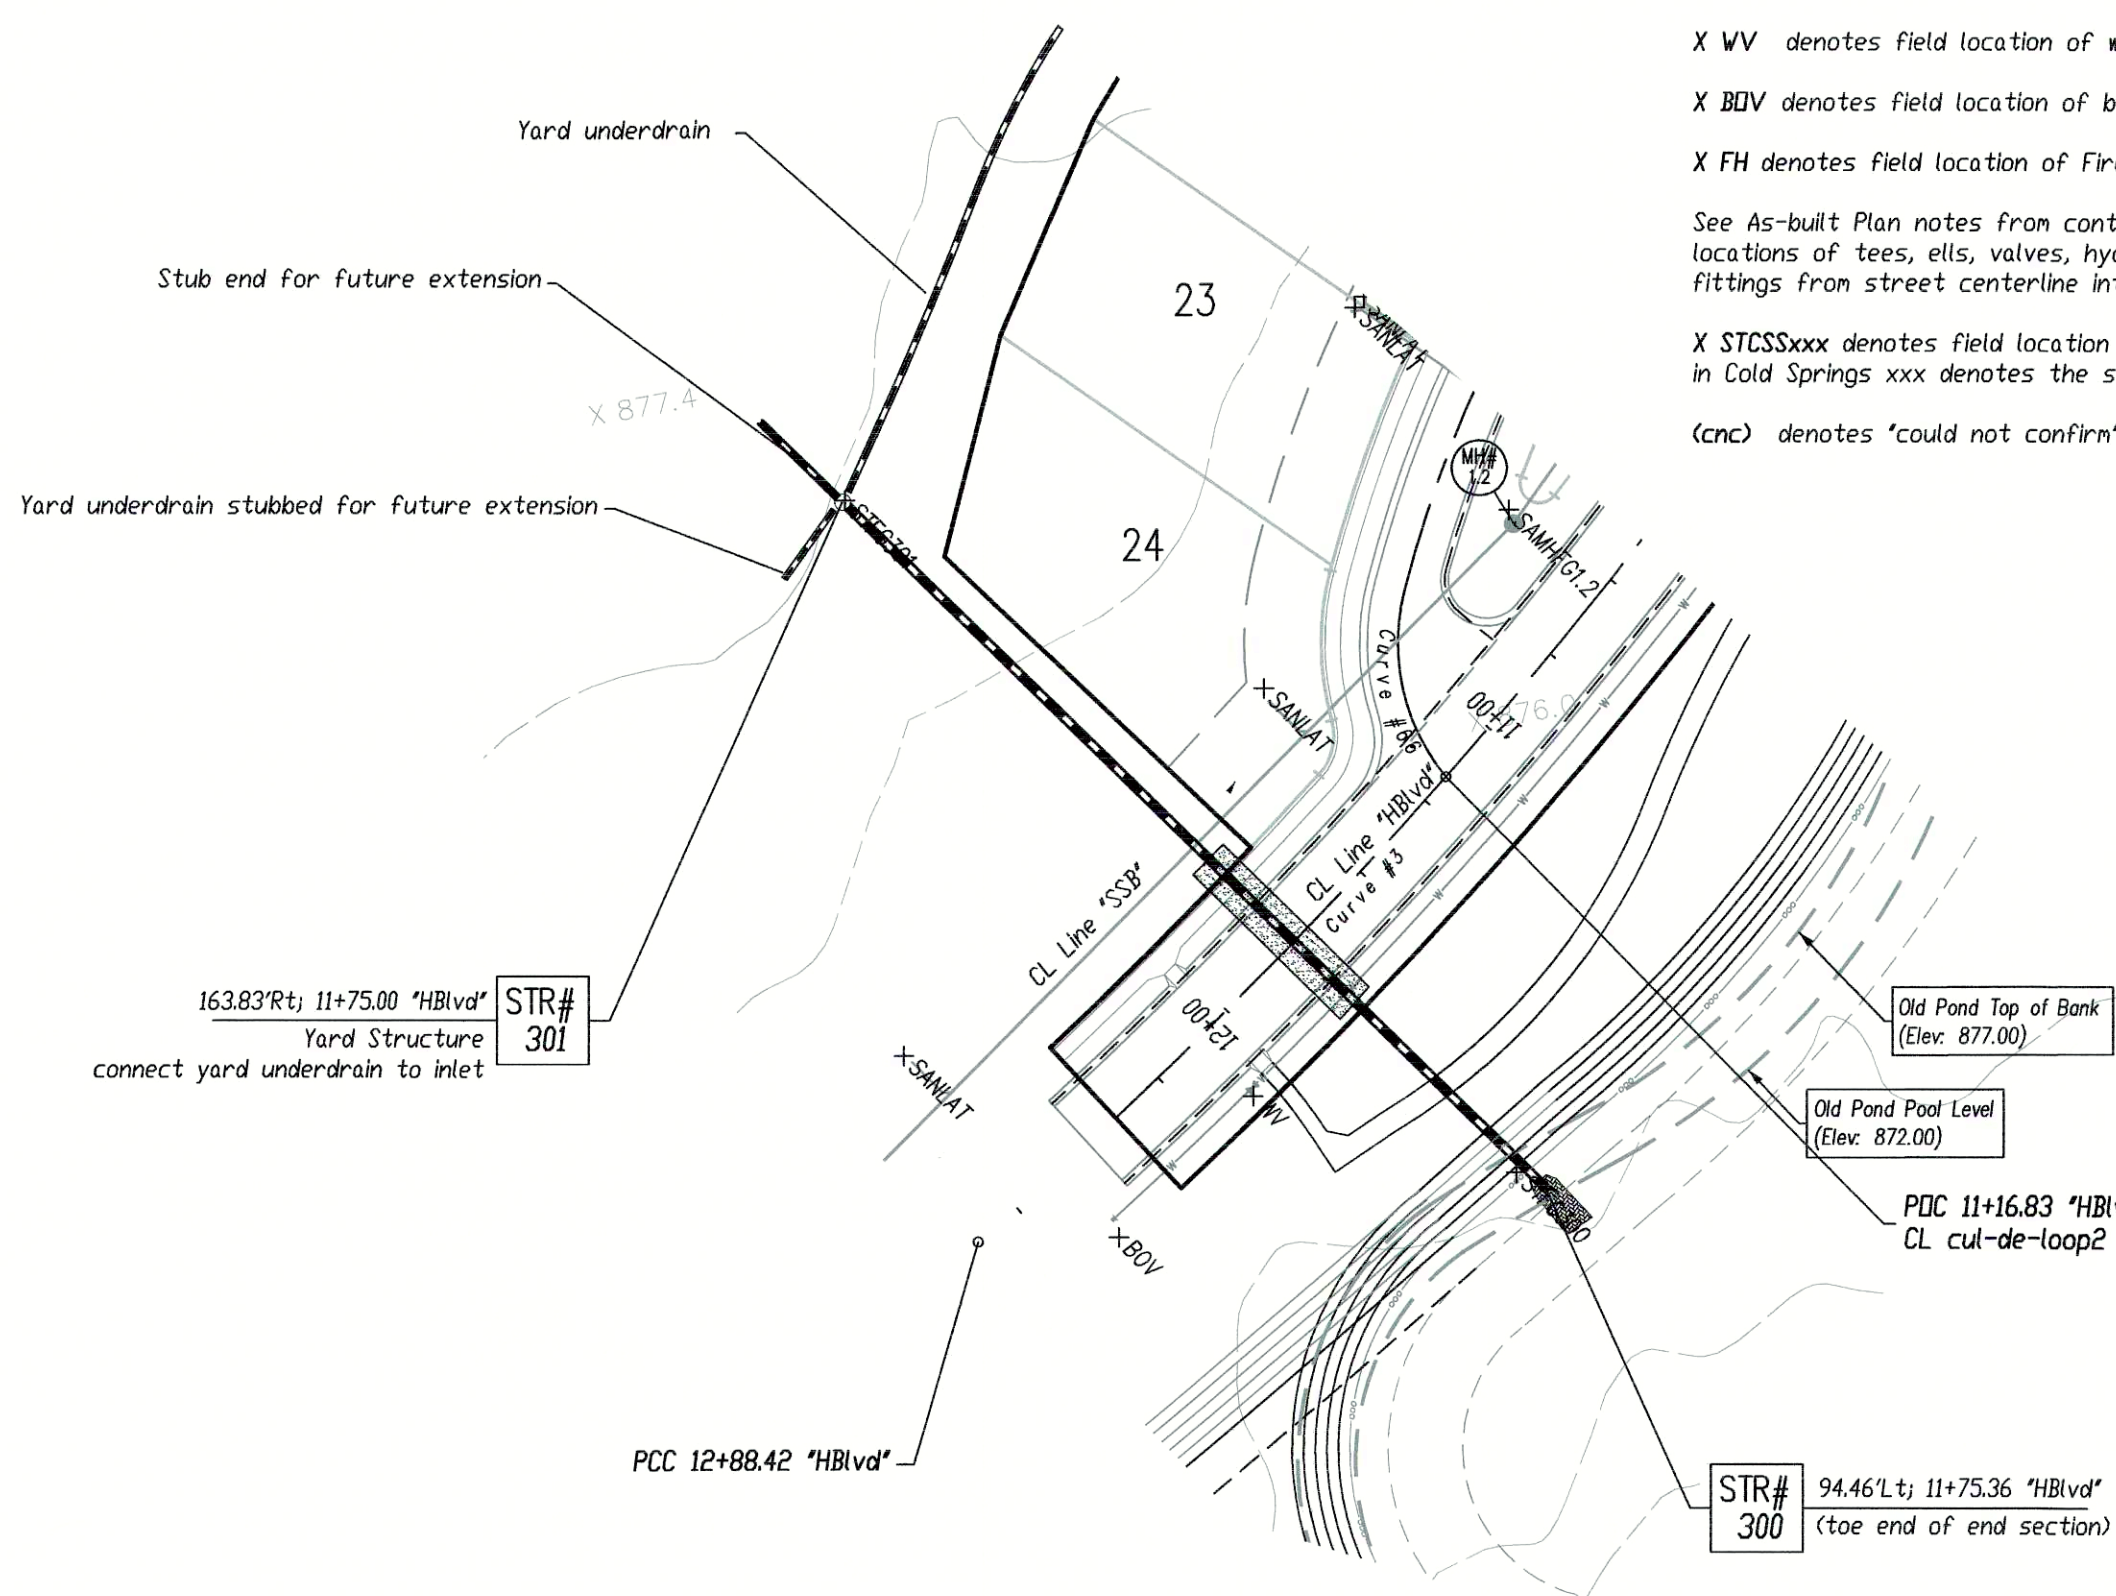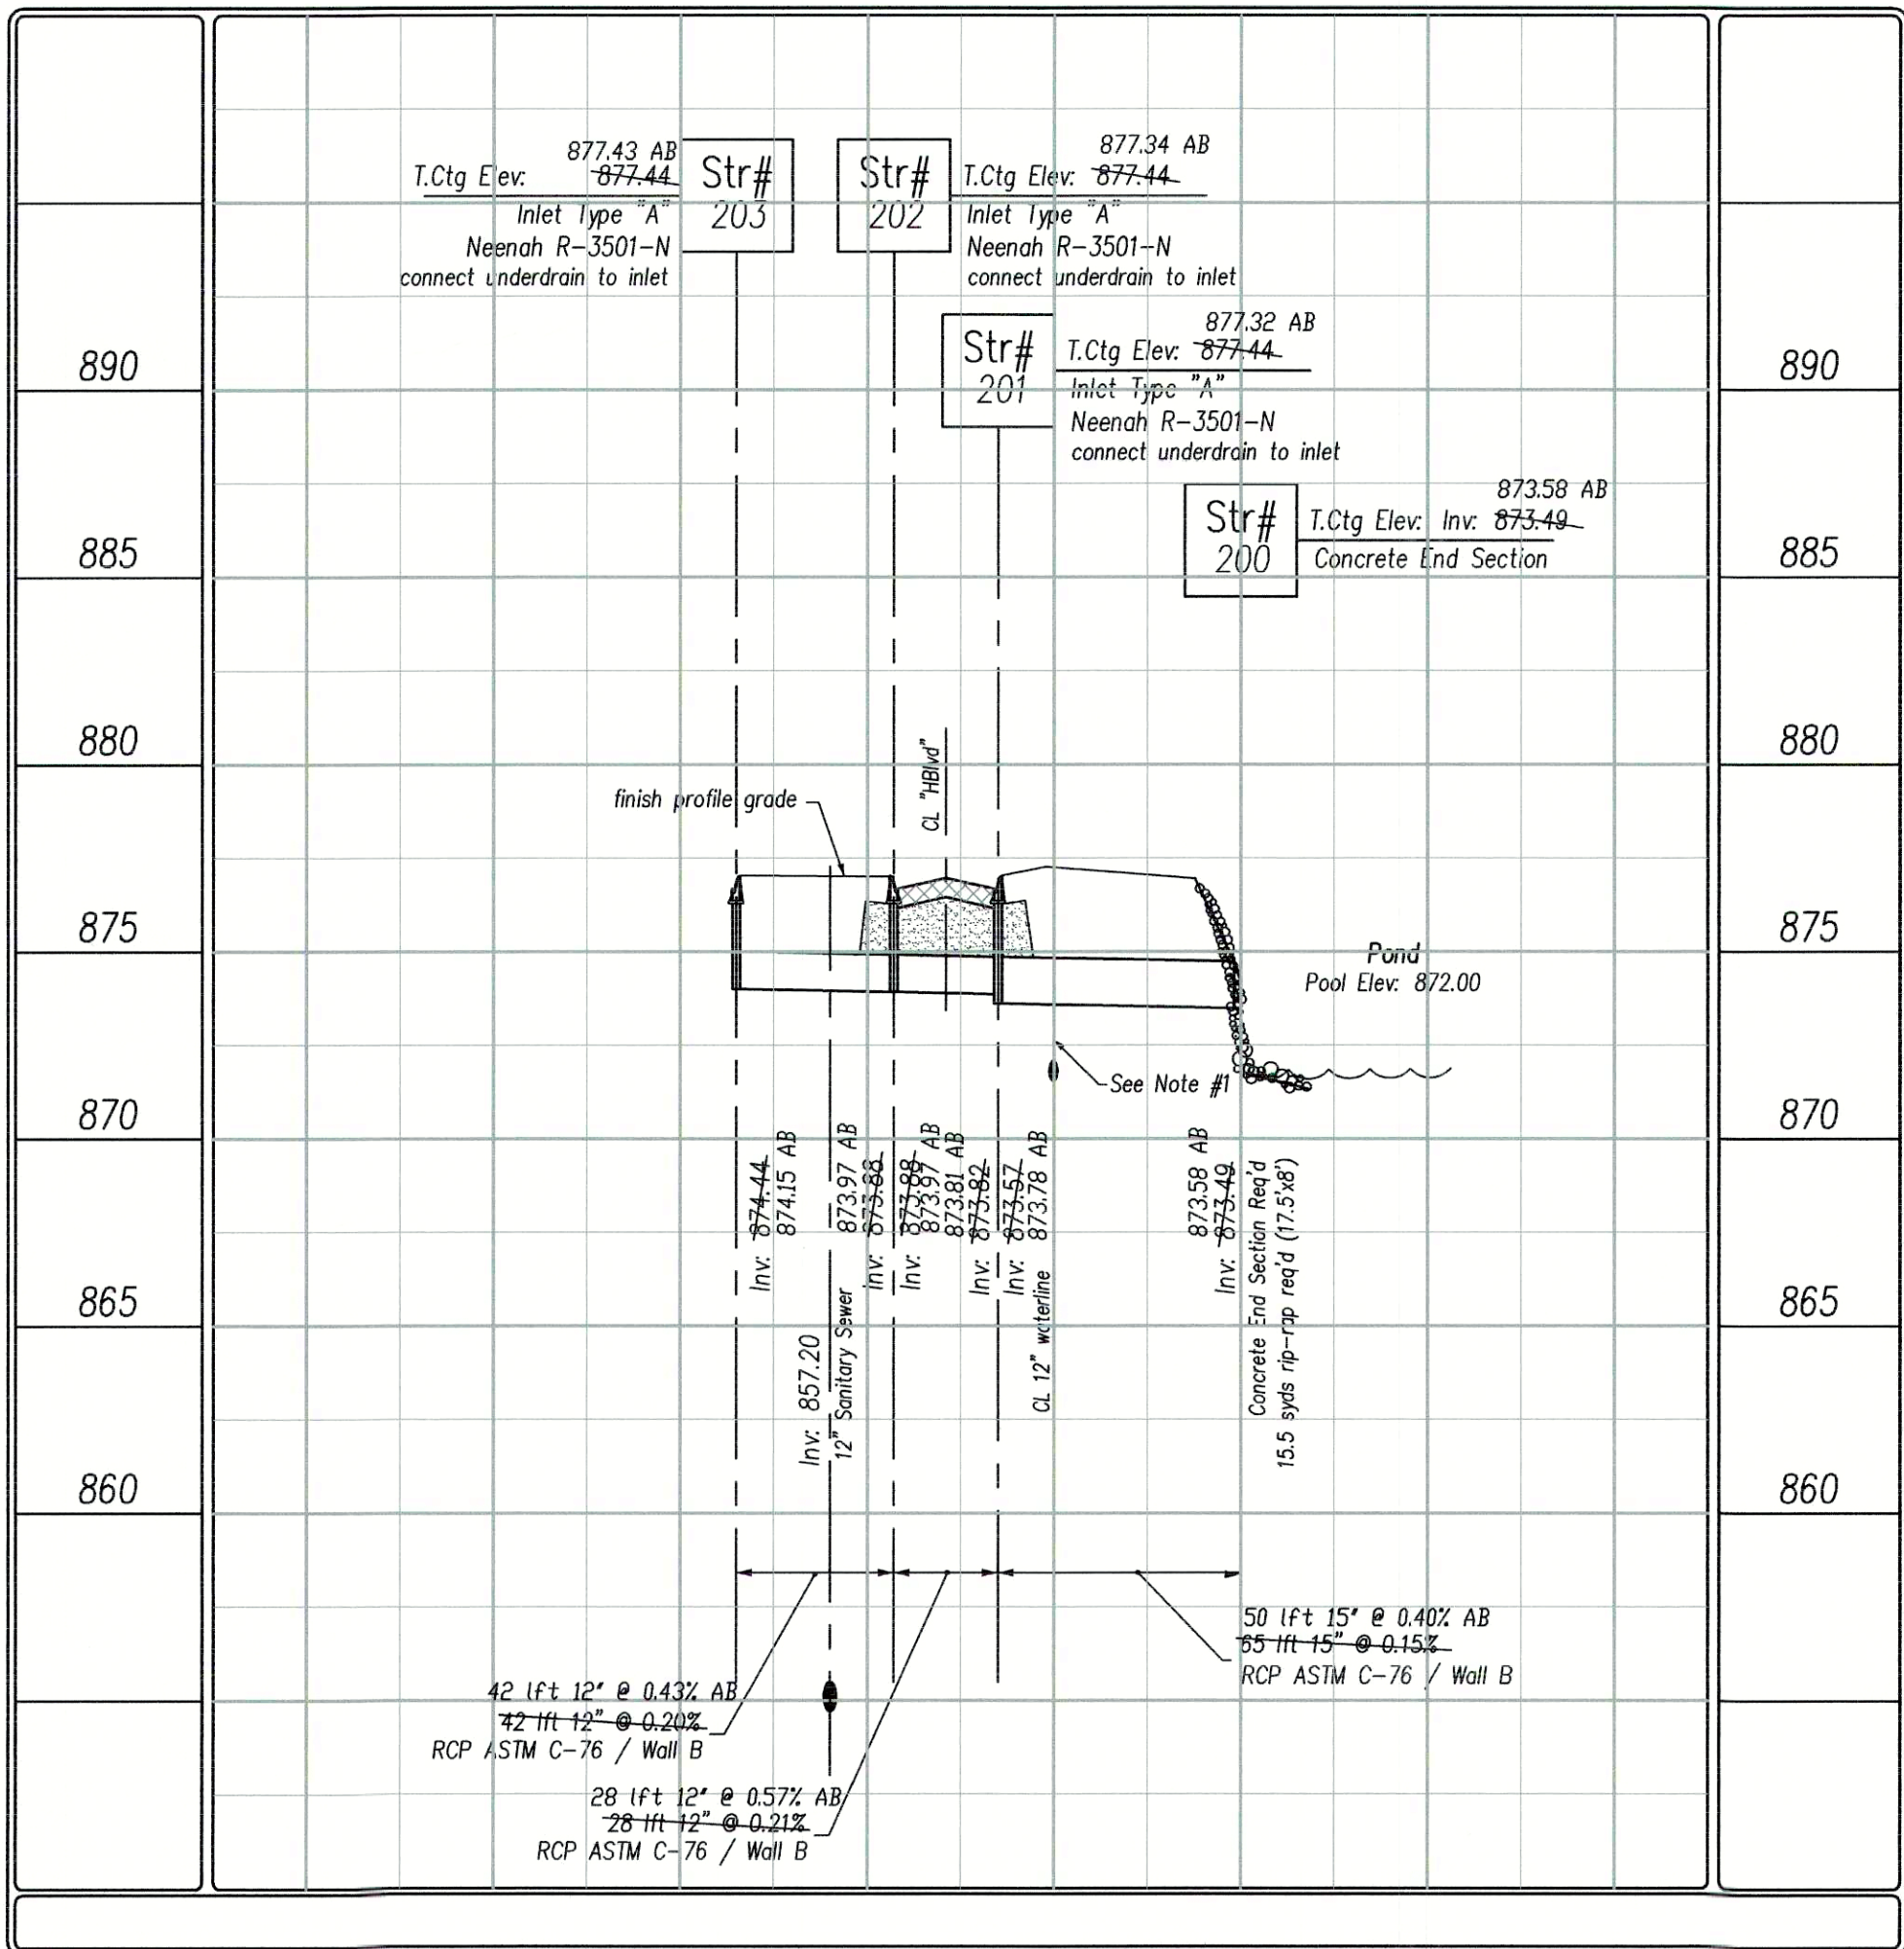

Structure Series 300

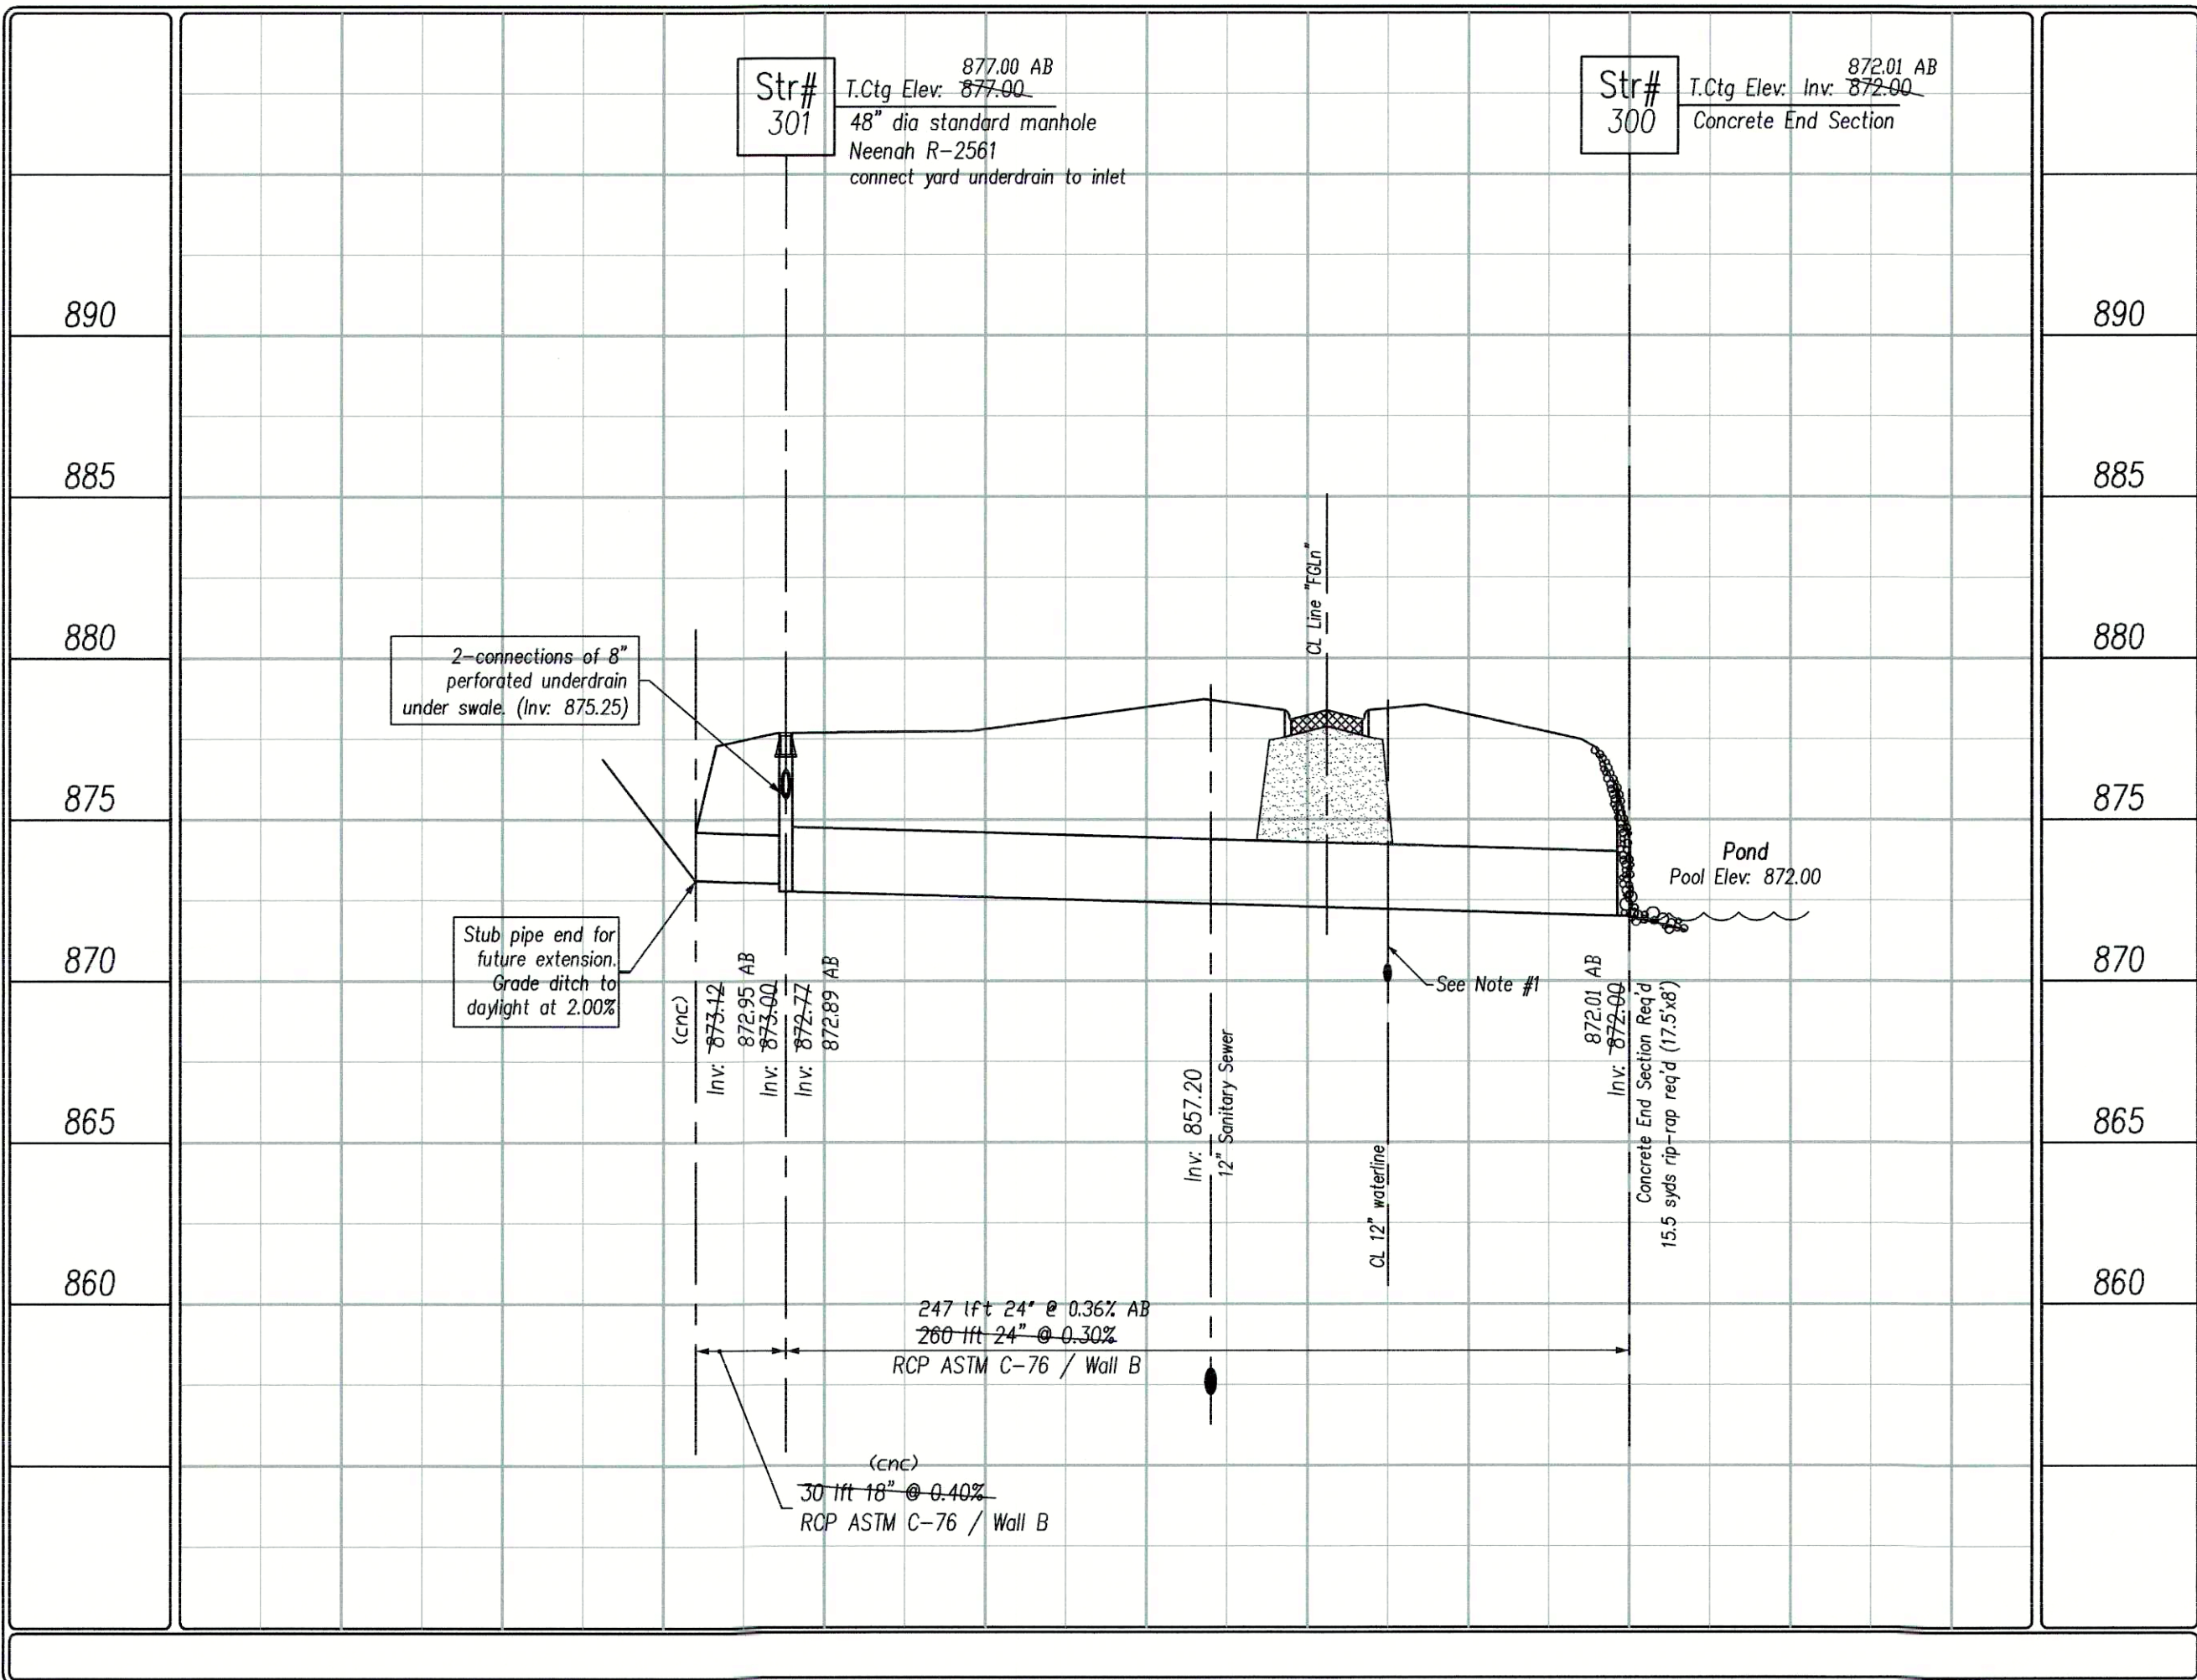

AS-BUILT NOTES:

X SANLAT denotes field location of sanitary lateral markers

X SANMHCSXX denotes field location of a manhole in Cold Springs XX denotes the manhole number

As-built locations of the sanitary lateral tees are denoted as distances from the downstream manhole, in line with the next upstream manhole.

X WV denotes field location of water valve.

X BDV denotes field location of blow-off valve

X FH denotes field location of Fire Hydrant

See As-built Plan notes from contractor for measured locations of tees, elbows, valves, hydrants and other fittings from street centerline intersections.

X STCSXXX denotes field location of storm structure in Cold Springs xxx denotes the structure number.

(cnc) denotes "could not confirm"

PER INDIANA STATE LAW IS-69-1991, IT IS AGAINST THE LAW TO EXCAVATE WITHOUT NOTIFYING THE UNDERGROUND LOCATION SERVICE TWO (2) WORKING DAYS BEFORE COMMENCING WORK.

WITHIN INDIANA:
1-800-382-5544
FROM OUTSIDE INDIANA:
1-800-468-5500

ELECTRIC RED
GAS-OIL YELLOW
COMMUNICATIONS ORANGE
WATER BLUE
SEWER GREEN

PROPOSED EDUCATION WHITE

THE INFORMATION NEEDED WHEN CALLING INDIANA UNDERGROUND PLANT PROTECTION SERVICES, INC. IS AS FOLLOWS:

COUNTY AND TOWNSHIP
STREET ADDRESS
TYPE OF WORK
EXTENT OF WORK
NAME OF CALLER AND TITLE
TELEPHONE NUMBER
BEST TIME TO CALL
START DATE AND START TIME
CONTRACTOR NAME AND ADDRESS

North

Scale: 1"=50'

Pendleton Consulting

Pendleton Land Company, LLC
9449 Priority Way West Drive
Suite 120
Indianapolis, Indiana 46240
Phone: 765-776-4540 Fax: 765-776-3571
email: pendcon@netdirect.net

Pendleton Land Company, LLC
9449 Priority Way West Drive
Suite 120
Indianapolis, Indiana 46240
Phone: 765-776-4540 Fax: 765-776-3571
email: pendcon@netdirect.net

Date: 7/31/04

Revised per comments of client, revised pond, revised storm system, revised S/S Series 100-300.

Revised per client, lot lines / numbering.

Project: FarmGate at Huntzinger Farms
Section 1
Pendleton, Madison County, Indiana

Sheet Title: Storm Plan - Profile
Storm Series 200, 300

REGISTERED PROFESSIONAL ENGINEER
STATE OF INDIANA
NO. 50441
E. BOJAKIEWICZ

Sheet No. 10
17 Sheets

As-built Plans