

**NOTE:**  
ADDITIONAL RIGHT-OF-WAY OR EASEMENTS MAY  
NEED TO BE ACQUIRED FOR INSTALLATION OF SEWER.

**DON'T DIG BLIND  
CALL BEFORE YOU DIG**  
TOLL FREE  
1-800-382-5544  
OTHER NUMBERS  
1-800-428-5200

PER INDIANA STATE LAW IS-69-1991, IT IS  
AGAINST THE LAW TO EXCAVATE WITHOUT  
NOTIFYING THE UNDERGROUND LOCATION SERVICE  
TWO (2) WORKING DAYS BEFORE COMMENCING WORK.

**NOTE:** CONTRACTOR TO VERIFY ALL UTILITY LOCATIONS  
PRIOR TO THE START OF CONSTRUCTION

**GENERAL NOTES:**


- ALL UTILITY LOCATIONS ARE APPROXIMATE. THE CONTRACTOR SHALL HAVE ALL UTILITIES FIELD VERIFIED AND MARKED PRIOR TO CONSTRUCTION.
- CONTRACTOR SHALL MAINTAIN A MINIMUM 10'-0" HORIZONTAL AND 18" VERTICAL SEPARATION BETWEEN SEWER AND WATER MAINS.
- ALL PROPOSED TOP OF CASTING ELEVATIONS ARE APPROXIMATE. THE CONTRACTOR SHALL ADJUST FINAL ELEVATIONS AS REQUIRED TO BE FLUSH WITH PAVEMENT.
- ALL SEWER TRENCHES SHALL BE BACKFILLED WITH FULL DEPTH COMPACTED GRANULAR BACKFILL ("B" BORROW) UNDER OR WITHIN 5' OF EDGE OF PAVEMENT.
- THE CONTRACTOR SHALL VISIT THE SITE PRIOR TO BID TO BECOME FAMILIAR WITH ALL SITE CONDITIONS.
- THE CONTRACTOR SHALL PROVIDE THE REQUIRED MEASURES FOR MAINTAINING SAFE TRAFFIC AT ALL TIMES.
- CONTRACTOR SHALL RESTORE ALL DISTURBED LAWN AREAS, STREETS, WALKS, DRIVES, ETC. AS SHOWN ON DRAWINGS, IN THE SPECIFICATIONS, OR TO AT LEAST PRE-EXISTING CONDITIONS.
- ALL UTILITY CROSSINGS SHALL BE PROTECTED AND SUPPORTED WITH GRANULAR FILL OR CONCRETE AS REQUIRED PER THE DETAIL SHEET.

**LEGEND:**

•	TREE	1085	CONTOUR	— — — — —	UNDERGROUND ELECTRIC LINE
○	POWER POLE	— x — x —	FENCE	— — — — —	UNDERGROUND TELEPHONE LINE
+	GUY WIRE	— MH —	EXIST. SANITARY SEWER w/ MANHOLE	— — — — —	APPROX. RIGHT-OF-WAY
⋈	FIRE HYDRANT	— • —	NEW SANITARY SEWER w/ MANHOLE	— . . . . .	APPROX. CORPORATE LIMITS
⊕	MAILBOX	— SC —	NEW SANITARY SERVICE CONNECTION	— — — — —	APPROX. PROPERTY LINE
FP	FLAGPOLE	— 4" — W —	WATER LINE	○ W	EXISTING WATER WELL
X 1085.2	SPOT SHOT	— 2" — G —	GAS LINE	■ S	EXISTING SEPTIC TANK



**SCALE:**  
HORIZONTAL 1" = 50'  
VERTICAL 1" = 5'

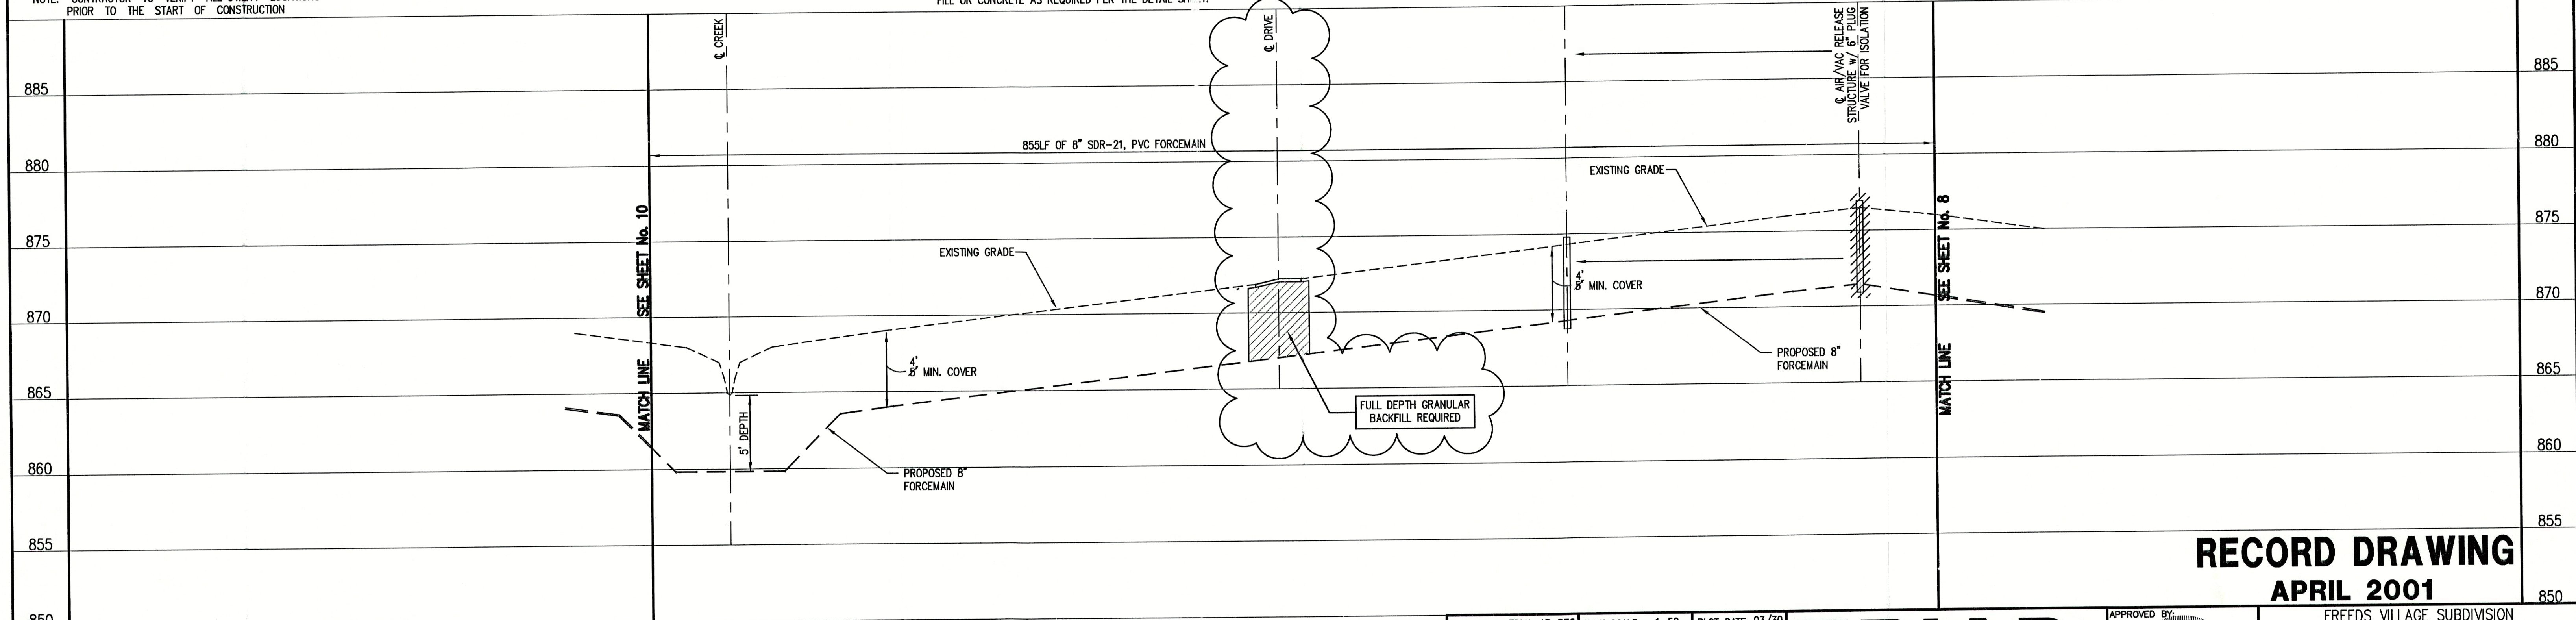

**RECORD DRAWING  
APRIL 2001**

**NOTE:**  
THE CONTRACTOR SHALL INCLUDE IN THE COSTS FOR SANITARY PIPE,  
ALL WATER SERVICE RECONNECTIONS, STORM SEWER RECONNECTION,  
WATER MAIN RELOCATIONS, CONCRETE RECONSTRUCTION, AND  
SIDEWALK RECONSTRUCTION AS REQUIRED TO INSTALL NEW WORK  
AS SHOWN ON THE DRAWINGS.

FILE NAME: FRVIL_15-REC		PLOT SCALE: 1=50	PLOT DATE: 03/30
NO.	DATE	DESCRIPTION	BY

**TRIAD  
ASSOCIATES  
INC.**  
INDIANAPOLIS, INDIANA

APPROVED BY:  
**THOMAS M. SCHUBERT**  
No. 15614  
STATE OF INDIANA  
REGISTERED PROFESSIONAL ENGINEER

FREEDS VILLAGE SUBDIVISION FALL CREEK REGIONAL WASTE DISTRICT			
PLAN AND PROFILE			
DRAWN BY: DAP	DATE 04/12/98	PROJECT No. 98008A	SHEET No. 9
DESIGNED BY: D.A. Pauling	CHECKED BY: James W. Frazell, P.E.	OF 20	