

Merry Hills
York Dr.

HARSHMAN ROAD, KEN - DALE MANOR ADDITION AND STATE ROAD 132 SANITARY SEWER PROJECT


PROJECT FOR THE
FALL CREEK REGIONAL WASTE DISTRICT
MADISON CO., IN.

1998
SRF PROJECT NO. CS 18207701
DIVISION II
CONTRACT 'E'
JOE ROWLETT - GENERAL MANAGER

SHEET INDEX


SHEET NO.	DESCRIPTION
1	TITLE SHEET AND INDEX
2-4	PROJECT BASE MAP
5-9	PLAN AND PROFILES FOR HARSHMAN ROAD
10-12	PLAN AND PROFILES FOR KEN - DALE MANOR ADDITION
13-17	PLAN AND PROFILES FOR STATE ROAD 132
18-19	STANDARD SANITARY DETAILS

AREA MAP

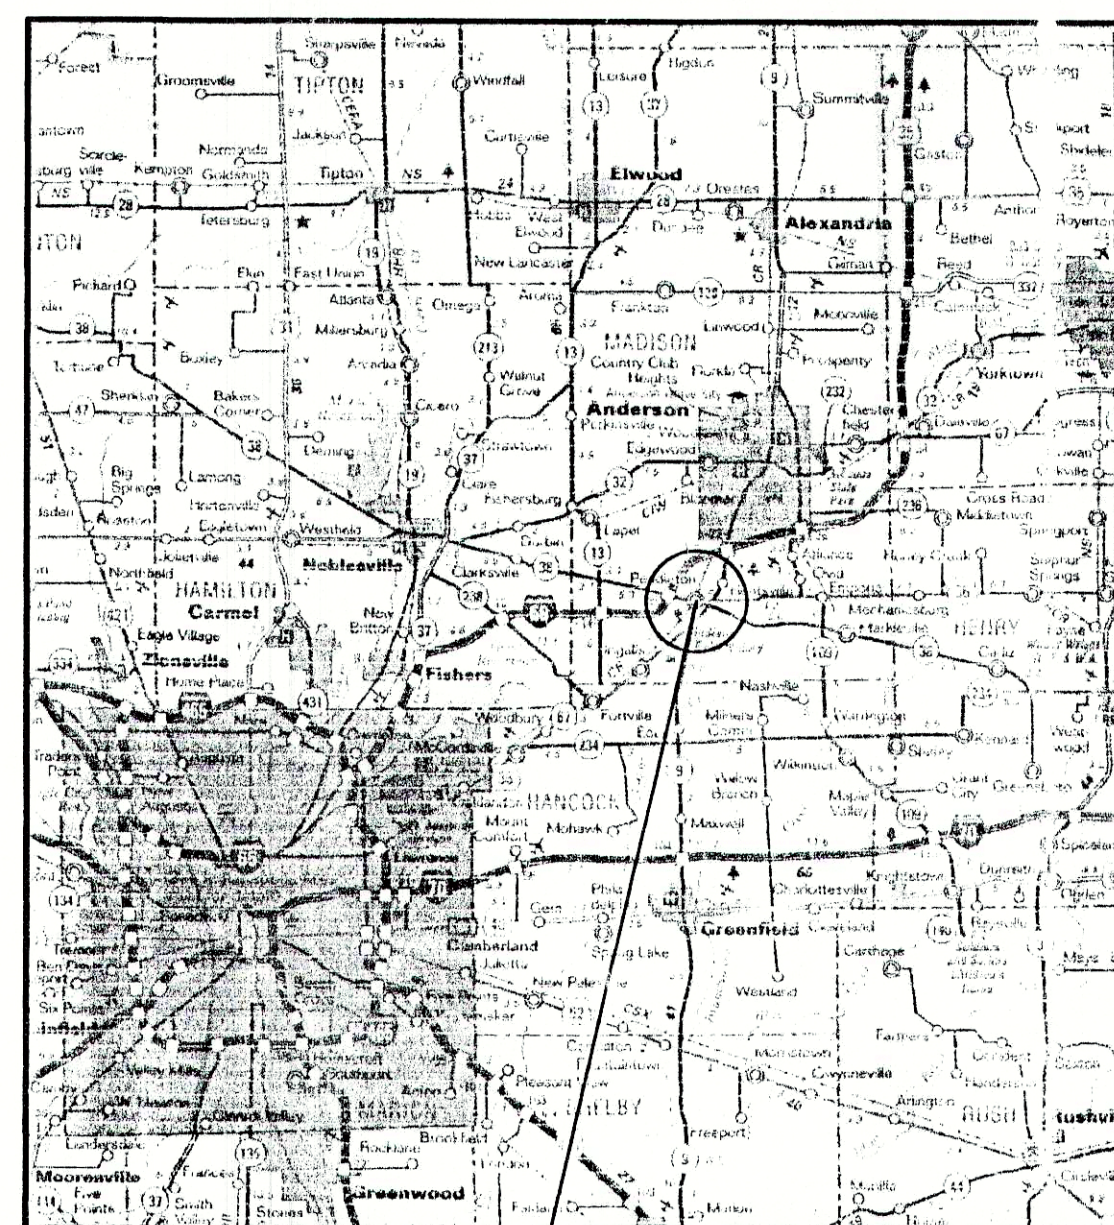

AREA
LOCATION

LOCATION MAP

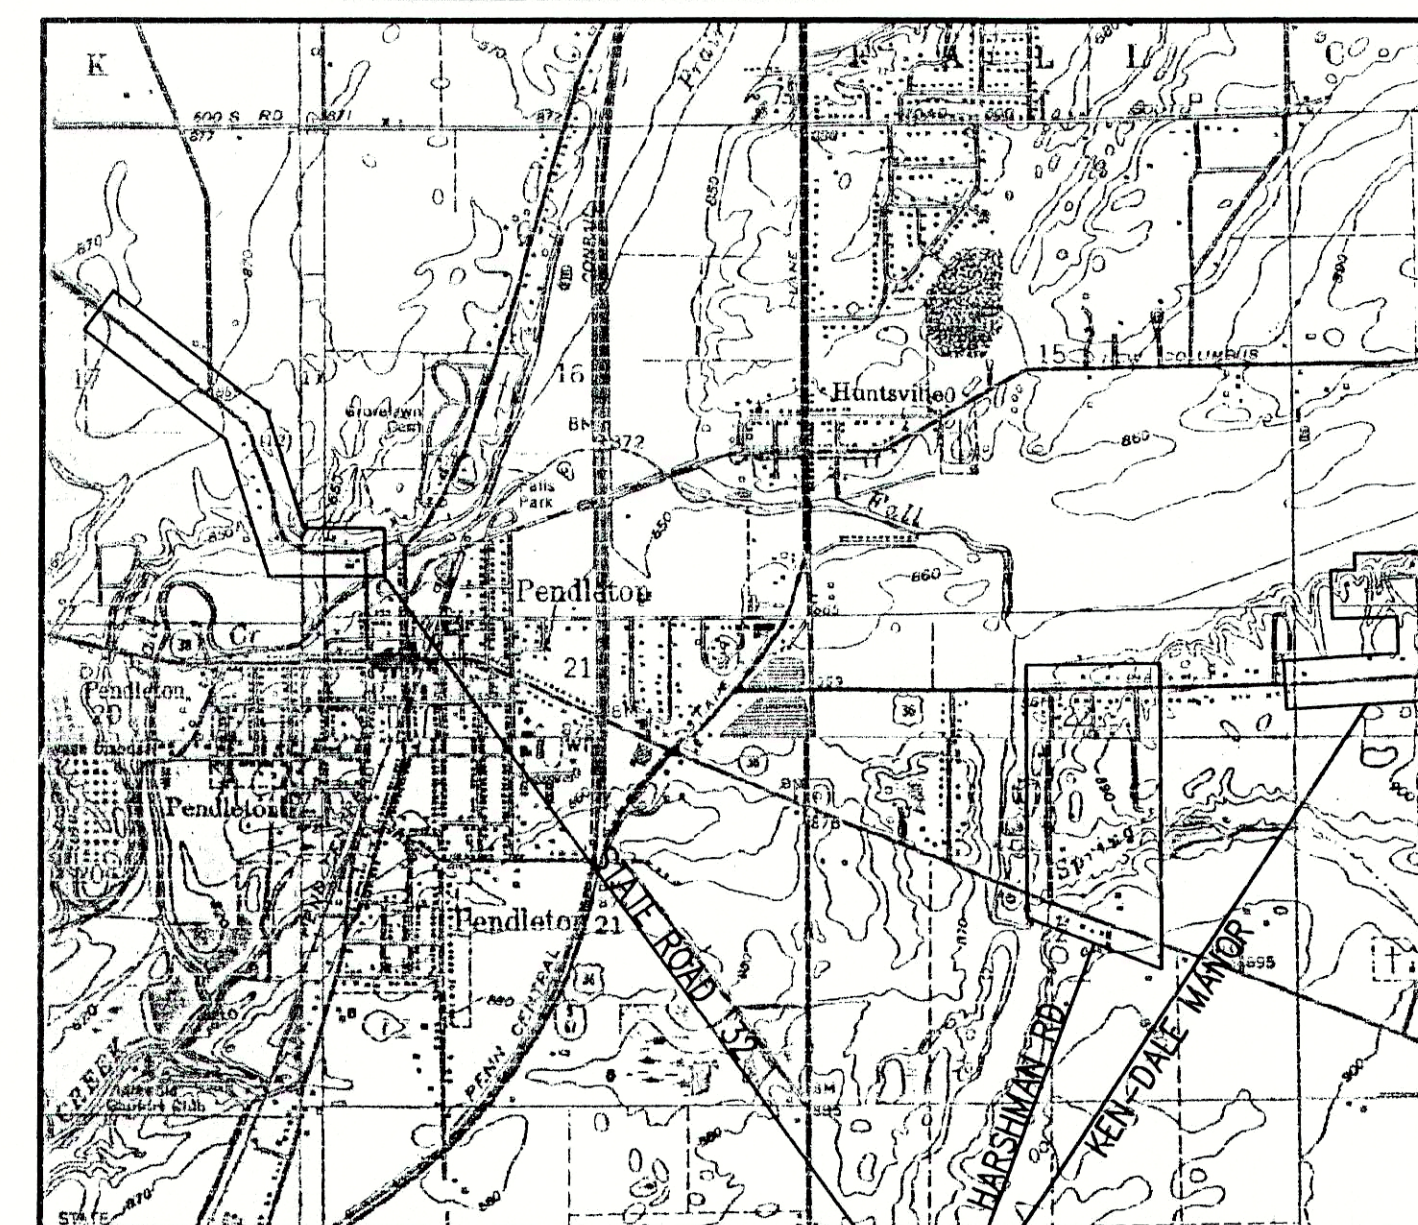

PROJECT
LOCATION

FALL CREEK REGIONAL WASTE DISTRICT BOARD

Mr. William Clark - President
Mr. Morris McCurdy - Member
Mr. Doug McGee - Member
Mr. Mark Jablonski - Member
Mr. Agon Tolbert - Member
Mr. Dallas Foster - Member
Mr. Jack Kasdorf - Member
Mr. Timothy Green - Member
Mr. John Ellingwood - Member
Mr. Joe Rowlett - General Manager

ATTORNEY

Mr. Randall Sorrell

PLANS PREPARED BY:

TRIAD
ASSOCIATES
INC.
INDIANAPOLIS, INDIANA

NOTE:
ADDITIONAL RIGHT-OF-WAY OR EASEMENTS MAY
NEED TO BE ACQUIRED FOR INSTALLATION OF SEWER.



DON'T DIG BLIND
CALL BEFORE YOU DIG
1-800-382-5544
1-800-428-5200

PER INDIANA STATE LAW IS-69-1991, IT IS
AGAINST THE LAW TO EXCAVATE WITHOUT
NOTIFYING THE UNDERGROUND LOCATION SERVICE
TWO (2) WORKING DAYS BEFORE COMMENCING WORK.

NOTE: CONTRACTOR TO VERIFY ALL UTILITY LOCATIONS
PRIOR TO THE START OF CONSTRUCTION

THESE PLANS CERTIFIED BY:

James W. Frazell, Professional Engineer

RECORD DRAWING

February 15, 2001

Thomas M. Schubert, Professional Engineer

