



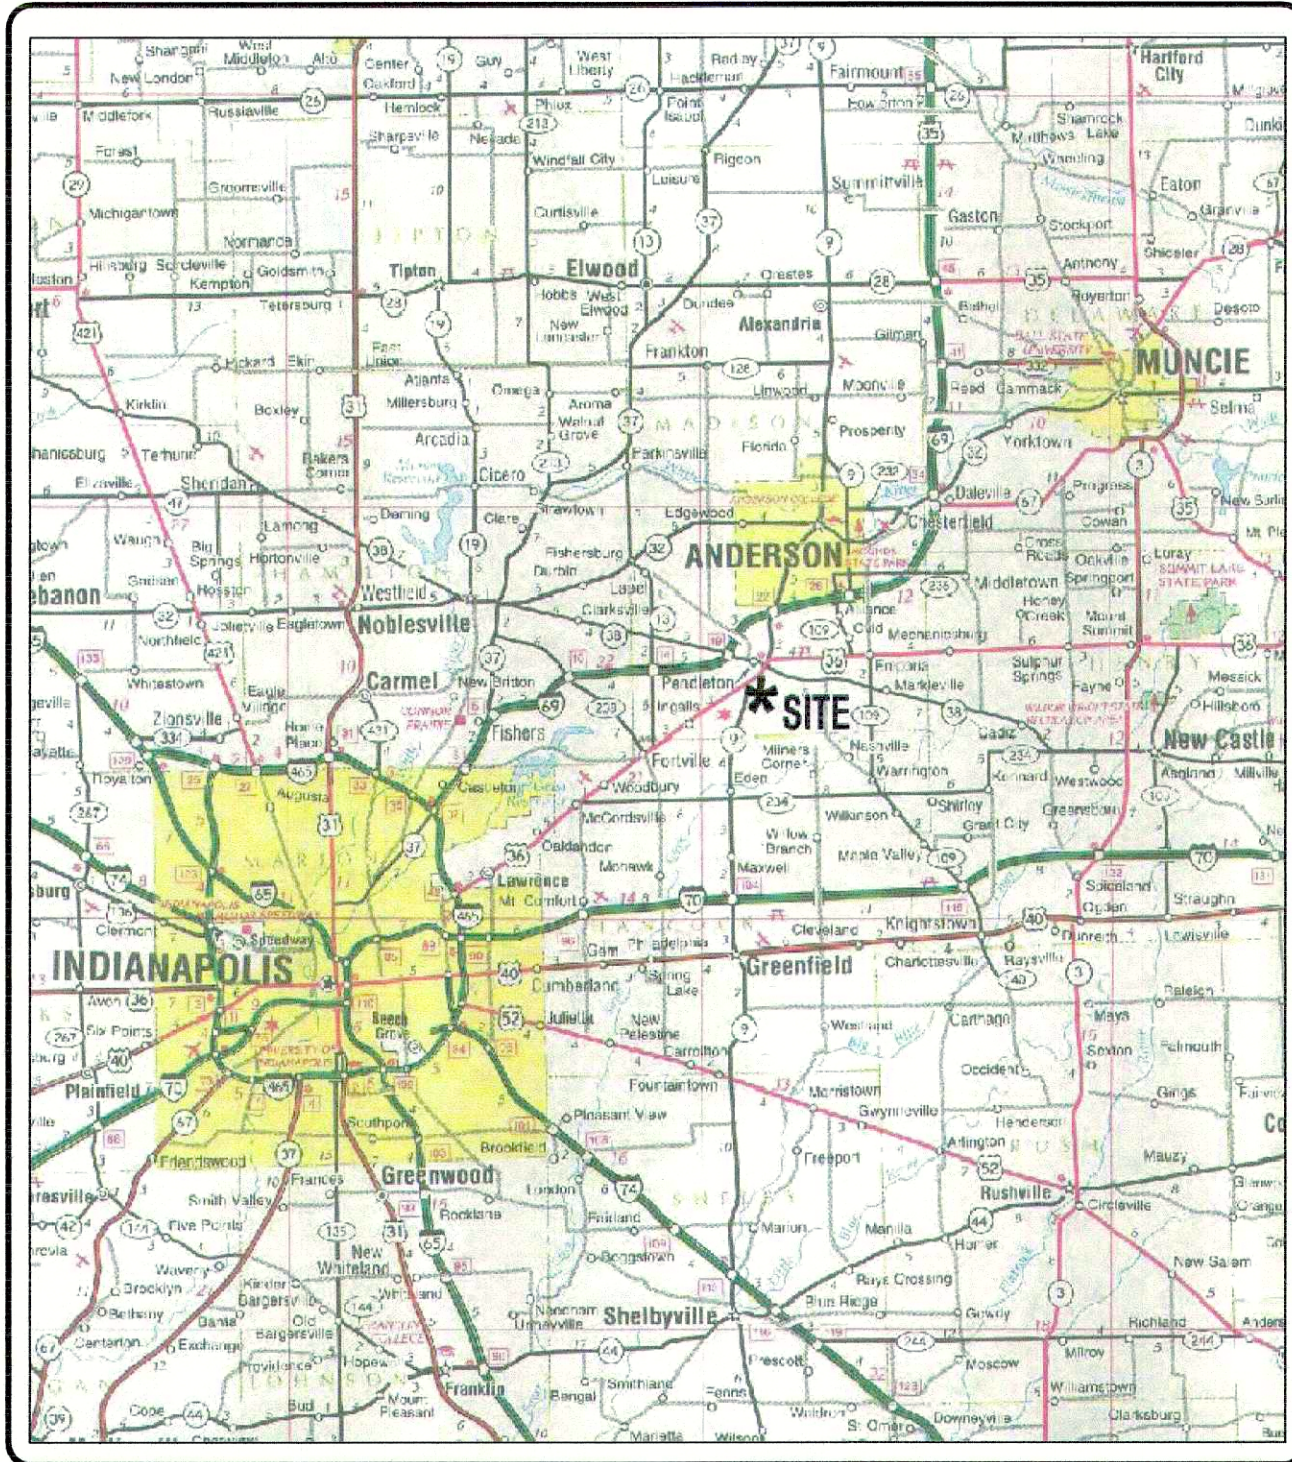

Location Map
State of Indiana Highway Map

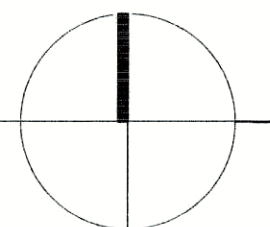

INDEX OF DRAWINGS	
Sheet No.	Description
1	Title Sheet
2	Standard Specifications
3	Grading Plan
4	Street Plan-Profile, Cold Springs Drive (Line "CSDr"), Winding Brook Way (Line "WBW")
5	Street Plan-Profile, Fair Weather Drive (Line "FWD")
6	Street Plan-Profile, Elderberry Court (Line "ECt")
7	Intersection Details / Cul-de-sac Street Details
8	Sanitary Plan-Profile, Lines "SSc", "SSc", "SSK"
9	Sanitary Plan-Profile, Lines "SSc"
10	Sanitary Plan-Profile, Lines "SSc", "SSC"
11	Storm Drainage Plan-Profile, Structure Series 100 (Strs #100-110)
12	Storm Drainage Plan-Profile, Structure Series 200, 100 (Strs #111 - 123)
13	Waterline Plan
14	Standard Details-Street / Waterline
15	Standard Details-Drainage
16	Standard Details-Sanitary
17	Erosion Control Plan-1
18	Erosion Control Details
Waterline Plan Contractors Notes	



REVISIONS		
Sheet #	Date	Description
3-13, 17	9/23/05	Revised per client; lot lines / numbering.

NOTES:

1. The construction standards for the Town of Pendleton (for streets, storm sewers and waterline) and Fall Creek Regional Waste District (for sanitary sewers) shall be used for all parts of this project.


Asbuilt Plans Cold Springs, Section 1 Huntzinger Farms PUD

Part of the Northwest & Southwest 1/4s, Section 28, Southeast & Northeast 1/4s,
Section 29, Township 18 North, Range 7 East
Town of Pendleton, Fall Creek Township, Madison County, Indiana

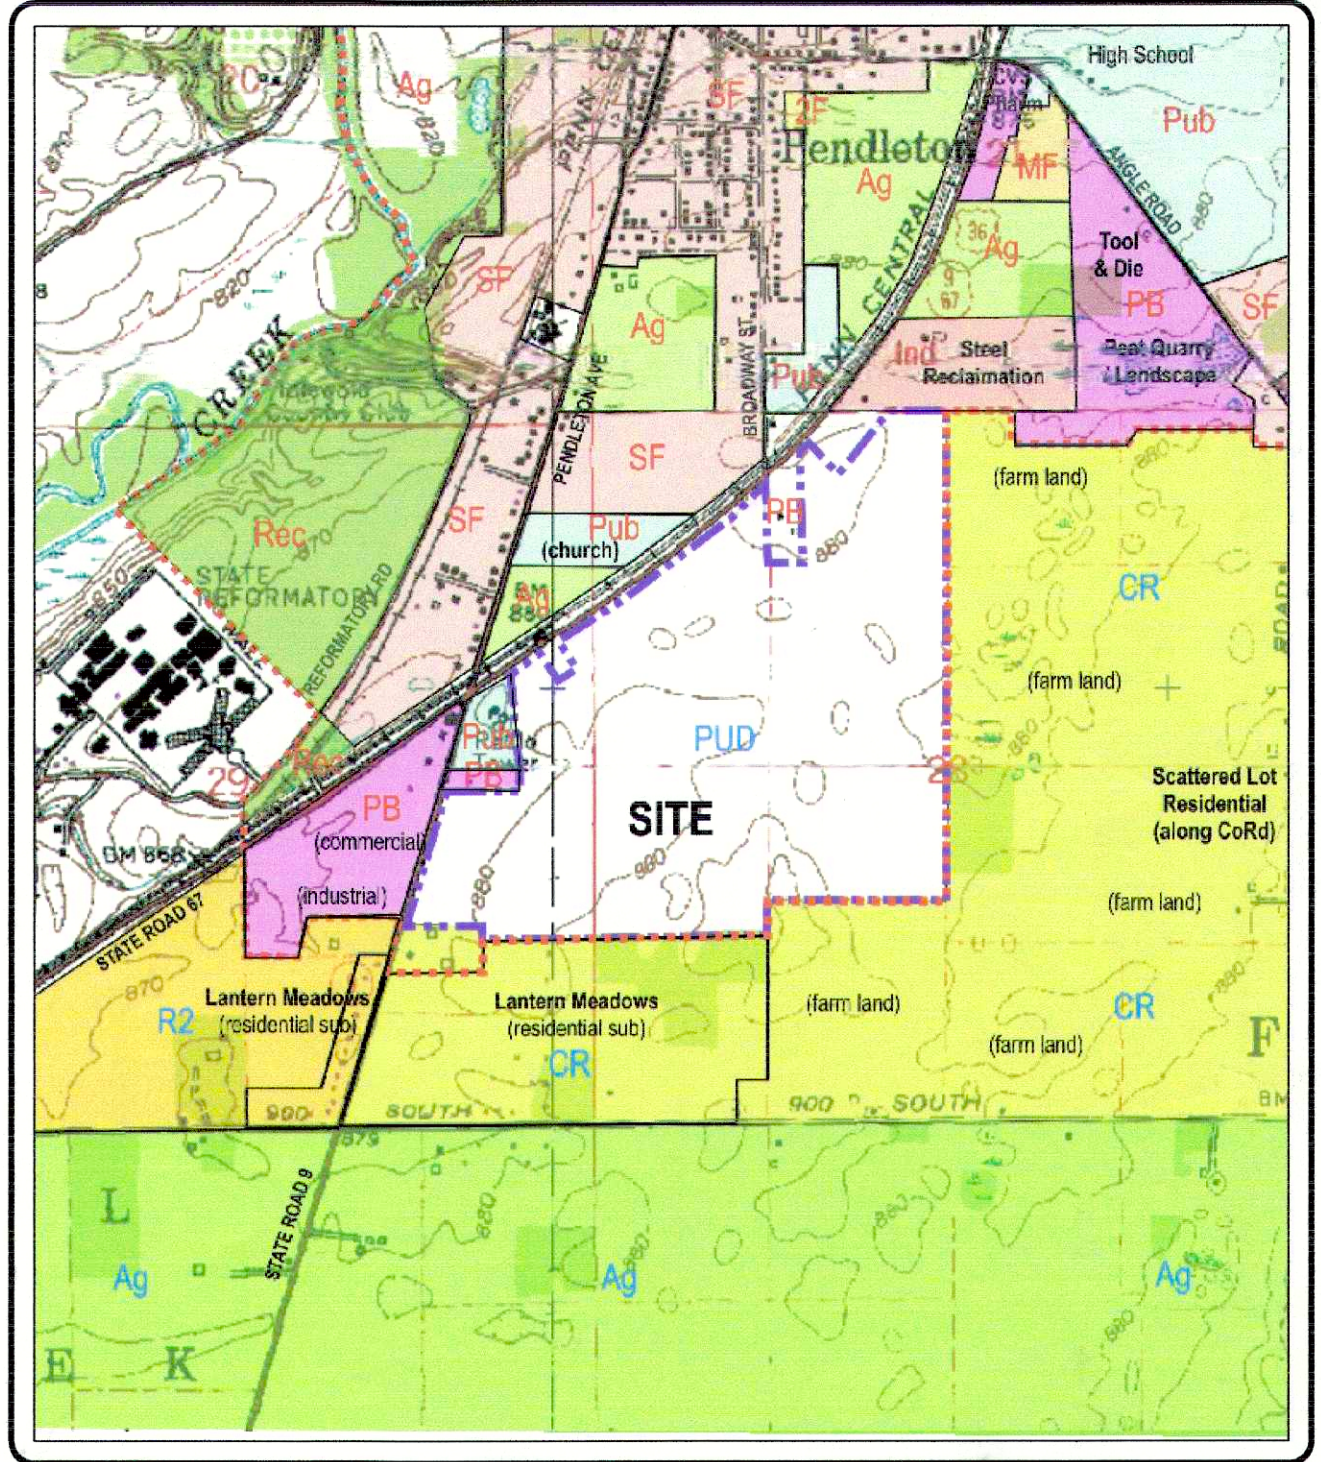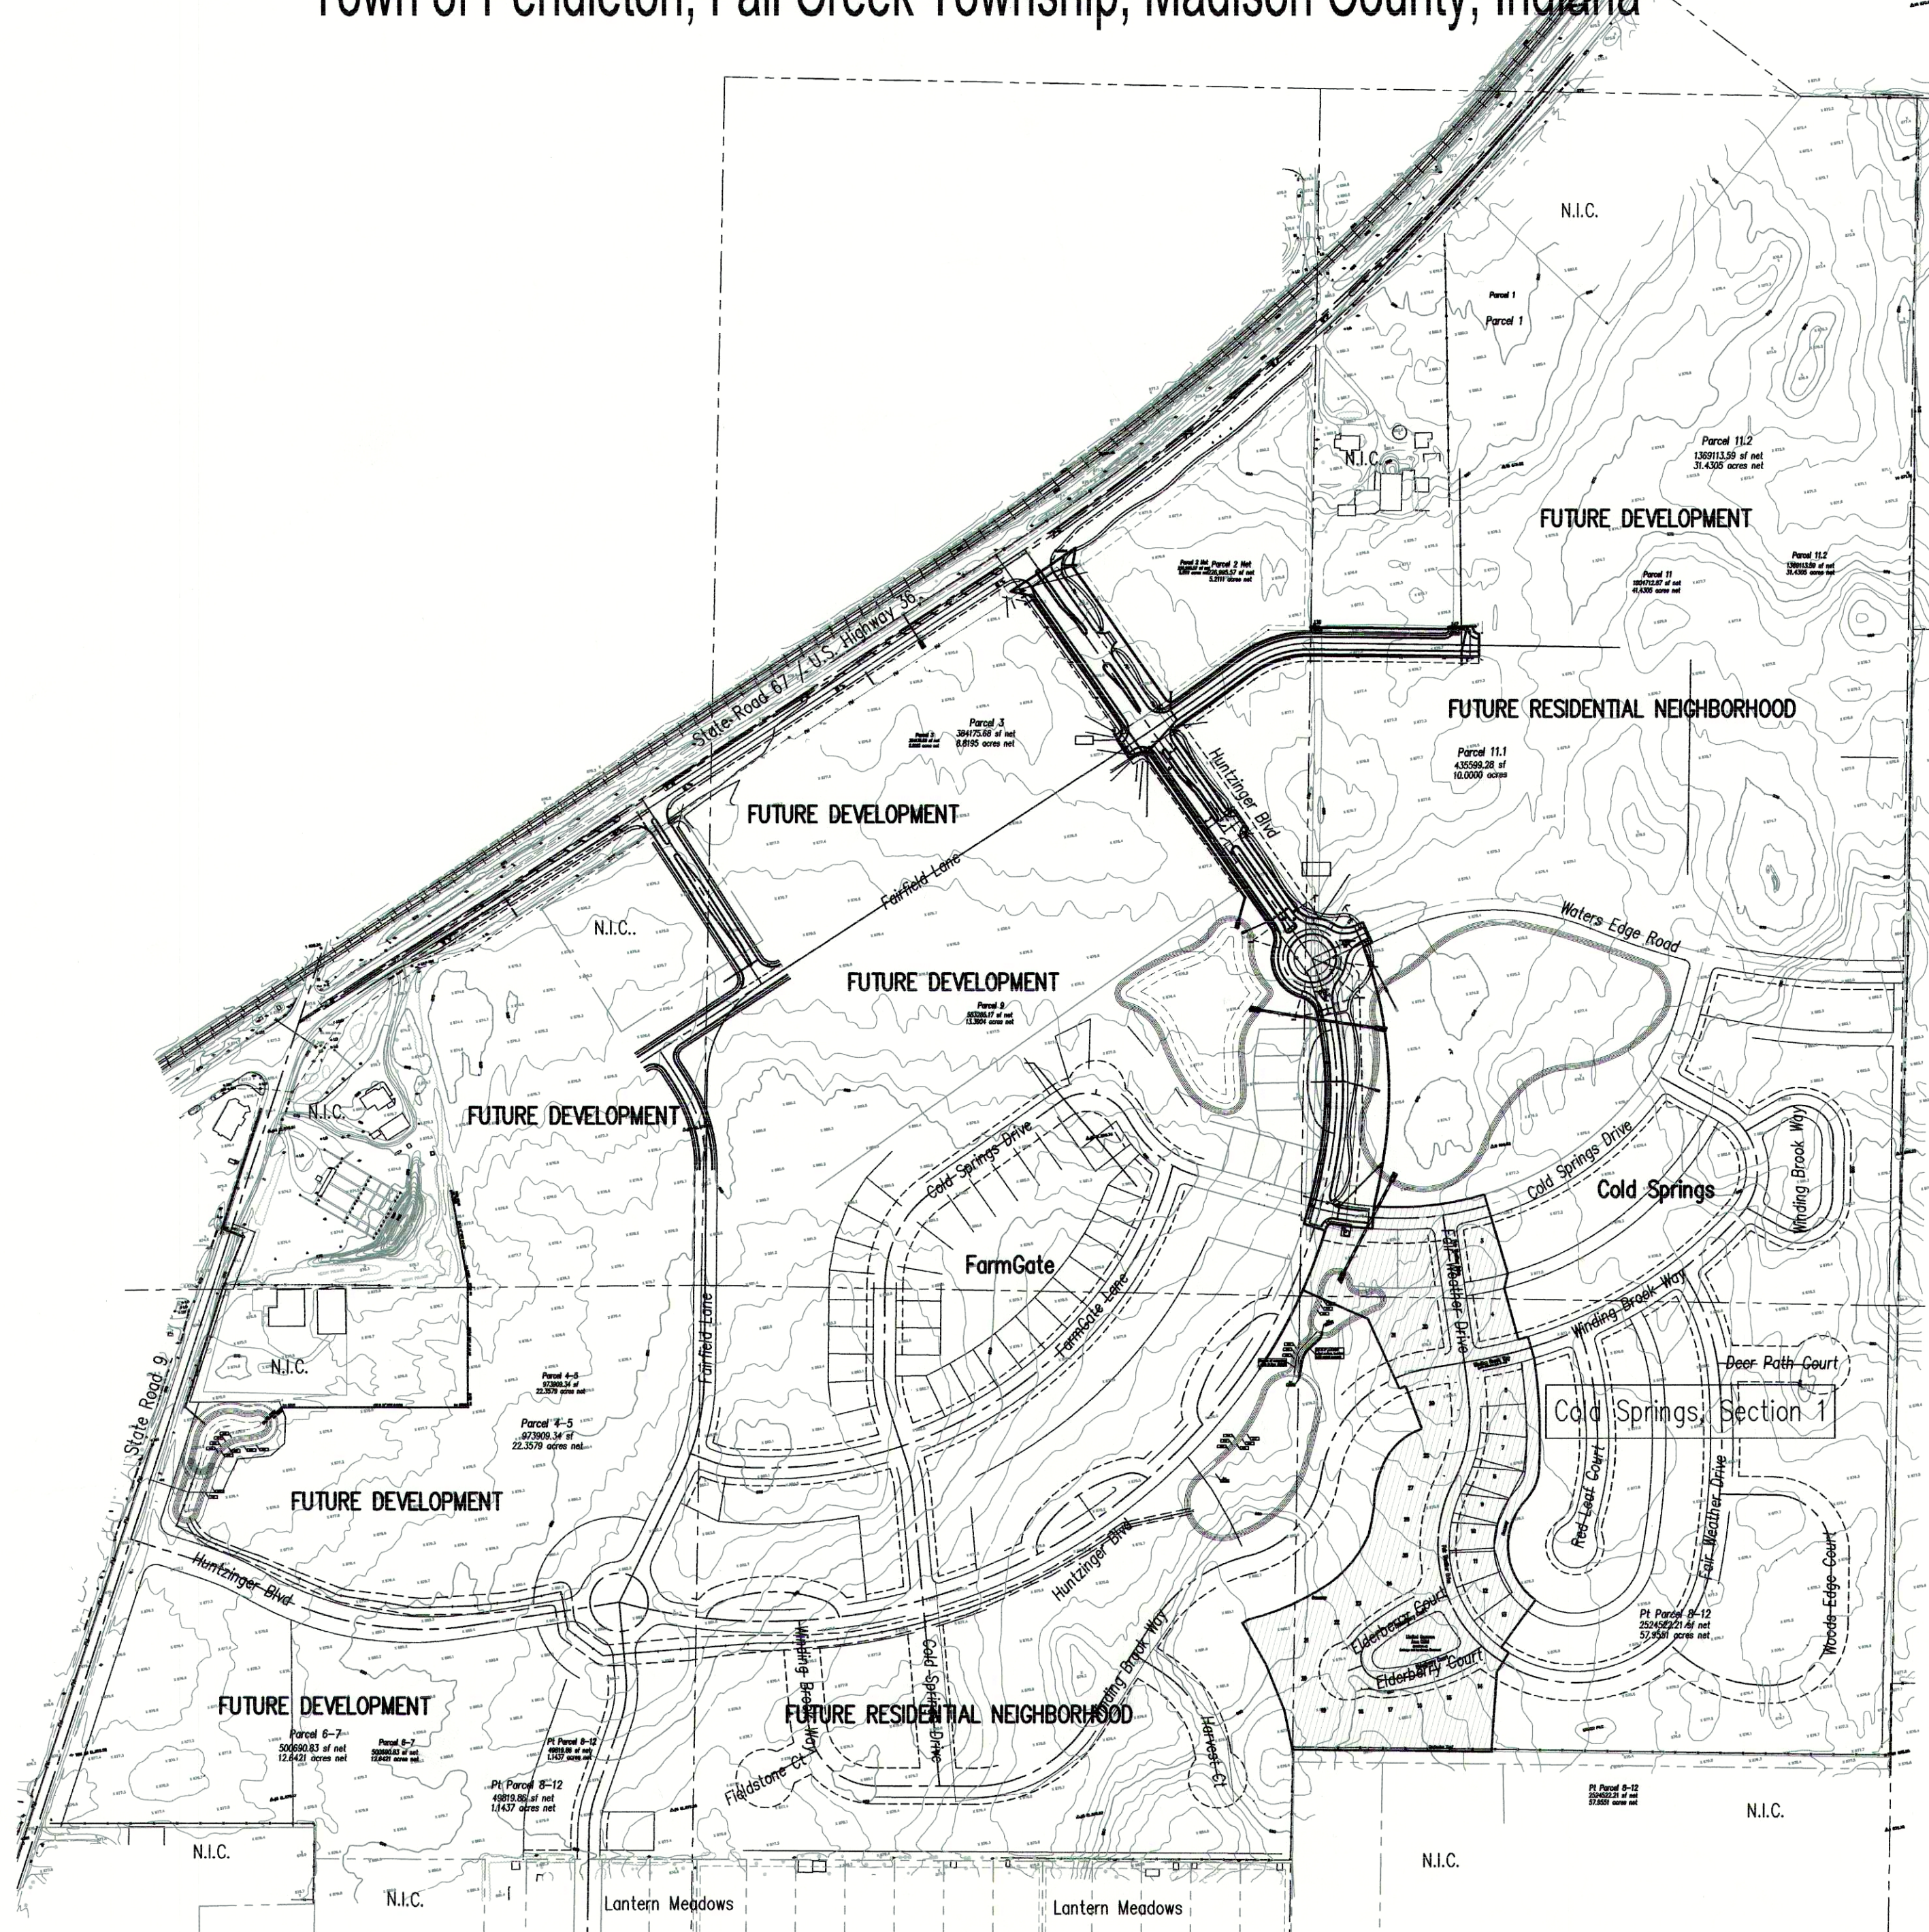

Area Map

USGS Quadrangle Maps:
Anderson North / Gilman / Middletown / Anderson South

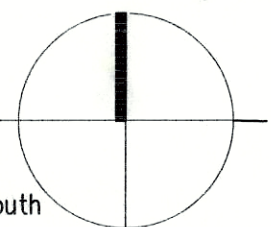

Project Data

Dedicated Street Lengths	
Fair Weather Drive (Line "FWD"):	1075.00 lft
Winding Brook Way (Line "WBW"):	300.00 lft
Cold Springs Drive (Line "CSDr"):	275.00 lft
Elderberry Court (Line "ECt"):	557.67 lft
Total: 2,207.67 lft	

prepared for: Pendleton Land Company, LLC
9449 Priority Way West Drive
Suite 120
Indianapolis, Indiana 46240
Tel: 317.705.2063
Fax: 317.705.2069

prepared by:

Pendleton
Consulting

P.O.Box 67 Pendleton, Indiana 46064
Phone (765) 778-4540 Fax 765-778-3571 email pendcon@netdirect.net

certified by:

Stephen E. Bourquein
Indiana Registered Professional Land Surveyor #S0441

