


Denotes approximate limits of granular backfill. Refer to respective specifications for exact limits and acceptable backfill materials.

NOTES:

1. Maintain a minimum of 18" of vertical separation per IDEM requirements.
2. Construct Cold Springs Drive (Line "CSDr") to the Neighborhood Collector Street Standard.
4. Construct Winding Brook Way (Line "WBW"), Elderberry Court (Line "ECt"), and Fair Weather Drive (Line "FWDr") to the Local Street Standards.

"WBW" denotes Winding Brook Way
"CSDr" denotes Cold Springs Drive
"ECt" denotes Elderberry Court
"FWDr" denotes Fair Weather Court
"SSC" denotes Sanitary Sewer Line "C"
"SSD" denotes Sanitary Sewer Line "D"
"SSE" denotes Sanitary Sewer Line "E"
"SSF" denotes Sanitary Sewer Line "F"
"SSG" denotes Sanitary Sewer Line "G"
"SSK" denotes Sanitary Sewer Line "K"


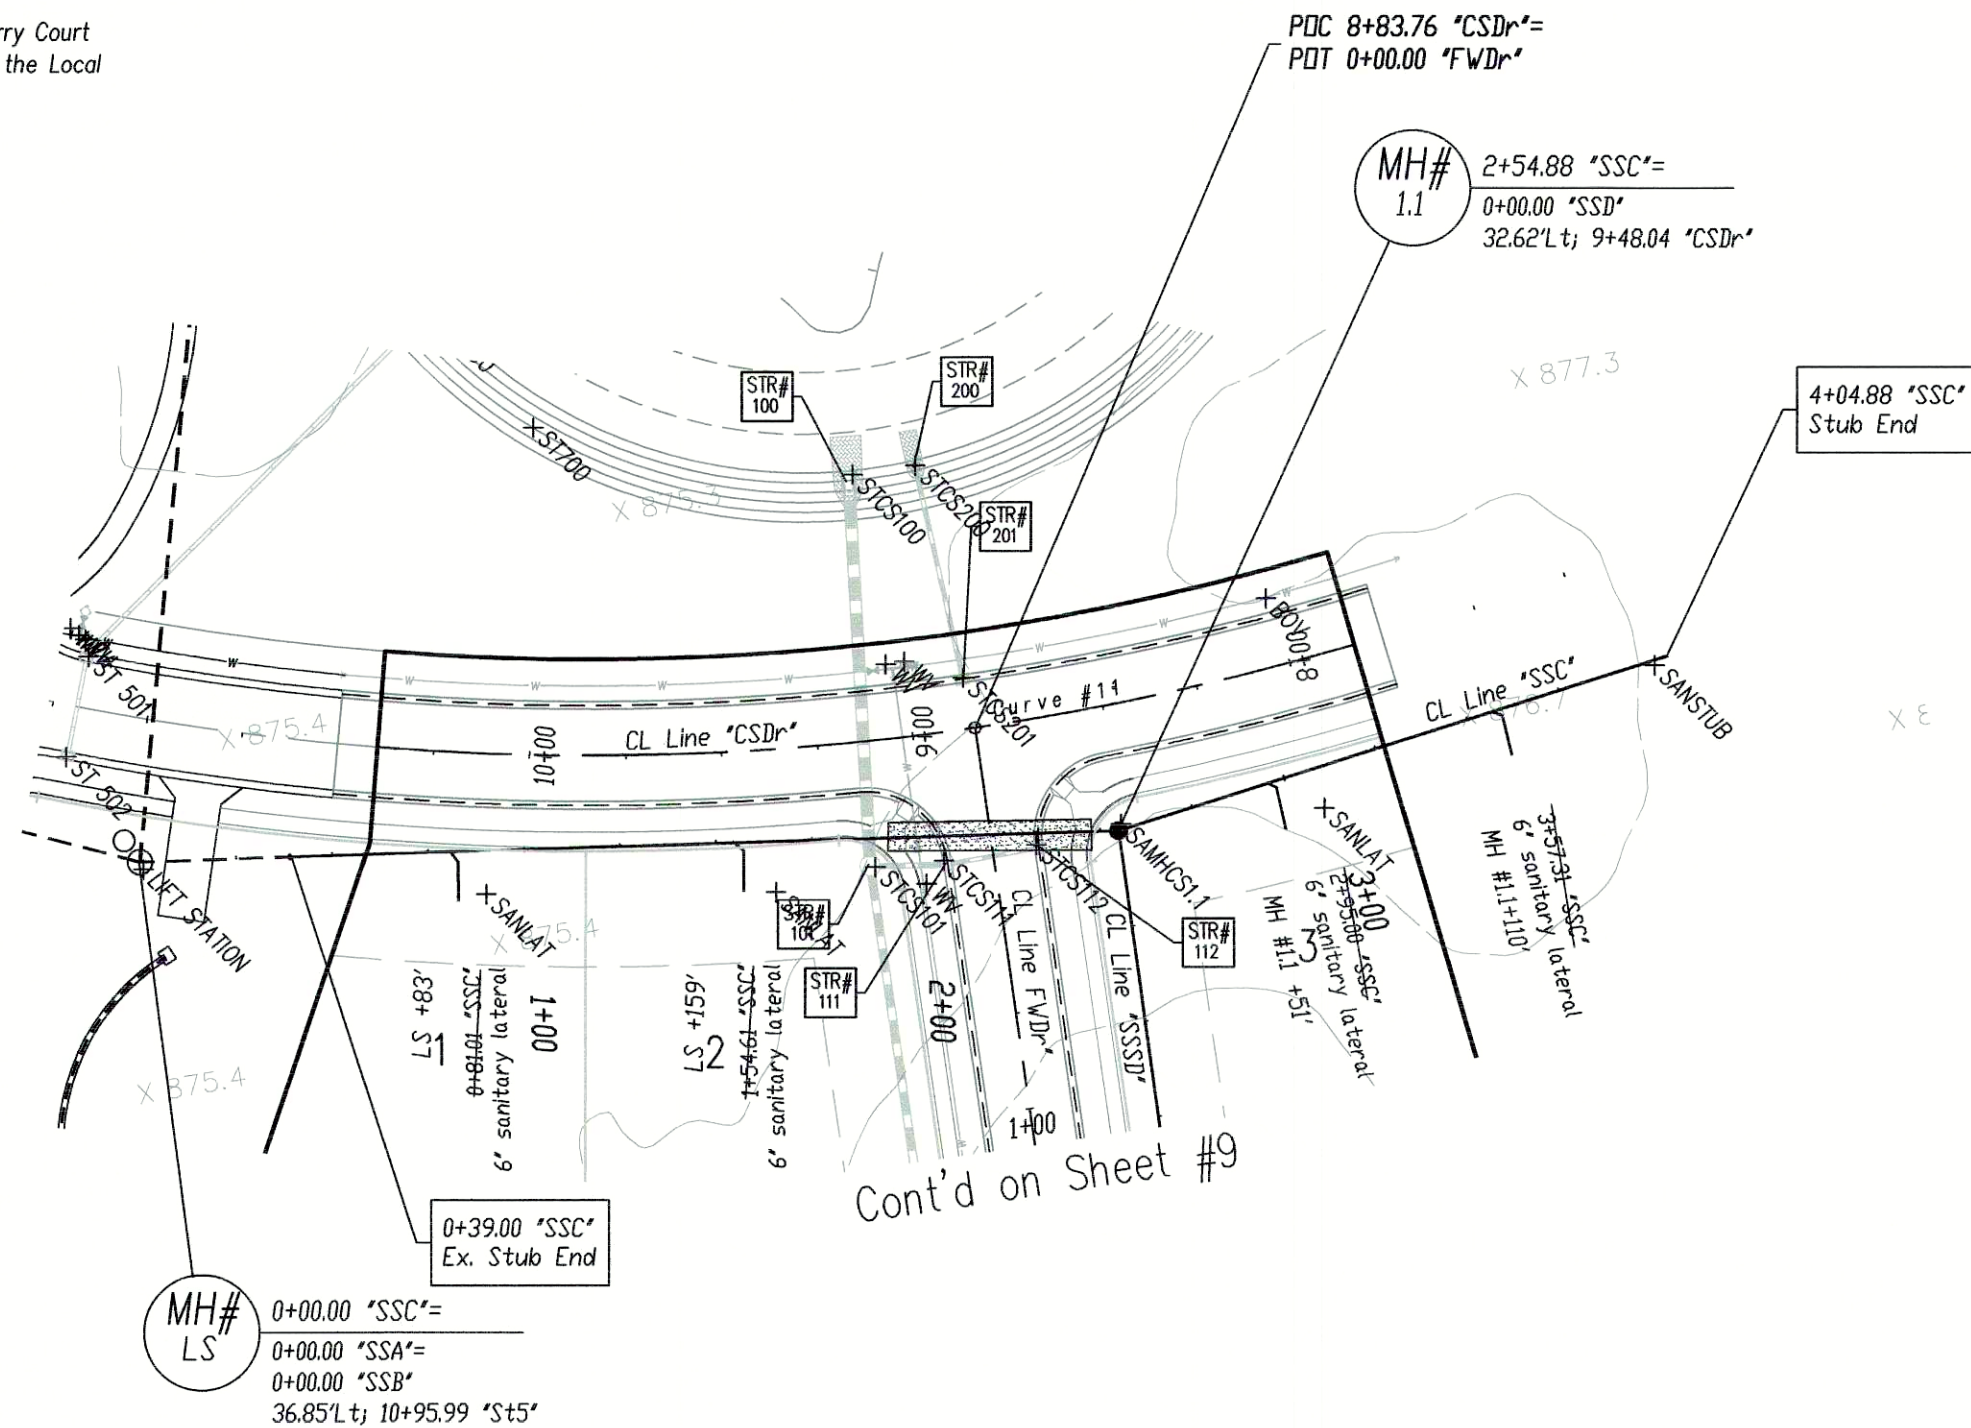


Scale:

Hor: 1"=50'

Ver: 1"=5'

Line "SSC"

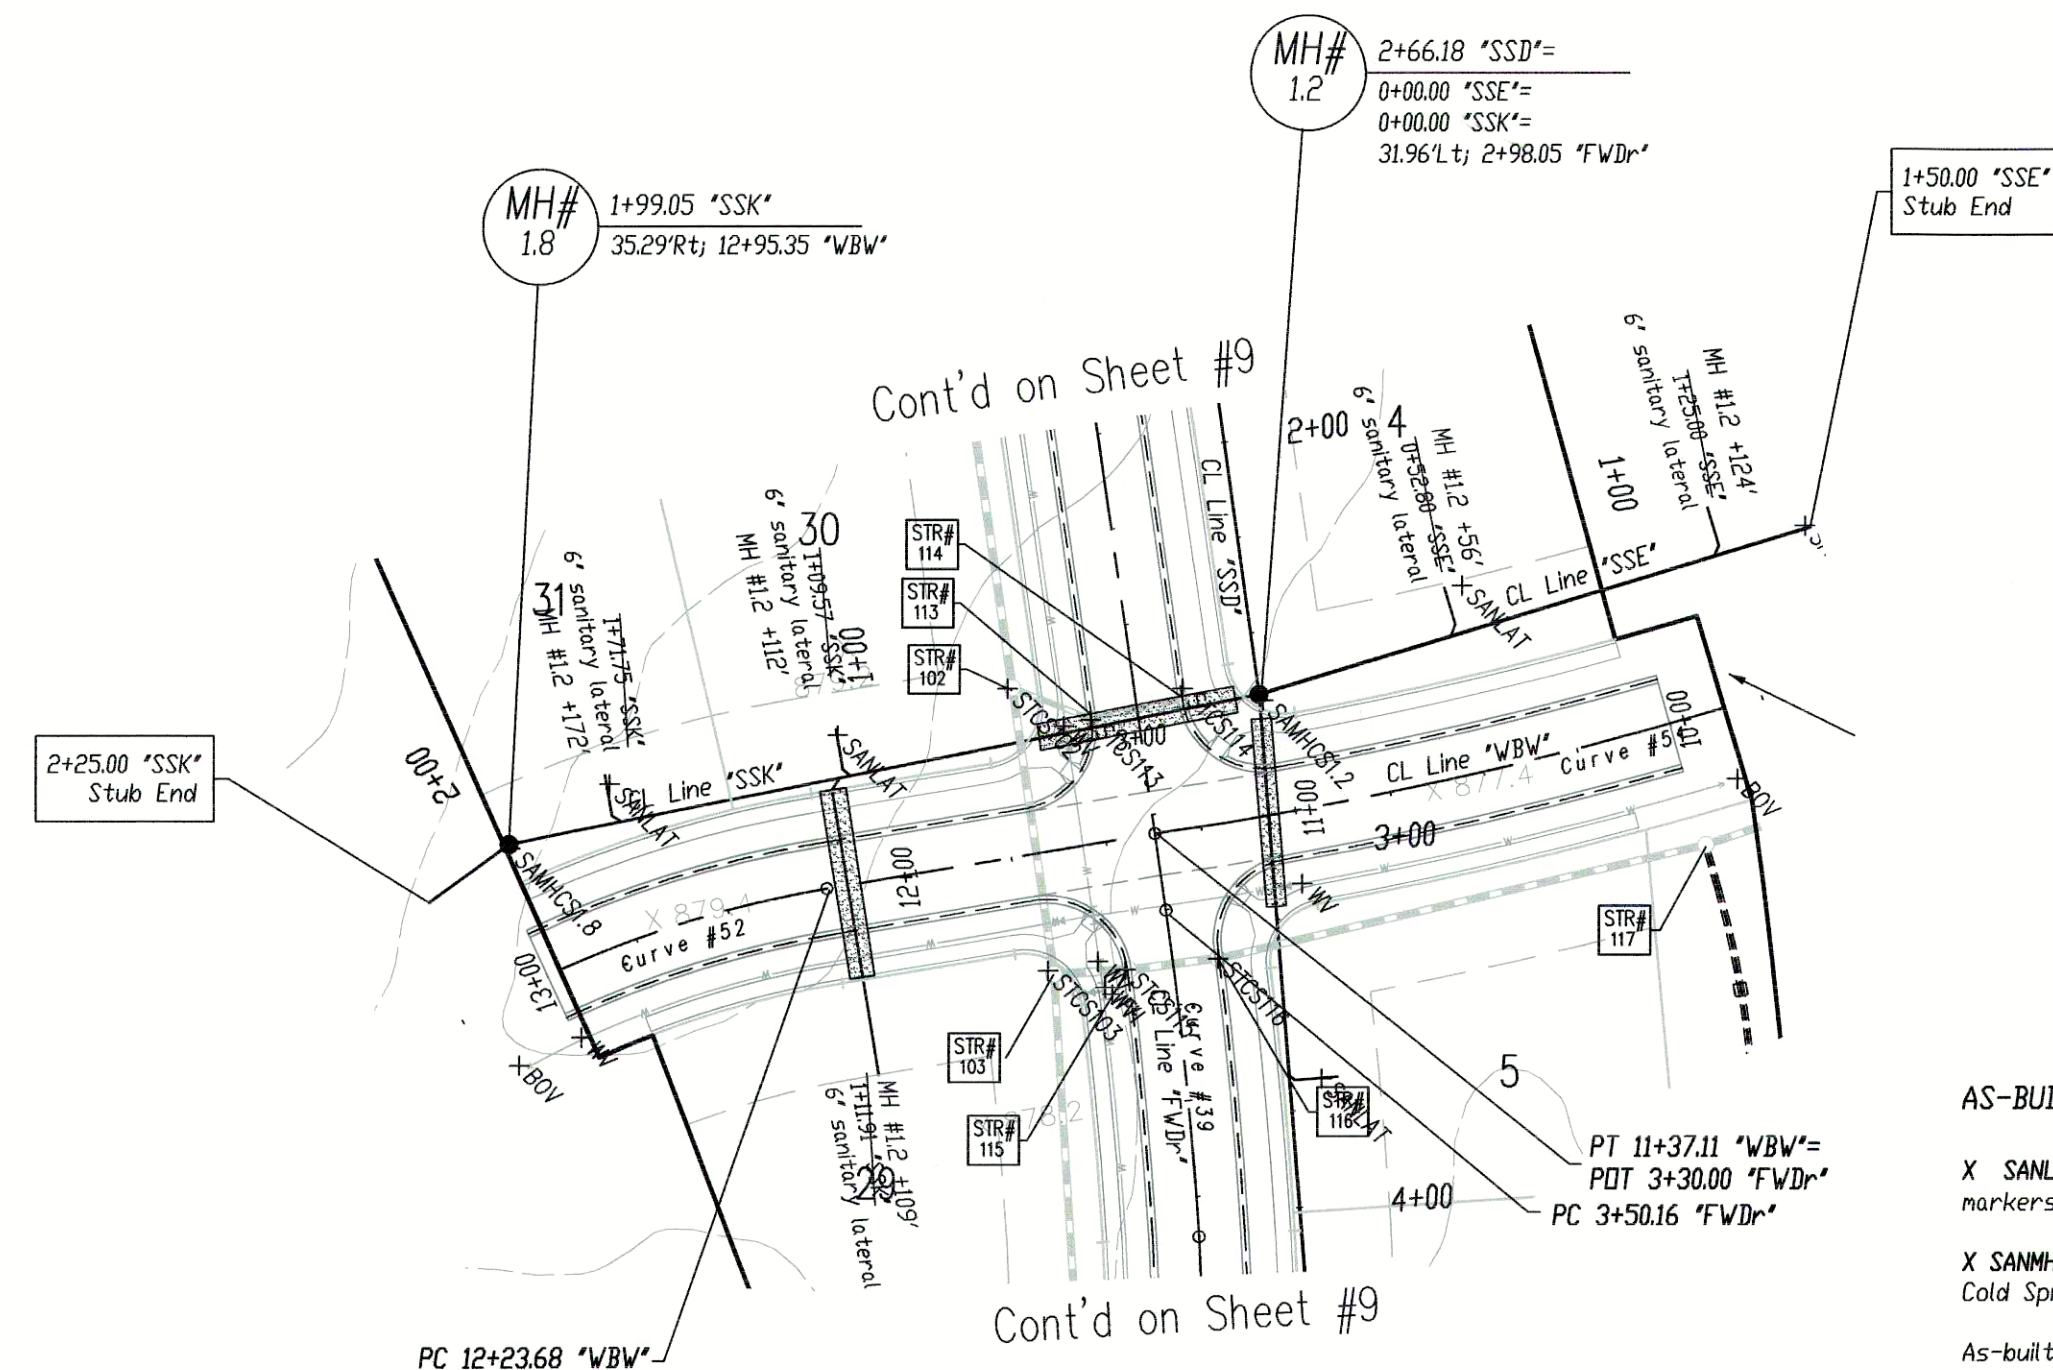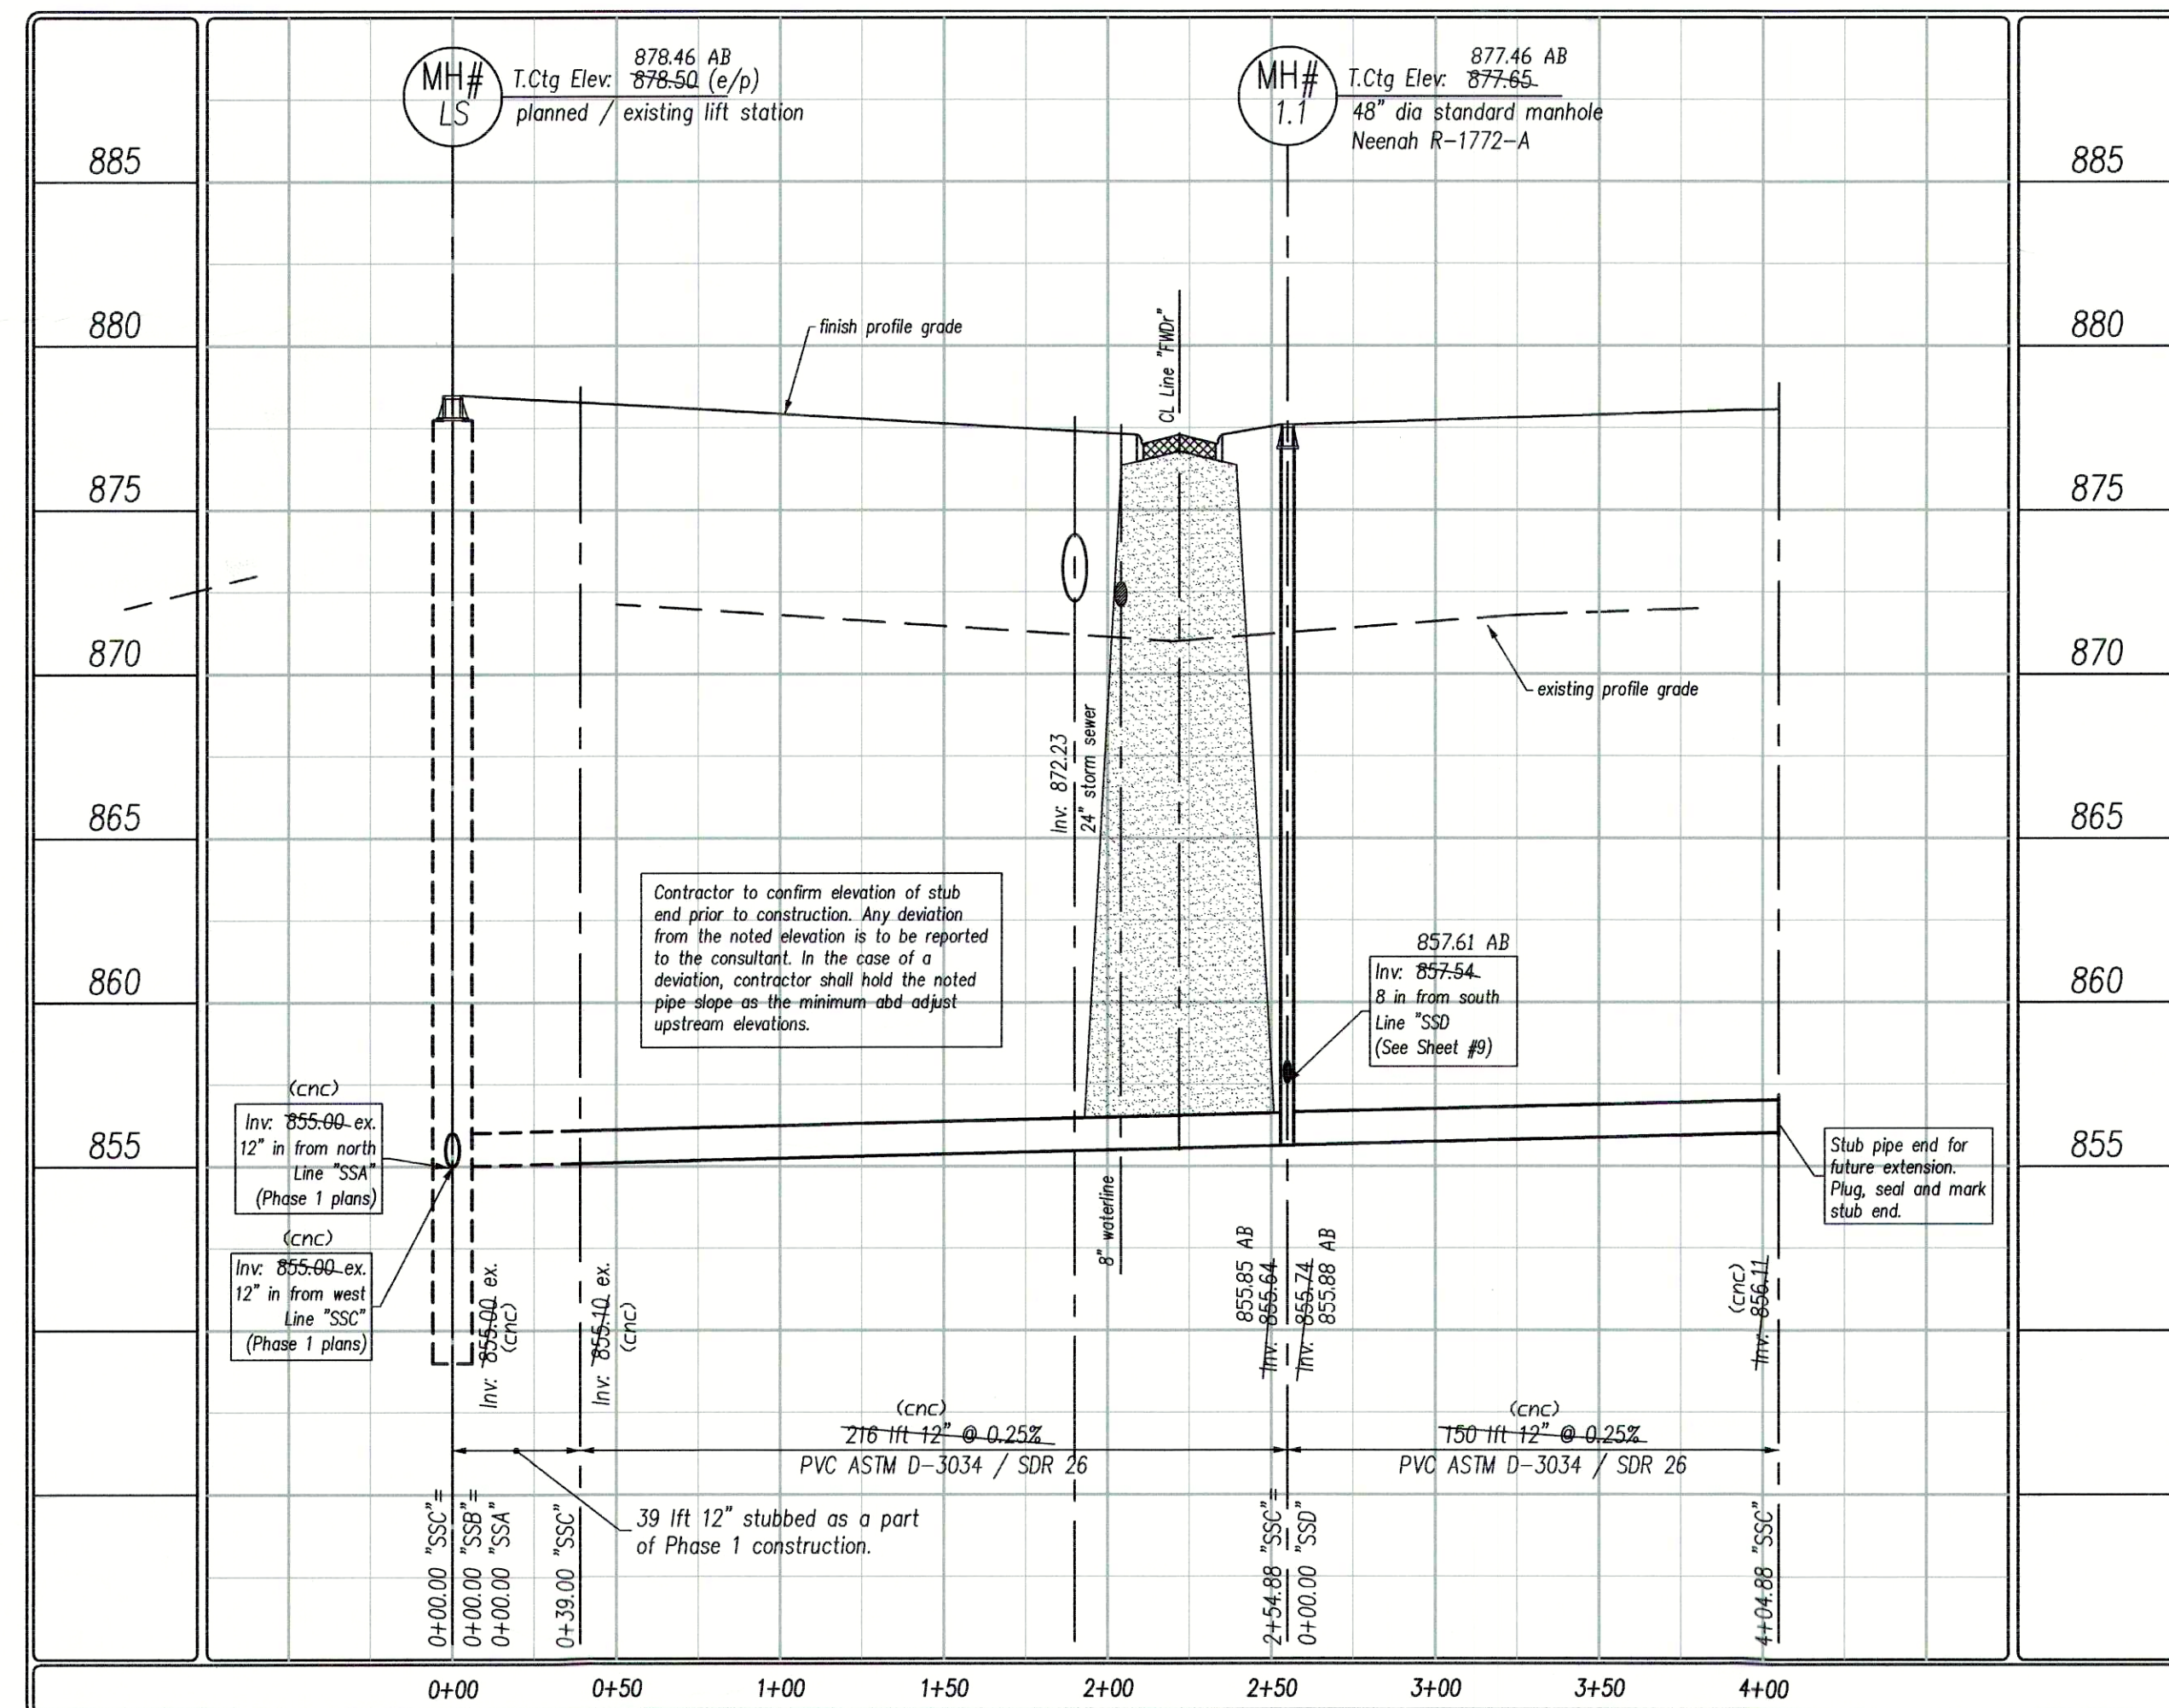

AS-BUILT NOTES:

X SANLAT denotes field location of sanitary lateral markers

X SANMCSXX denotes field location of a manhole in Cold Springs XX denotes the manhole number

As-built locations of the sanitary lateral tees are denoted as distances from the downstream manhole, in line with the next upstream manhole.

X WV denotes field location of water valve.

X BDV denotes field location of blow-off valve


X FH denotes field location of Fire Hydrant

See As-built Plan notes from contractor for measured locations of tees, elts, valves, hydrants and other fittings from street centerline intersections.

X STCSXXX denotes field location of storm structure in Cold Springs xxx denotes the structure number.

(cnc) denotes "could not confirm"

Line "SSE" / "SSK"

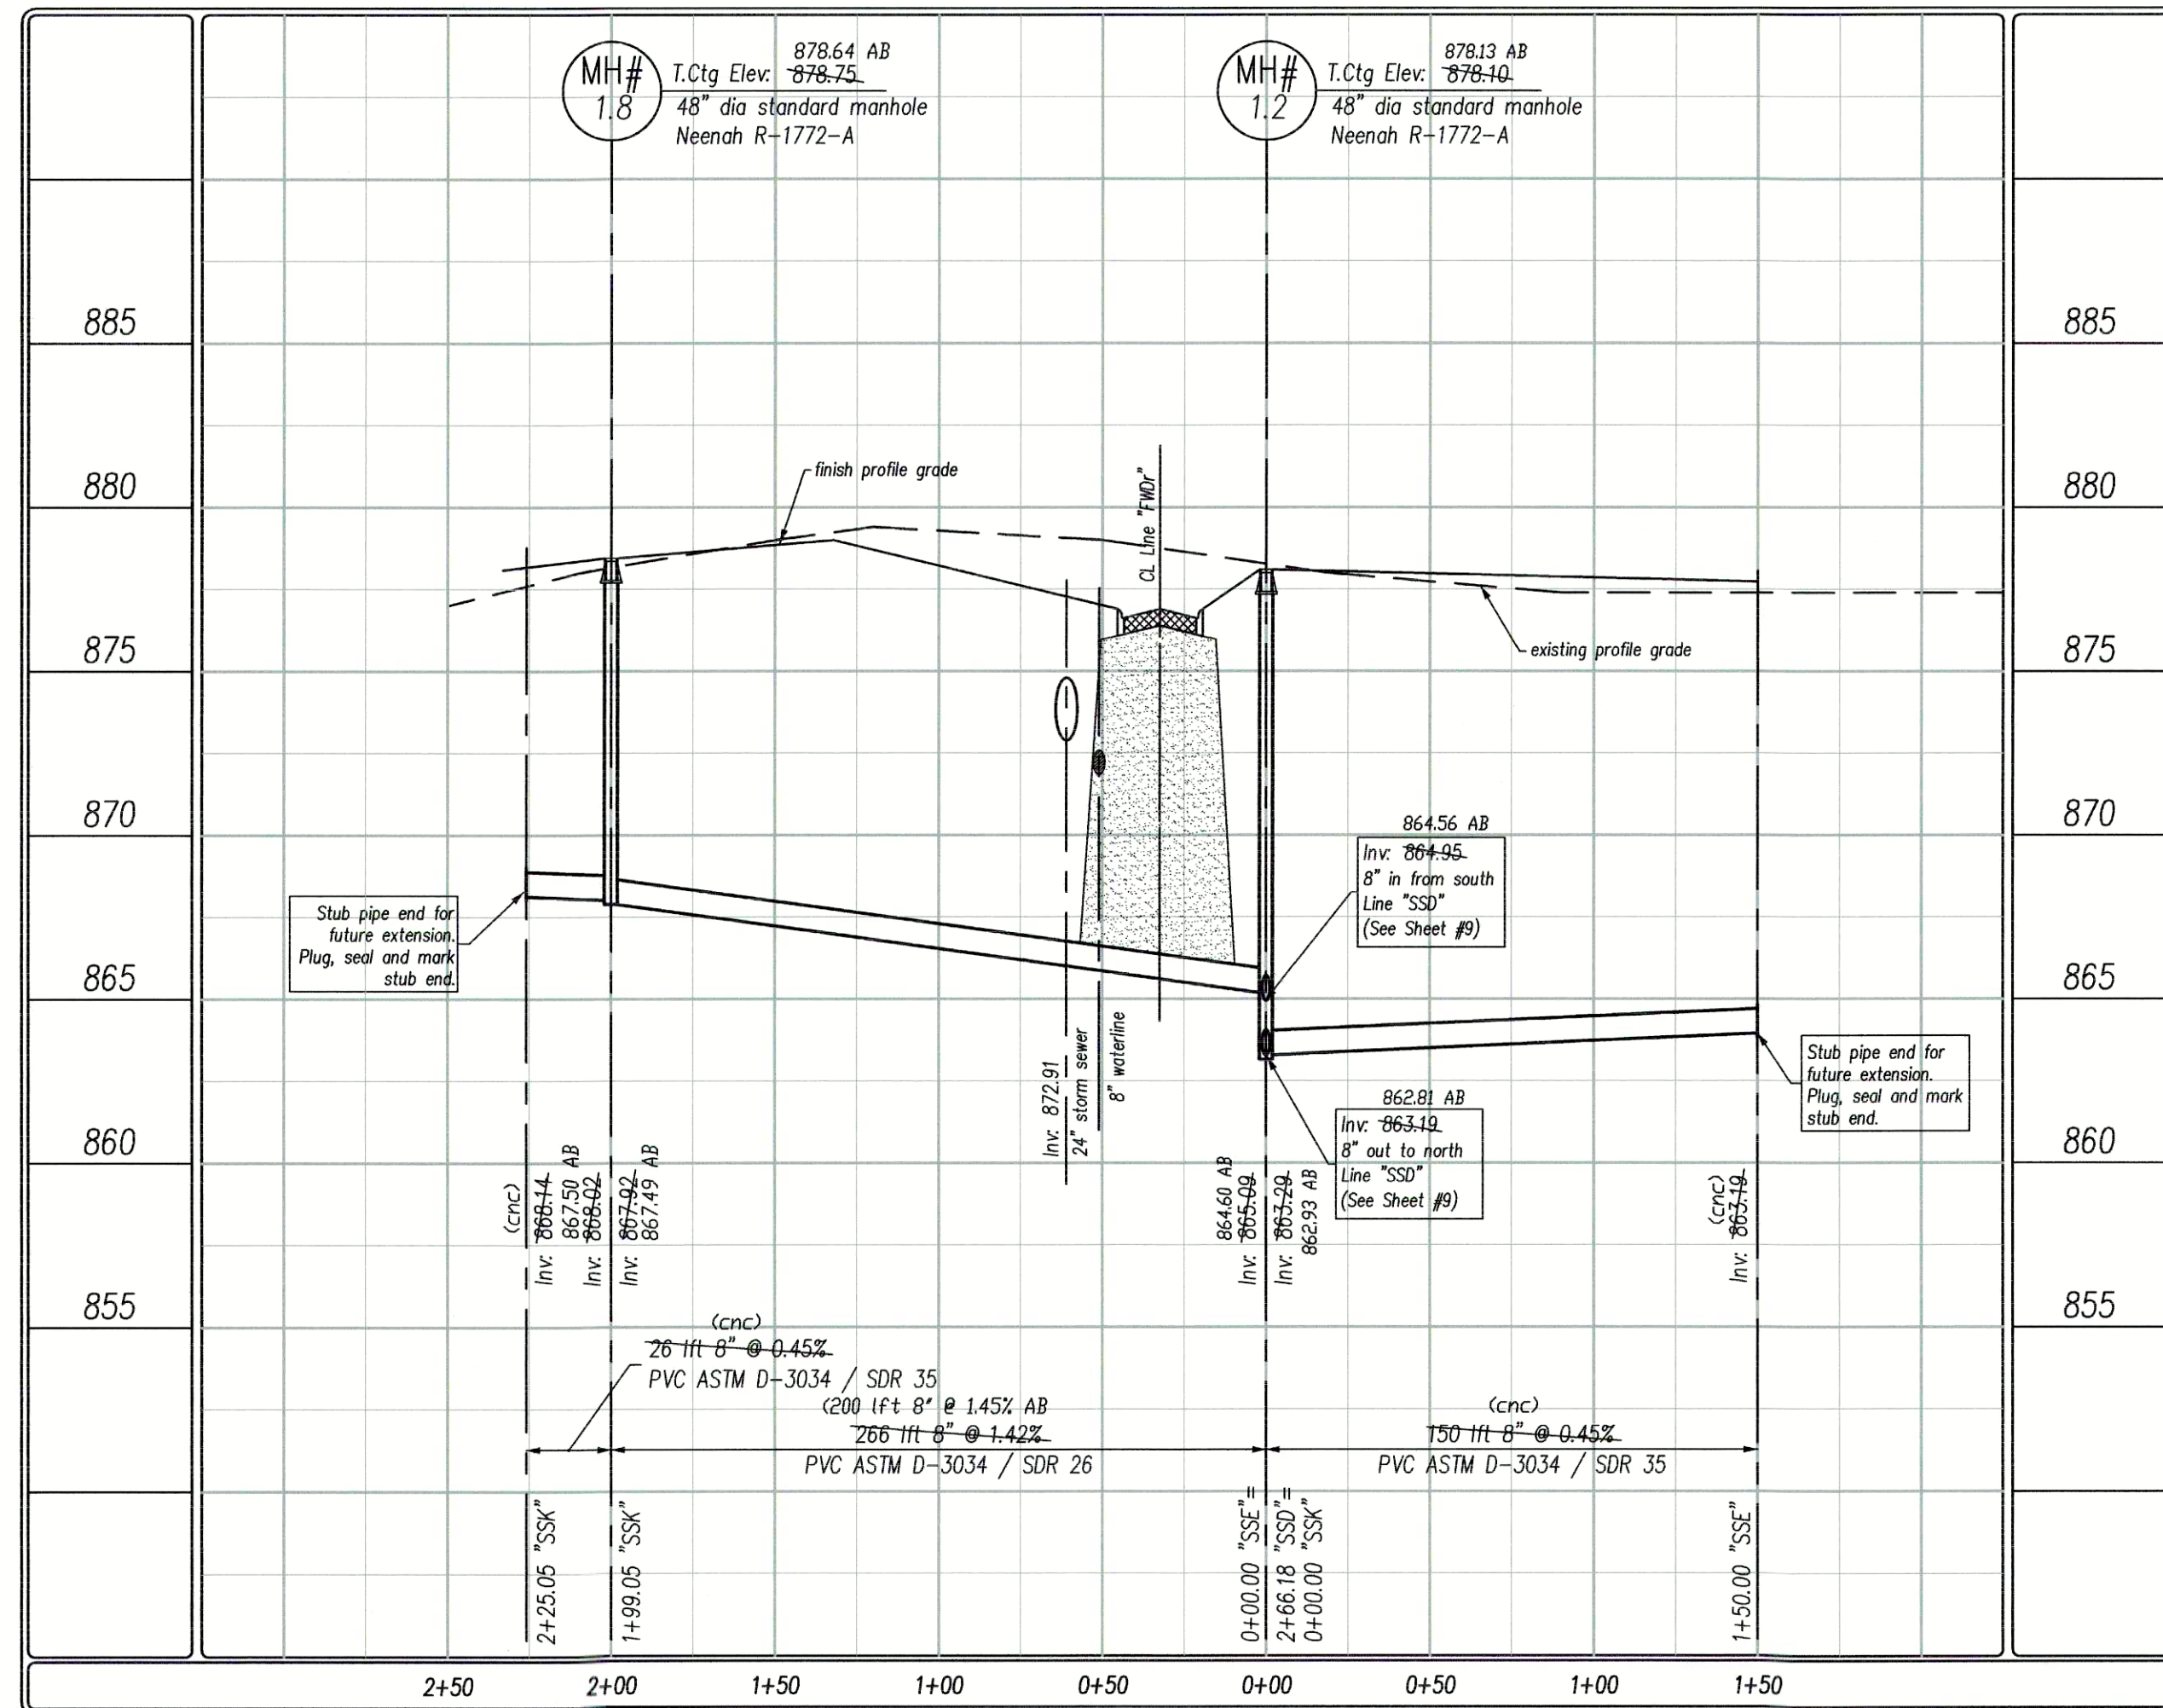


PER INDIANA STATE LAW IS-69-1991, IT IS AGAINST THE LAW TO EXCAVATE WITHOUT NOTIFYING THE UNDERGROUND LOCATION SERVICE TWO (2) WORKING DAYS BEFORE COMMENCING WORK.

WITHIN INDIANA
1-800-382-5544
FROM OUTSIDE INDIANA:
1-800-428-5200

ELECTRIC RED
GAS-OIL YELLOW
COMMUNICATIONS ORANGE
WATER BLUE
SEWER GREEN
PROPOSED EXCAVATION WHITE

THE INFORMATION NEEDED WHEN CALLING INDIANA UNDERGROUND PLANT PROTECTION SERVICES, INC. IS AS FOLLOWS:
COUNTY AND TOWNSHIP
STREET ADDRESS
TYPE OF WORK
EXTENT OF WORK
NAME OF CALLER AND TITLE
TELEPHONE NUMBER
BEST TIME TO CALL
DATE AND START TIME
CONTRACTOR NAME AND ADDRESS

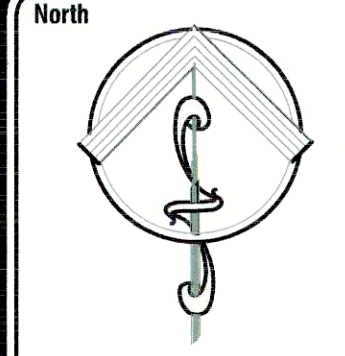

Scale: 1"=50'

Pendleton Consulting
P.O. Box 67 Pendleton, Indiana 46064
Phone: 765-778-4540 Fax: 765-778-3571
email: pendcon@netdirect.net


Pendleton Land Company, LLC
9449 Priority Way West Drive
Suite 120
Indianapolis, Indiana 46240
Phone: 317-585-1885 Fax: 317-705-2088

Date: 8/08/04

Revised per client lot lines / numbering.

Date: 9/23/05

Cold Springs at Huntzinger Farms
Section 1
Pendleton, Madison County, Indiana
Sanitary Plan - Profile
Lines "SSC", "SSE" & "SSK"

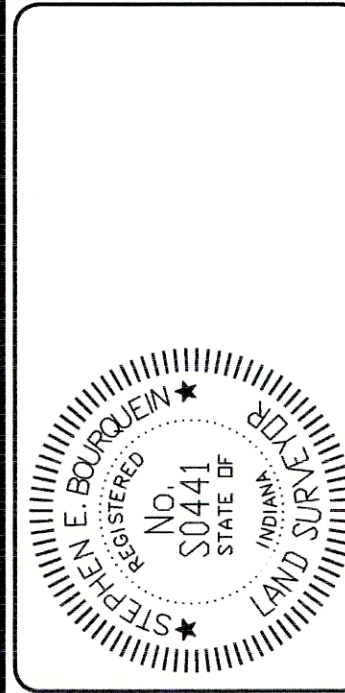

Sheet No.

8
18 Sheets

As-built Plans