


Denotes approximate limits of granular backfill. Refer to respective specifications for exact limits and acceptable backfill materials.

NOTES:

1. Maintain a minimum of 18" of vertical separation per IDEM requirements.
2. Construct Cold Springs Drive (Line "SSD") to the Neighborhood Collector Street Standard.
4. Construct Winding Brook Way (Line "WBW"), Elderberry Court (Line "EC"), and Fair Weather Drive (Line "FWD") to the Local Street Standards.

'WBW' denotes Winding Brook Way
'SSD' denotes Sanitary Sewer Line 'D'
'SSC' denotes Sanitary Sewer Line 'E'
'SSF' denotes Sanitary Sewer Line 'F'
'SSG' denotes Sanitary Sewer Line 'G'
'SSK' denotes Sanitary Sewer Line 'K'

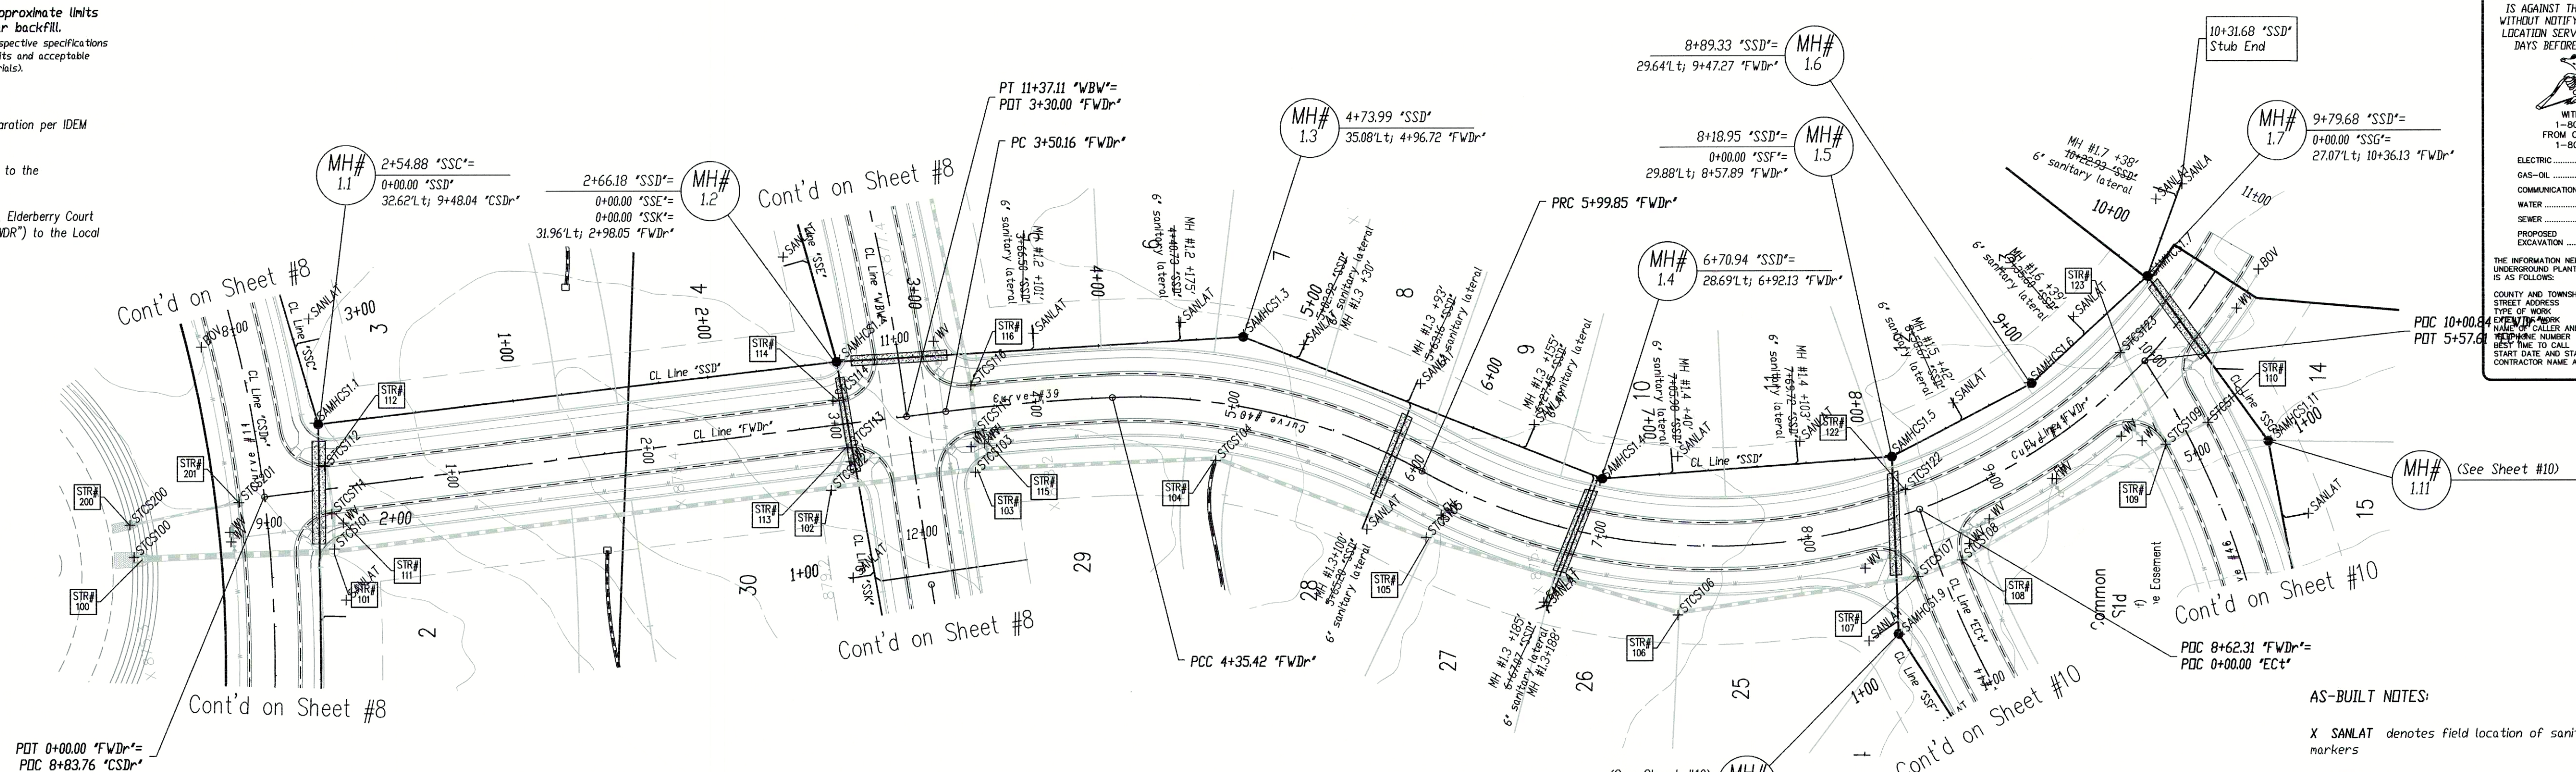

PER INDIANA STATE LAW IS-69-1991, IT IS AGAINST THE LAW TO EXCAVATE WITHOUT NOTIFYING THE UNDERGROUND LOCATION SERVICE TWO (2) WORKING DAYS BEFORE COMMENCING WORK.

WITHIN INDIANA:
1-800-382-5044
FROM OUTSIDE INDIANA:
1-800-428-5200

ELECTRIC.....RED
GAS-OIL.....YELLOW
COMMUNICATIONS.....ORANGE
WATER.....BLUE
SEWER.....GREEN
PROPOSED EXCAVATION.....WHITE

THE INFORMATION NEEDED WHEN CALLING INDIANA UNDERGROUND PLANT PROTECTION SERVICES, INC. IS AS FOLLOWS:

COUNTY AND TOWNSHIP
STREET ADDRESS
TYPE OF WORK
NAME OF CALLER AND TITLE
NEAREST CROSS STREET
BEST TIME TO CALL
START DATE AND START TIME
CONTRACTOR NAME AND ADDRESS

AS-BUILT NOTES:

X SANLAT denotes field location of sanitary lateral markers

X SANHCSXX denotes field location of a manhole in Cold Springs XX denotes the manhole number

As-built locations of the sanitary lateral tees are denoted as distances from the downstream manhole, in line with the next upstream manhole.

X WV denotes field location of water valve.

X BDV denotes field location of blow-off valve


X FH denotes field location of Fire Hydrant

See As-built Plan notes from contractor for measured locations of tees, els, valves, hydrants and other fittings from street centerline intersections.


X STCSxxx denotes field location of storm structure in Cold Springs xxx denotes the structure number.

(CNC) denotes 'could not confirm'

Scale:
Hor: 1"=50'
Ver: 1"=5'

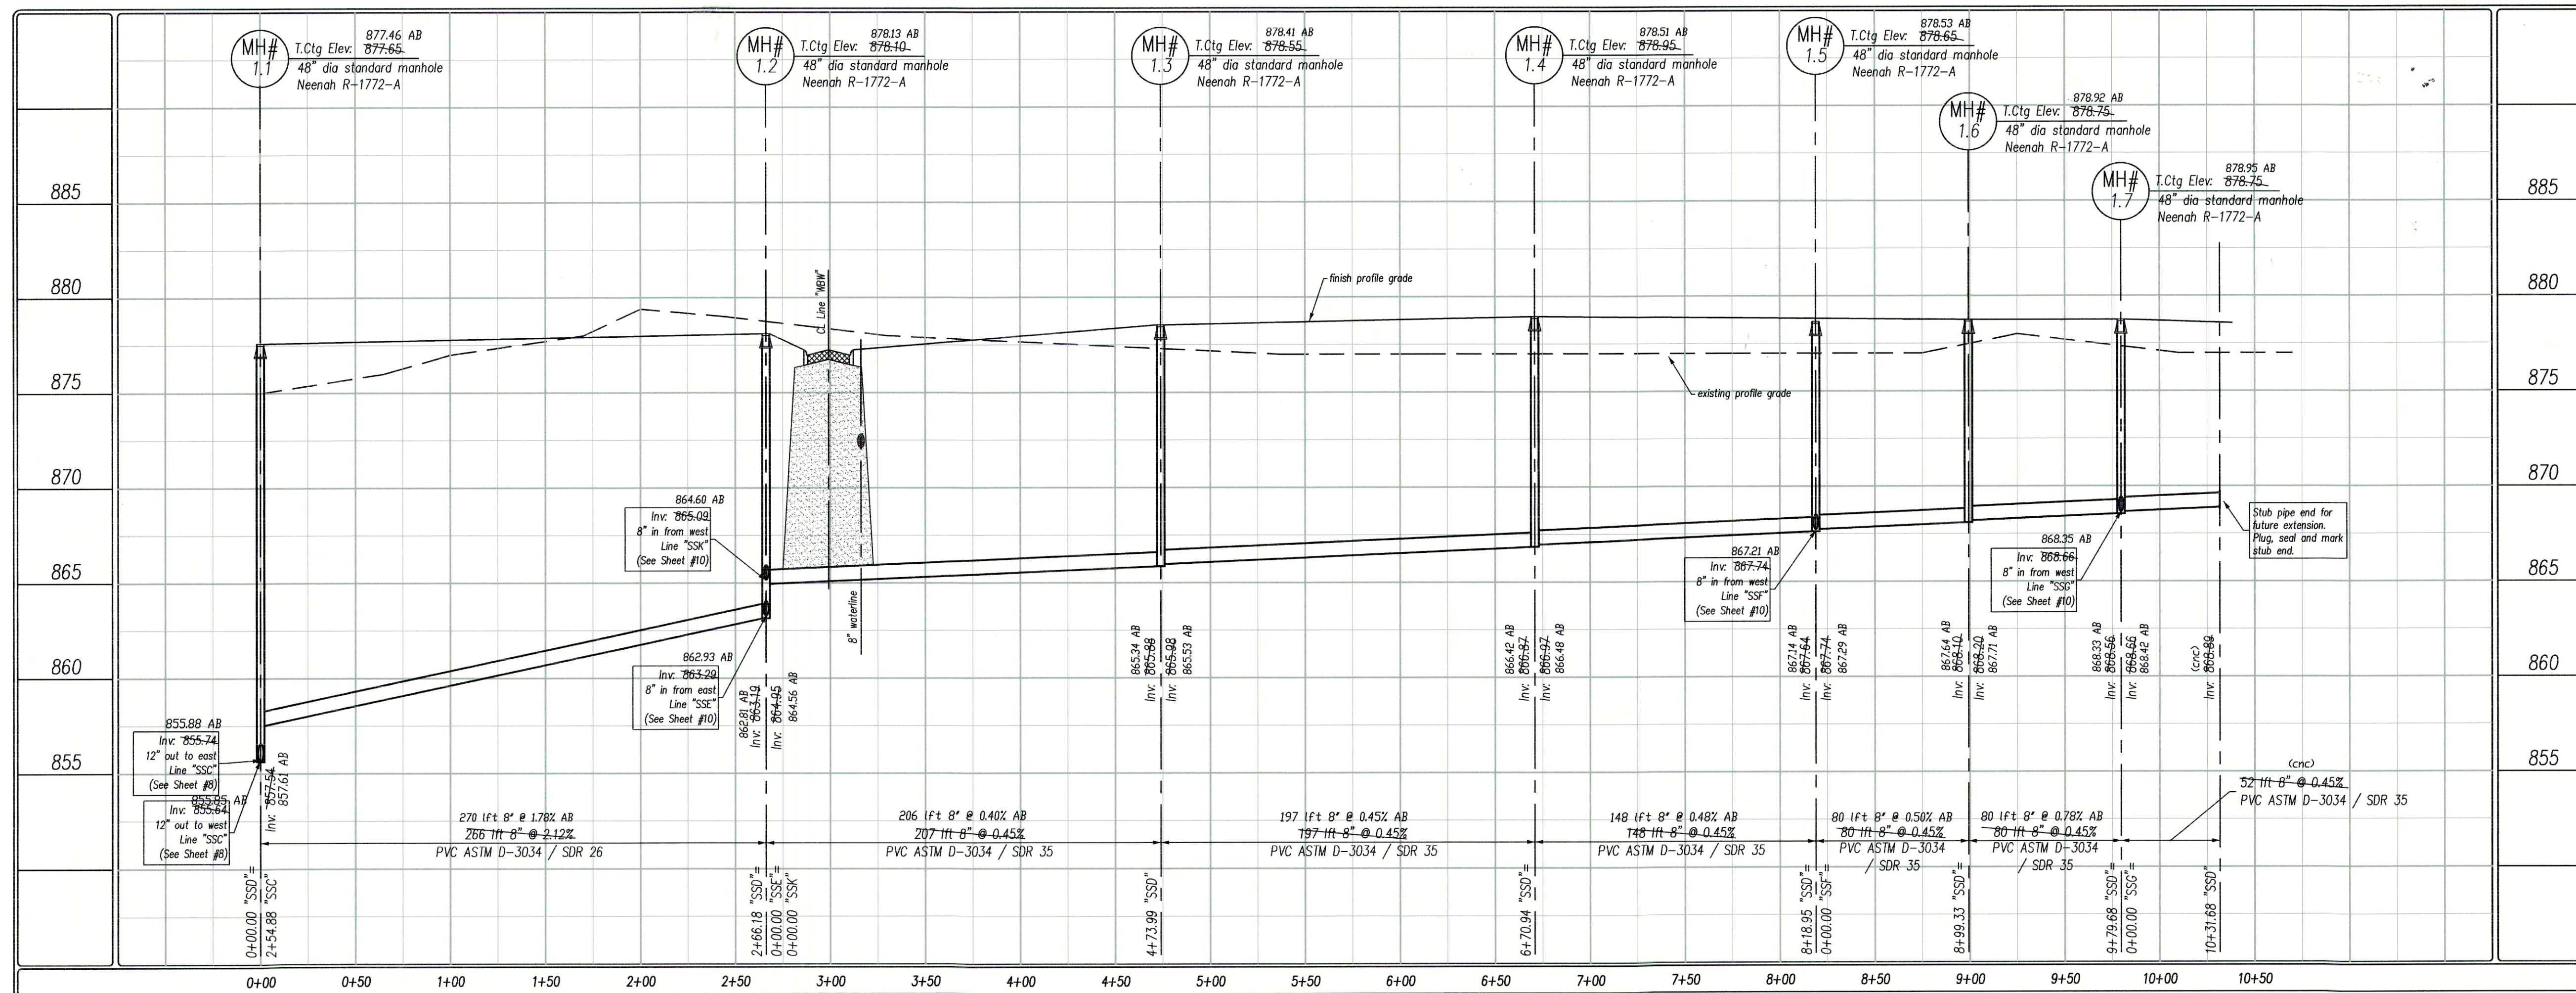

As-built Plans

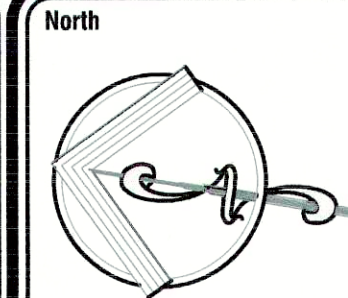

Scale: 1"=50'

Pendleton Consulting
P.O. Box 67 Pendleton, Indiana 46064
Phone: 765-778-4540 Fax: 765-778-3871
email: pendleton@earthlink.net

Pendleton Land Company, LLC
9449 Priority Way West Drive
Suite 120
Indianapolis, Indiana 46240
Tel: 317.705.2083 Fax: 317.705.2089

Date: 8/08/04

Revised per client lot lines / numbering

Cold Springs at Huntzinger Farms
Section 1
Pendleton, Madison County, Indiana
Sanitary Plan - Profile
Line "SSD"



Sheet No.

9
18 Sheets