


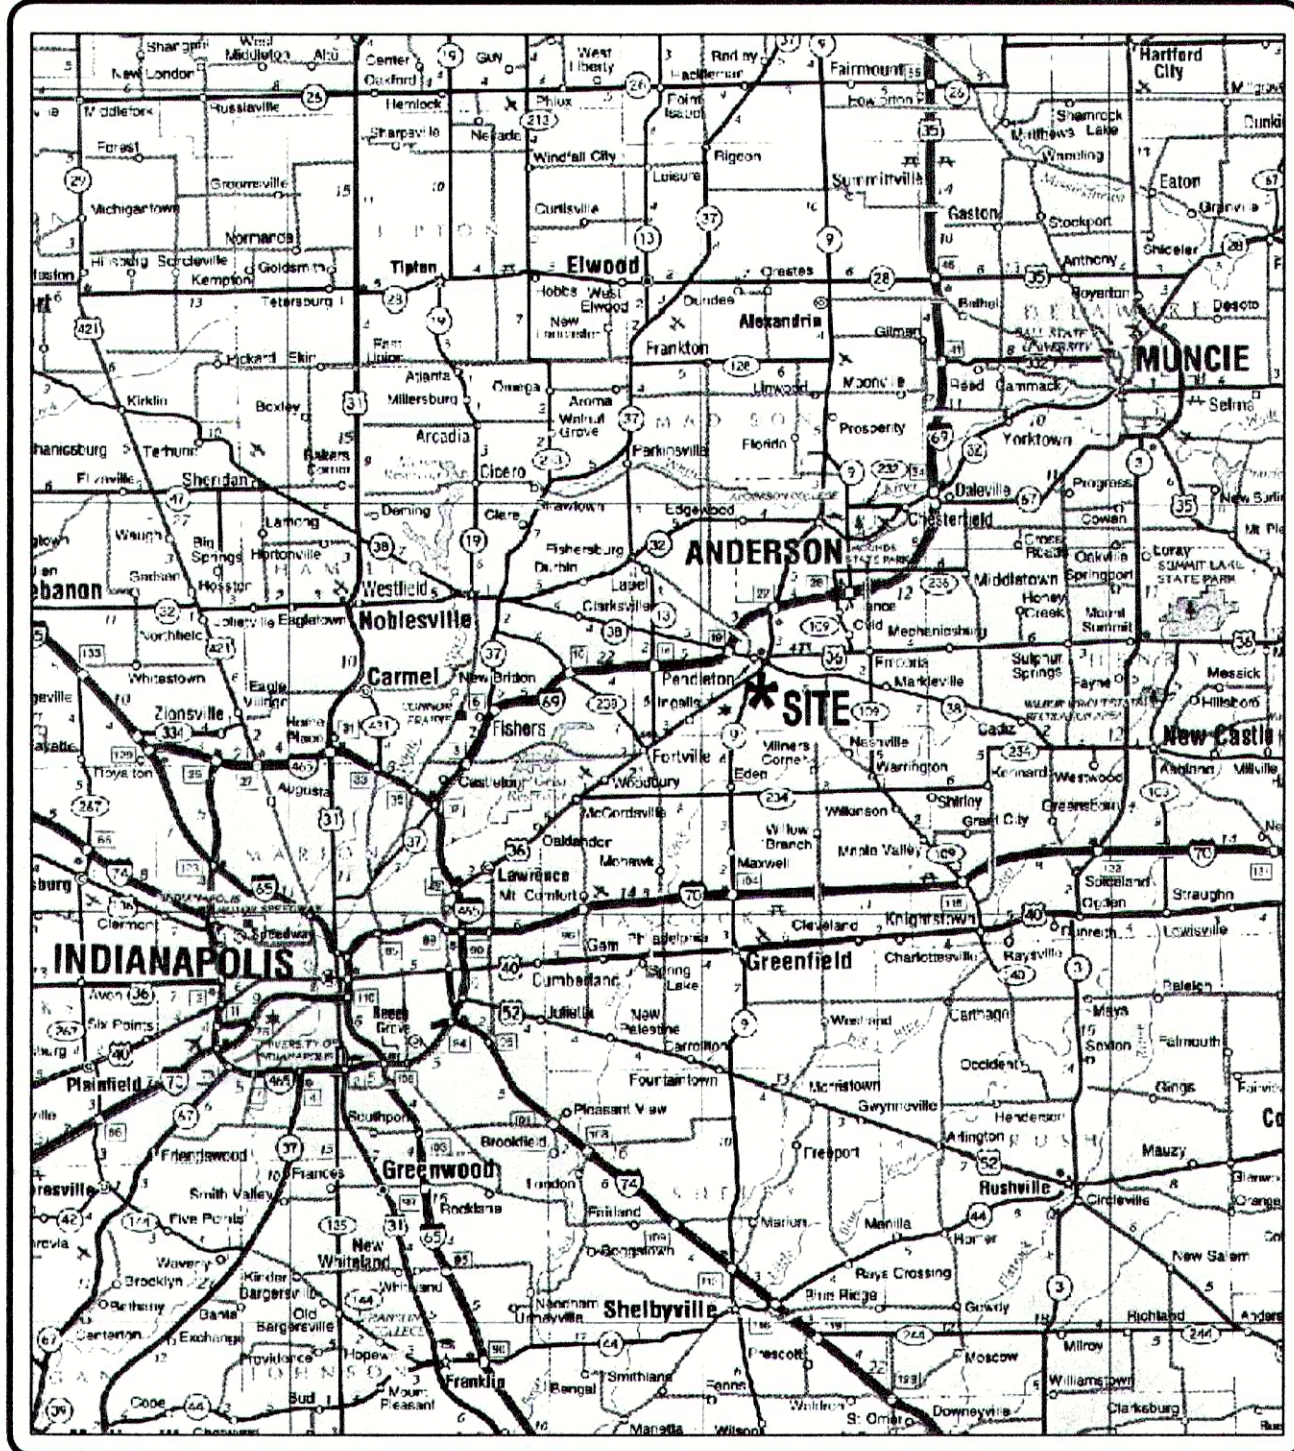

Location Map
State of Indiana Highway Map



INDEX OF DRAWINGS	
Sheet No.	Description
1	Title Sheet
2	Standard Specifications
3	Grading Plan: Detention Pond #1
4	Grading Plan: Detention Pond #2 and 3 / Storm Series 700
5	Grading Plan: Temporary Ditch Str #800 to Detention Pond #1
6	Street Plan-Profile: Line "HBlvd"
7	Street Plan-Profile: Line "HBlvd"
8	Street Plan-Profile: Line "Fln" / Street Intersection Detail Lines "Fln" / "BSC"
9	Street Detail: Line "HBlvd", Sta 0+00 - 9+00
10	Street Detail: Line "HBlvd", Sta 9+00 - Cul-de-loop / Intersection Lines "HBlvd" & "CSD"
11	Sanitary Plan-Profile: Line "SSA"
12	Sanitary Plan-Profile: Force Main
13	Sanitary Plan-Profile: Line "SSC" / Storm Drainage Plan-Profile Structure: Series 800
14	Storm Drainage Plan-Profile: Structure Series 100
15	Storm Drainage Plan-Profile: Structure Series 100, 200, 300
16	Storm Drainage Plan-Profile: Structure Series 400, 500, 600
17	Waterline Plan - Huntzinger Blvd
18	Waterline Plan - Fairfield Lane
19	Street Standard Details
20	Storm and Waterline Standard Details
21	Sanitary Standard Details - Lift Station Detail
22	Erosion Control Plan-1
23	Erosion Control Plan-2
24	Erosion Control Plan-3
25	Erosion Control Plan-4
26	Erosion Control Details
27	Erosion Control Details / Regulatory Information Sheet
	Waterline Plan - Huntzinger Blvd / Contractor notes
	Waterline Plan - Huntzinger Blvd / Contractor notes

REVISIONS		
Sheet #	Date	Description
2	3/28/04	Revised per comments from T&P per check-off list dated 3/22/04.
11-13	4/1/04	Corrected str numbering.
11	4/12/04	Revised to adjust pipe inverts Str #103-106 per client.
18-21a	4/12/04	Revised per comments from ModCo SWCD per email received on 4/11/04.
9, 17	5/21/04	Revised per comments from FCRWD/Trid per markup plans dated 4/16/04.
1-27	6/30/04	Revised to add Fairfield Lane street, storm, sanitary per client.
2, 12, 21	7/16/04	Revised to correct jurisdiction, add "4" section line of LS.

NOTES:
1. The construction standards for the Town of Pendleton (for streets, storm sewers and waterline) and Fall Creek Regional Waste District (for sanitary sewers) shall be used for all parts of this project.

Asbuilt Plans Huntzinger Farms PUD Phase I

Part of the Northwest & Southwest 1/4s, Section 28, Southeast & Northeast 1/4s,
Section 29, Township 18 North, Range 7 East
Town of Pendleton, Fall Creek Township, Madison County, Indiana

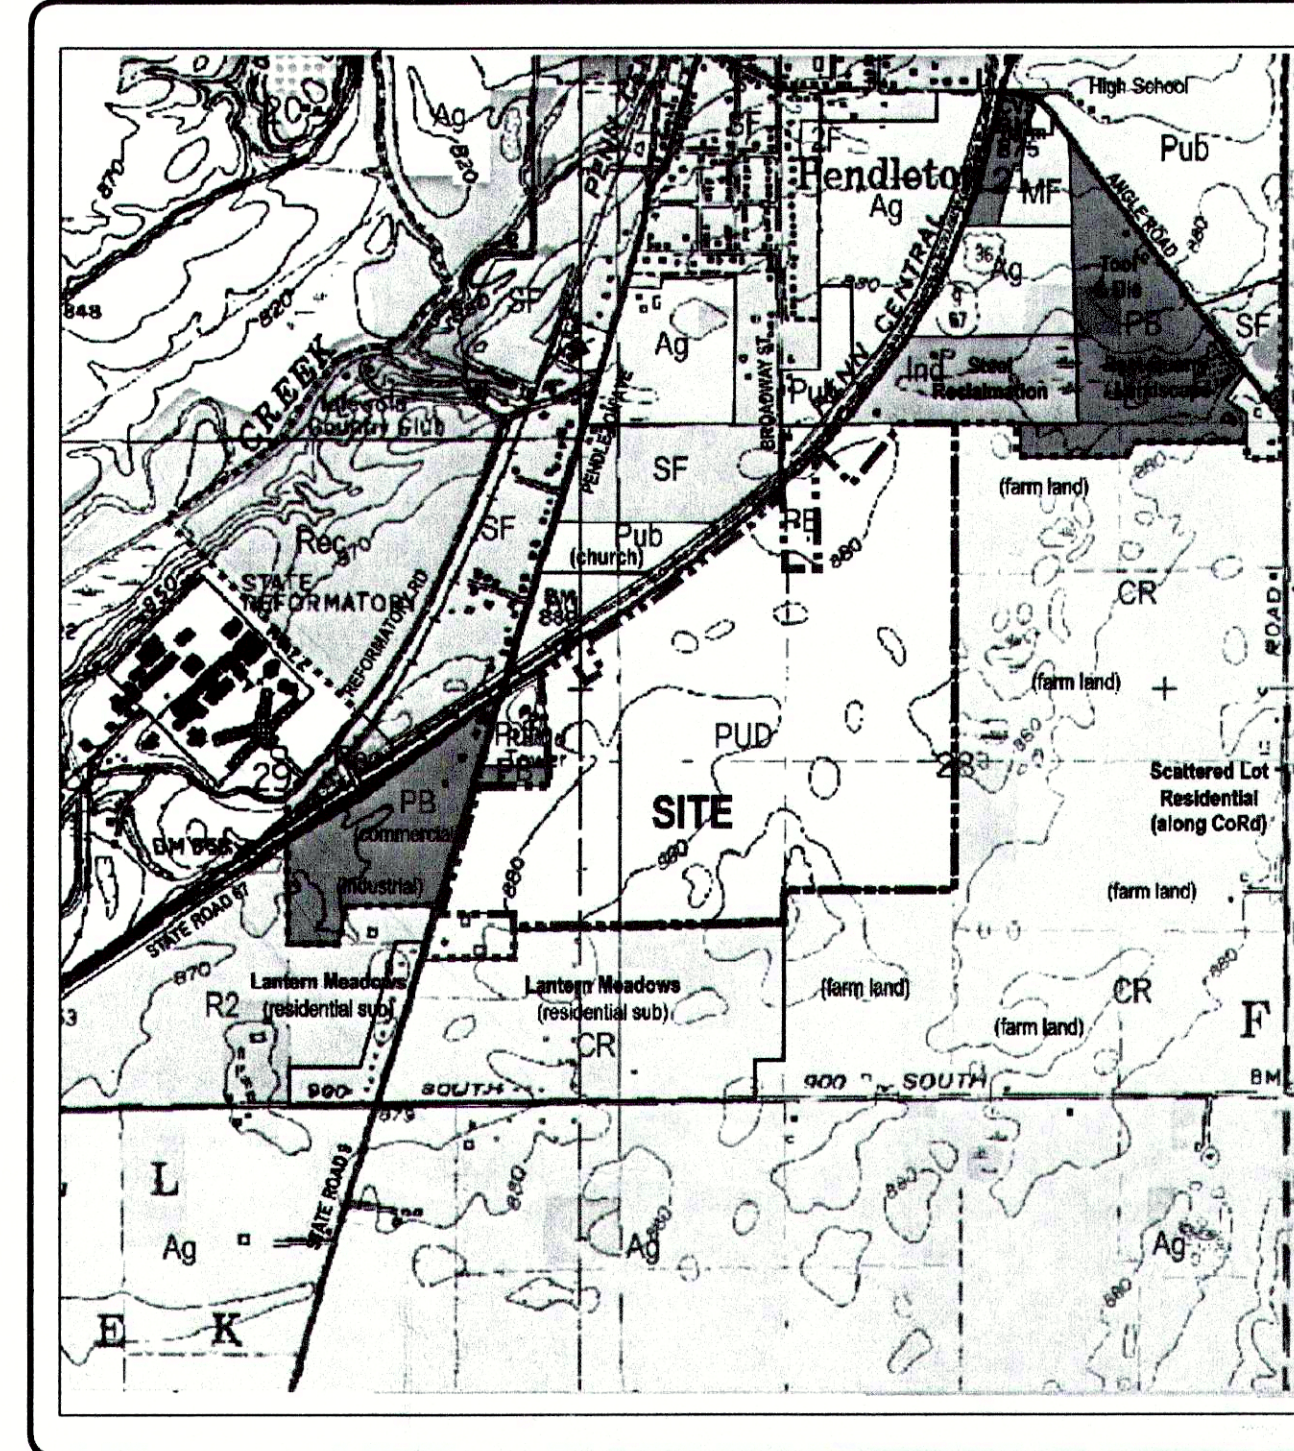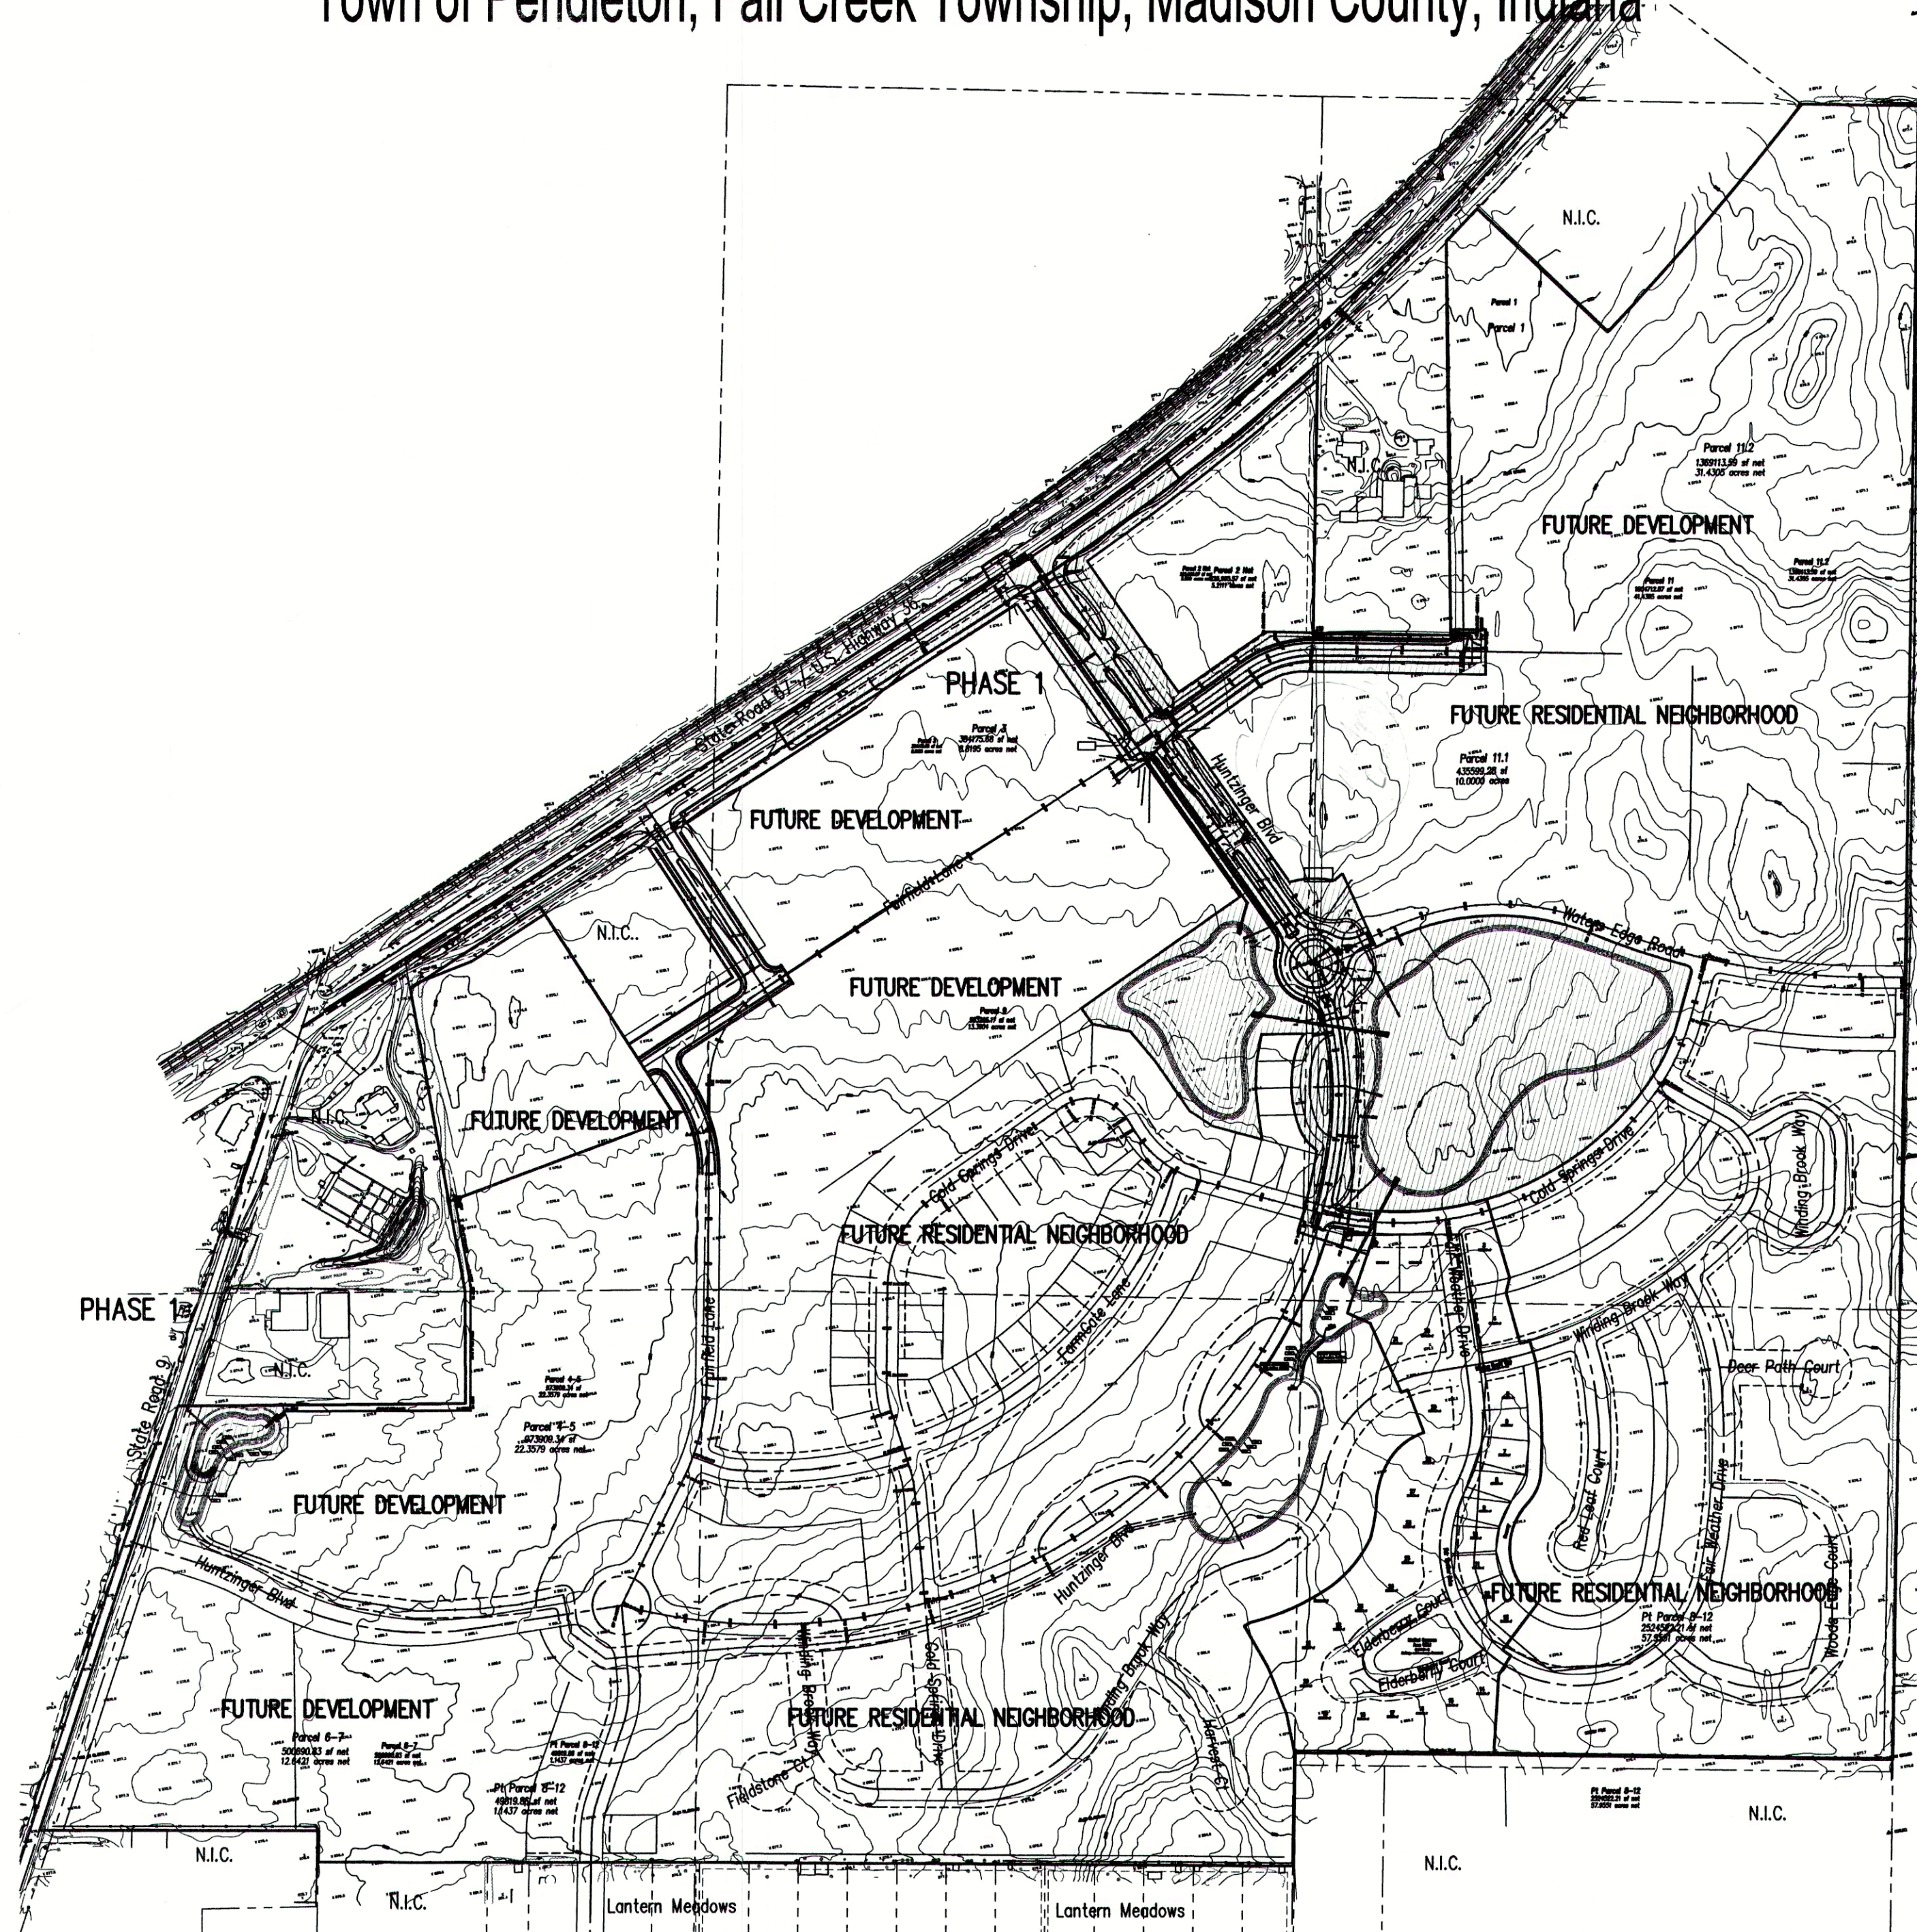

Area Map
USGS Quadrangle Maps:
Anderson North / Gilman / Middletown / Anderson South

Project Data

Dedicated Street Lengths	
Huntzinger Blvd (Line "HBlvd"):	1,728.25 lft
Waters Edge Road (Line "WERd"):	115.30 lft
Cold Springs Drive (Line "CSDr"):	95.78 lft
Fairfield Lane (Line "FLn"):	857.80 lft
Broadway Street (Line "BSt"):	41.14 lft
Total:	2,838.27 lft

prepared for: Pendleton Land Company, LLC
9449 Priority Way West Drive
Suite 120
Indianapolis, Indiana 46240
Tel: 317.705.2063
Fax: 317.705.2069

prepared by:

Pendleton
Consulting

P.O. Box 67 Pendleton, Indiana 46064
Phone (765) 778-4540 Fax 765-778-3571 email pendc@netdirect.net

certified by:

Stephen E. Bourquein
Indiana Registered Professional Land Surveyor #S0441

