




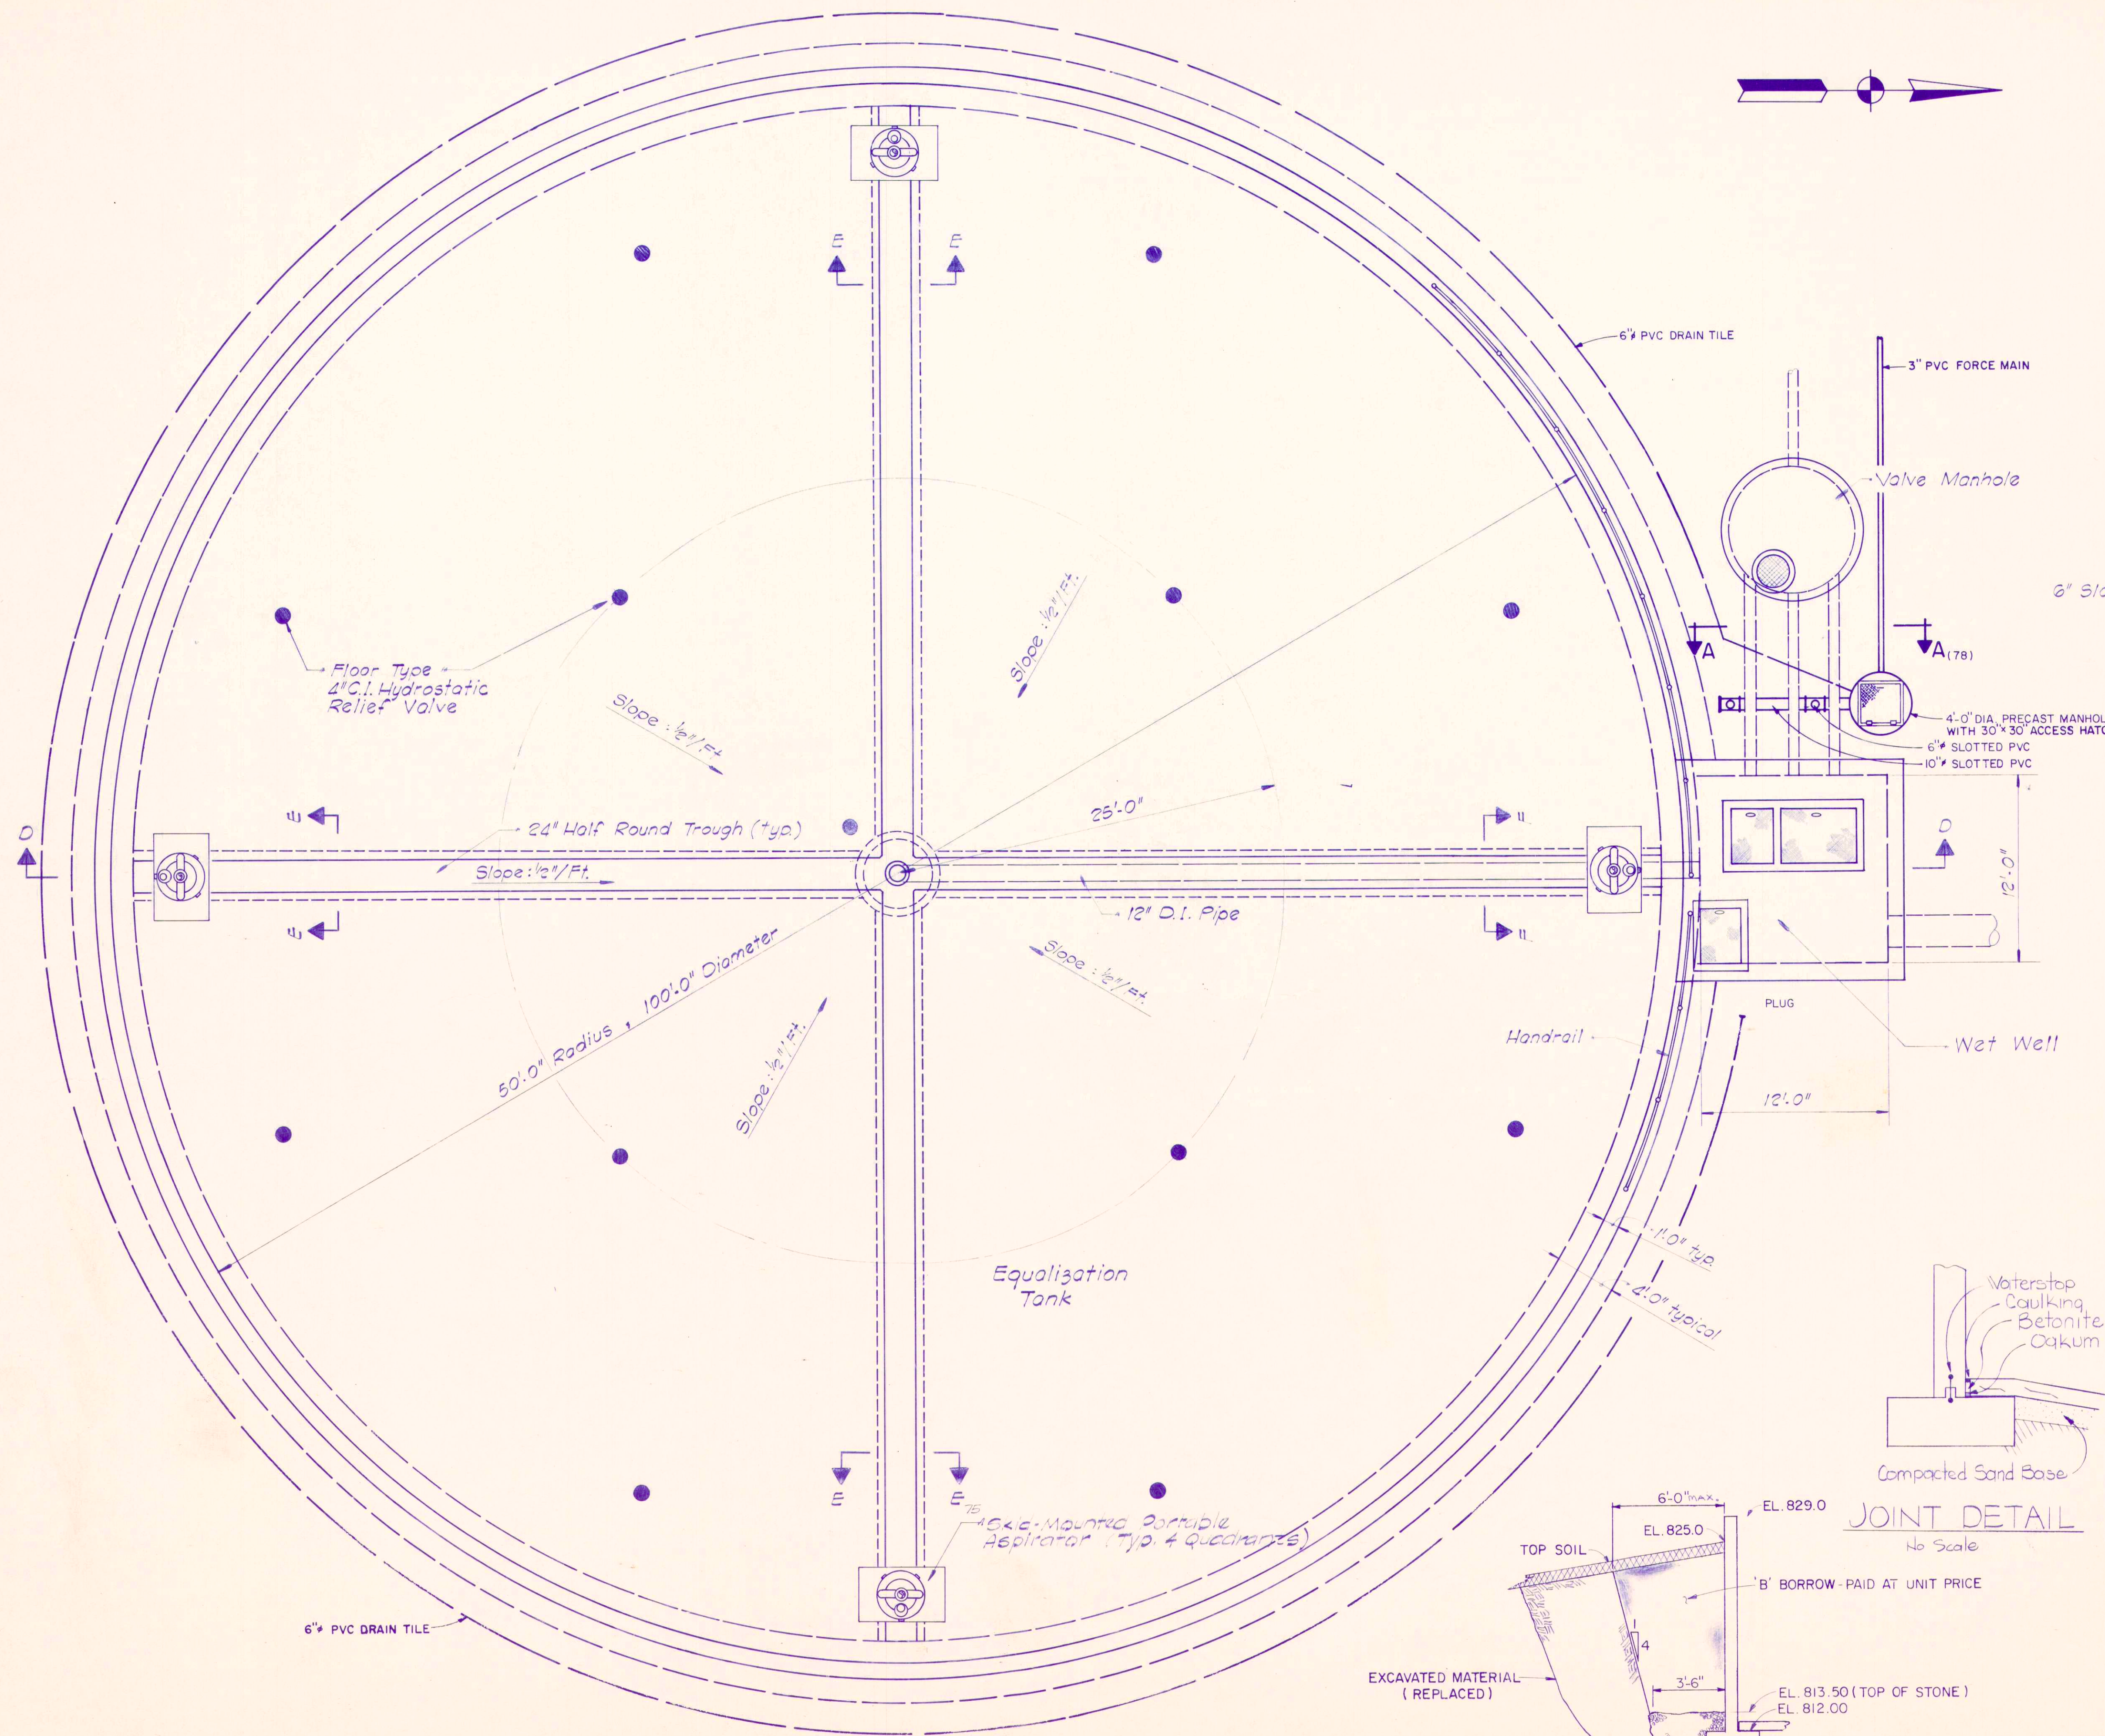


PLAN
Scale: 3/16" = 1'-0"

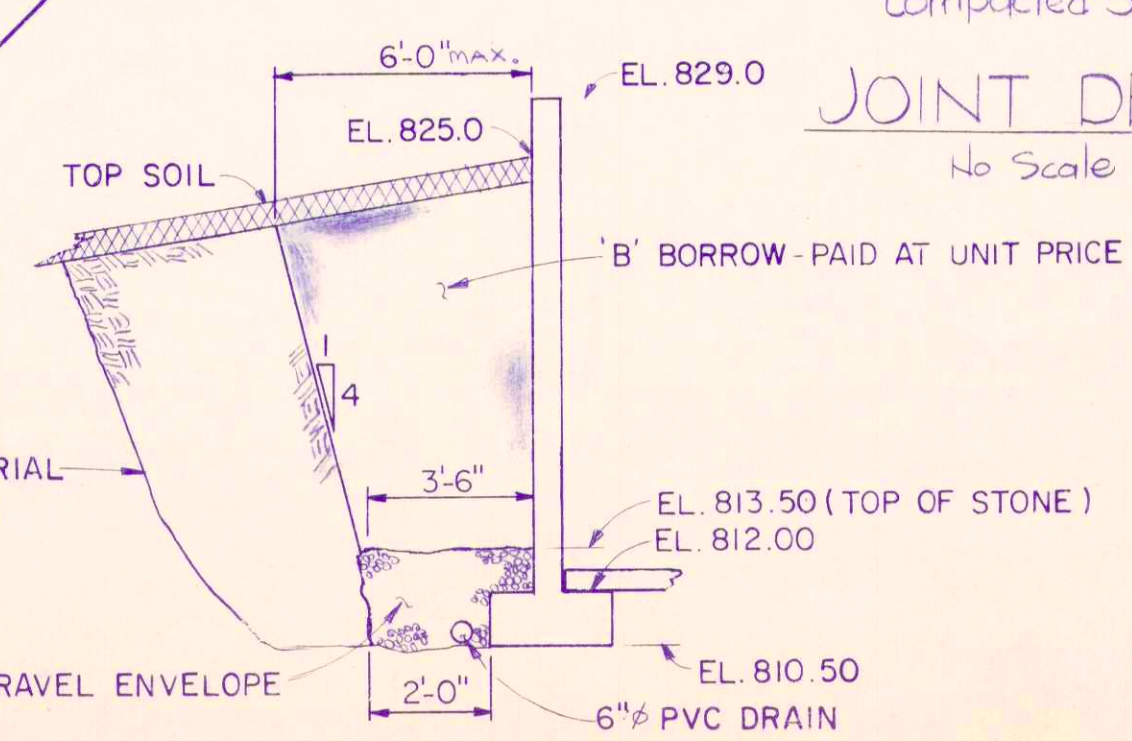


SECTION B-B (TYPICAL)
NO SCALE

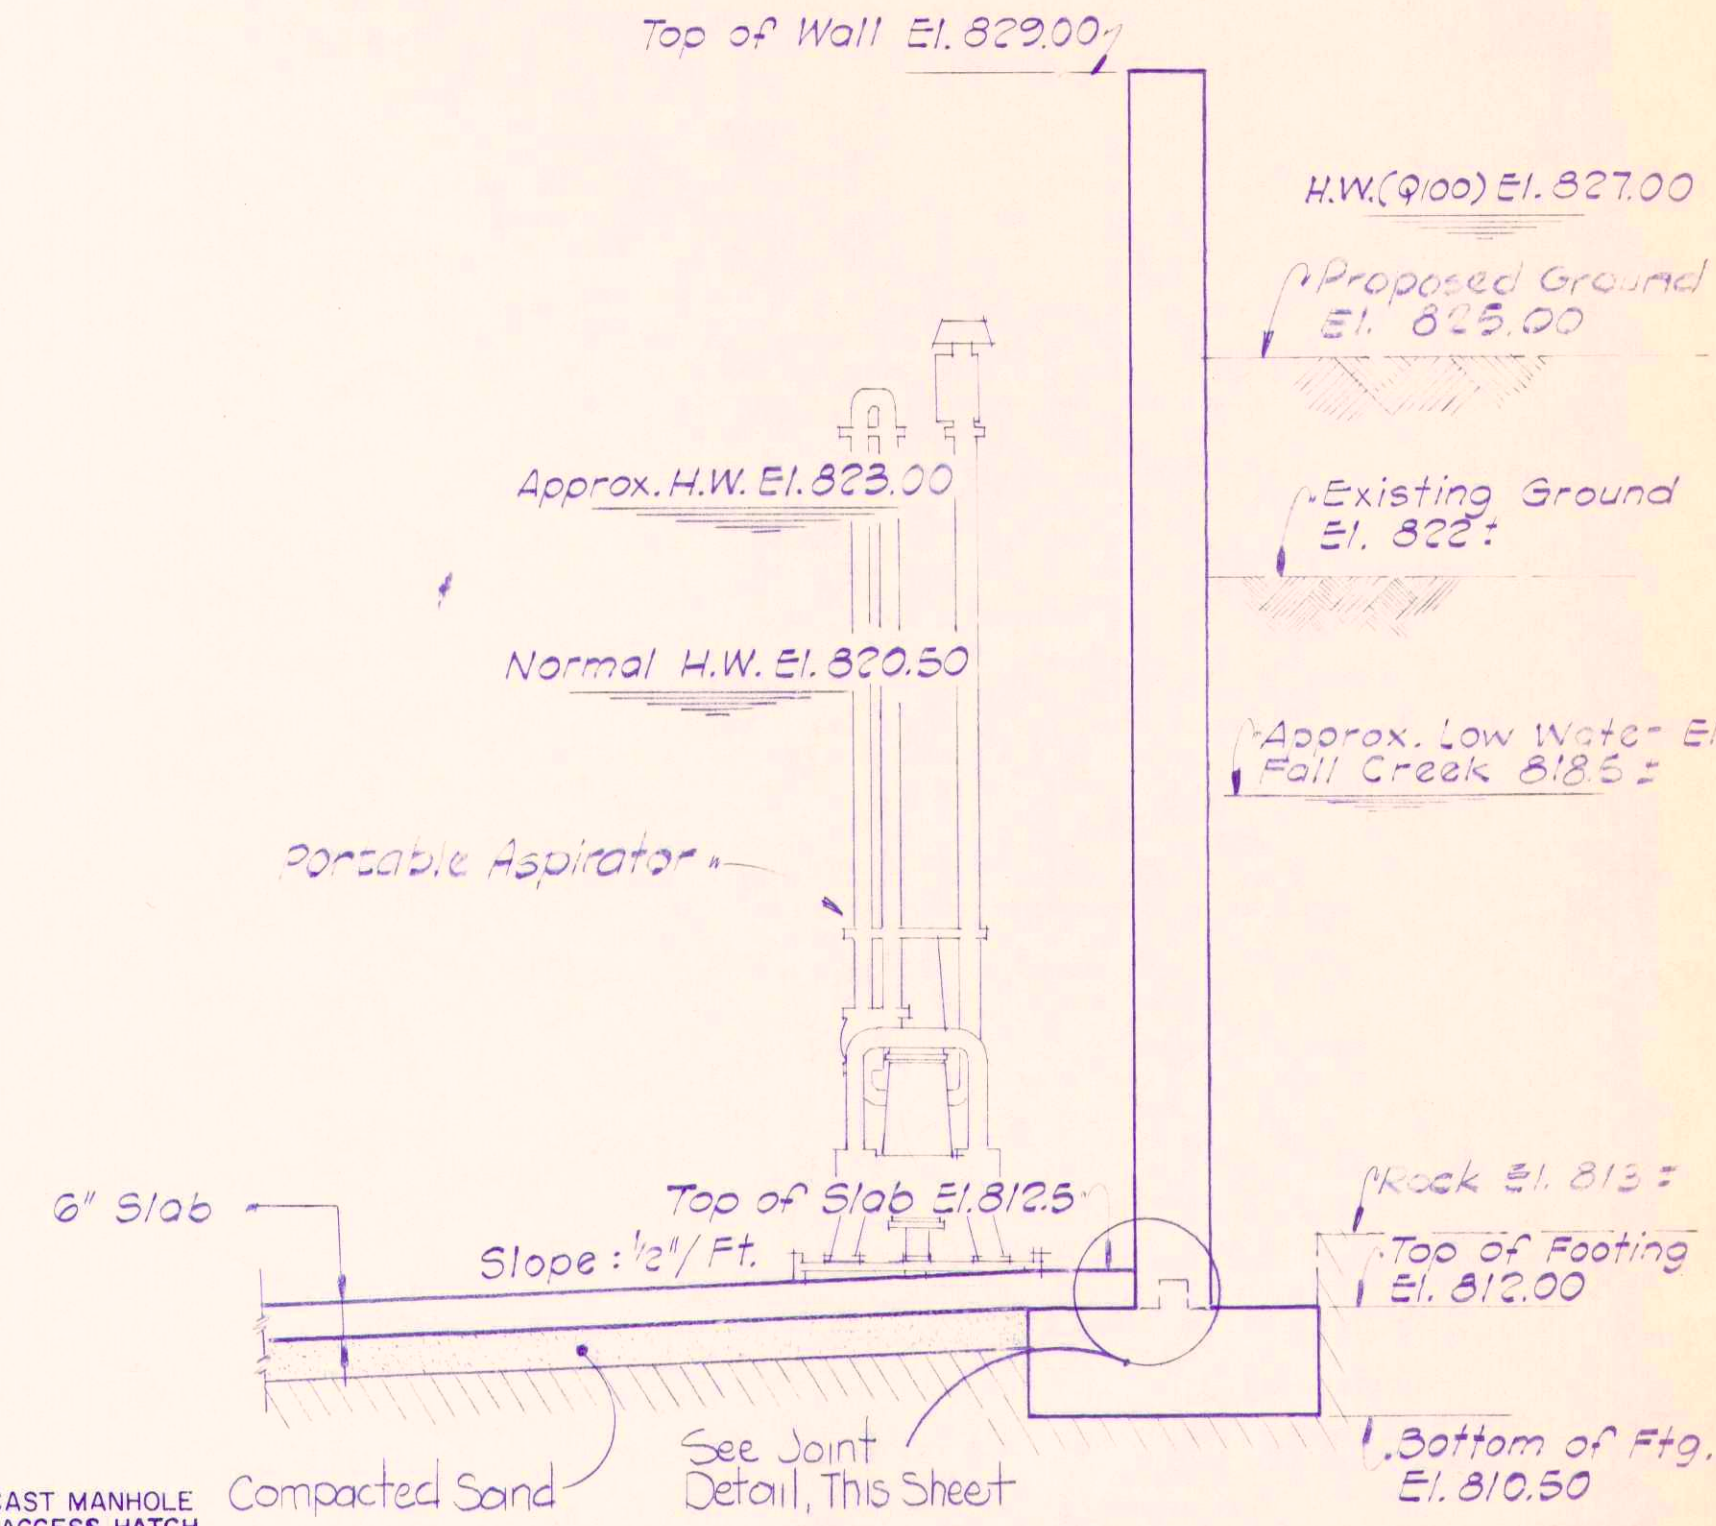

TYPICAL WALL SECTION
Scale: 3/8" = 1'-0"

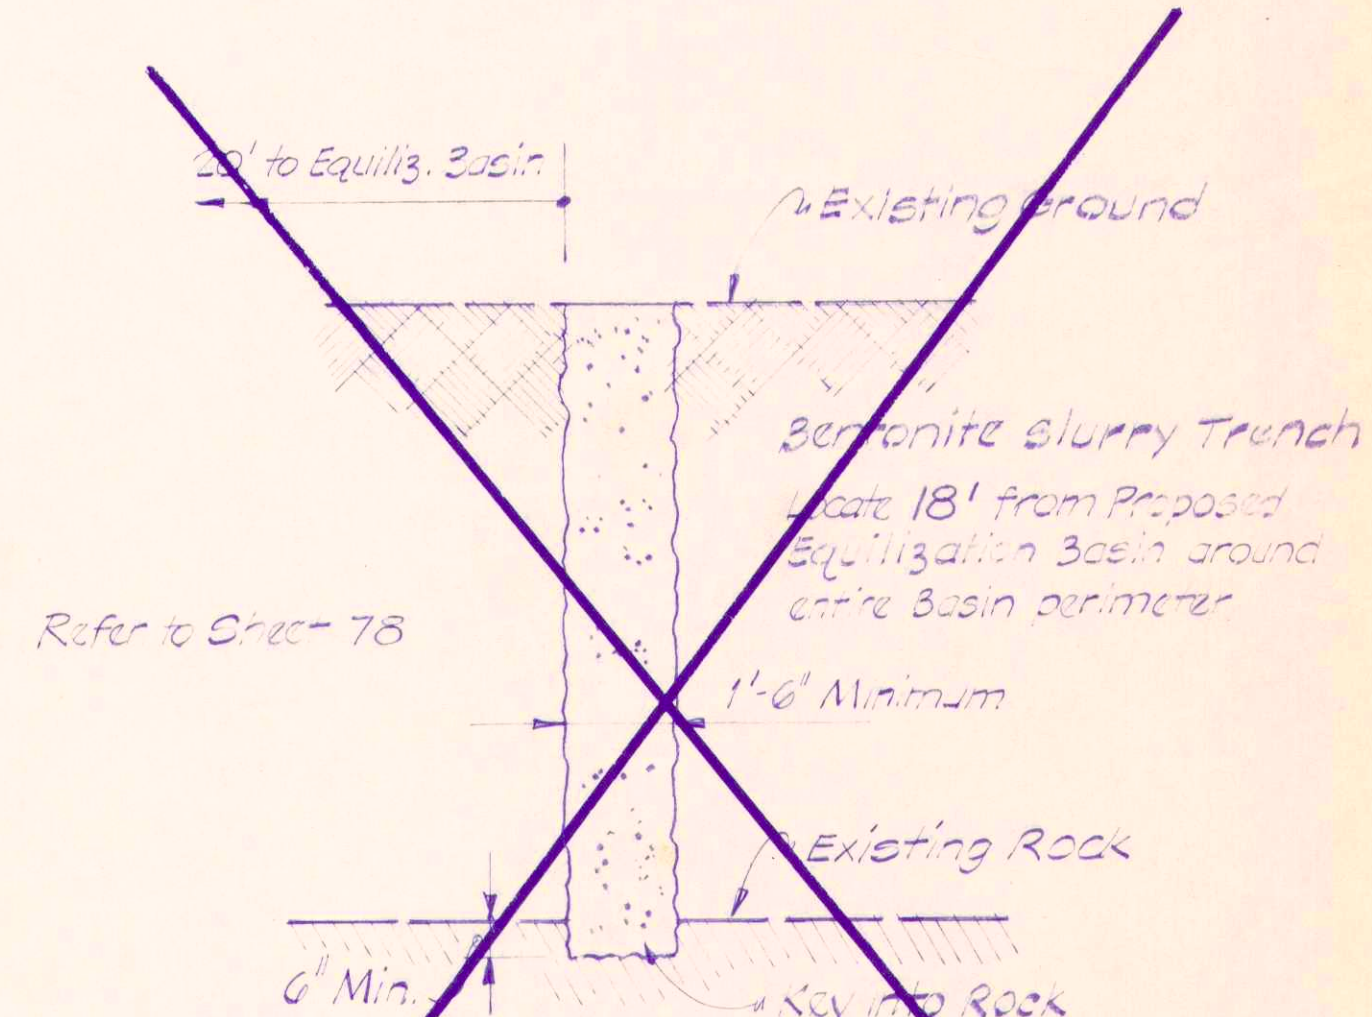

TYPICAL BENTONITE
SLURRY TRENCH DETAIL
Not to Scale

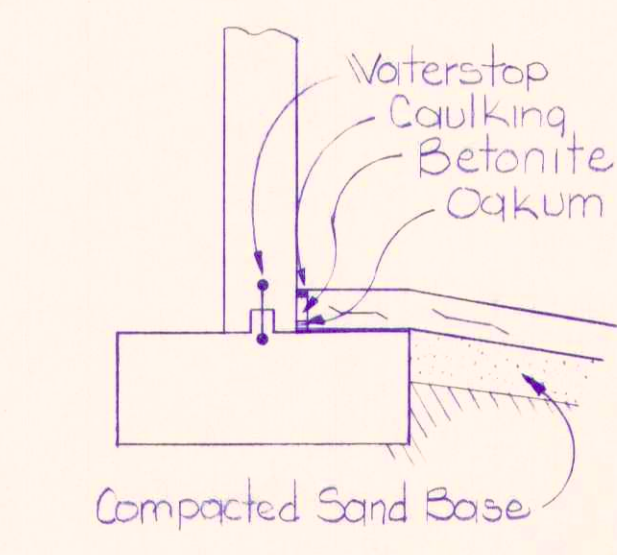

JOINT DETAIL
No Scale

DELETED

RECORD DRAWING

EQUALIZATION TANK
PLAN - STRUCTURAL

Scale: 3/16" = 1'-0"	FAIL CREEK R.W.D.	Sheet
Drawn By: J.B.	BEAM, LONGEST & NEFF	79
Designed By: R.F.S.	Consulting Engineers	
Certified By: E.R.	8136 Castleton Road	
	Indianapolis, IN 46250	

REVISED 10/11/84