

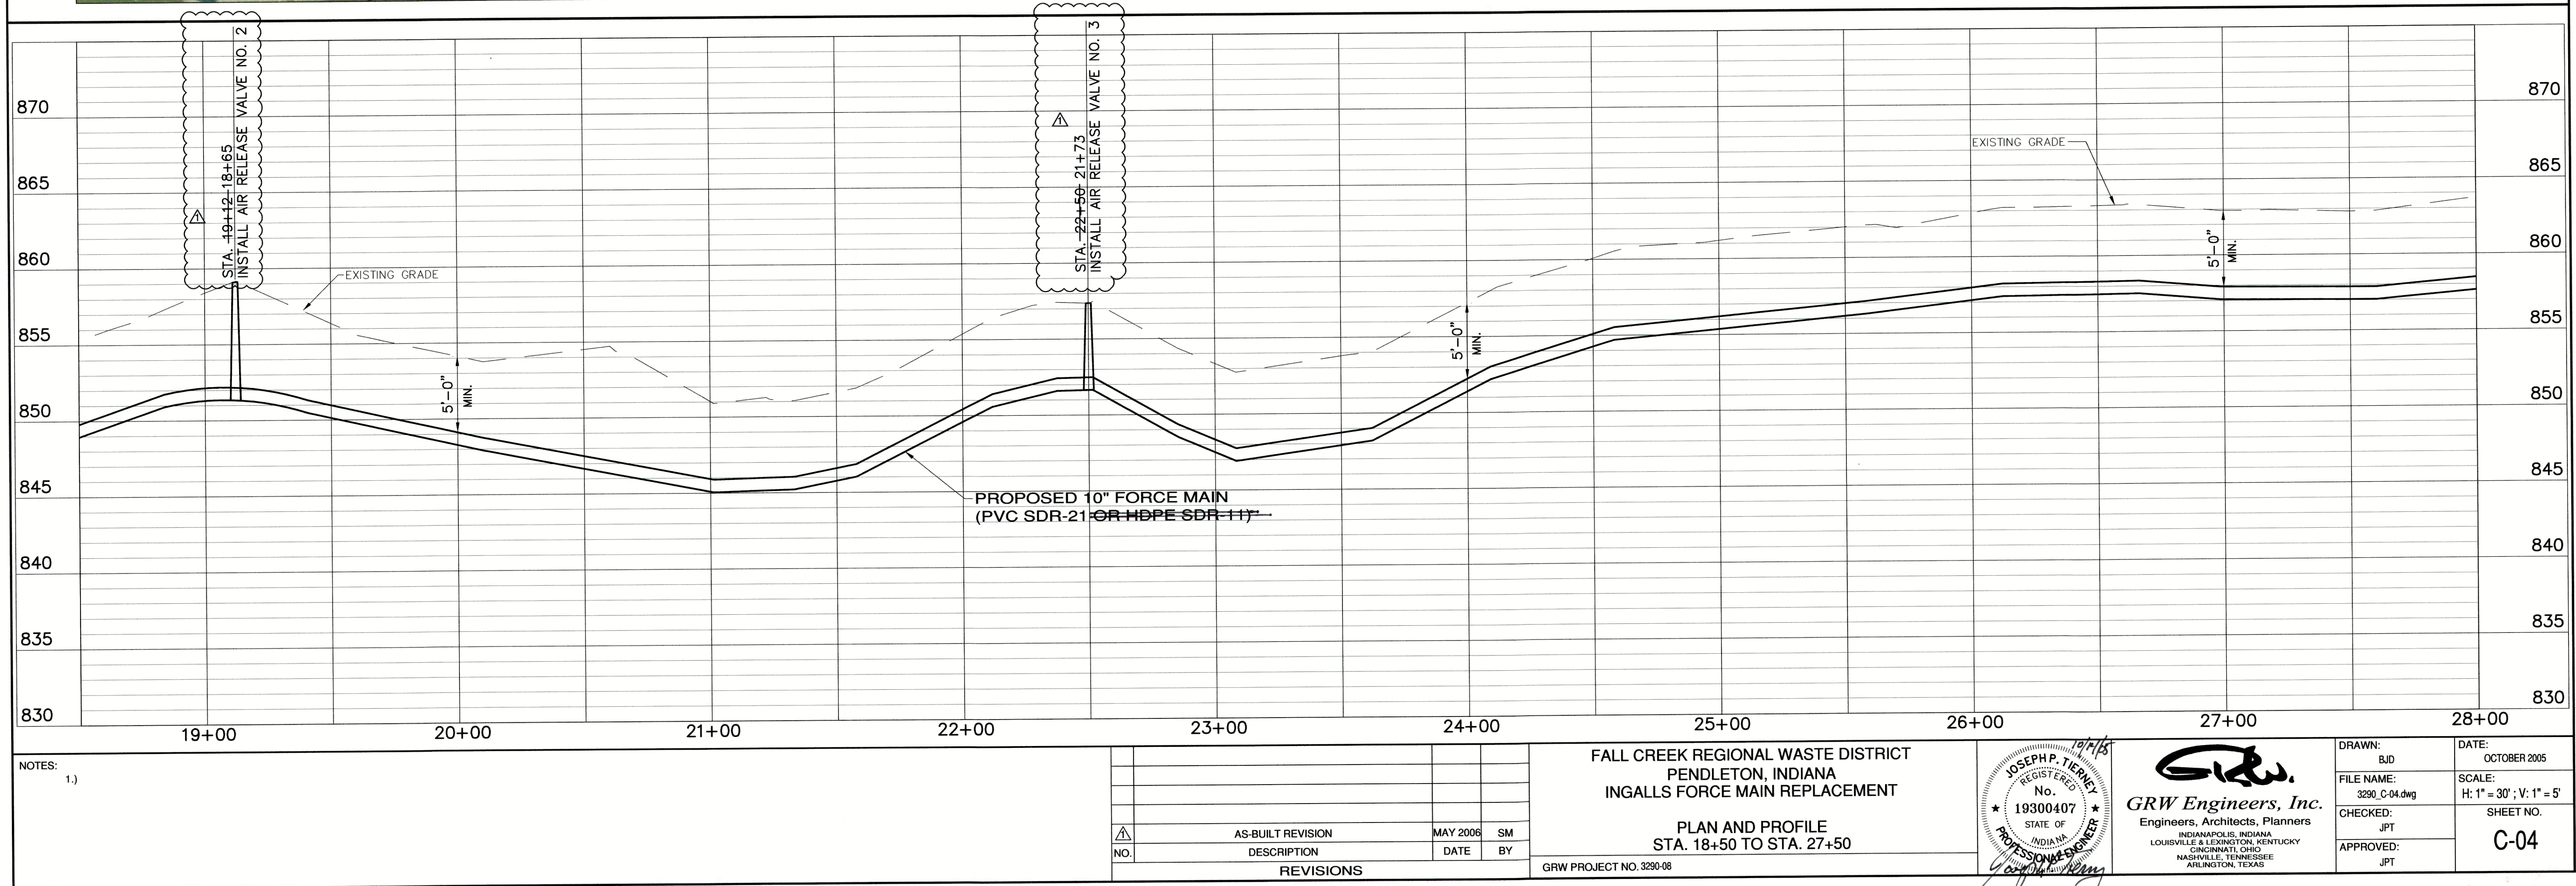


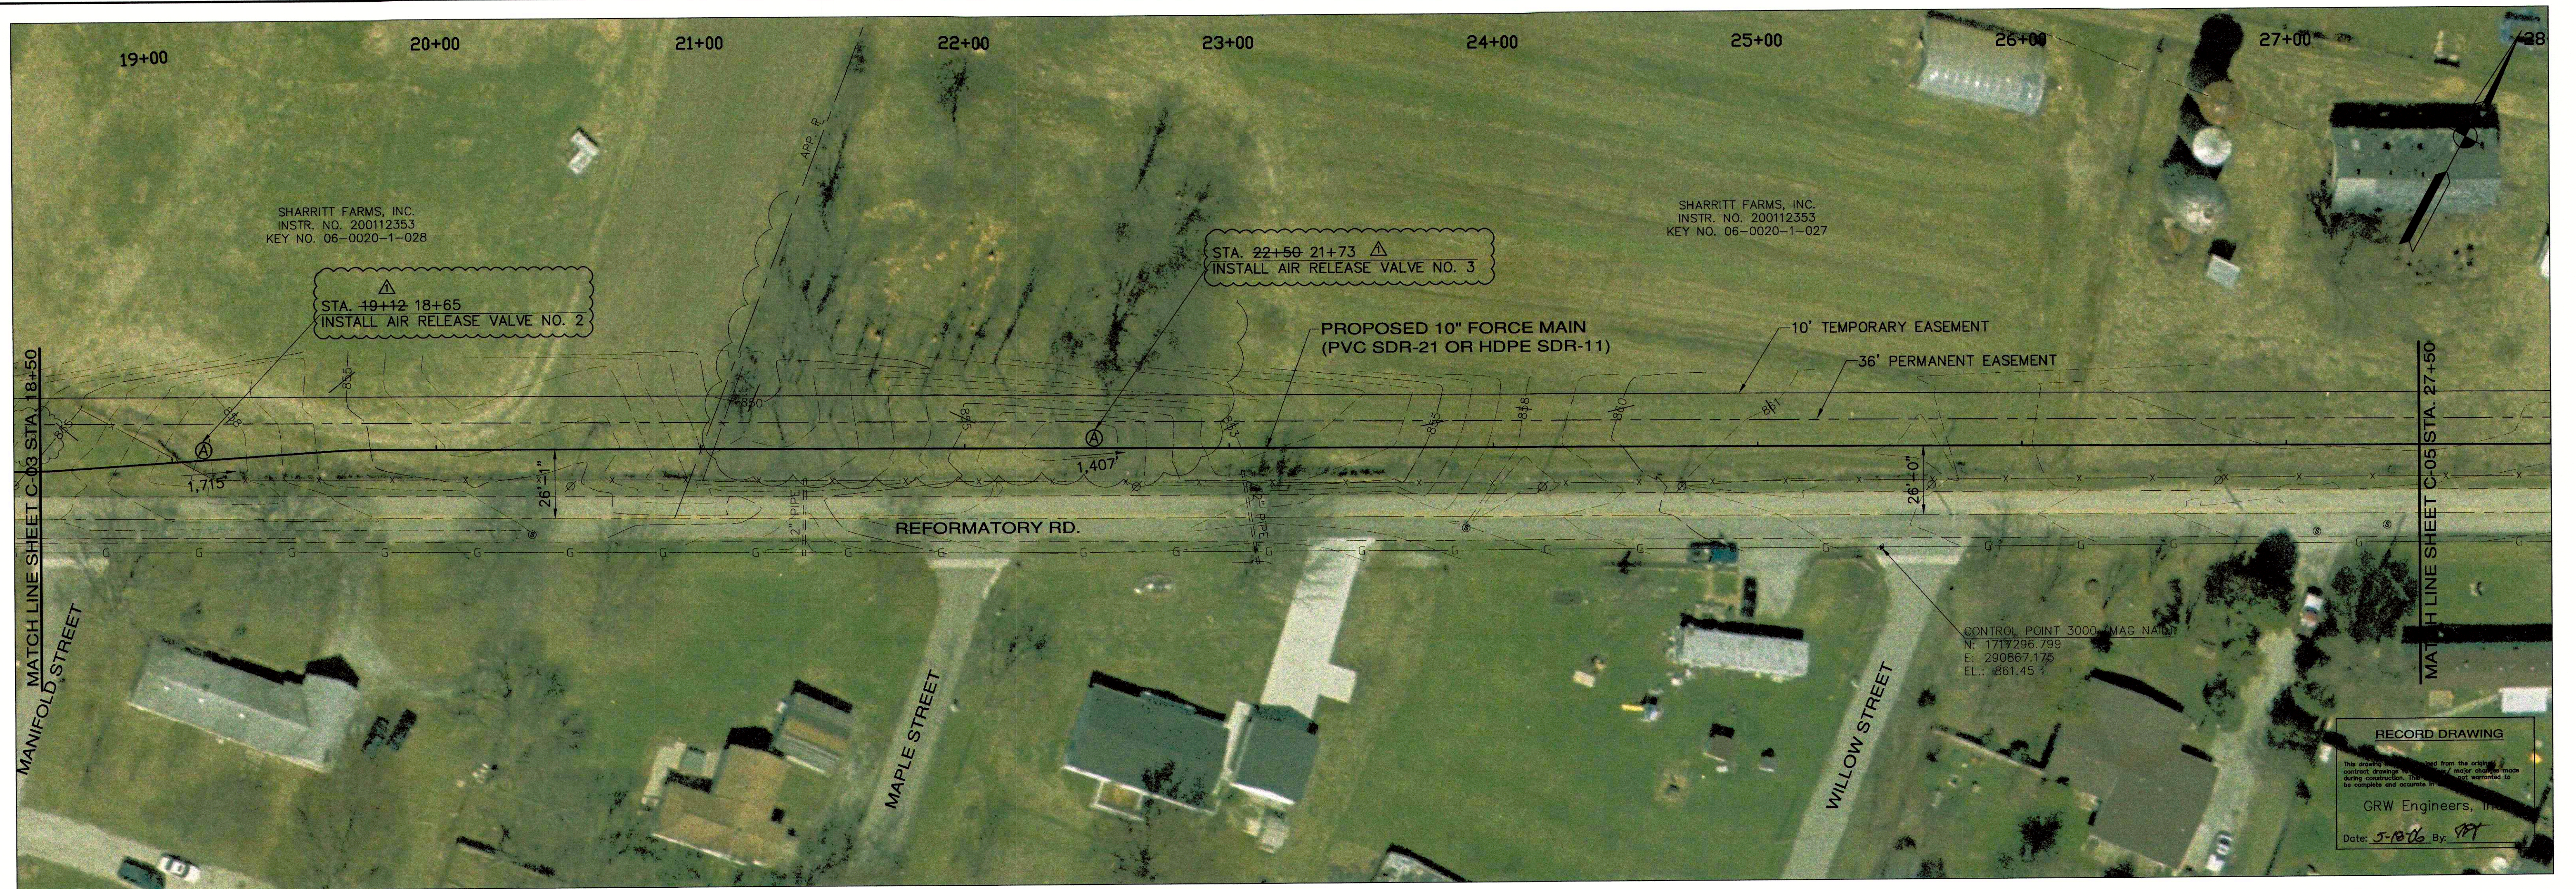

NOTES:
1.)

NO.	DESCRIPTION	DATE	BY
1	AS-BUILT REVISION	MAY 2006	SM
REVISIONS			

FALL CREEK REGIONAL WASTE DISTRICT
PENDLETON, INDIANA
INGALLS FORCE MAIN REPLACEMENT
PLAN AND PROFILE
STA. 18+50 TO STA. 27+50
GRW PROJECT NO. 3290-08

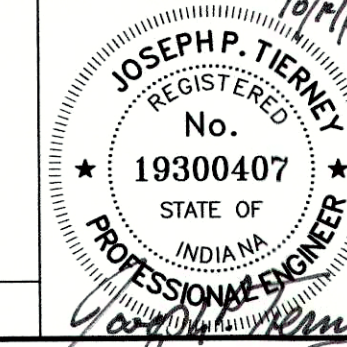

GRW Engineers, Inc.
Engineers, Architects, Planners
INDIANAPOLIS, INDIANA
LOUISVILLE & LEXINGTON, KENTUCKY
CINCINNATI, OHIO
NASHVILLE, TENNESSEE
ARLINGTON, TEXAS

DRAWN: BJD	DATE: OCTOBER 2005
FILE NAME: 3290_C-04.dwg	SCALE: H: 1" = 30'; V: 1" = 5'
CHECKED: JPT	SHEET NO. C-04
APPROVED: JPT	