
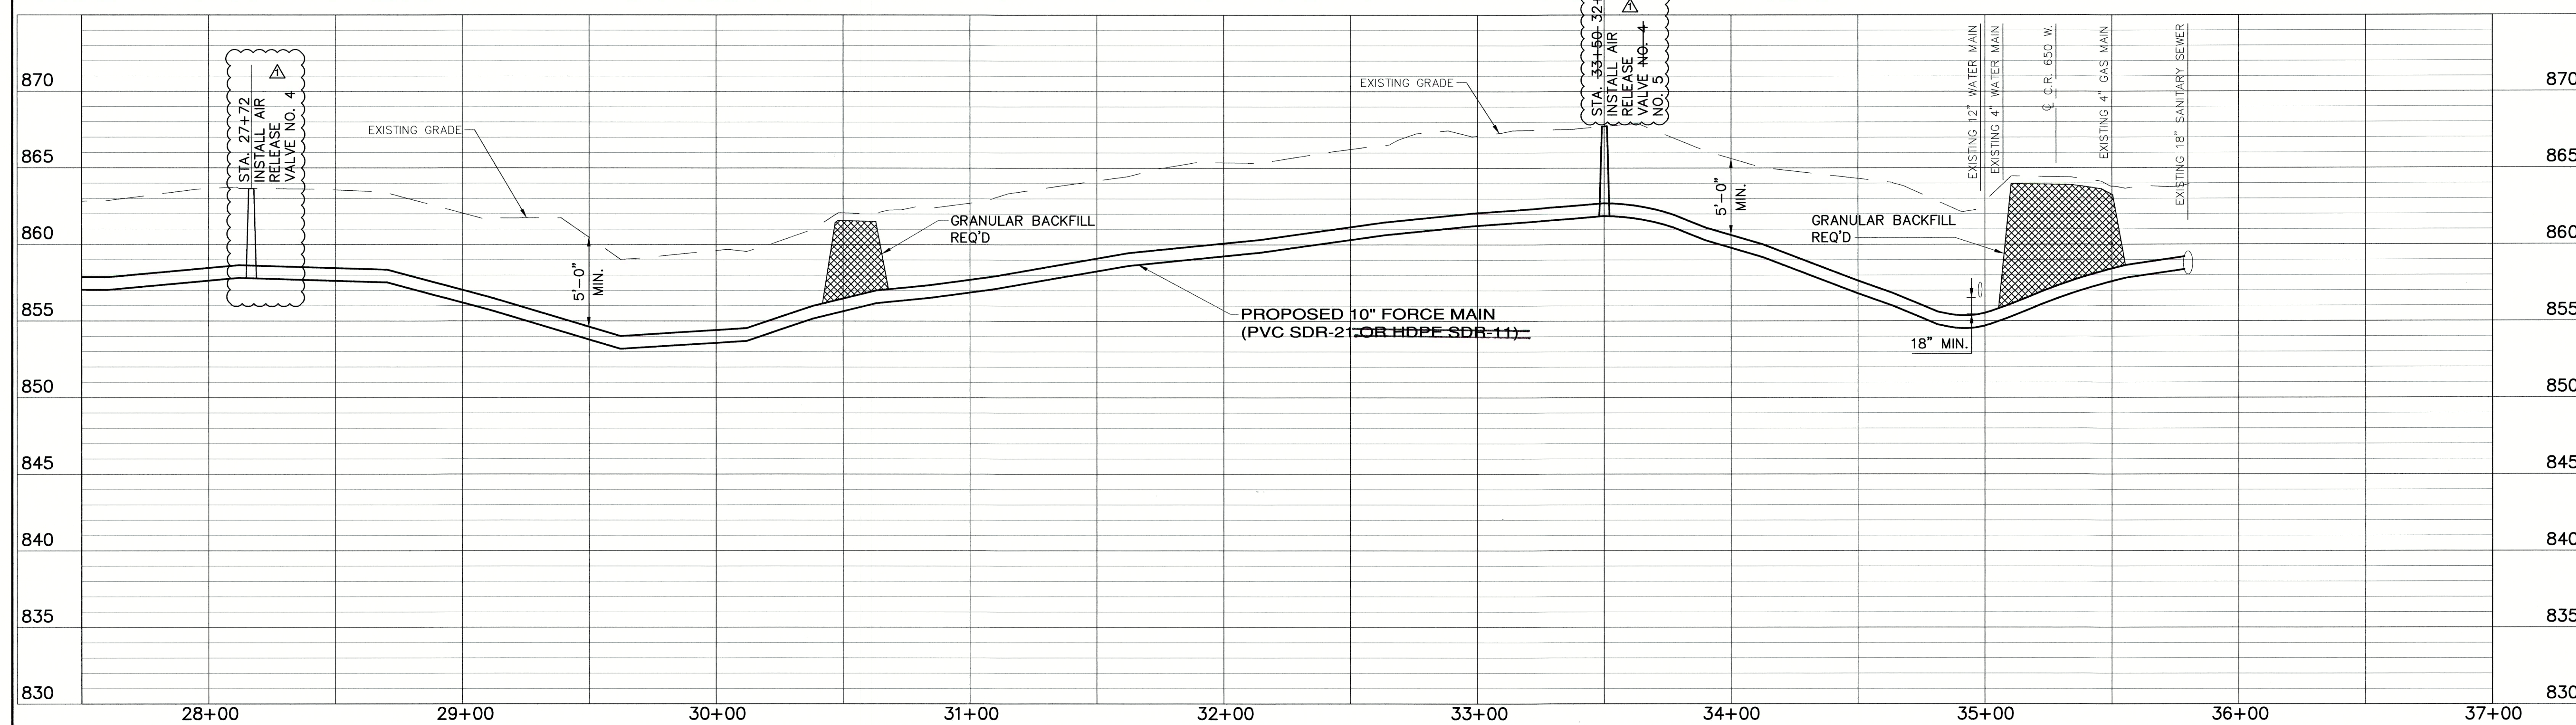


MATCH LINE SHEET C-04 STA. 27+50

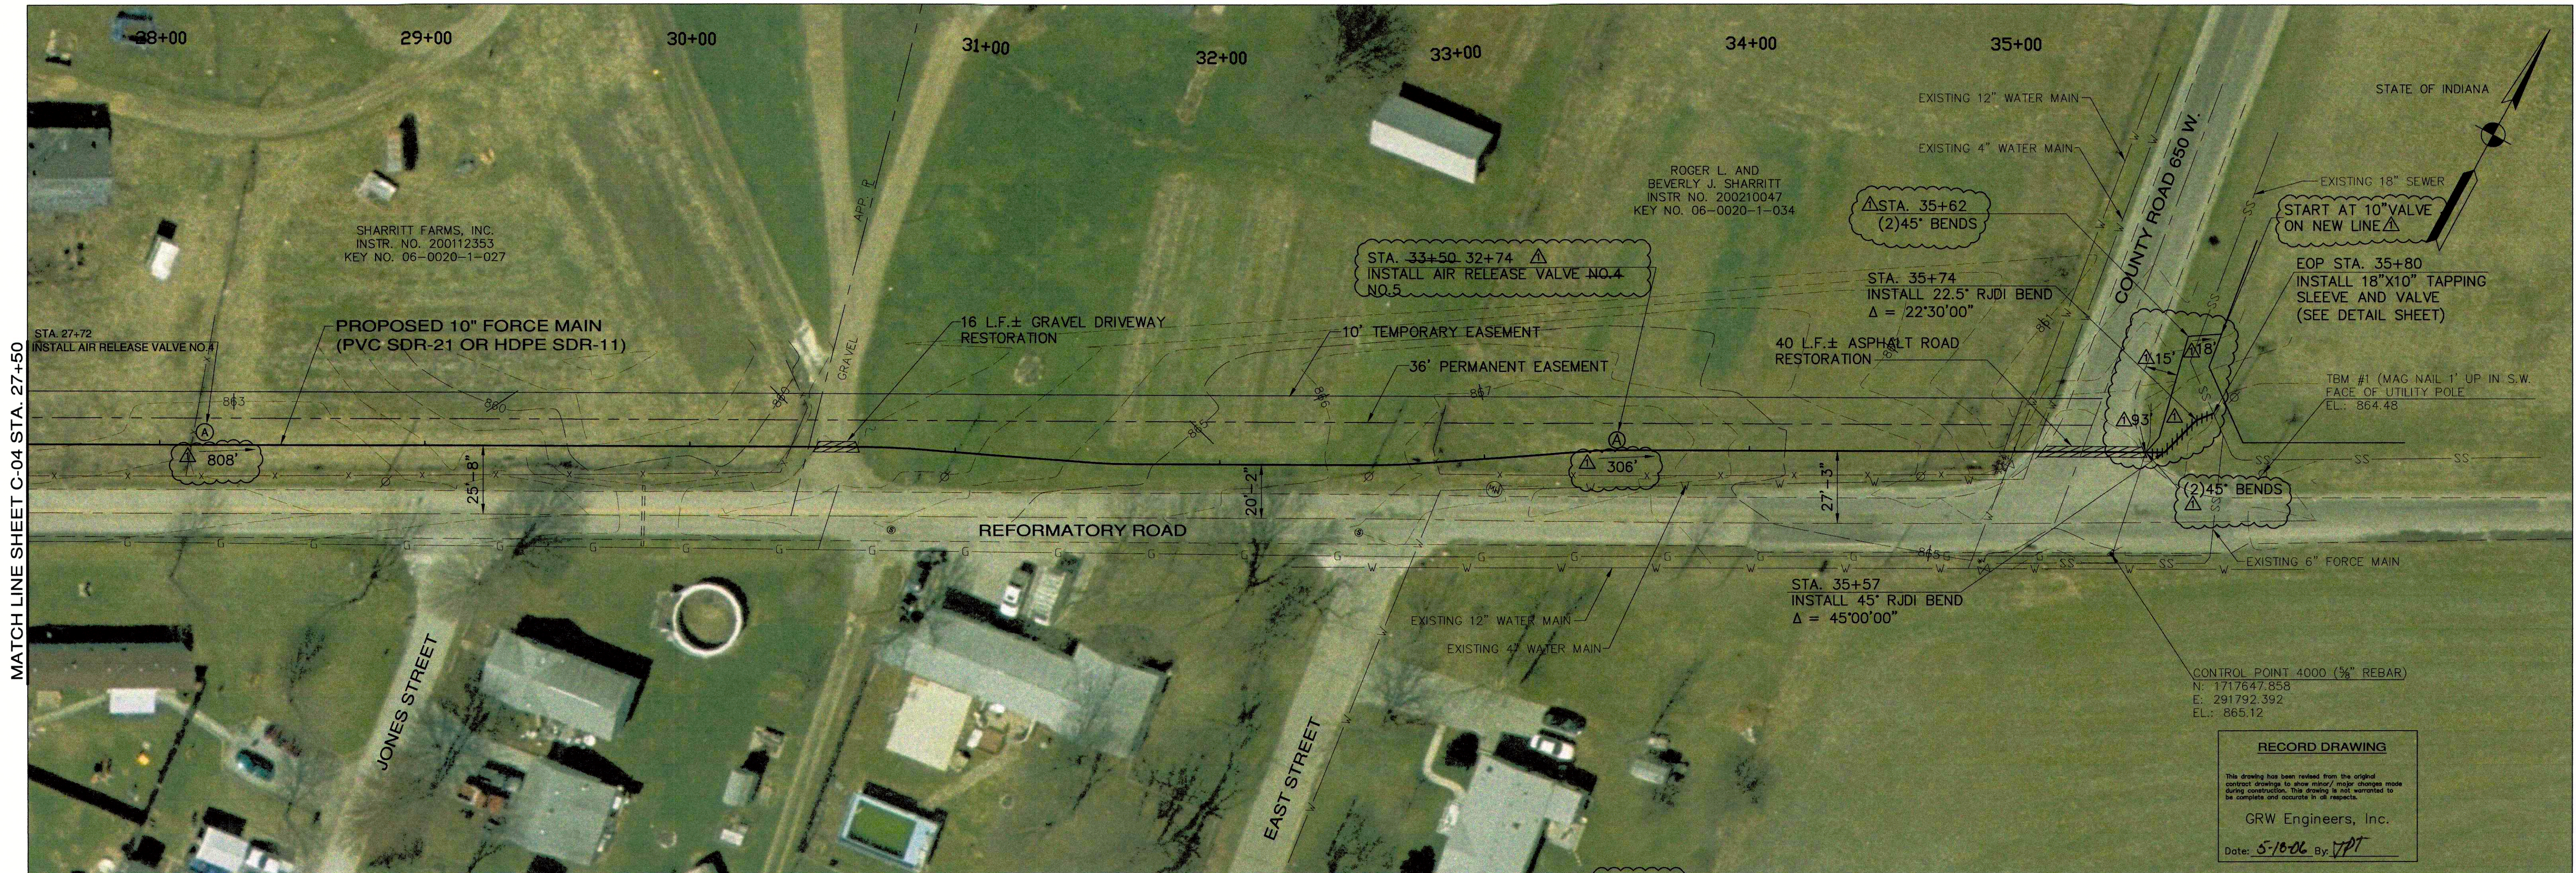

NOTES:

1.)

NO.	DESCRIPTION	DATE	BY
1	AS-BUILT REVISION	MAY 2006	SM

FALL CREEK REGIONAL WASTE DISTRICT
PENDLETON, INDIANA
INGALLS FORCE MAIN REPLACEMENT

PLAN AND PROFILE
STA. 27+50 TO STA. 35+80

GRW PROJECT NO. 3290-08

JOSEPH P. TURLEY
REGISTERED
No. 19300407
STATE OF INDIANA
PROFESSIONAL ENGINEER

GRW
GRW Engineers, Inc.
Engineers, Architects, Planners
INDIANAPOLIS, INDIANA
LOUISVILLE & LEXINGTON, KENTUCKY
CINCINNATI, OHIO
NASHVILLE, TENNESSEE
ARLINGTON, TEXAS

DRAWN: BJD	DATE: OCTOBER 2005
FILE NAME: 3290_C-05.dwg	SCALE: H: 1" = 30' ; V: 1" = 5'
CHECKED: JPT	SHEET NO. C-05
APPROVED: JPT	