

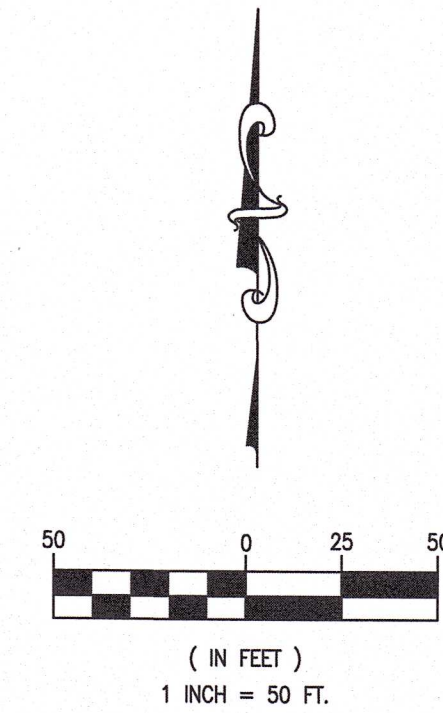
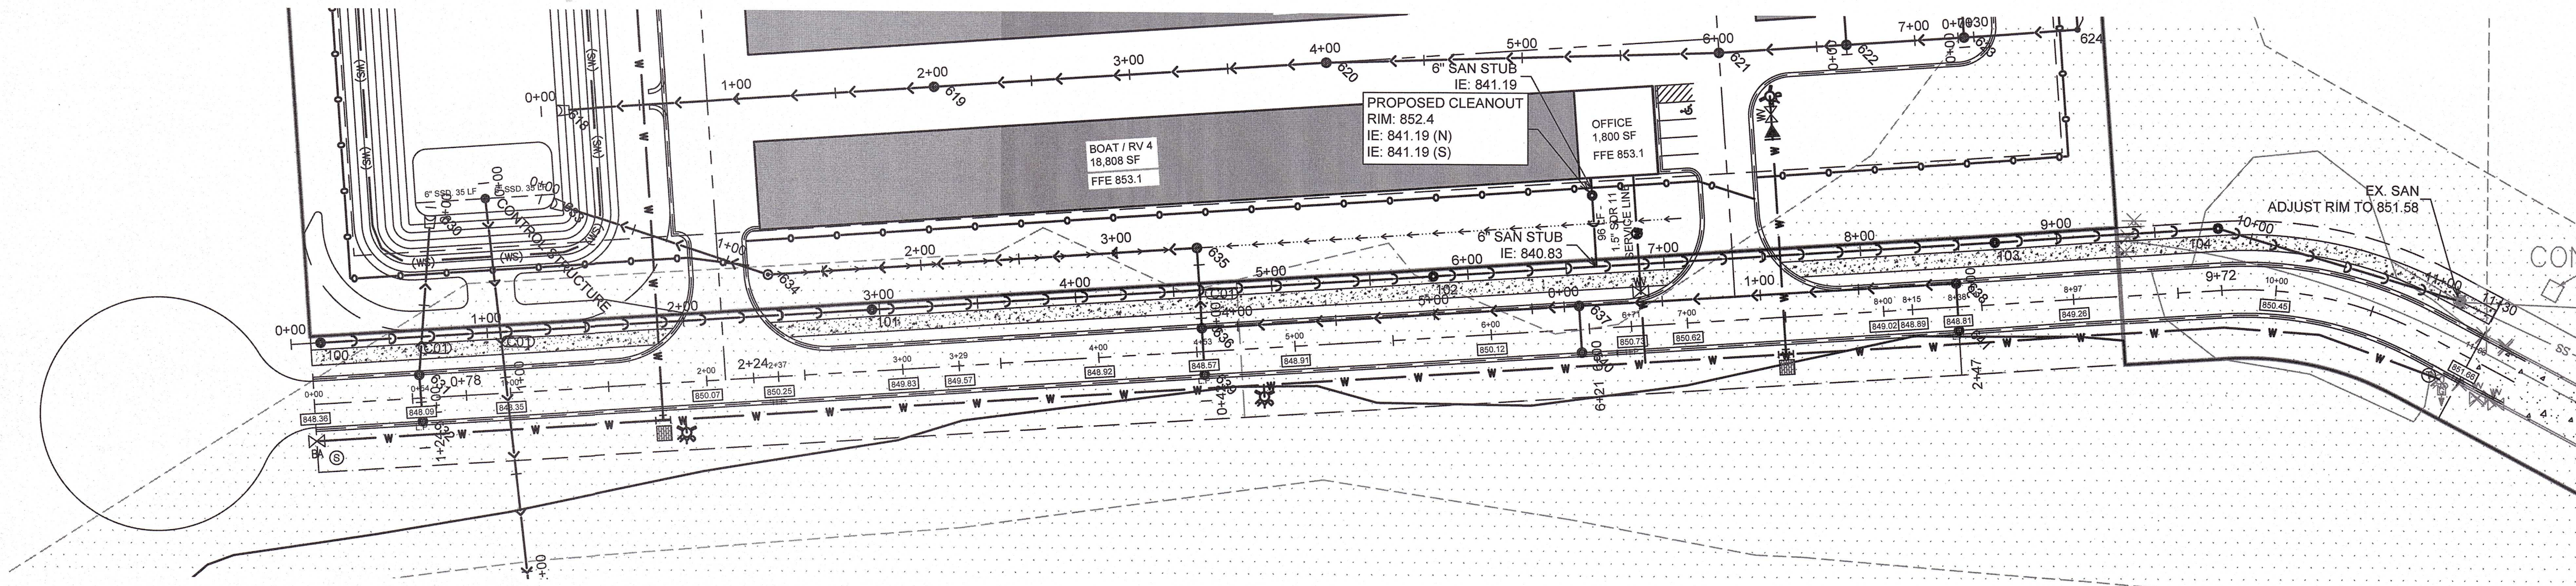


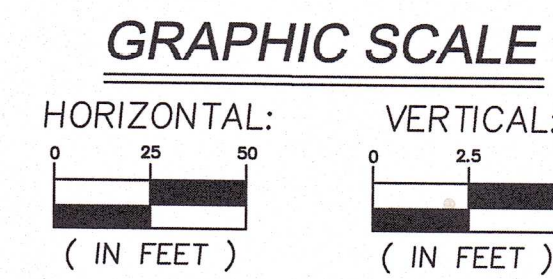

SANITARY

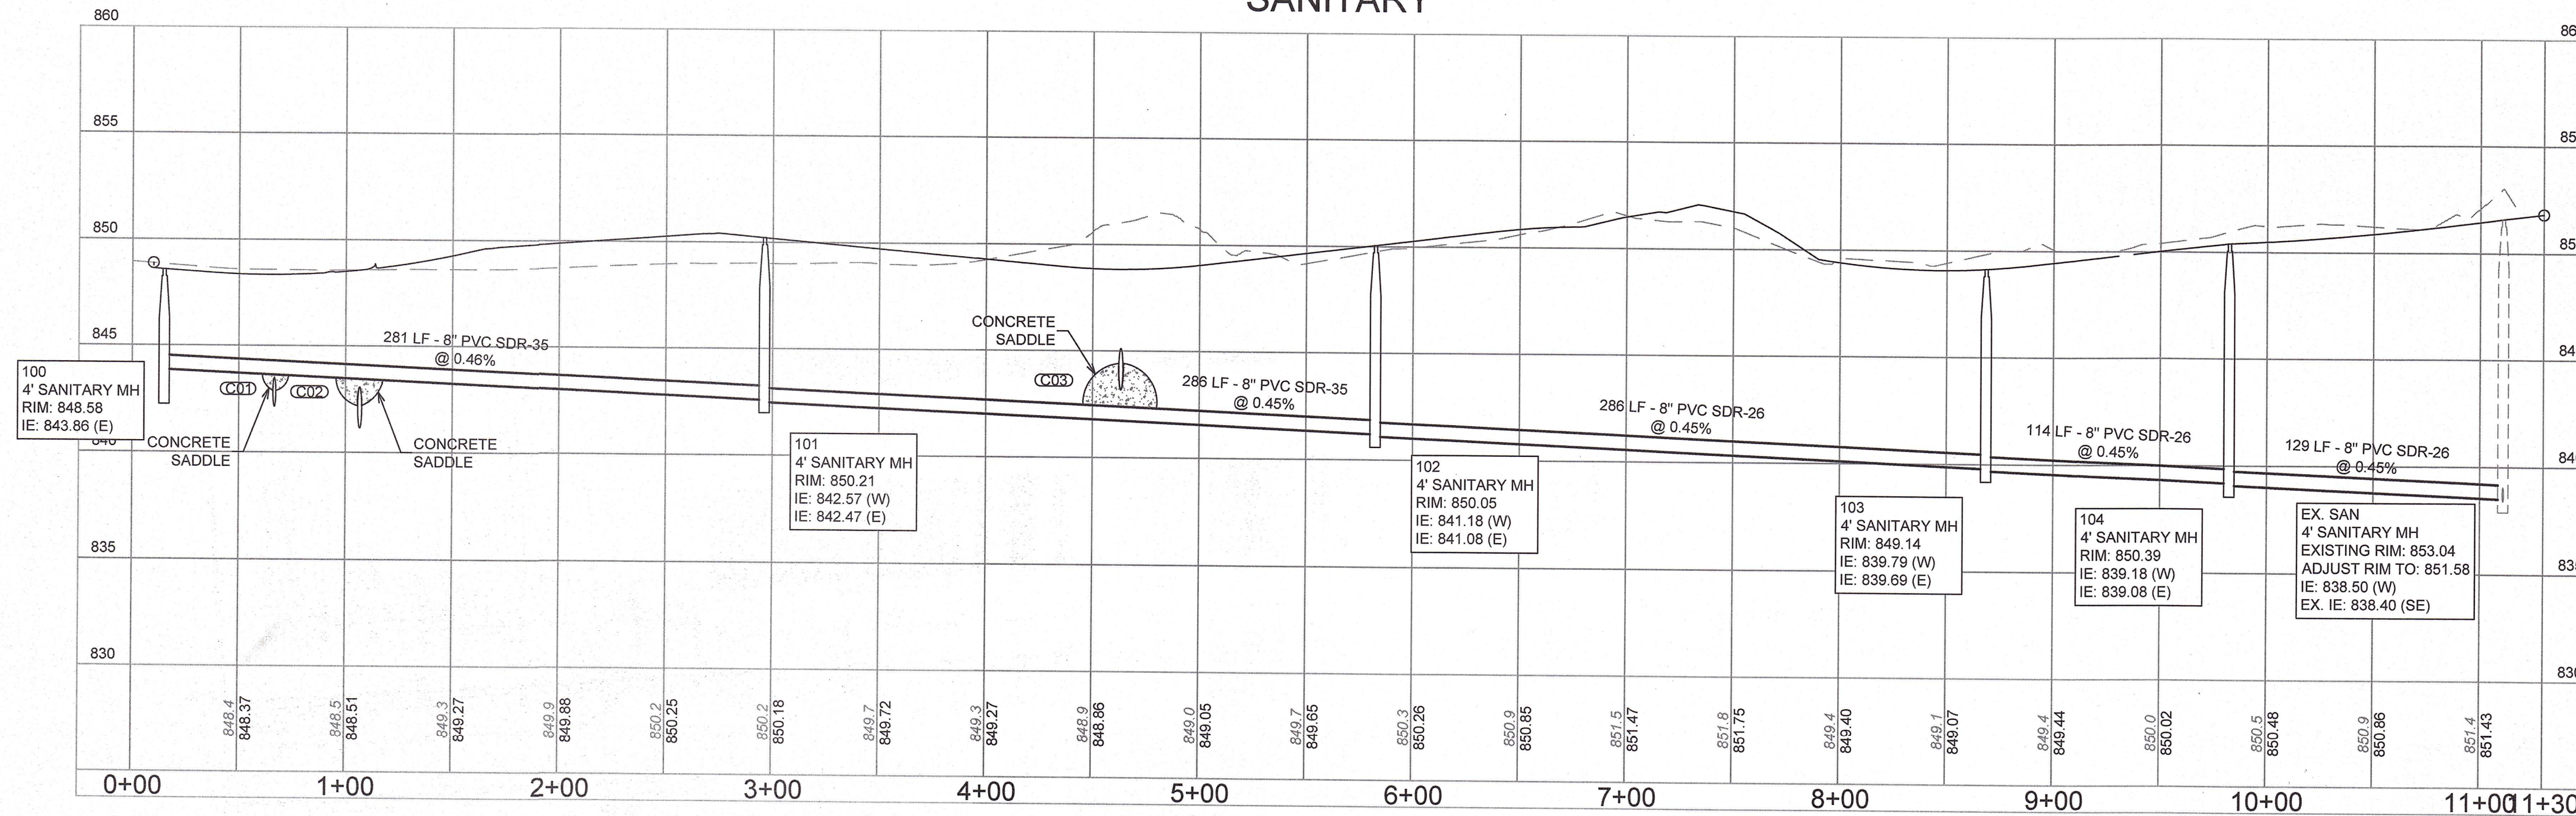

REVISIONS		DESCRIPTION	
NO.	DATE	DESCRIPTION	DATE
1			

PROJECT NO.: 19248	PROJECT MANAGER: DJO	DESIGNED BY: NAL	DRAWN BY: NAL
ORIGINAL ISSUE DATE: MAY 15, 2019			

SANITARY SEWER PLAN AND PROFILE


INGALLS PARK SELF STORAGE

INGALLS MADISON COUNTY INDIANA

619 N Pennsylvania St
Indianapolis, IN 46204
317.423.0690 phone
www.v3co.com

811
Know what's below.
Call before you dig.

DRAWING NO.
C6.5

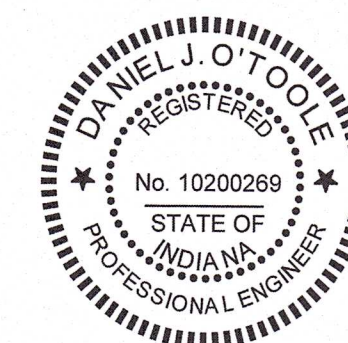

Daniel J. O'Toole