

NOTE:
ADDITIONAL RIGHT-OF-WAY OR EASEMENTS MAY
NEED TO BE ACQUIRED FOR INSTALLATION OF SEWER.



DON'T DIG BLIND
CALL BEFORE YOU DIG
1-800-382-5544
1-800-428-5200

PER INDIANA STATE LAW IS-69-1991, IT IS
AGAINST THE LAW TO EXCAVATE WITHOUT
NOTIFYING THE UNDERGROUND LOCATION SERVICE
TWO (2) WORKING DAYS BEFORE COMMENCING WORK.


NOTE: CONTRACTOR TO VERIFY ALL UTILITY LOCATIONS
PRIOR TO THE START OF CONSTRUCTION

- GENERAL NOTES:
- ALL UTILITY LOCATIONS ARE APPROXIMATE. THE CONTRACTOR SHALL HAVE ALL UTILITIES FIELD VERIFIED AND MARKED PRIOR TO CONSTRUCTION.
 - CONTRACTOR SHALL MAINTAIN A MINIMUM 10'-0" HORIZONTAL AND 18" VERTICAL SEPARATION BETWEEN SEWER AND WATER MAINS.
 - ALL PROPOSED TOP OF CASTING ELEVATIONS ARE APPROXIMATE. THE CONTRACTOR SHALL ADJUST FINAL ELEVATIONS AS REQUIRED TO BE FLUSH WITH PAVEMENT.
 - ALL SEWER TRENCHES SHALL BE BACKFILLED WITH FULL DEPTH COMPACTED GRANULAR BACKFILL ("B" BORROW) UNDER OR WITHIN 5' OF EDGE OF PAVEMENT.
 - THE CONTRACTOR SHALL VISIT THE SITE PRIOR TO BID TO BECOME FAMILIAR WITH ALL SITE CONDITIONS.
 - THE CONTRACTOR SHALL PROVIDE THE REQUIRED MEANS FOR MAINTAINING SAFE TRAFFIC AT ALL TIMES.
 - CONTRACTOR SHALL RESTORE ALL DISTURBED LAWN AREAS, STREETS, WALKS, DRIVES, ETC. AS SHOWN ON DRAWINGS, IN THE SPECIFICATIONS, OR TO AT LEAST PRE-EXISTING CONDITIONS.
 - ALL UTILITY CROSSINGS SHALL BE PROTECTED AND SUPPORTED WITH GRANULAR FILL OR CONCRETE AS REQUIRED PER THE DETAIL SHEET.

- LEGEND:
- | | | | | |
|--------------|------------|----------------------------------|-----------|-----------------------------------|
| TREE | 1085 | CONTOUR | — E — | UNDERGROUND ELECTRIC LINE |
| POWER POLE | — X — X — | FENCE | — T — | UNDERGROUND TELEPHONE LINE |
| GUY WIRE | — MH — | EXIST. SANITARY SEWER w/ MANHOLE | — — — | APPROX. RIGHT-OF-WAY |
| FIRE HYDRANT | — SC — | NEW SANITARY SEWER w/ MANHOLE | — . . . — | APPROX. CORPORATE LIMITS |
| MAILBOX | — SC — | NEW SANITARY SERVICE CONNECTION | — — — | APPROX. PROPERTY LINE |
| FLAGPOLE | — 4" — W — | WATER LINE | — O W — | EXISTING WATER WELL |
| SPOT SHOT | — 2" — G — | GAS LINE | — S — | EXISTING SEPTIC TANK |
| | | | — W O — | PROPOSED GRINDER PUMP VALVE VAULT |

NORTH

SCALE:
HORIZONTAL 1" = 50'
VERTICAL 1" = 5'

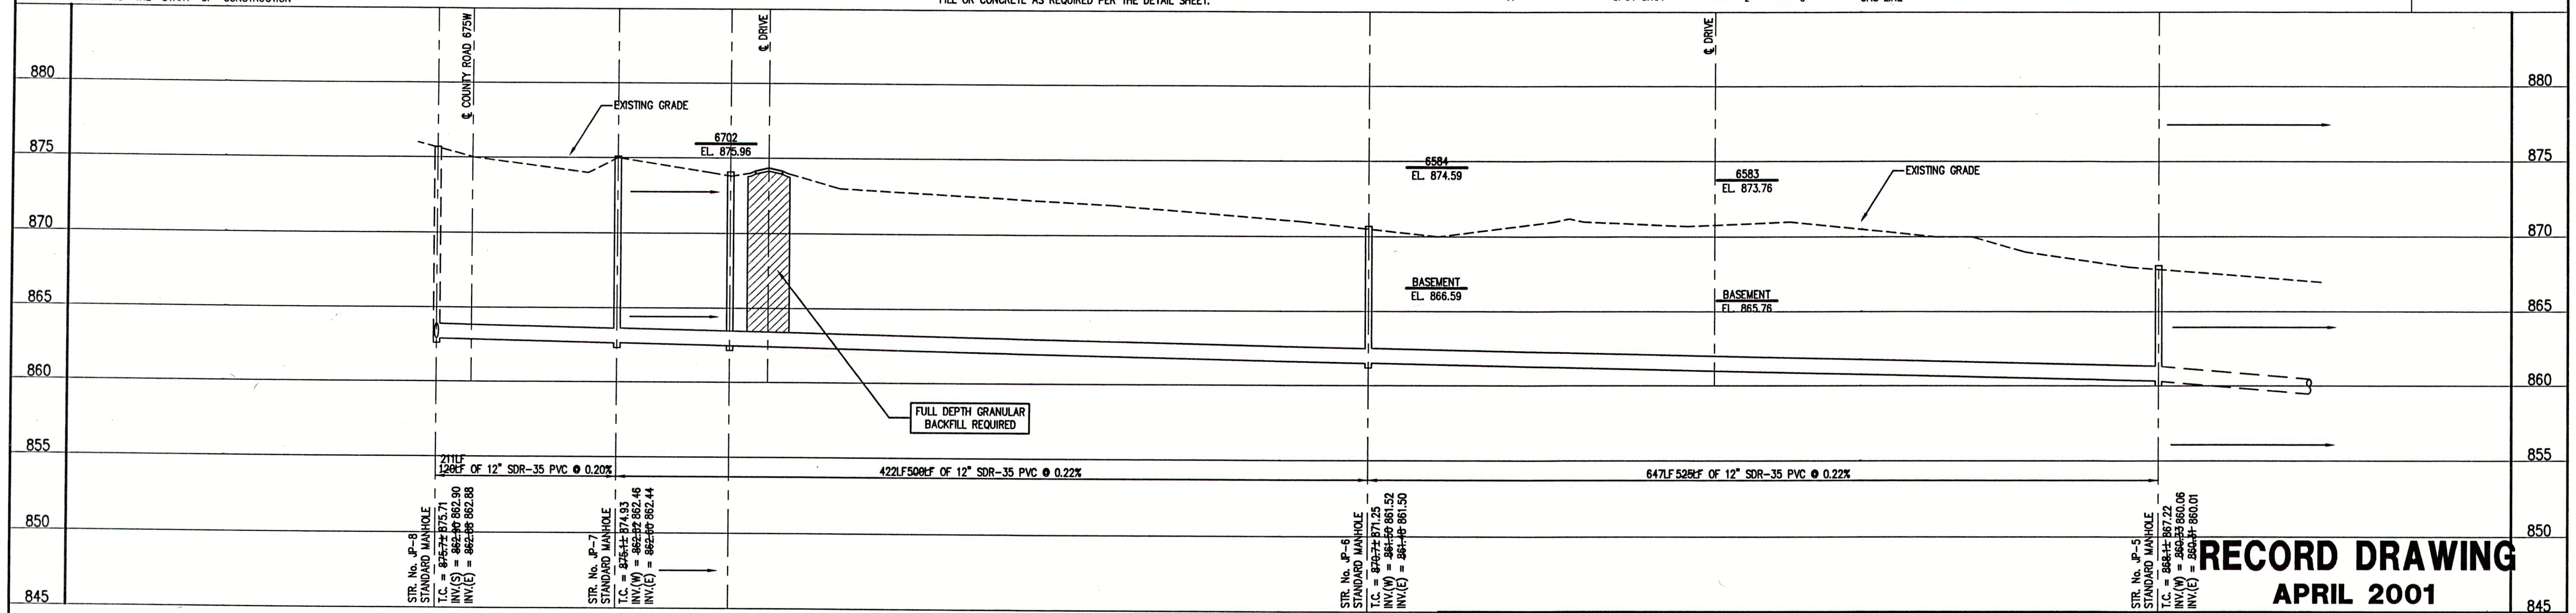

NOTE:
THE CONTRACTOR SHALL INCLUDE IN THE COSTS FOR SANITARY PIPE, ALL WATER SERVICE RECONNECTIONS, STORM SEWER RECONNECTION, WATER MAIN RELOCATIONS, CONCRETE RECONSTRUCTION, AND SIDEWALK RECONSTRUCTION AS REQUIRED TO INSTALL NEW WORK AS SHOWN ON THE DRAWINGS.

FILE NAME: JP_2-REC		PLOT SCALE: 1=50	PLOT DATE: 04/04
NO.	DATE	DESCRIPTION	BY

TRIAD ASSOCIATES INC.
INDIANAPOLIS, INDIANA

APPROVED BY:
THOMAS M. SCHUBERT
No. 15614
PROFESSIONAL ENGINEER
STATE OF INDIANA

RECORD DRAWING
APRIL 2001

JEFFERSON PL., CO. RD. 600W & CO. RD. 675W
FALL CREEK REGIONAL WASTE DISTRICT

PLAN AND PROFILE

DRAWN BY:	DATE	PROJECT No.	SHEET No.
DAP	04/12/98	98008A	6
DESIGNED BY:	SCALE	AS NOTED	20
D.A. Pauling			
CHECKED BY:			
James W. Frazell, P.E.			