

NOTE:
ADDITIONAL RIGHT-OF-WAY OR EASEMENTS MAY
NEED TO BE ACQUIRED FOR INSTALLATION OF SEWER.

**DON'T DIG BLIND
CALL BEFORE YOU DIG**
TOLL FREE
1-800-362-5544
INDIANA
1-800-428-5200

PER INDIANA STATE LAW 15-19-1991, IT IS
AGAINST THE LAW TO EXCAVATE WITHOUT
NOTIFYING THE UNDERGROUND LOCATION SERVICE
TWO (2) WORKING DAYS BEFORE COMMENCING WORK.

NOTE: CONTRACTOR TO VERIFY ALL UTILITY LOCATIONS
PRIOR TO THE START OF CONSTRUCTION

GENERAL NOTES:

1. ALL UTILITY LOCATIONS ARE APPROXIMATE. THE CONTRACTOR SHALL HAVE ALL UTILITIES FIELD VERIFIED AND MARKED PRIOR TO CONSTRUCTION.
2. CONTRACTOR SHALL MAINTAIN A MINIMUM 10'-0" HORIZONTAL AND 18" VERTICAL SEPARATION BETWEEN SEWER AND WATER MAINS.
3. ALL PROPOSED TOP OF CASTING ELEVATIONS ARE APPROXIMATE. THE CONTRACTOR SHALL ADJUST FINAL ELEVATIONS AS REQUIRED TO BE FLUSH WITH PAVEMENT.
4. ALL SEWER TRENCHES SHALL BE BACKFILLED WITH FULL DEPTH COMPACTED GRANULAR BACKFILL ("B" BORROW) UNDER OR WITHIN 5' OF EDGE OF PAVEMENT.
5. THE CONTRACTOR SHALL VISIT THE SITE PRIOR TO BID TO BECOME FAMILIAR WITH ALL SITE CONDITIONS.
6. THE CONTRACTOR SHALL PROVIDE THE REQUIRED MEANS FOR MAINTAINING SAFE TRAFFIC AT ALL TIMES.
7. CONTRACTOR SHALL RESTORE ALL DISTURBED LAWN AREAS, STREETS, WALKS, DRIVES, ETC. AS SHOWN ON DRAWINGS, IN THE SPECIFICATIONS, OR TO AT LEAST PRE-EXISTING CONDITIONS.
8. ALL UTILITY CROSSINGS SHALL BE PROTECTED AND SUPPORTED WITH GRANULAR FILL OR CONCRETE AS REQUIRED PER THE DETAIL SHEET.


NOTE:
ALL SERVICE CONNECTION VALVE VAULTS SHALL
BE PLACED AT, AND WITHIN, RIGHT-OF-WAY LINE.

LEGEND:

TREE	1085	CONTOUR	— — — — —	UNDERGROUND ELECTRIC LINE
POWER POLE	X X	FENCE	— — — — —	UNDERGROUND TELEPHONE LINE
GUY WIRE	— — — — —	EXIST. SANITARY SEWER w/ MANHOLE	— — — — —	APPROX. RIGHT-OF-WAY
FIRE HYDRANT	SC	NEW SANITARY SEWER w/ MANHOLE	— — — — —	APPROX. CORPORATE LIMITS
MAILBOX	— — — — —	NEW SANITARY SERVICE CONNECTION	— — — — —	APPROX. PROPERTY LINE
FLAGPOLE	— — — — —	WATER LINE	— — — — —	EXISTING WATER WELL
SPOT SHOT	— — — — —	GAS LINE	— — — — —	EXISTING SEPTIC TANK
				PROPOSED GRINDER PUMP VALVE VAULT



SCALE:
HORIZONTAL 1" = 50'
VERTICAL 1" = 5'

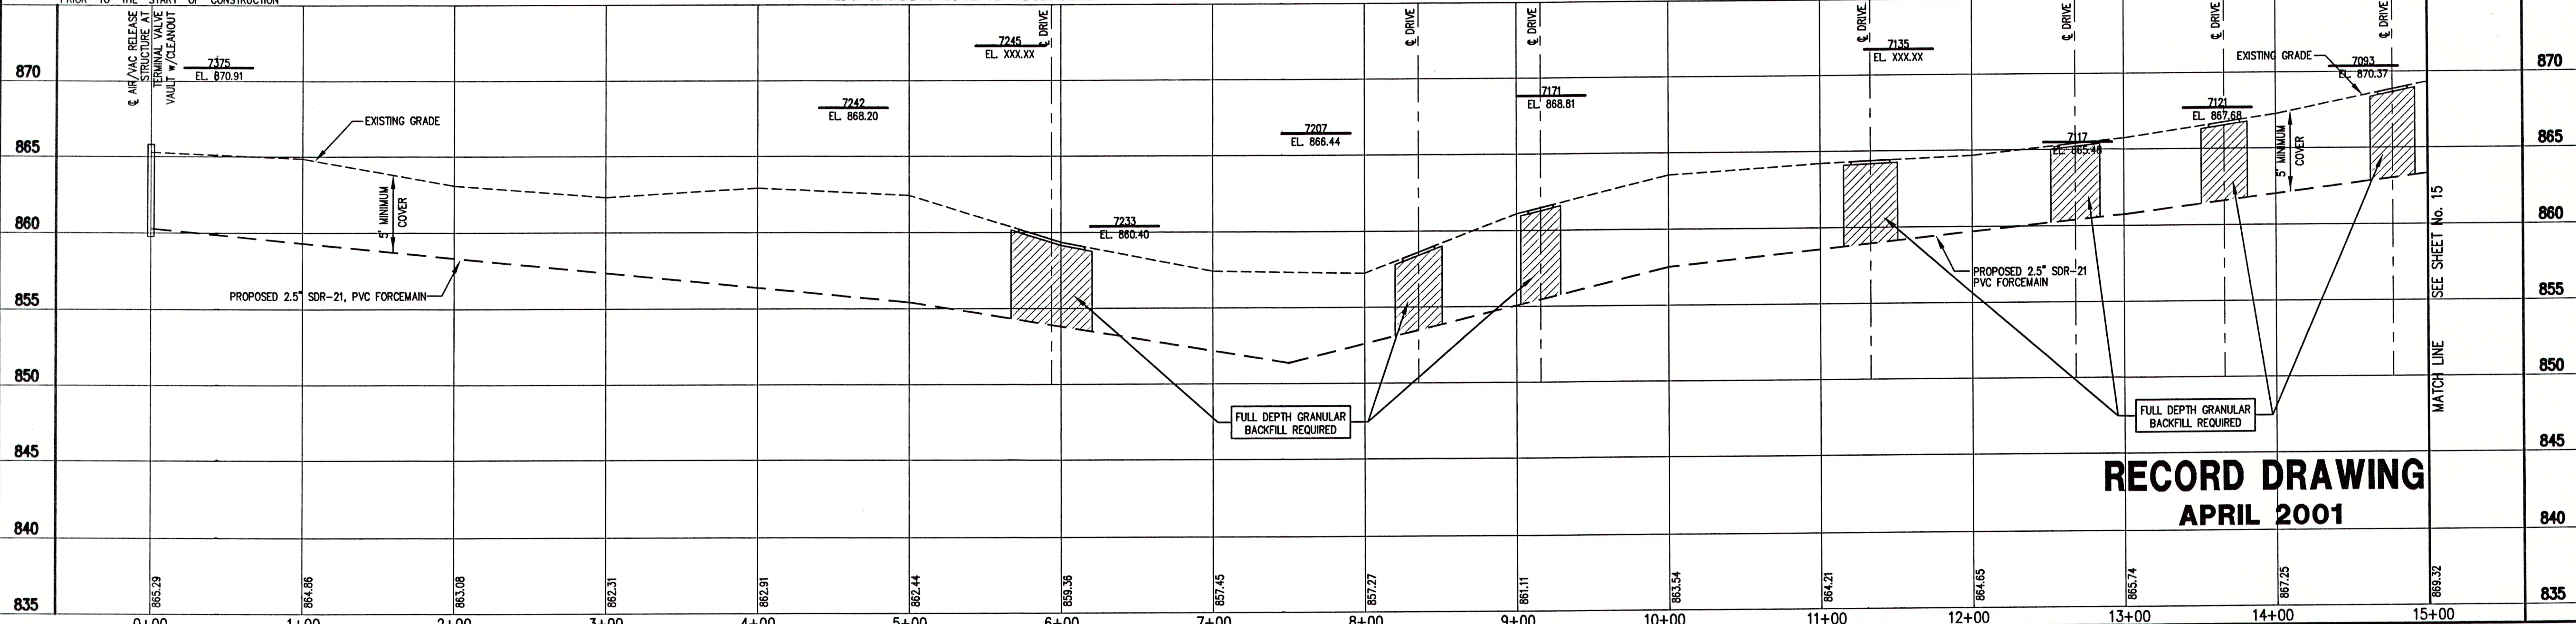

**RECORD DRAWING
APRIL 2001**

NOTE:
THE CONTRACTOR SHALL INCLUDE IN THE COSTS FOR SANITARY PIPE,
ALL WATER SERVICE RECONNECTIONS, STORM SEWER RECONNECTION,
WATER MAIN RELOCATIONS, CONCRETE RECONSTRUCTION, AND
SIDEWALK RECONSTRUCTION AS REQUIRED TO INSTALL NEW WORK
AS SHOWN ON THE DRAWINGS.

FILE NAME:	1002-REC	PLOT SCALE:	1=1	PLOT DATE:	04/05
NO.	DATE	DESCRIPTION	BY		

**TRIAD
ASSOCIATES
INC.**
INDIANAPOLIS, INDIANA

APPROVED BY:

Thomas M. Schubert, P.E.

JEFFERSON PL., CO. RD. 600W & CO. RD. 675W
FALL CREEK REGIONAL WASTE DISTRICT

PLAN AND PROFILE

DRAWN BY:	DATE	PROJECT No.	SHEET No.
DAP	04/12/98	980008A	16
DESIGNED BY:	D.A. Pauling		20
CHECKED BY:	James W. Frazell, P.E.		