

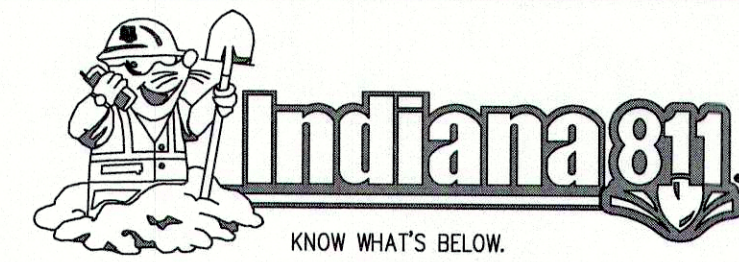


Plot Date: Aug 01, 2018 Plot Time: 2:36pm File Name: W:\Arbor Homes\2017-095-B Arbor- Maple Trails Sec. 2\Design\CAD\17095B-Sanitary Plan.dwg, Layout: C4.1 By: tdoivis

SANITARY PROFILE
VERTICAL SCALE: 1" = 5'
HORIZONTAL SCALE: 1" = 50'

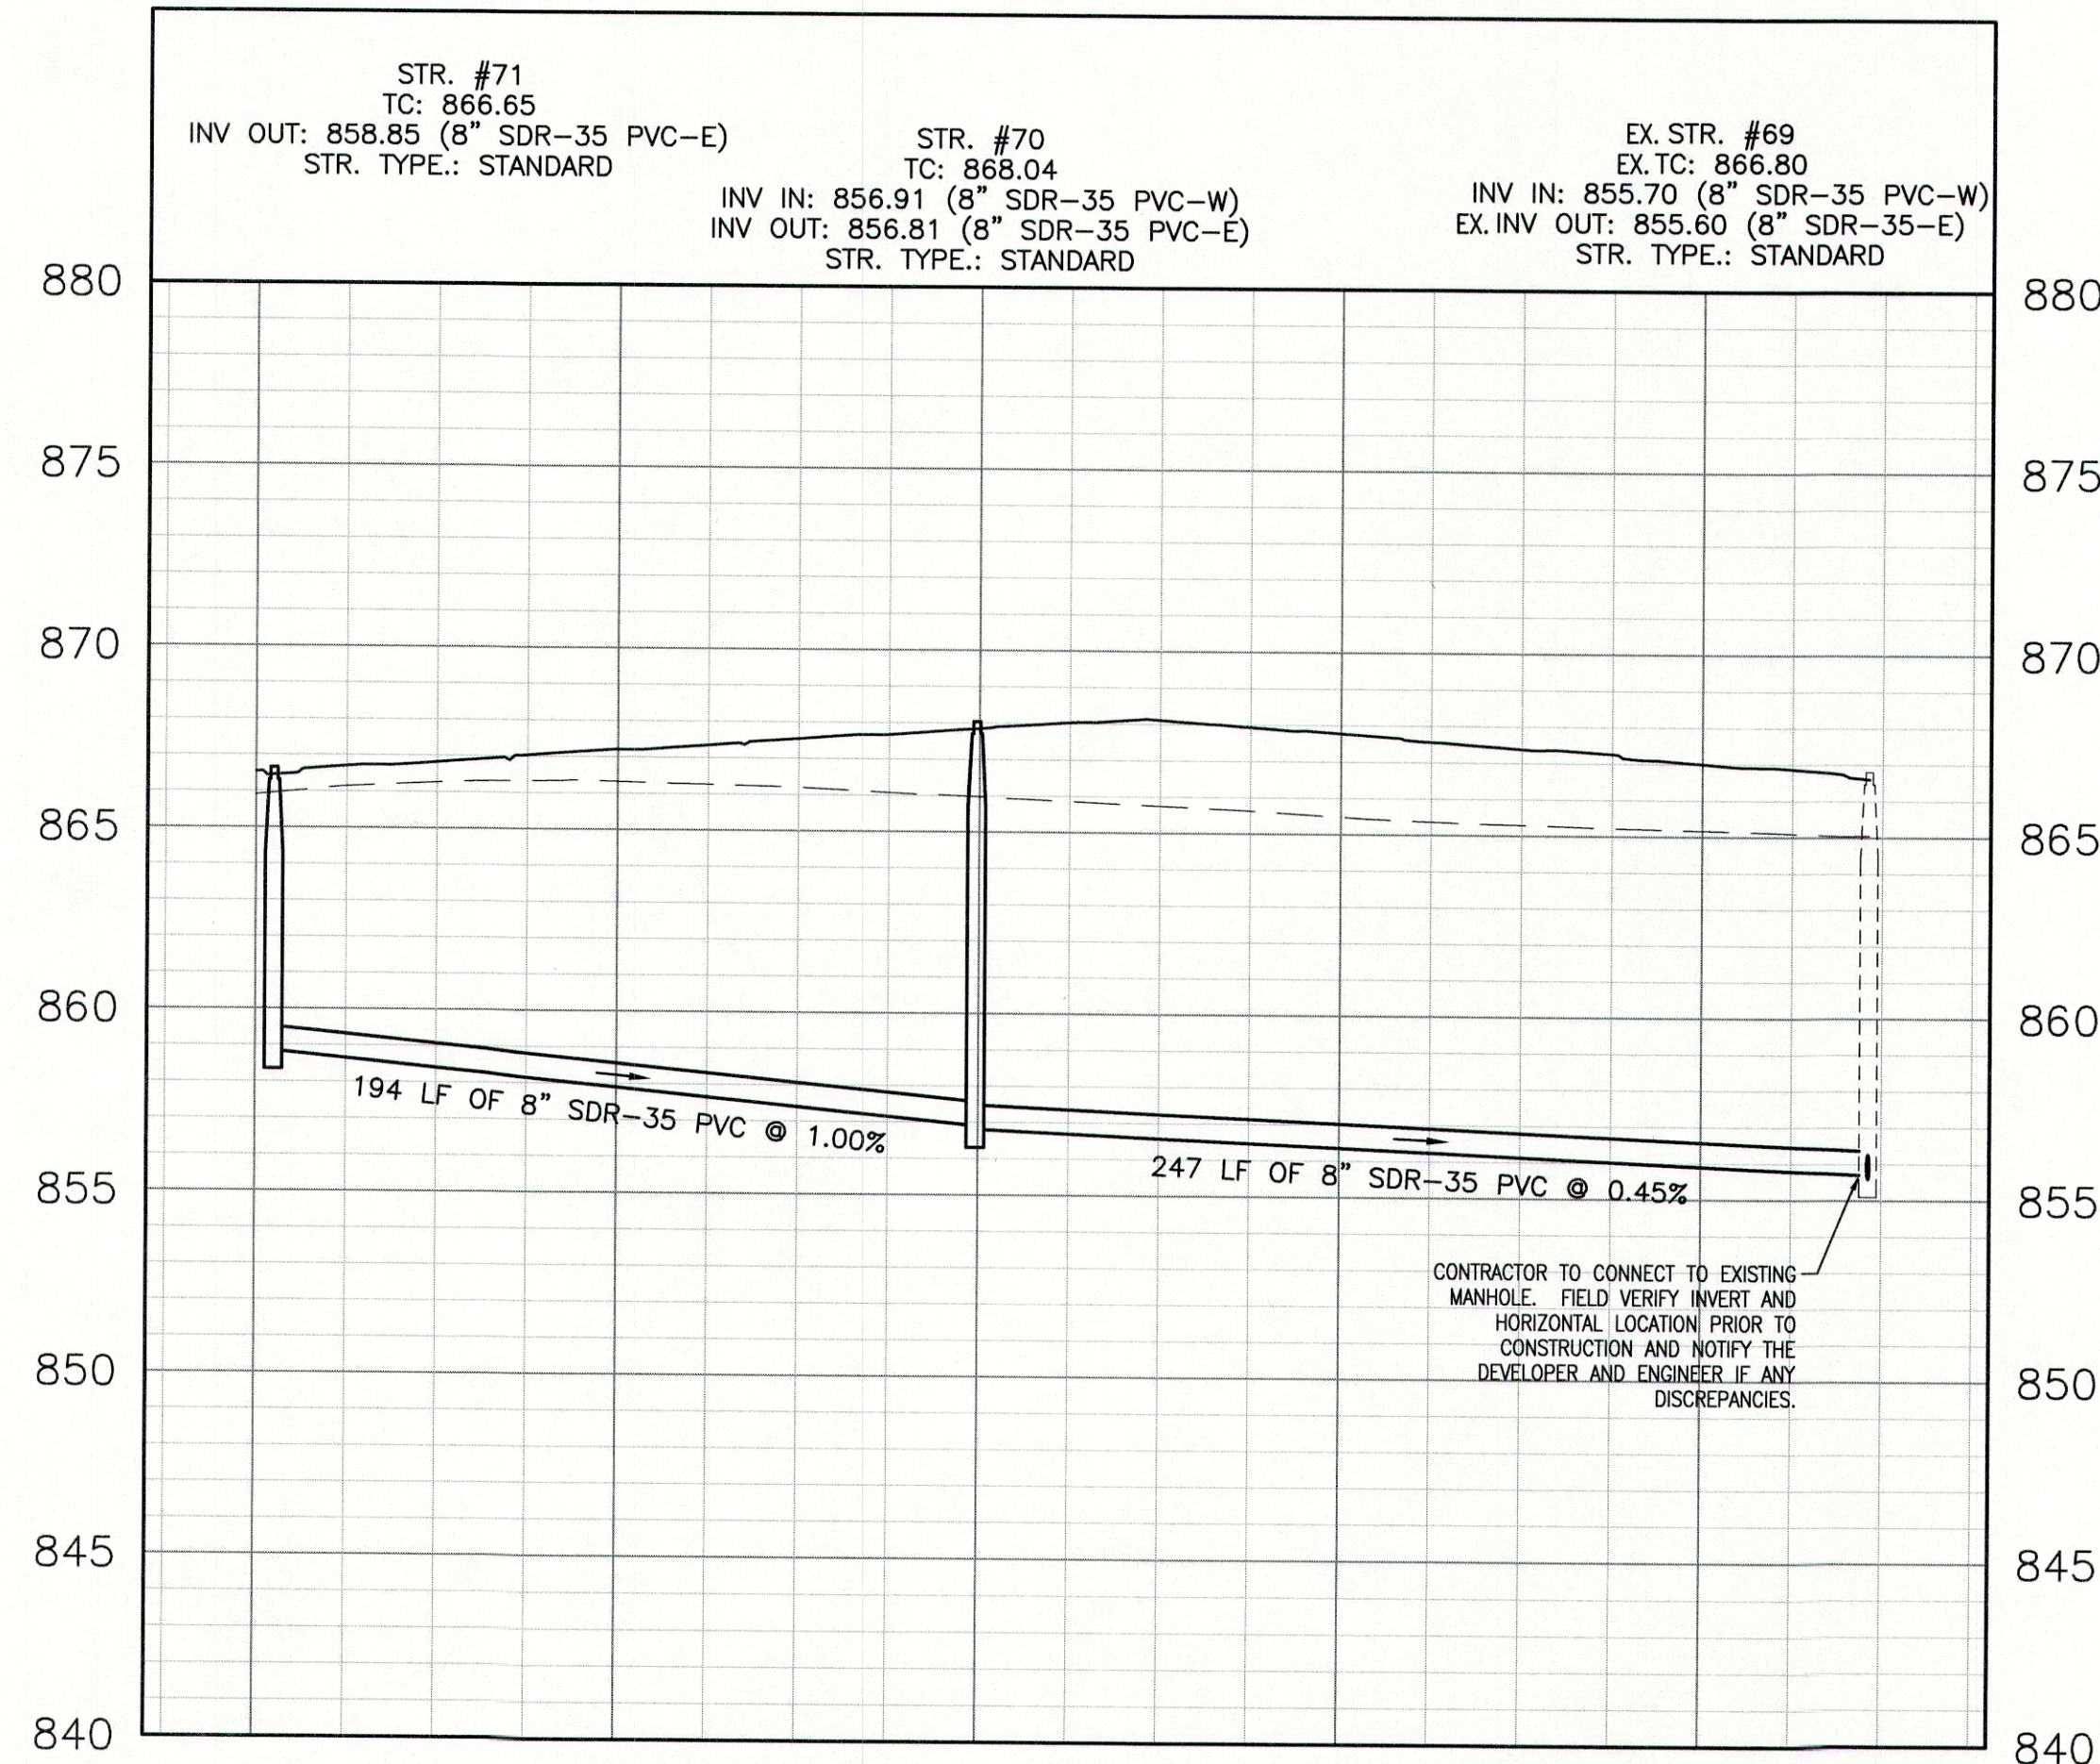

Call 811 or 800-382-5544 Before you Dig!

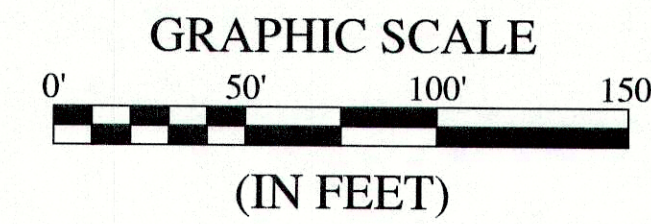

BENCHMARK INFORMATION:
ORIGINATING BENCHMARK: INDOT 48-G-0085
A BRONZE PLATE IN THE NORTH END OF THE EAST SIDEWALK OF CR 650 W BRIDGE (STR 169-15-05323, NBI 39070) OVER I-69, ALSO 18 FEET SOUTH OF THE NORTH END OF THE BRIDGE.
ELEV = 880.30 (NGVD 29)
ELEV = 879.87 (NAVD 88)

TBM #1
SOUTHWEST UPPER BONNET BOLT
50 FEET SOUTH OF CL 800 SOUTH & 15 FEET WEST OF CL 650 WEST
ELEV = 870.36 (NAVD 88)

TBM #2
SOUTHWEST UPPER BONNET BOLT
670 FEET SOUTH OF CL 800 SOUTH & 15 FEET WEST OF CL 650 WEST
ELEV = 866.74 (NAVD 88)

TBM #3
SOUTHWEST UPPER BONNET BOLT
1665 FEET SOUTH OF CL 800 SOUTH & 17 FEET WEST OF CL 650 WEST
ELEV = 866.25 (NAVD 88)

TBM #4
SOUTHWEST UPPER BONNET BOLT
1290 FEET NORTH OF CL FALL CREEK DRIVE & 17 FEET WEST OF CL 650 WEST
ELEV = 864.08 (NAVD 88)

LEGEND:


EXISTING	PROPOSED
---	RIGHT-OF-WAY LINE
---	EASEMENT LINE
---	SETBACK LINE
---	CENTERLINE
---	SWALE / FLOWLINE
---	CURB UNDERDRAIN
---	SANITARY SEWER
---	STORM SEWER
---	STORM CULVERT
---	WATER MAIN
---	SANITARY MANHOLE
---	STORM MANHOLE
---	STORM INLET
---	STORM END SECTION
---	FIRE HYDRANT
---	PROFILLED PIPELINE
EX	EXISTING
INV	INVERT ELEVATION
MH	MANHOLE
PVC	POLYVINYL CHLORIDE PIPE
TC	TOP OF CASTING GRADE

GRANULAR BACKFILL
EXISTING GRADE
PROPOSED GRADE

DATE	DESCRIPTION	BY

HWC
ENGINEERING
INDIANAPOLIS - TERRE HAUTE
LAFAYETTE - MUNCIE - NEW ALBANY
www.hwcengineering.com

MAPLE TRAILS
SECTION 2
SANITARY SEWER PLAN & PROFILE

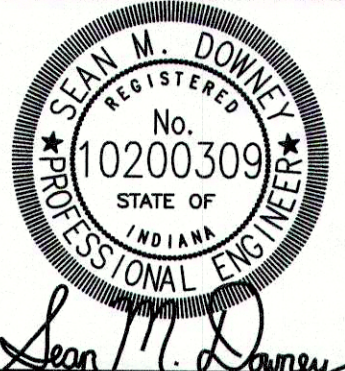

DRAWN BY TD	JOB NUMBER 2017-095-B
CHECKED BY SD	
DATE AUGUST 7, 2018	
SCALE AS SHOWN	
SHEET	

C4.1
SANITARY SEWER PLAN & PROFILE