



File Name: W:\Arbor Homes\2017-095-C Arbor- Maple Trails Sec 3\Design\CAD\17095C-Sanitary Plan.dwg, Layout: C4.1 By: tsmtsh Plot Date: Aug 07, 2019 Plot Time: 3:03pm

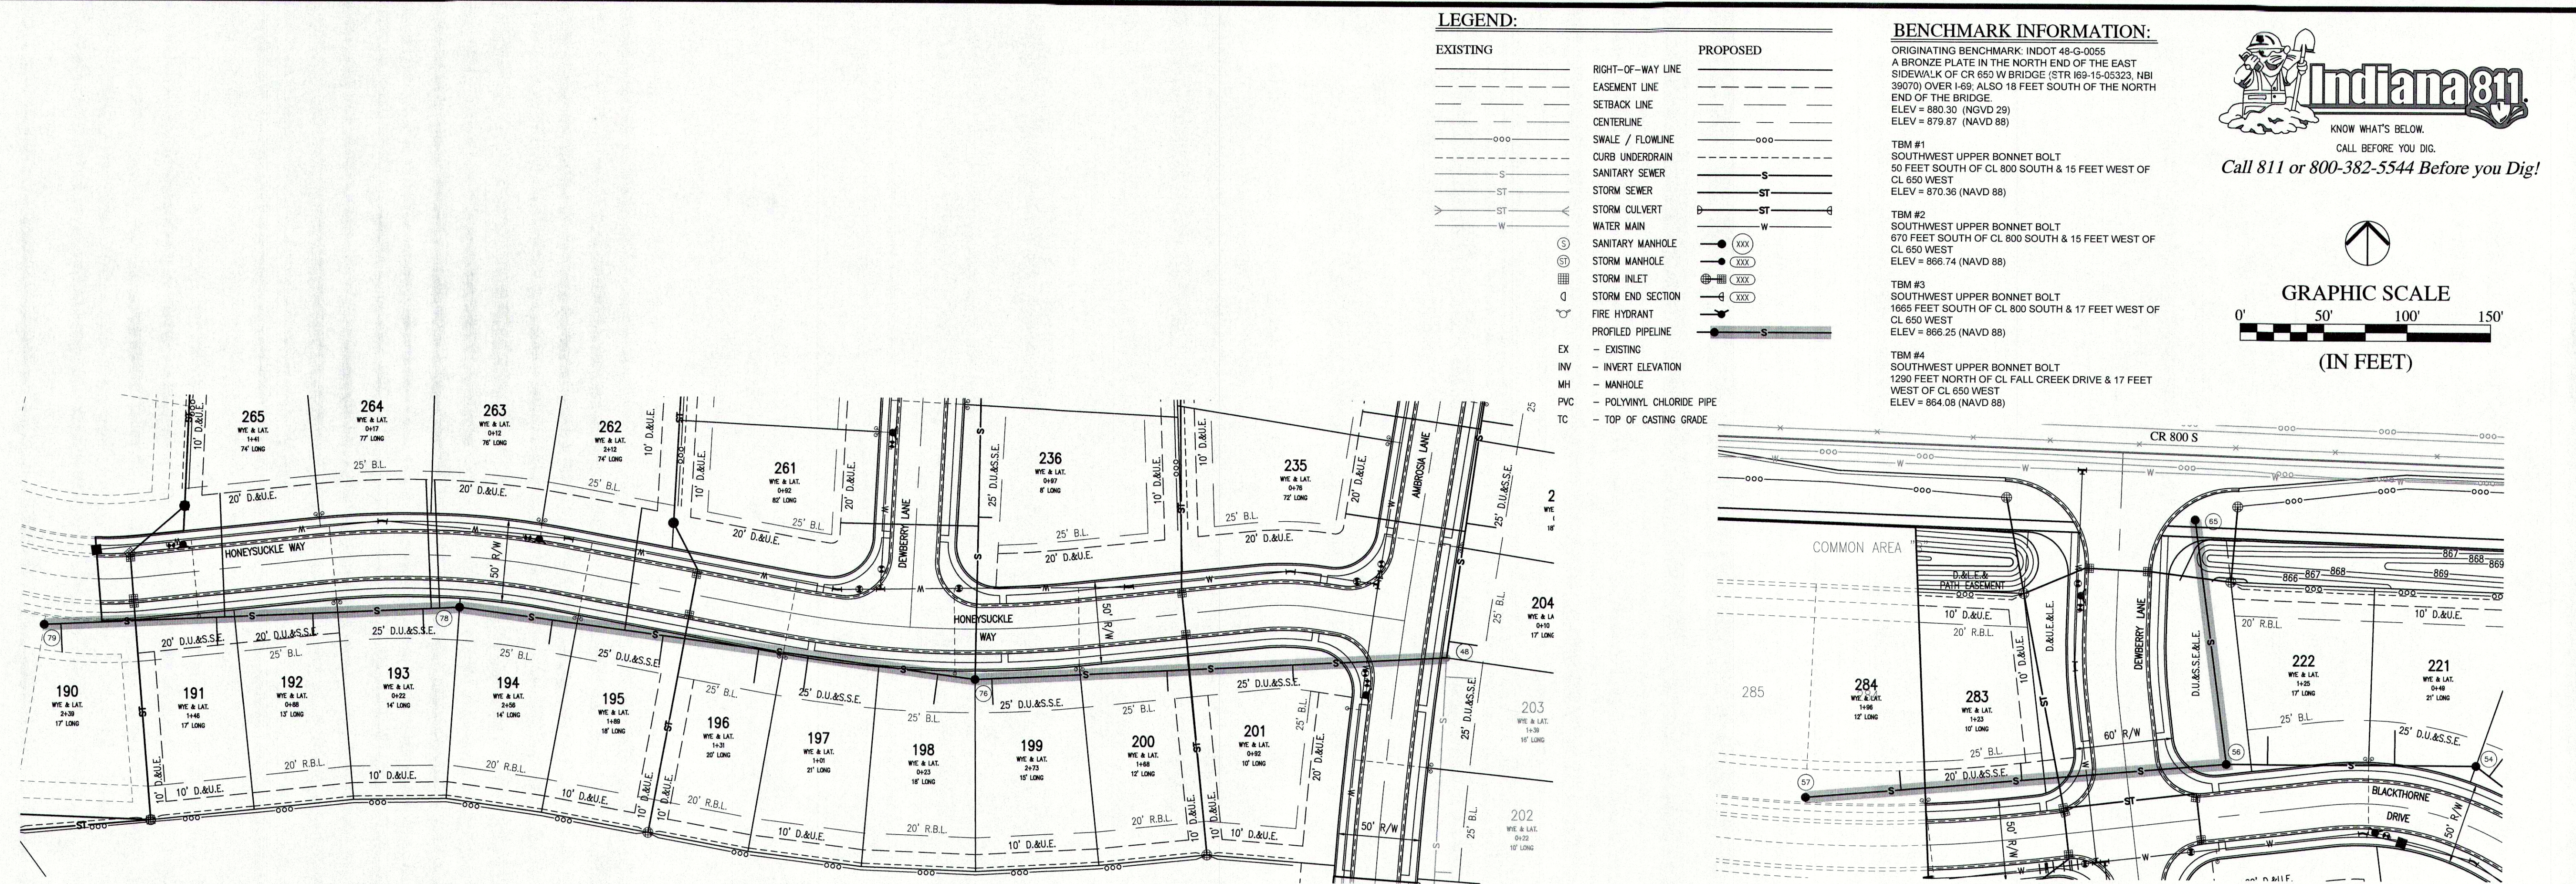

SANITARY PROFILE

VERTICAL SCALE: 1" = 5'
HORIZONTAL SCALE: 1" = 50'

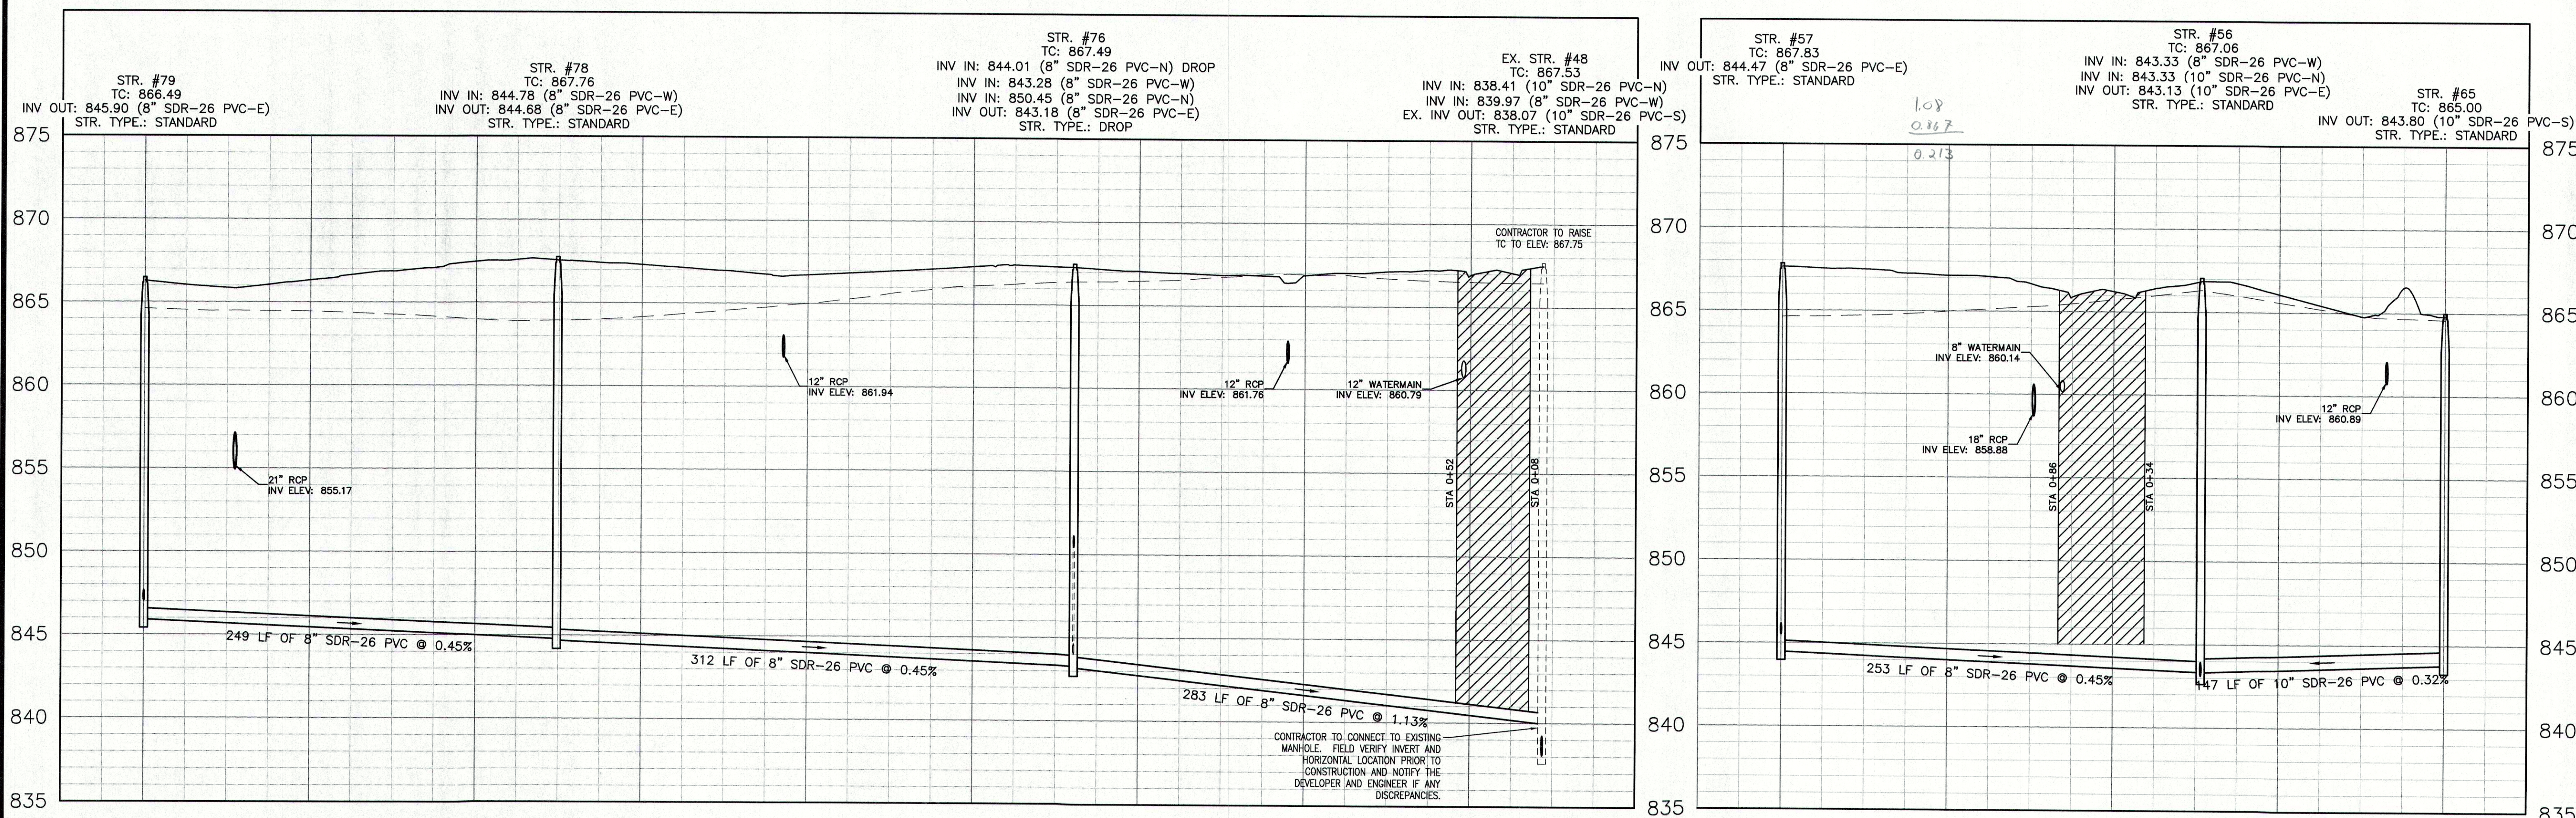

REVISIONS		
DATE	DESCRIPTION	BY



MAPLE TRAILS SECTION 3 SANITARY SEWER PLAN & PROFILE

REGISTERED PROFESSIONAL ENGINEER
No. 11400758
STATE OF INDIANA
Kristopher K. Eichhorn

DRAWN BY: TS
CHECKED BY: KE
DATE: AUGUST 7, 2019
SCALE: AS SHOWN
SHEET: C4.1
SANITARY SEWER PLAN & PROFILE

JOB NUMBER: 2017-095-C