
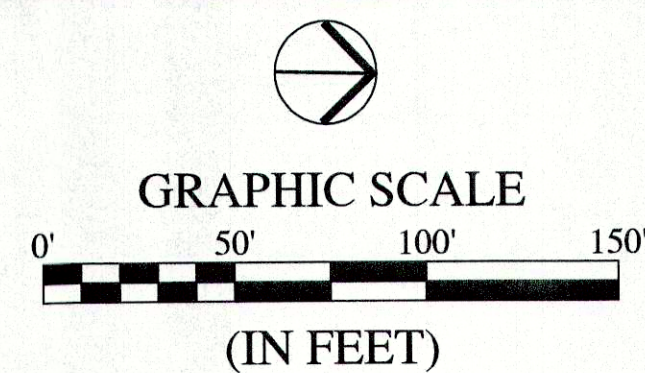


Plot Date: Aug 07, 2019 Plot Time: 3:04pm File Name: W:\Arbor Homes\2017-095-C Arbor- Maple Trails Sec. 3\Design\CAD\17095C Sanitary Plan.dwg Layout: C4.2 By: tsmith

SANITARY PROFILE

VERTICAL SCALE: 1" = 5'
HORIZONTAL SCALE: 1" = 50'

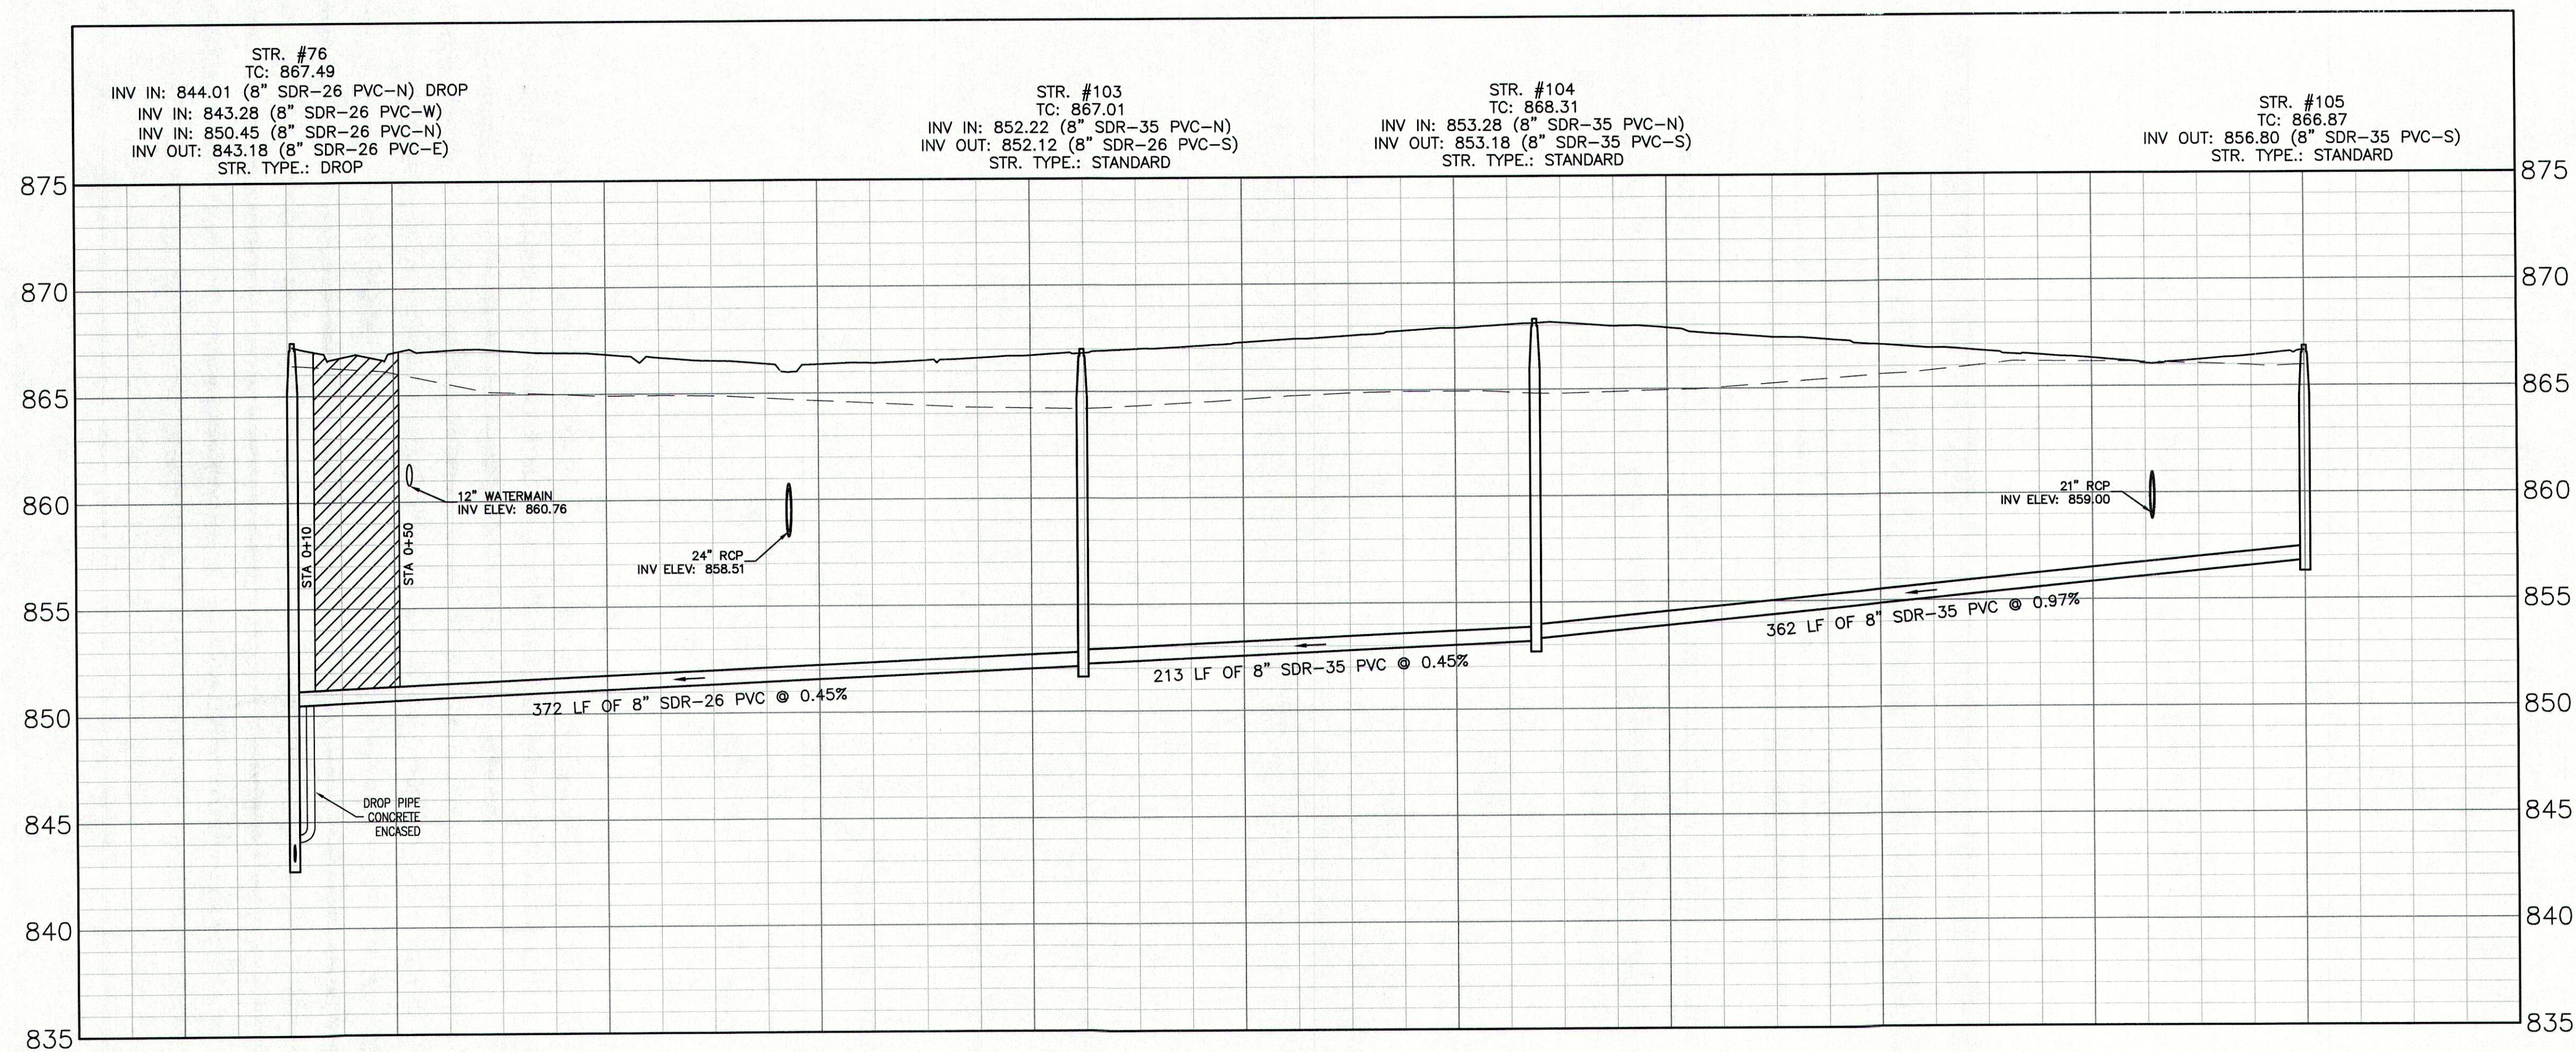

BENCHMARK INFORMATION:

ORIGINATING BENCHMARK: INDOT 48-G-0055
A BRONZE PLATE IN THE NORTH END OF THE EAST SIDEWALK OF CR 650 W BRIDGE (STR 169-15-05323, NBI 39070) OVER I-69; ALSO 18 FEET SOUTH OF THE NORTH END OF THE BRIDGE.
ELEV = 880.30 (NGVD 29)
ELEV = 879.87 (NAVD 88)

TBM #1
SOUTHWEST UPPER BONNET BOLT
50 FEET SOUTH OF CL 800 SOUTH & 15 FEET WEST OF CL 650 WEST
ELEV = 870.36 (NAVD 88)

TBM #2
SOUTHWEST UPPER BONNET BOLT
670 FEET SOUTH OF CL 800 SOUTH & 15 FEET WEST OF CL 650 WEST
ELEV = 866.74 (NAVD 88)

TBM #3
SOUTHWEST UPPER BONNET BOLT
1665 FEET SOUTH OF CL 800 SOUTH & 17 FEET WEST OF CL 650 WEST
ELEV = 866.74 (NAVD 88)

TBM #4
SOUTHWEST UPPER BONNET BOLT
1250 FEET NORTH OF CL FALL CREEK DRIVE & 17 FEET WEST OF CL 650 WEST
ELEV = 864.08 (NAVD 88)


LEGEND:

EXISTING	PROPOSED
RIGHT-OF-WAY LINE	RIGHT-OF-WAY LINE
EASEMENT LINE	EASEMENT LINE
SETBACK LINE	SETBACK LINE
CENTERLINE	CENTERLINE
SWALE / FLOWLINE	SWALE / FLOWLINE
CURB UNDERDRAIN	CURB UNDERDRAIN
SANITARY SEWER	SANITARY SEWER
STORM SEWER	STORM SEWER
STORM CULVERT	STORM CULVERT
WATER MAIN	WATER MAIN
SANITARY MANHOLE	SANITARY MANHOLE
STORM MANHOLE	STORM MANHOLE
STORM INLET	STORM INLET
STORM END SECTION	STORM END SECTION
FIRE HYDRANT	FIRE HYDRANT
PROFILED PIPELINE	PROFILED PIPELINE
EX - EXISTING	INVERT ELEVATION
INV - INVERT ELEVATION	MANHOLE
MH - MANHOLE	PVC - POLYVINYL CHLORIDE PIPE
PVC - POLYVINYL CHLORIDE PIPE	TC - TOP OF CASTING GRADE

GRANULAR BACKFILL
EXISTING GRADE
PROPOSED GRADE

MAPLE TRAILS SECTION 3 SANITARY SEWER PLAN & PROFILE

DATE	DESCRIPTION	BY

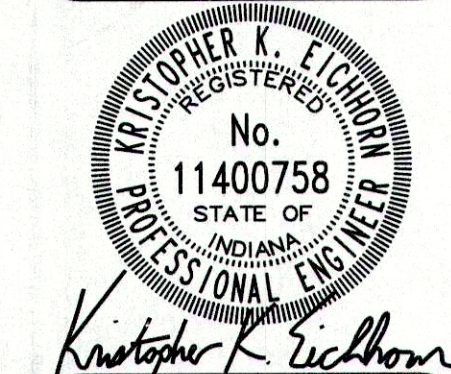

DRAWN BY TS	CHECKED BY KE
DATE AUGUST 7, 2019	SCALE AS SHOWN
SHEET	

C4.2
SANITARY SEWER PLAN & PROFILE