

Plot Date: Dec 17, 2020 Plot Time: 10:09pm File Name: W:\Arbor Homes\2017-095-E Arbor- Maple Trails Sec 5\Design\CA0\17095E-Sanitary Plan.dwg, Layout: C4.0 By: tsmith

BENCHMARK INFORMATION:



ORIGINATING BENCHMARK: INDOT 48-G-0055
A BRONZE PLATE IN THE NORTH END OF THE EAST
SIDEWALK OF CR 650 W BRIDGE (STR 169-15-05323, NBI
38070) OVER I49; ALSO 16 FEET SOUTH OF THE NORTH
END OF THE BRIDGE.
ELEV = 880.30 (NGVD 29)
ELEV = 879.87 (NAVD 88)

TBM #1
SOUTHWEST UPPER BONNET BOLT
50 FEET SOUTH OF CL 800 SOUTH & 15 FEET WEST OF
CL 650 WEST
ELEV = 870.36 (NAVD 88)

TBM #2
SOUTHWEST UPPER BONNET BOLT
670 FEET SOUTH OF CL 800 SOUTH & 15 FEET WEST OF
CL 650 WEST
ELEV = 866.74 (NAVD 88)

TBM #3
SOUTHWEST UPPER BONNET BOLT
1665 FEET SOUTH OF CL 800 SOUTH & 17 FEET WEST OF
CL 650 WEST
ELEV = 866.25 (NAVD 88)

TBM #4
SOUTHWEST UPPER BONNET BOLT
1290 FEET NORTH OF CL FALL CREEK DRIVE & 17 FEET
WEST OF CL 650 WEST
ELEV = 864.08 (NAVD 88)

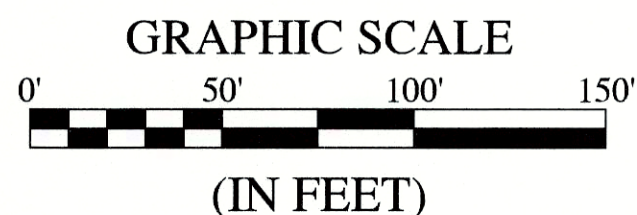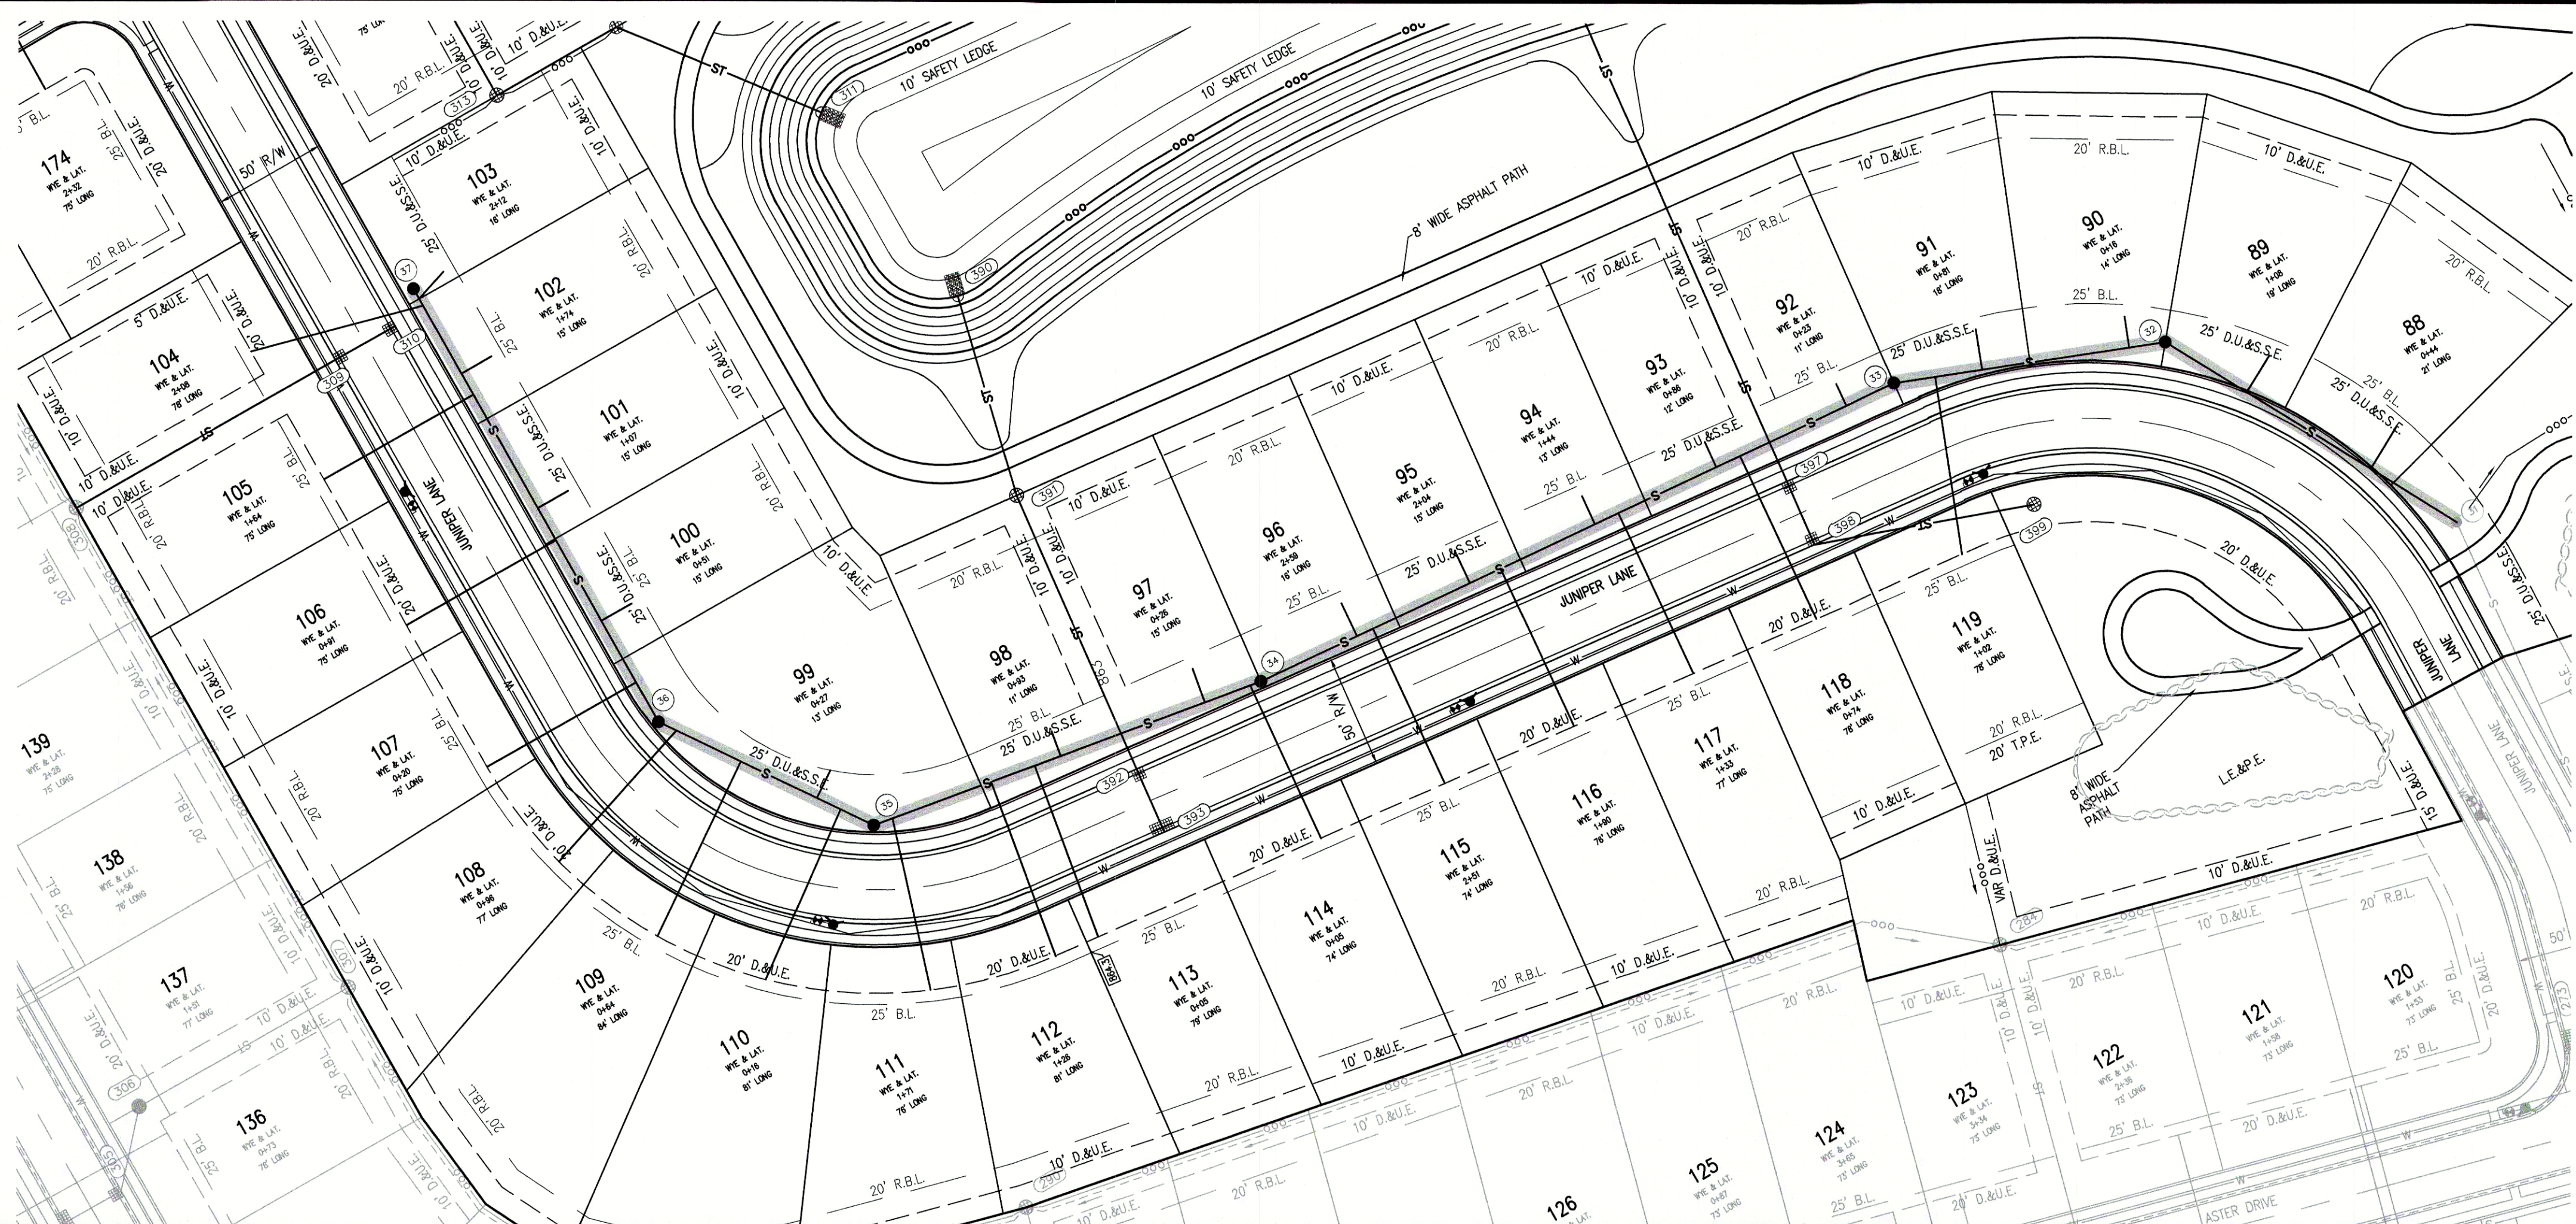


LEGEND:

EXISTING	PROPOSED
--- RIGHT-OF-WAY LINE	--- RIGHT-OF-WAY LINE
--- EASEMENT LINE	--- EASEMENT LINE
--- SETBACK LINE	--- SETBACK LINE
--- CENTERLINE	--- CENTERLINE
--- SWALE / FLOWLINE	--- SWALE / FLOWLINE
--- CURB UNDERDRAIN	--- CURB UNDERDRAIN
--- SANITARY SEWER	--- SANITARY SEWER
--- STORM SEWER	--- STORM SEWER
--- STORM CULVERT	--- STORM CULVERT
--- WATER MAIN	--- WATER MAIN
--- SANITARY MANHOLE	--- SANITARY MANHOLE
--- STORM MANHOLE	--- STORM MANHOLE
--- STORM INLET	--- STORM INLET
--- STORM END SECTION	--- STORM END SECTION
--- FIRE HYDRANT	--- FIRE HYDRANT
--- PROFILED PIPELINE	--- PROFILED PIPELINE
EX --- EXISTING	INV --- INVERT ELEVATION
INV --- INVERT ELEVATION	MH --- MANHOLE
MH --- MANHOLE	PVC --- POLYVINYL CHLORIDE PIPE
PVC --- POLYVINYL CHLORIDE PIPE	TC --- TOP OF CASTING GRADE
TC --- TOP OF CASTING GRADE	

SANITARY PROFILE

VERTICAL SCALE: 1" = 5'
HORIZONTAL SCALE: 1" = 50'

PVC GRAVITY SEWER PIPE AND FITTINGS
MUST, AT A MINIMUM, BE INSTALLED IN
ACCORDANCE WITH THE DIRECTIONS
CONTAINED IN ASTM D 2321 AND
FOLLOW CURRENT FCRWD STANDARDS.

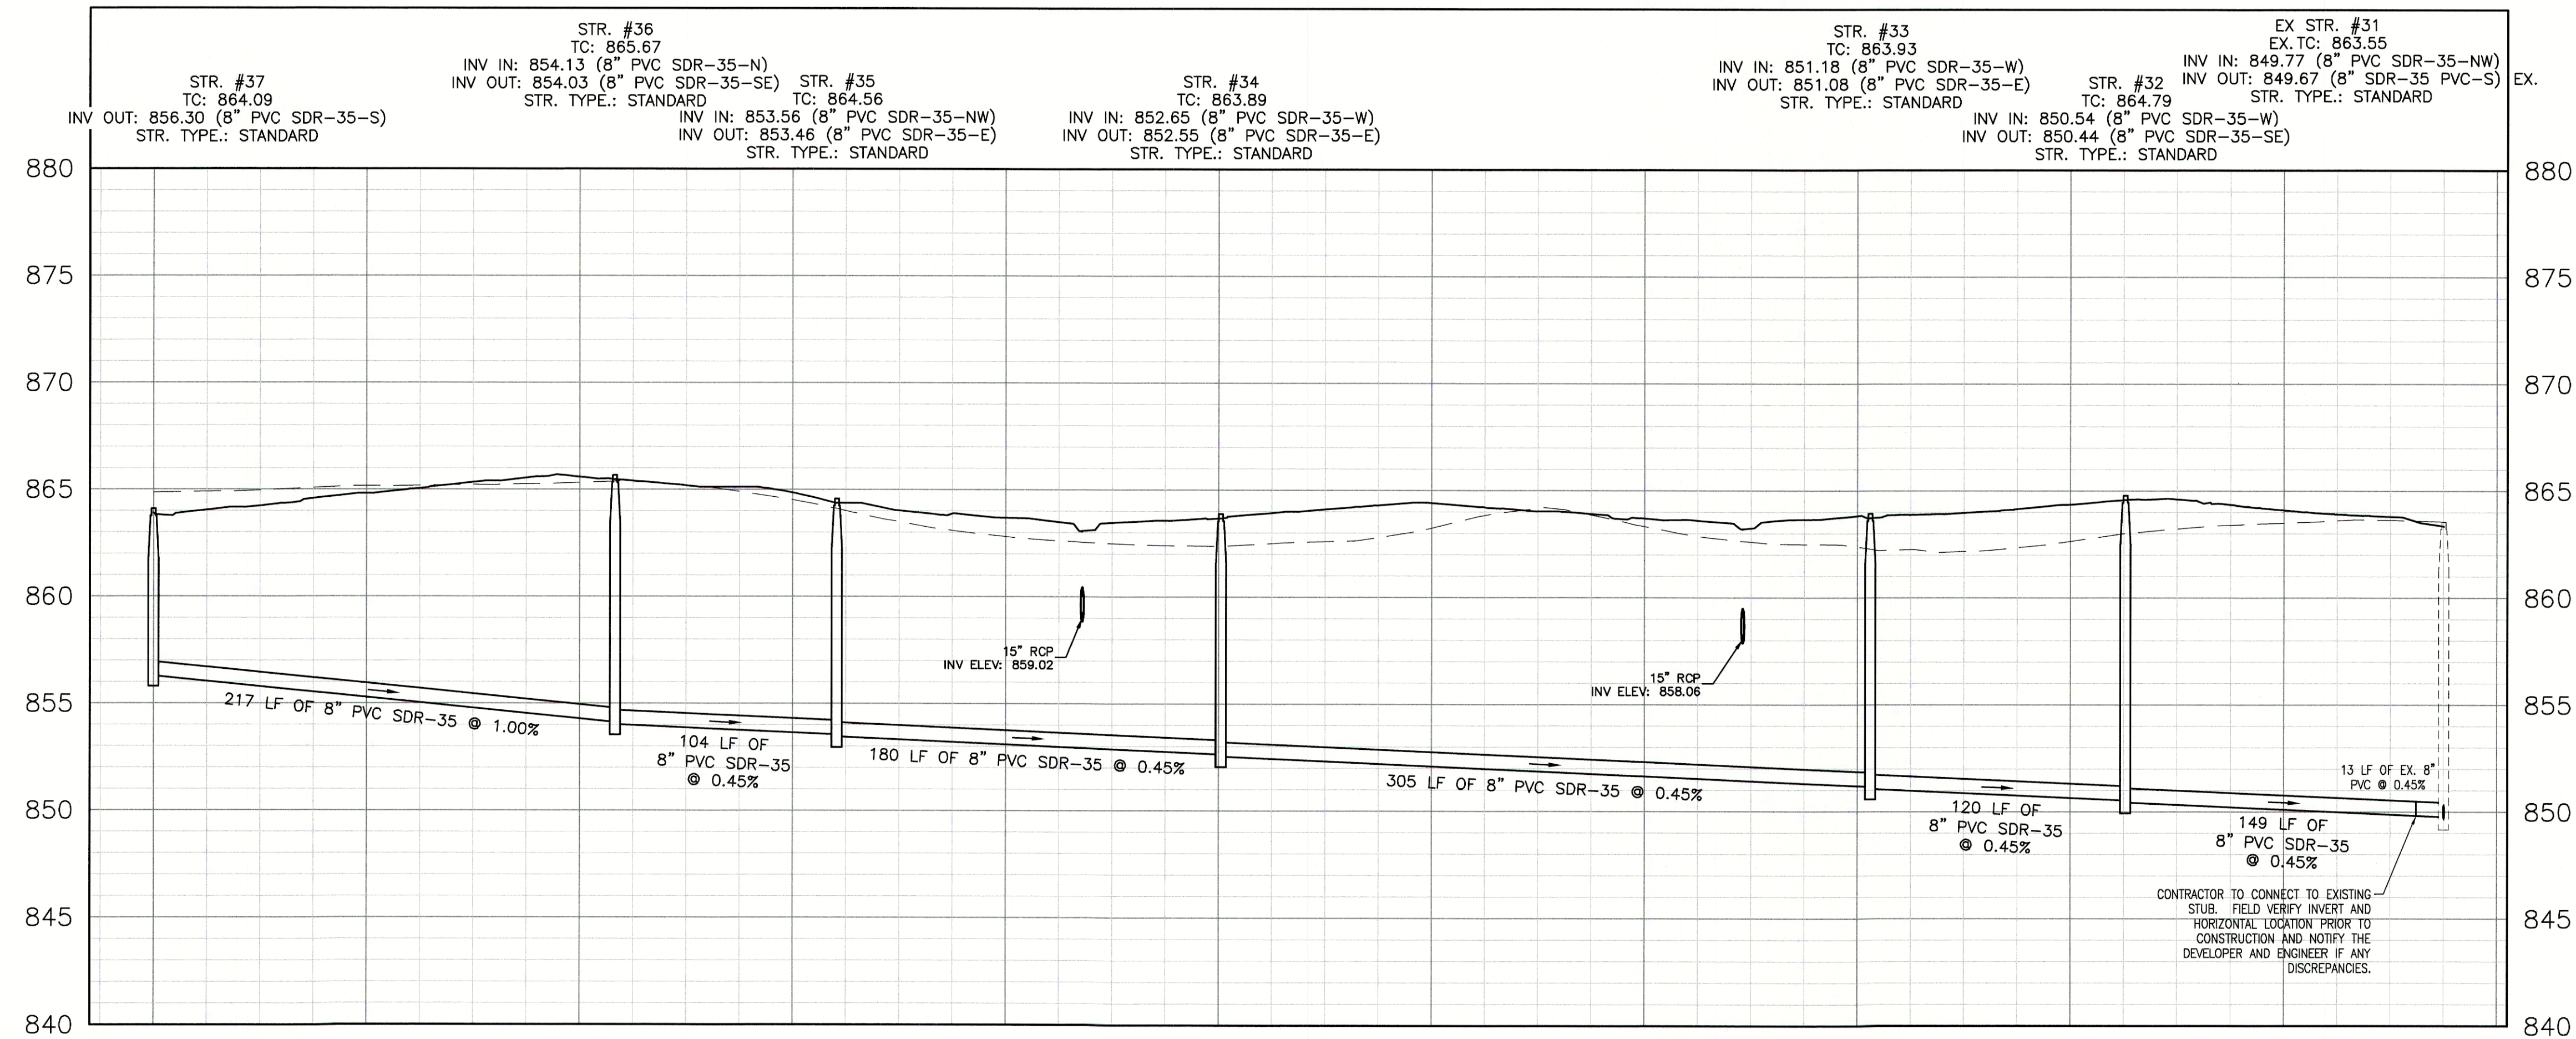

REVISIONS		
DATE	DESCRIPTION	BY

HWC
ENGINEERING
INDIANAPOLIS - TERRE HAUTE
LAFAYETTE - MUNICIE - NEW ALBANY
www.hwcengineering.com

MAPLE TRAILS SECTION 5
INGALLS, INDIANA
SANITARY SEWER PLAN & PROFILE

PREPARED BY
Kristopher K. Eickhorn
REGISTERED
No. 11400758
STATE OF INDIANA
PROFESSIONAL ENGINEER

DRAWN BY: TD/TS/GM
CHECKED BY: KE
DATE: DECEMBER 18, 2020
SCALE: AS SHOWN
SHEET: C4.0
SANITARY SEWER PLAN & PROFILE
JOB NUMBER: 2017-095-E
© 2020