


Plot Date: Sep 27, 2021 Plot Time: 11:05am File Name: W:\Arbor Homes\2017-095-E Arbor- Maple Trails Sec 6\Design\CAD\17095F Sanitary Plan.dwg, Layout: C4.1 By: Keithhorn

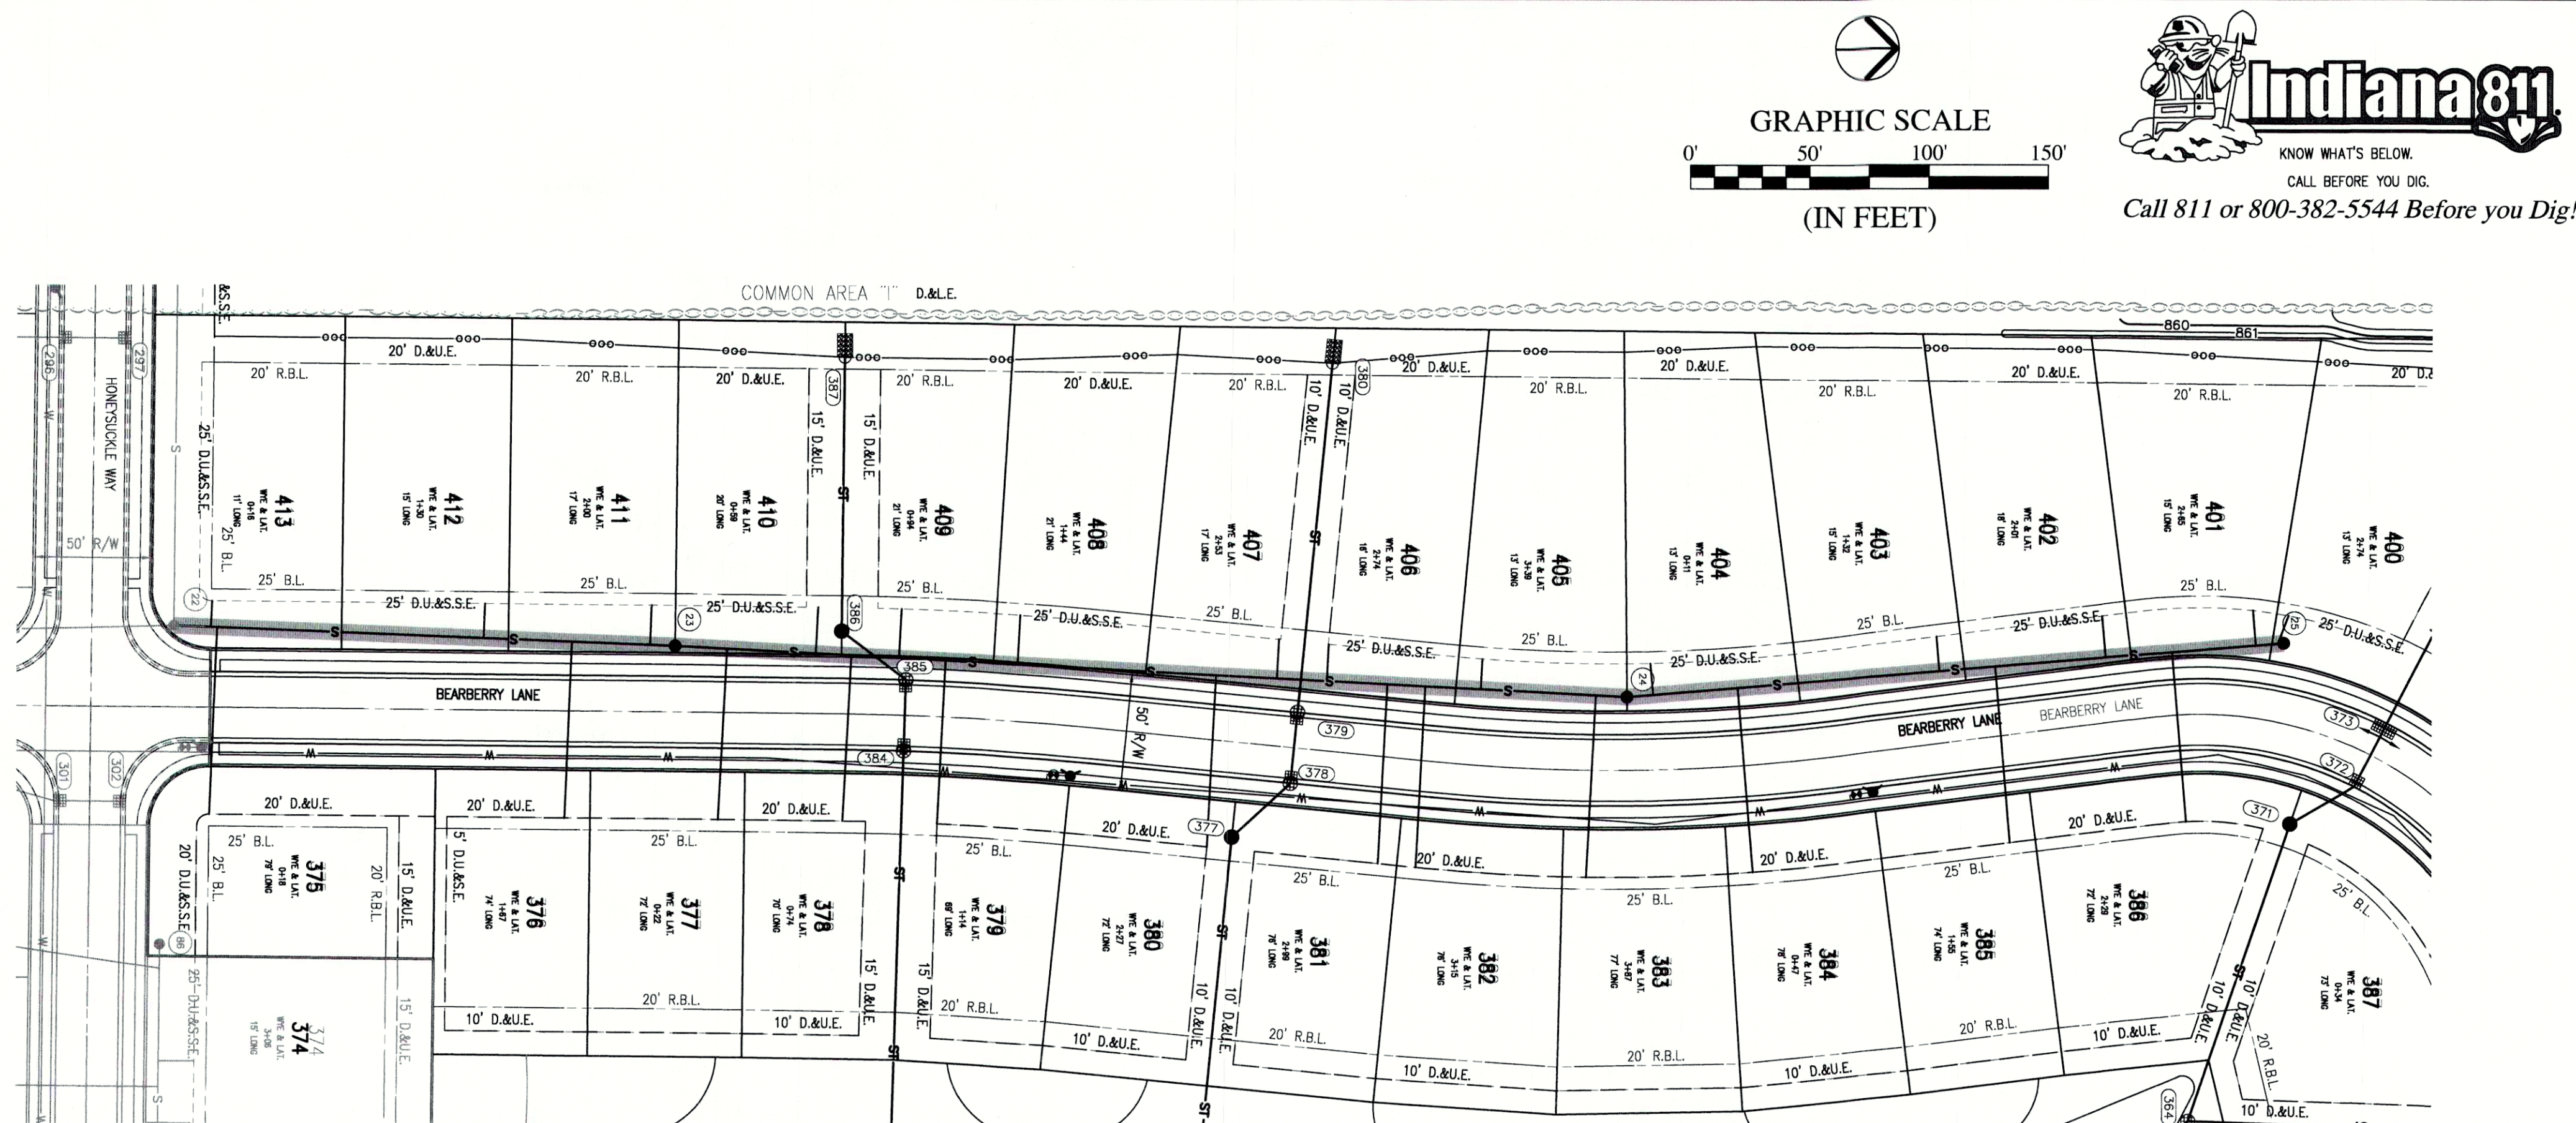

LEGEND:		
EXISTING		PROPOSED
---	RIGHT-OF-WAY LINE	---
---	EASEMENT LINE	---
---	SETBACK LINE	---
---	CENTERLINE	---
---	SWALE / FLOWLINE	---
---	CURB UNDERDRAIN	---
---	SANITARY SEWER	---
---	STORM SEWER	---
---	STORM CULVERT	---
---	WATER MAIN	---
---	SANITARY MANHOLE	---
---	STORM MANHOLE	---
---	STORM INLET	---
---	STORM END SECTION	---
---	FIRE HYDRANT	---
---	PROFILED PIPELINE	---
EX	- EXISTING	
INV	- INVERT ELEVATION	
MH	- MANHOLE	
PVC	- POLYVINYL CHLORIDE PIPE	
TC	- TOP OF CASTING GRADE	

BENCHMARK INFORMATION:

ORIGINATING BENCHMARK: INDOT 48-G-0055
A BRONZE PLATE IN THE NORTH END OF THE EAST SIDEWALK OF CR 650 W BRIDGE (STR 169-15-05323, NBI 38070) OVER I-89, ALSO 18 FEET SOUTH OF THE NORTH END OF THE BRIDGE
ELEV = 880.30 (NGVD 29)
ELEV = 879.87 (NAVD 88)

TBM #1
SOUTHWEST UPPER BONNET BOLT
50 FEET SOUTH OF CL 800 SOUTH & 15 FEET WEST OF CL 650 WEST
ELEV = 870.38 (NAVD 88)

TBM #2
SOUTHWEST UPPER BONNET BOLT
670 FEET SOUTH OF CL 800 SOUTH & 15 FEET WEST OF CL 650 WEST
ELEV = 866.74 (NAVD 88)

TBM #3
SOUTHWEST UPPER BONNET BOLT
1665 FEET SOUTH OF CL 800 SOUTH & 17 FEET WEST OF CL 650 WEST
ELEV = 866.25 (NAVD 88)


TBM #4
SOUTHWEST UPPER BONNET BOLT
1290 FEET NORTH OF CL FALL CREEK DRIVE & 17 FEET WEST OF CL 650 WEST
ELEV = 864.08 (NAVD 88)

SANITARY PROFILE

VERTICAL SCALE: 1" = 5'
HORIZONTAL SCALE: 1" = 50'

PVC GRAVITY SEWER PIPE AND FITTINGS MUST, AT A MINIMUM, BE INSTALLED IN ACCORDANCE WITH THE DIRECTIONS CONTAINED IN ASTM D 2321 AND FOLLOW CURRENT FCRWD STANDARDS.

---	GRANULAR BACKFILL
---	EXISTING GRADE
---	PROPOSED GRADE

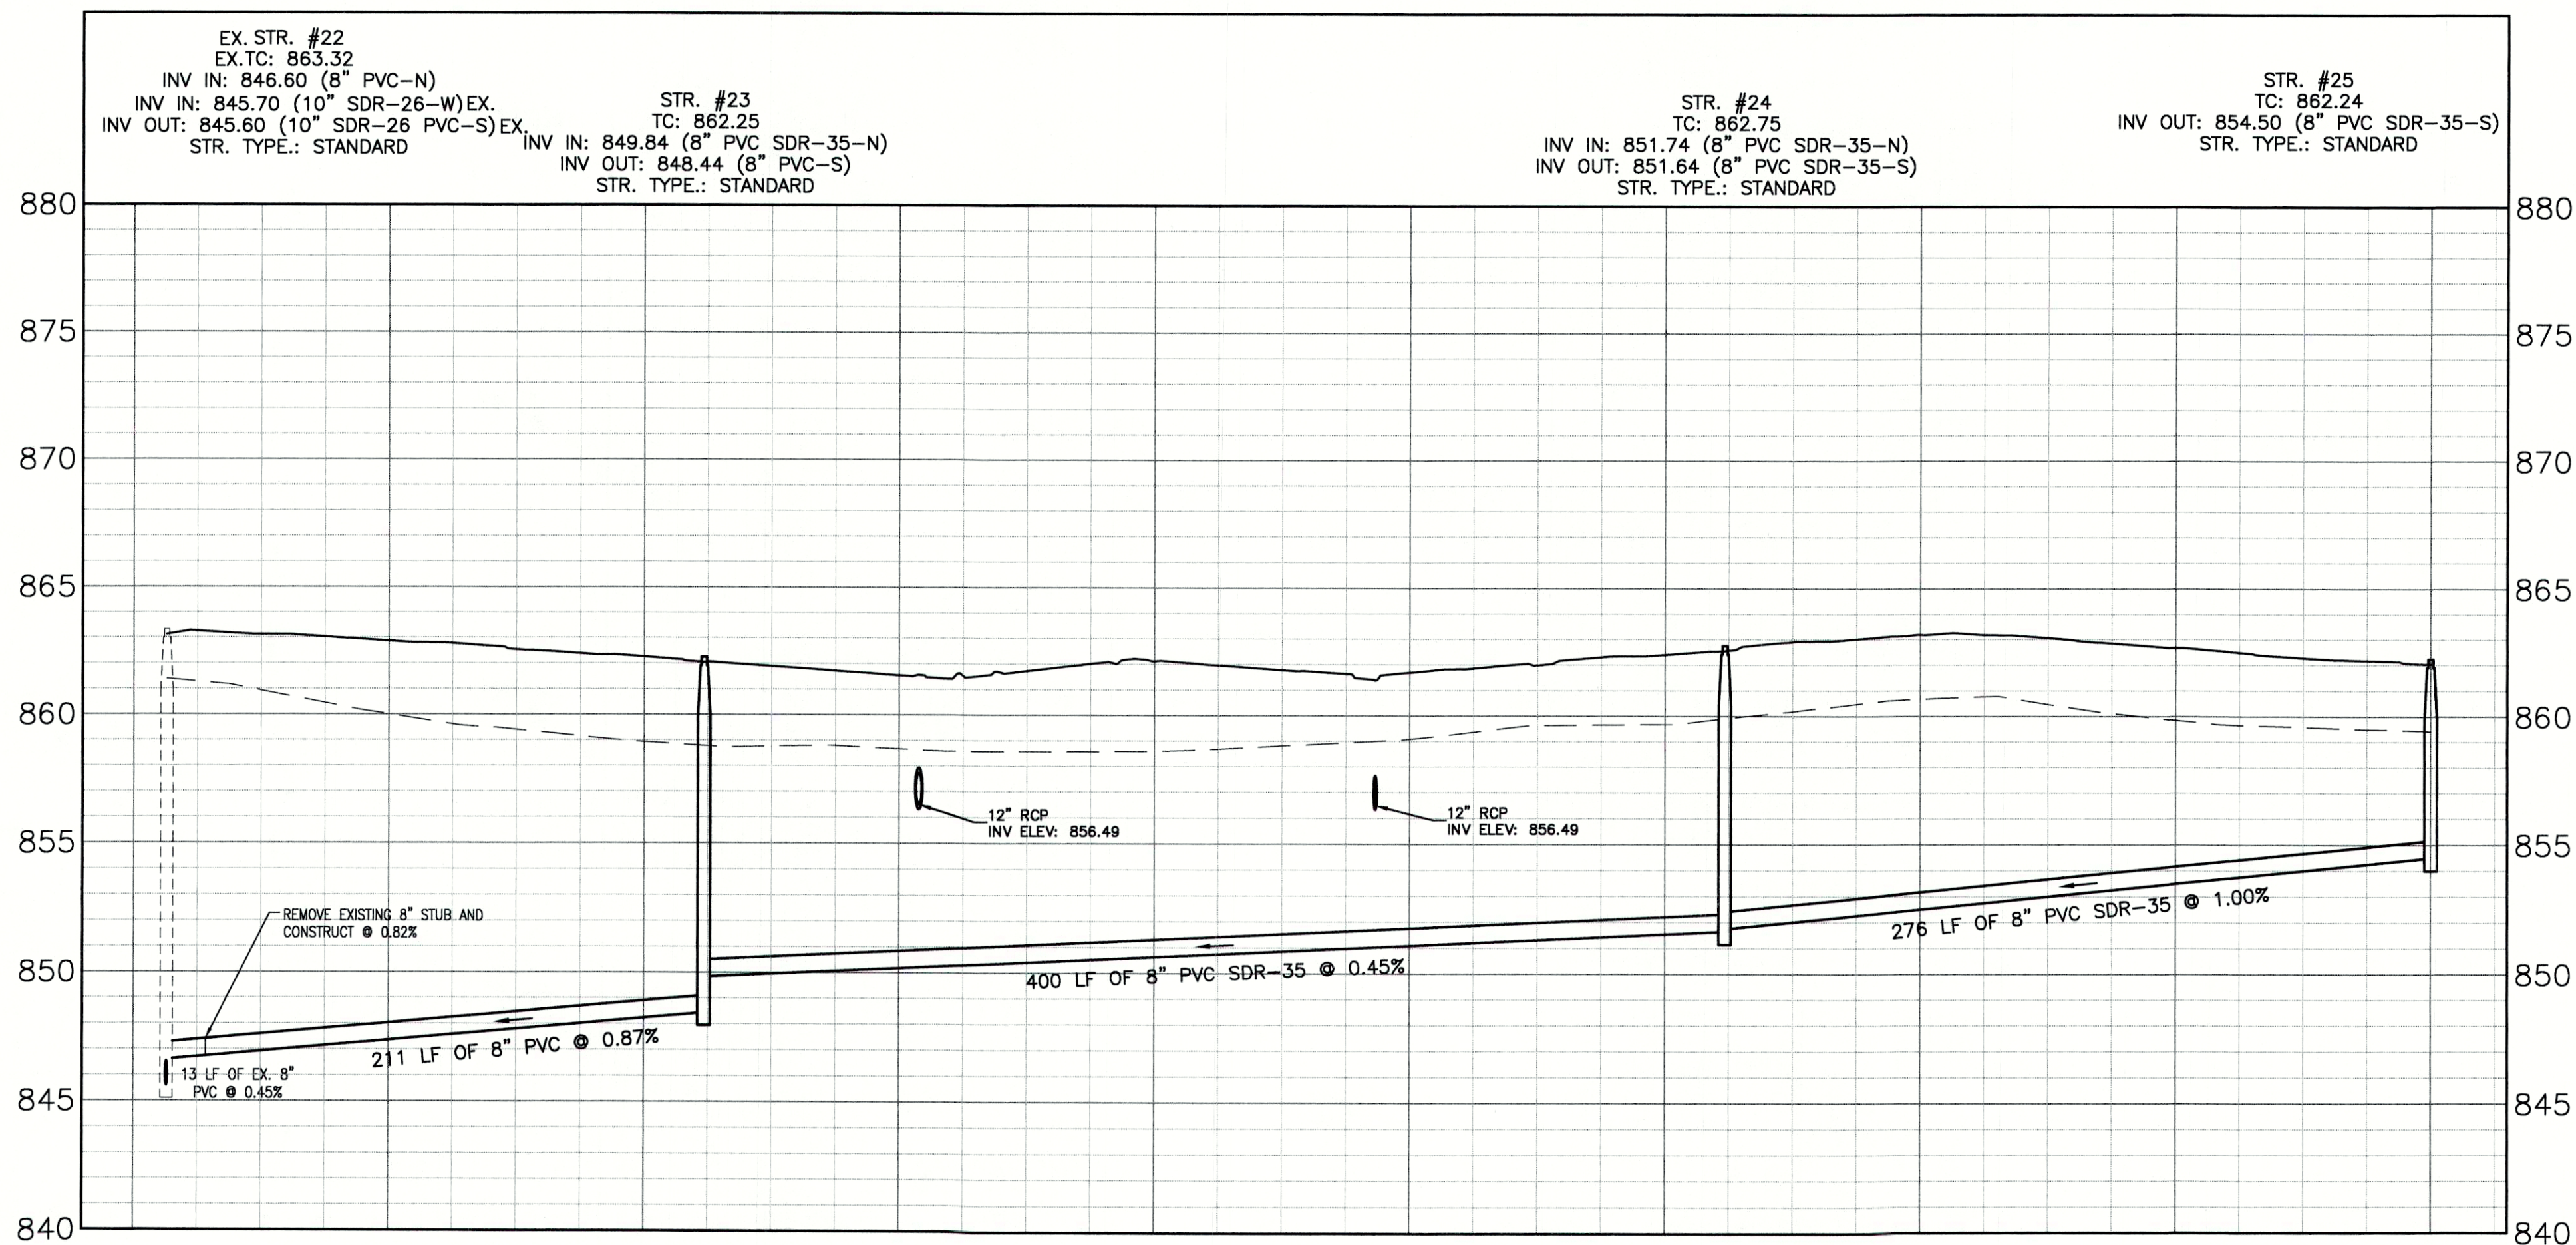

REVISIONS		
DATE	DESCRIPTION	BY



MAPLE TRAILS SECTION 6
INGALLS, INDIANA
SANITARY SEWER PLAN & PROFILE



DRAWN BY TD/GM	JOB NUMBER 2017-095-E
CHECKED BY KE	
DATE SEPTEMBER 17, 2021	
SCALE AS SHOWN	
SHEET	

C4.1
SANITARY SEWER PLAN &
PROFILE