

Denotes approximate limits of granular backfill.
(Refer to respective specifications for exact limits and acceptable backfill materials).

NOTES:

1. Maintain a minimum of 18" of vertical separation per IDEM requirements.
2. Construct Huntzinger Blvd (Line "HBlvd") to the Neighborhood Collector Street Standard.
3. Construct Cold Springs Drive (Line "CSDr") and FarmGate Lane (Line "FGLn") to the Local Street Standard.
4. Construct the cut-de-loops to the Limited Local Street Standard.

"HBlvd" denotes Huntzinger Blvd

"CSDr" denotes Cold Springs Drive

"FGLn" denotes FarmGate Lane

"MWCt" denotes MapleWood Court

"cdl3" denotes Cut-de-loop 3

"SSB" denotes Sanitary Sewer Line "B"


"SSi" denotes Sanitary Sewer Line "i"

"SSj" denotes Sanitary Sewer Line "j"


"SSk" denotes Sanitary Sewer Line "k"

"SSL" denotes Sanitary Sewer Line "L"

"SSM" denotes Sanitary Sewer Line "M"

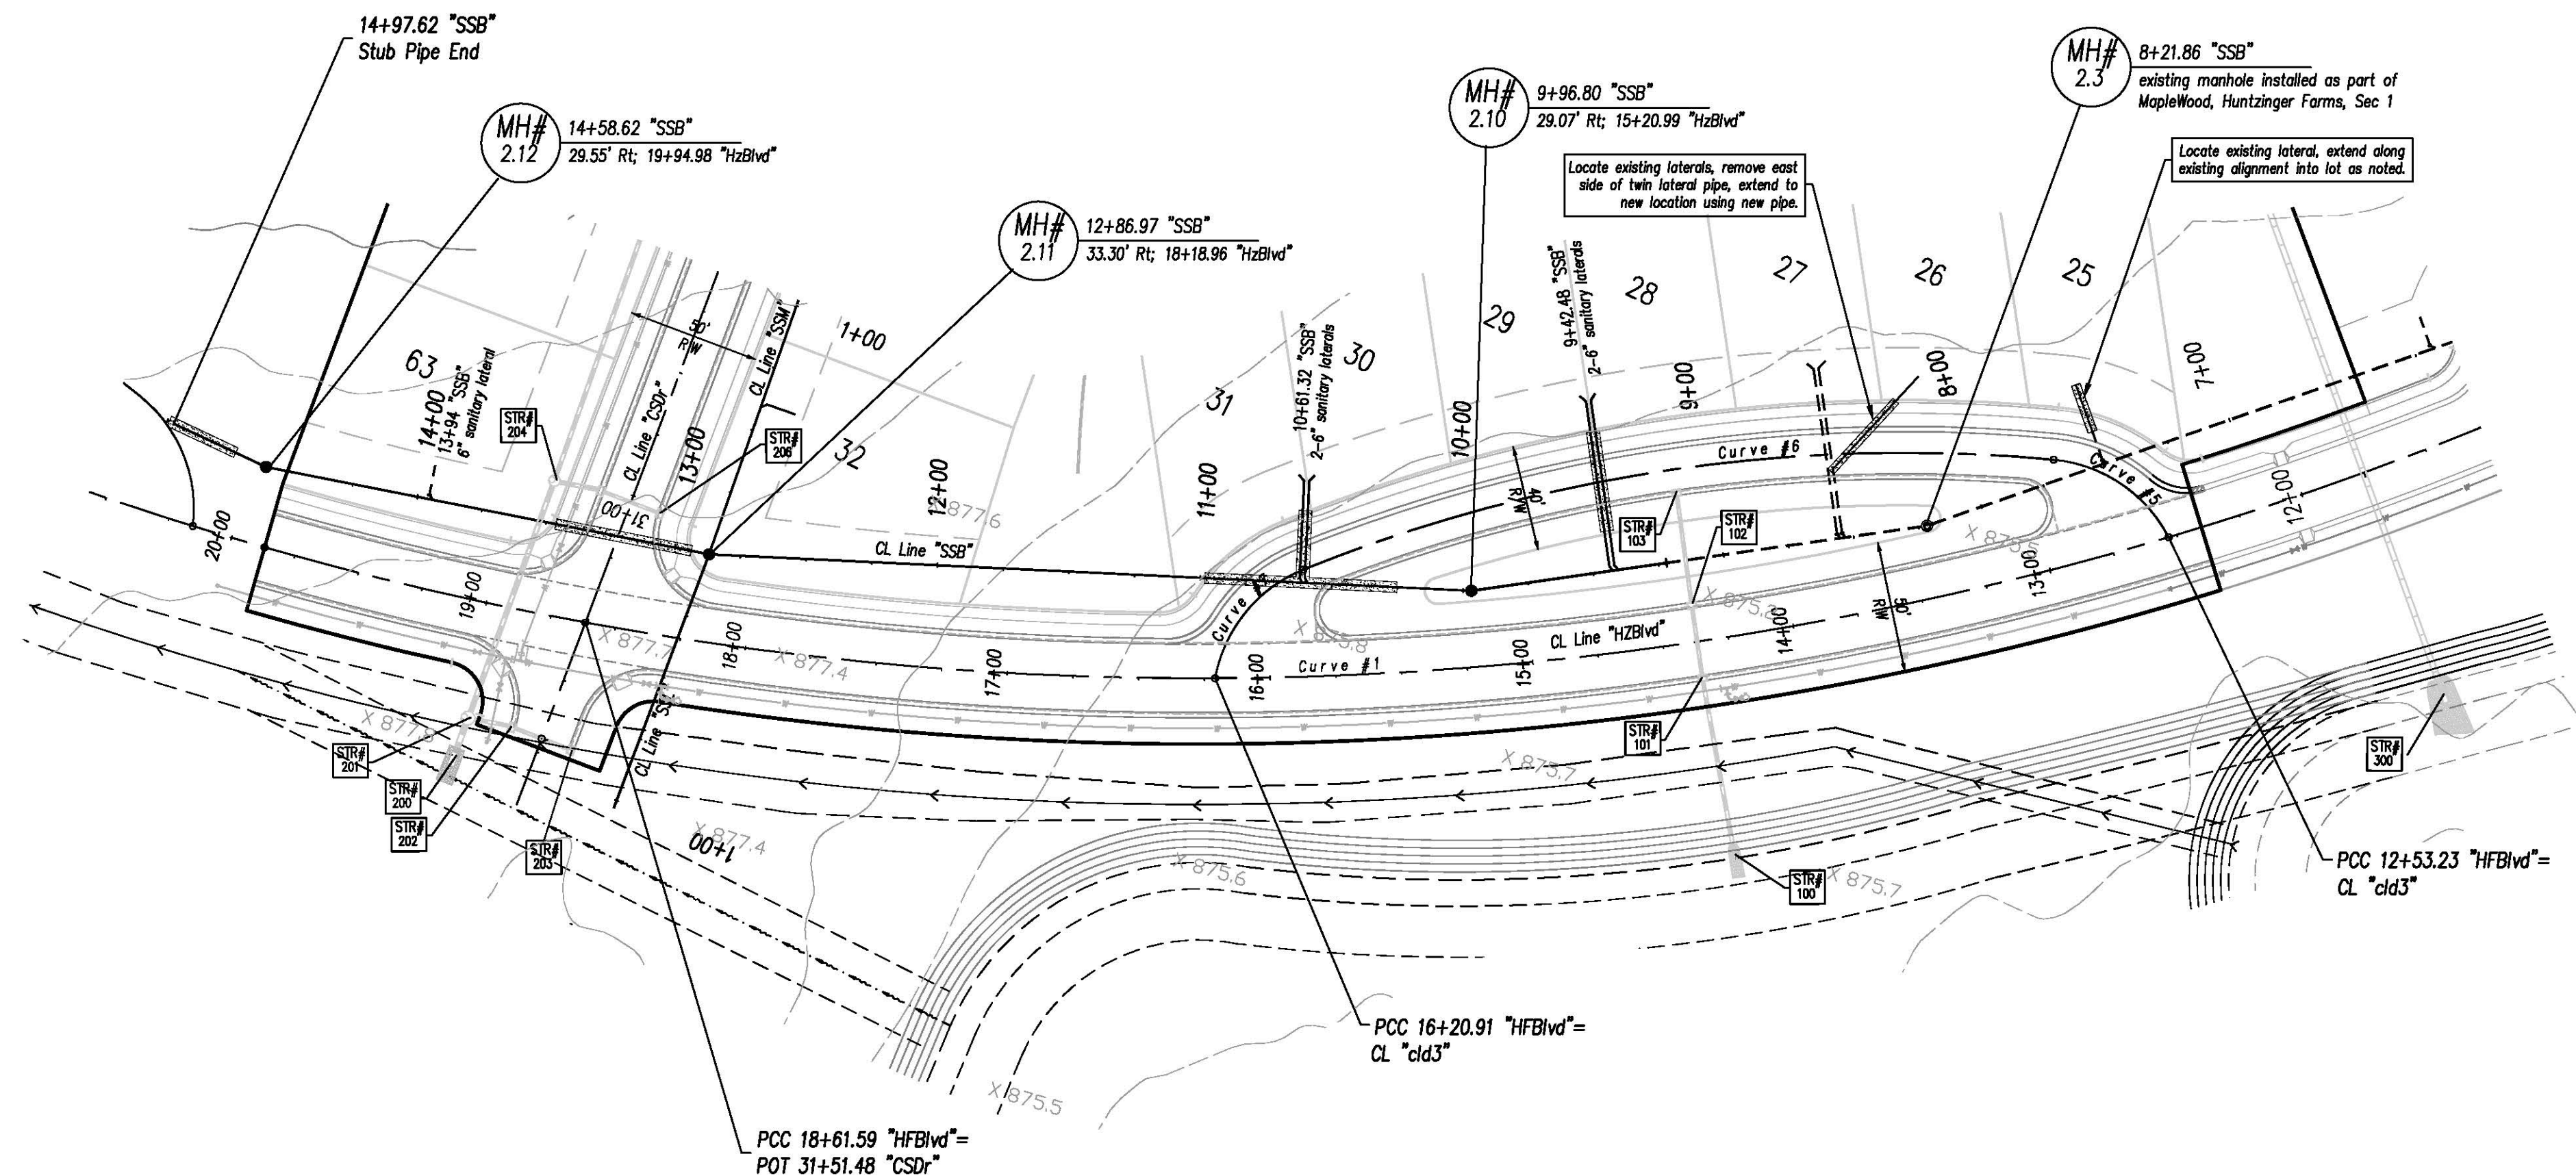

Line "SSB"

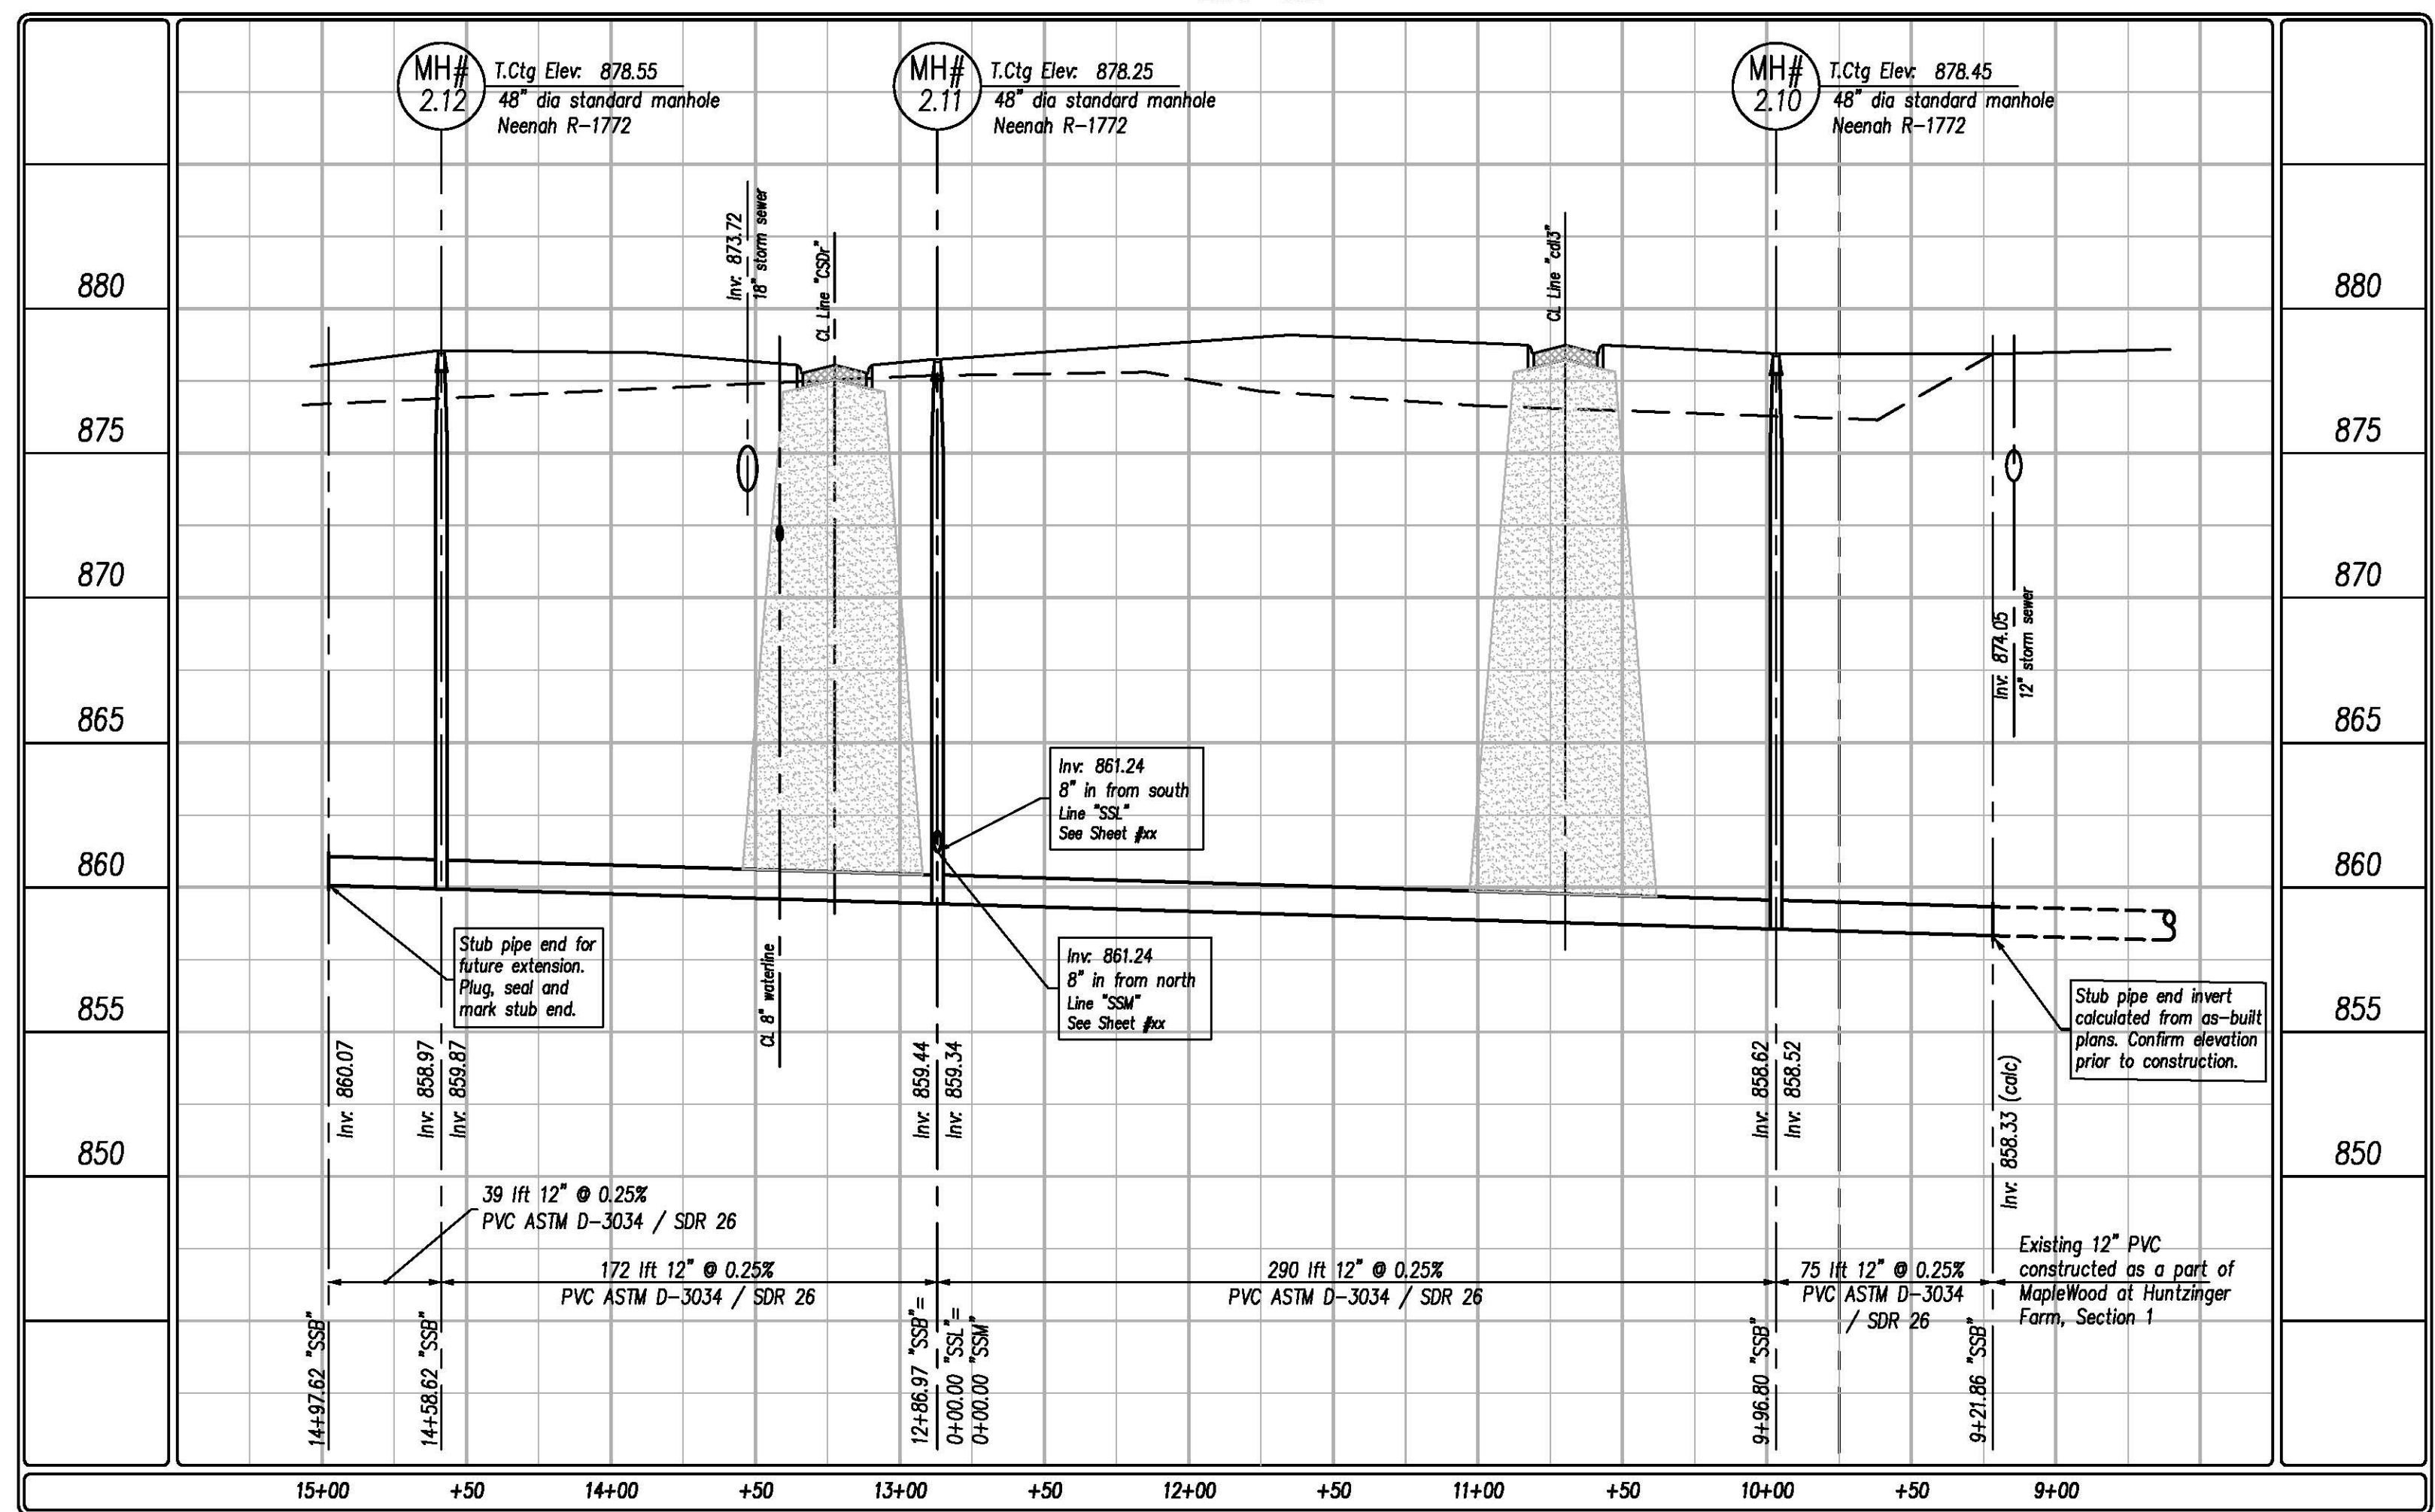

PER INDIANA STATE LAW 15-69-1991, IT IS AGAINST THE LAW TO EXCAVATE WITHOUT NOTIFYING THE UNDERGROUND LOCATION SERVICE TWO (2) WORKING DAYS BEFORE COMMENCING WORK.

WITHIN INDIANA:
1-800-362-5844
FROM OUTSIDE INDIANA:
1-800-428-5200

ELECTRIC: RED
GAS-OIL: YELLOW
COMMUNICATIONS: ORANGE
WATER: BLUE
SEWER: GREEN

PROPOSED EXCAVATION: WHITE

THE INFORMATION NEEDED WHEN CALLING INDIANA UNDERGROUND PLANT PROTECTION SERVICES, INC. IS AS FOLLOWS:

COUNTY AND TOWNSHIP
STREET ADDRESS
TYPE OF WORK
EXTENT OF WORK
NAME OF CALLER AND TITLE
TELEPHONE NUMBER
BEST TIME TO CALL
START DATE AND START TIME
CONTRACTOR NAME AND ADDRESS

North

Scale: shown

Pendleton Land Consulting
P.O. Box 67, Pendleton, Indiana 46064
Phone: 765-779-1540 Fax: 765-779-5871
email: pendletonland@att.net

Pendleton Land Company, LLC
9449 Priority Way West Drive
Suite 120
Indianapolis, Indiana 46240
Tel: 317.765.2663 Fax: 317.765.2665


Date: 6/12/2006

Revision

Date

Project: **MapleWood at Huntzinger Farm**
Section 2
Pendleton, Madison County, Indiana

Sheet Title: **Sanitary Plan-Profile**
Line "SSB"

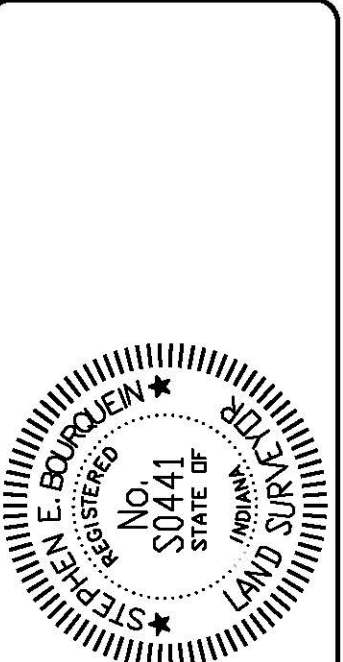

Sheet No. **9**
of 20 Sheets