 




These compiled engineering record drawings are a compilation of a copy of the original sealed engineering design drawings for this project, modified by addenda, change orders and information furnished by the contractor. The information shown on these compiled engineering record drawings that was provided by the contractor or others not associated with me cannot be verified for accuracy or completeness. My compilation of this information does not relieve the contractor of responsibility for errors resultant to incorrect, incomplete or omitted data on the contractor's as-built record drawings - nor does it relieve the contractor of responsibility for non-conformance with the original contract documents.

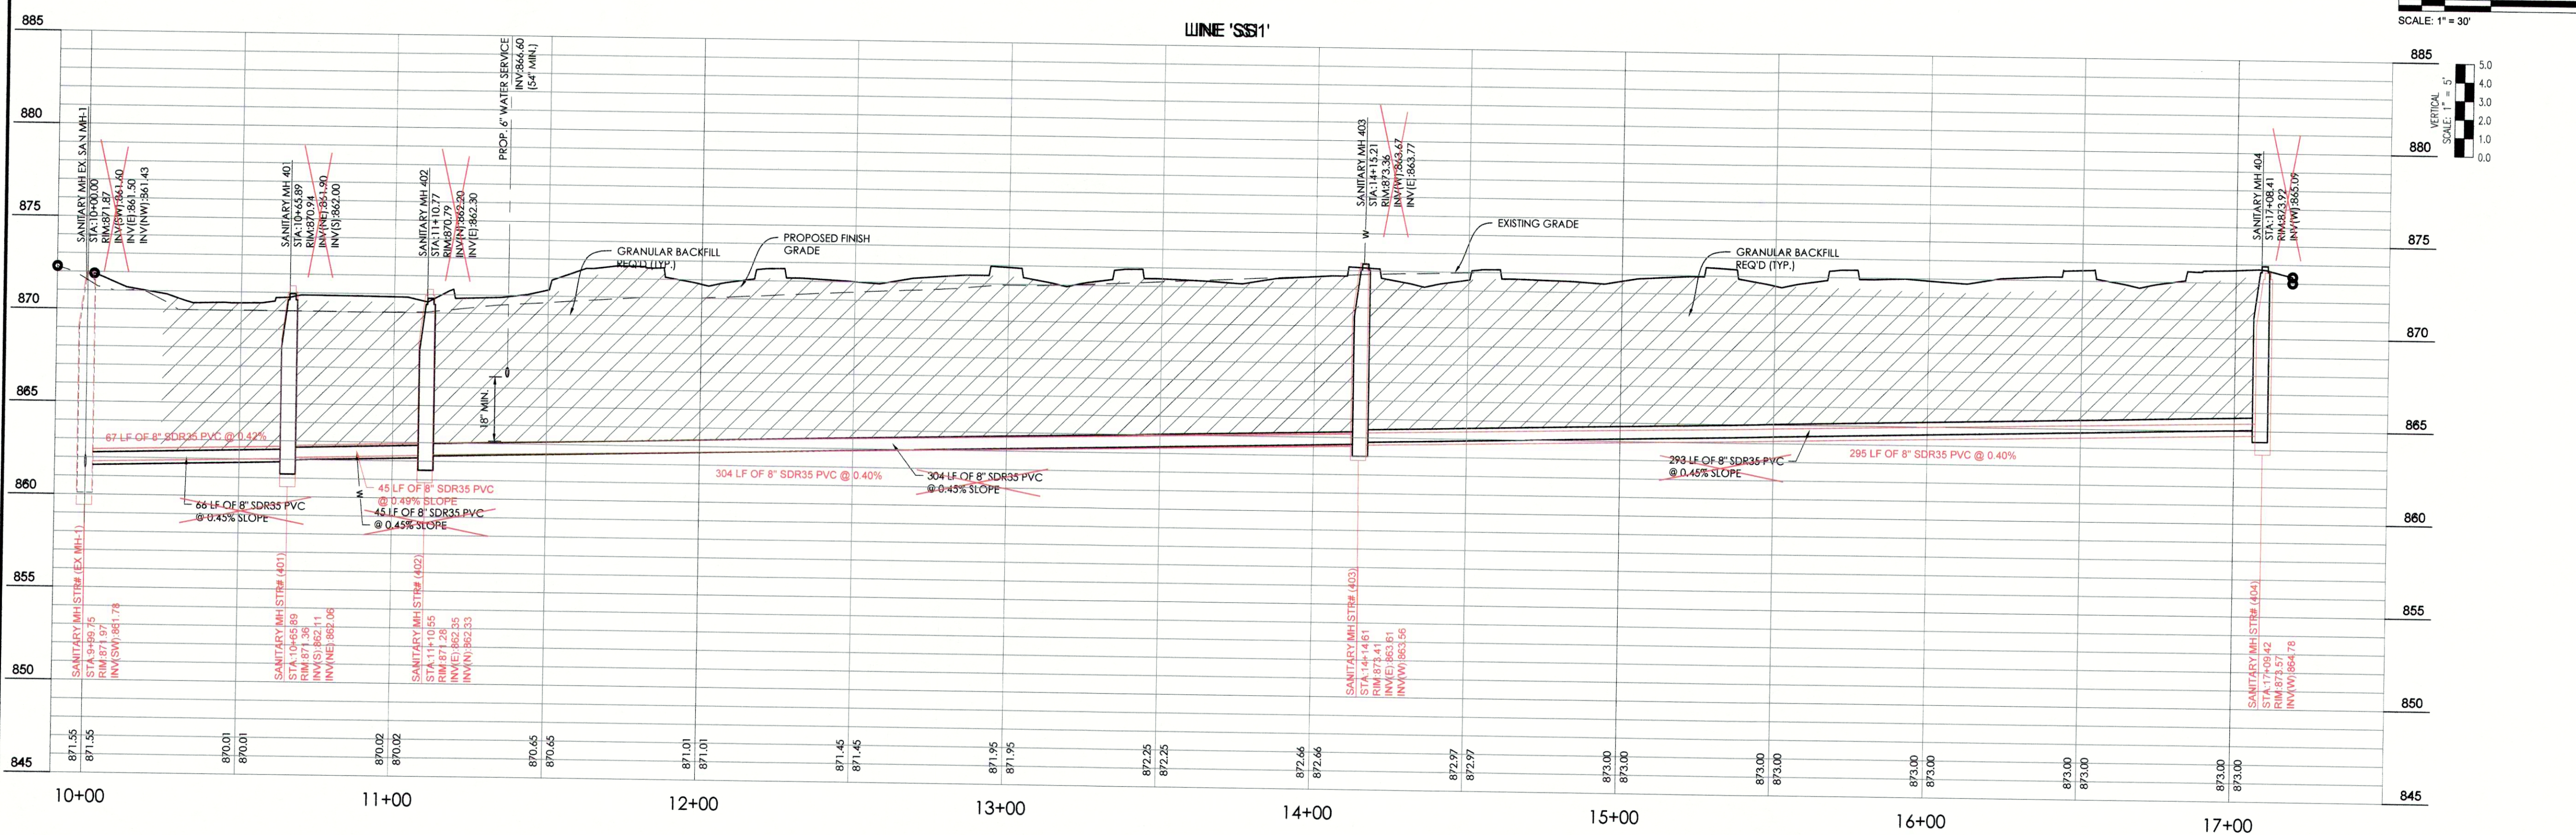

Fritz Engineering Services, LLC
14020 Mississinewa Drive
Carmel, Indiana 46033
P: 317.324.8695 F: 317.324.8695
www.Fritz-Eng.com

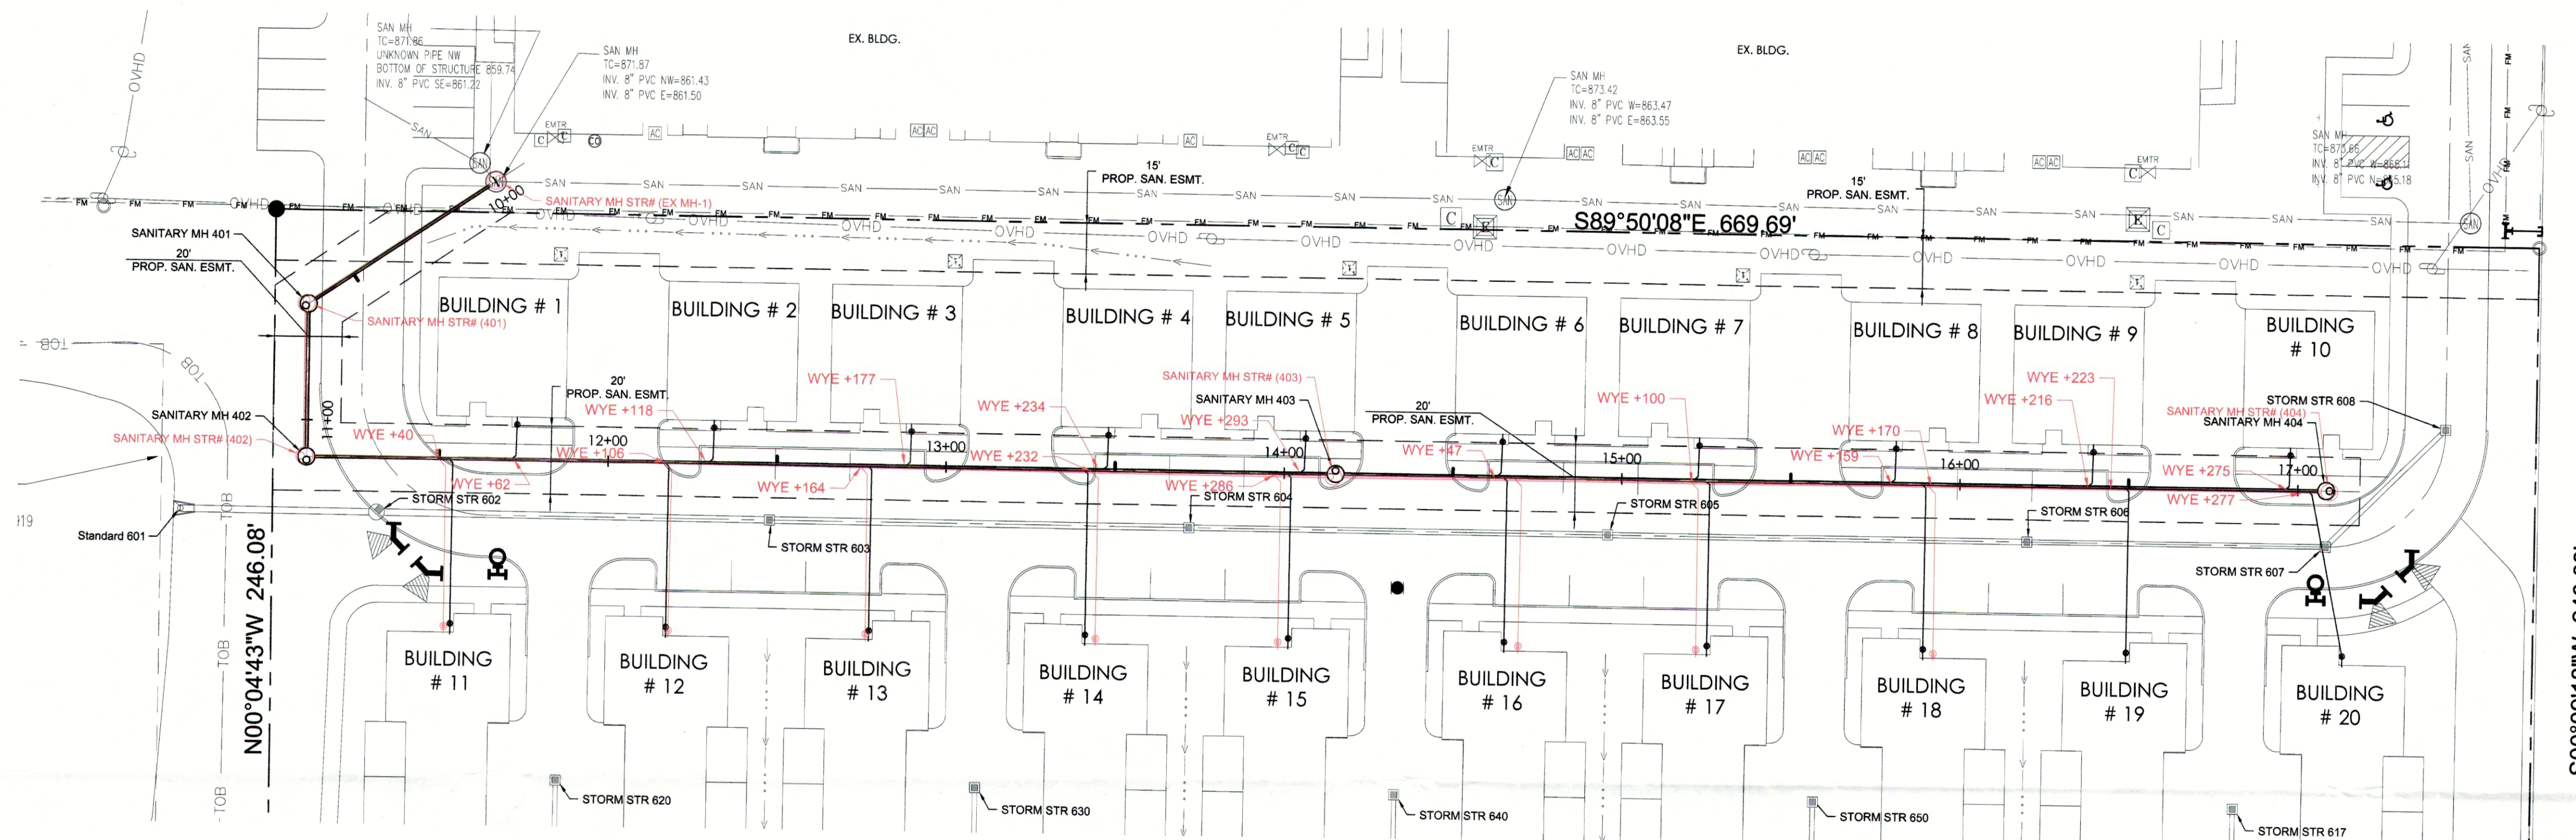

PROJECT:
PENDLETON PLACE
APTS-PHASE III
RECORD DRAWINGS

PROJECT LOCATION:
PIONEER TRACE
PENDLETON, IN 46064
MADISON COUNTY

SECTION, TOWNSHIP, RANGE:
S19, T18N, R7E

CLIENT:
HOUSE INVESTMENTS
10220 N. ILLINOIS STREET
INDIANAPOLIS, IN 46290

PLAN DATE:		
1/16/2018		
DESIGN: AF	CHECK: AF	DRAWN: AF
PROJECT NO. 1801001		
SHEET NO.		
SANITARY PLAN & PROFILE RECORD DRAWING C402-RD		