


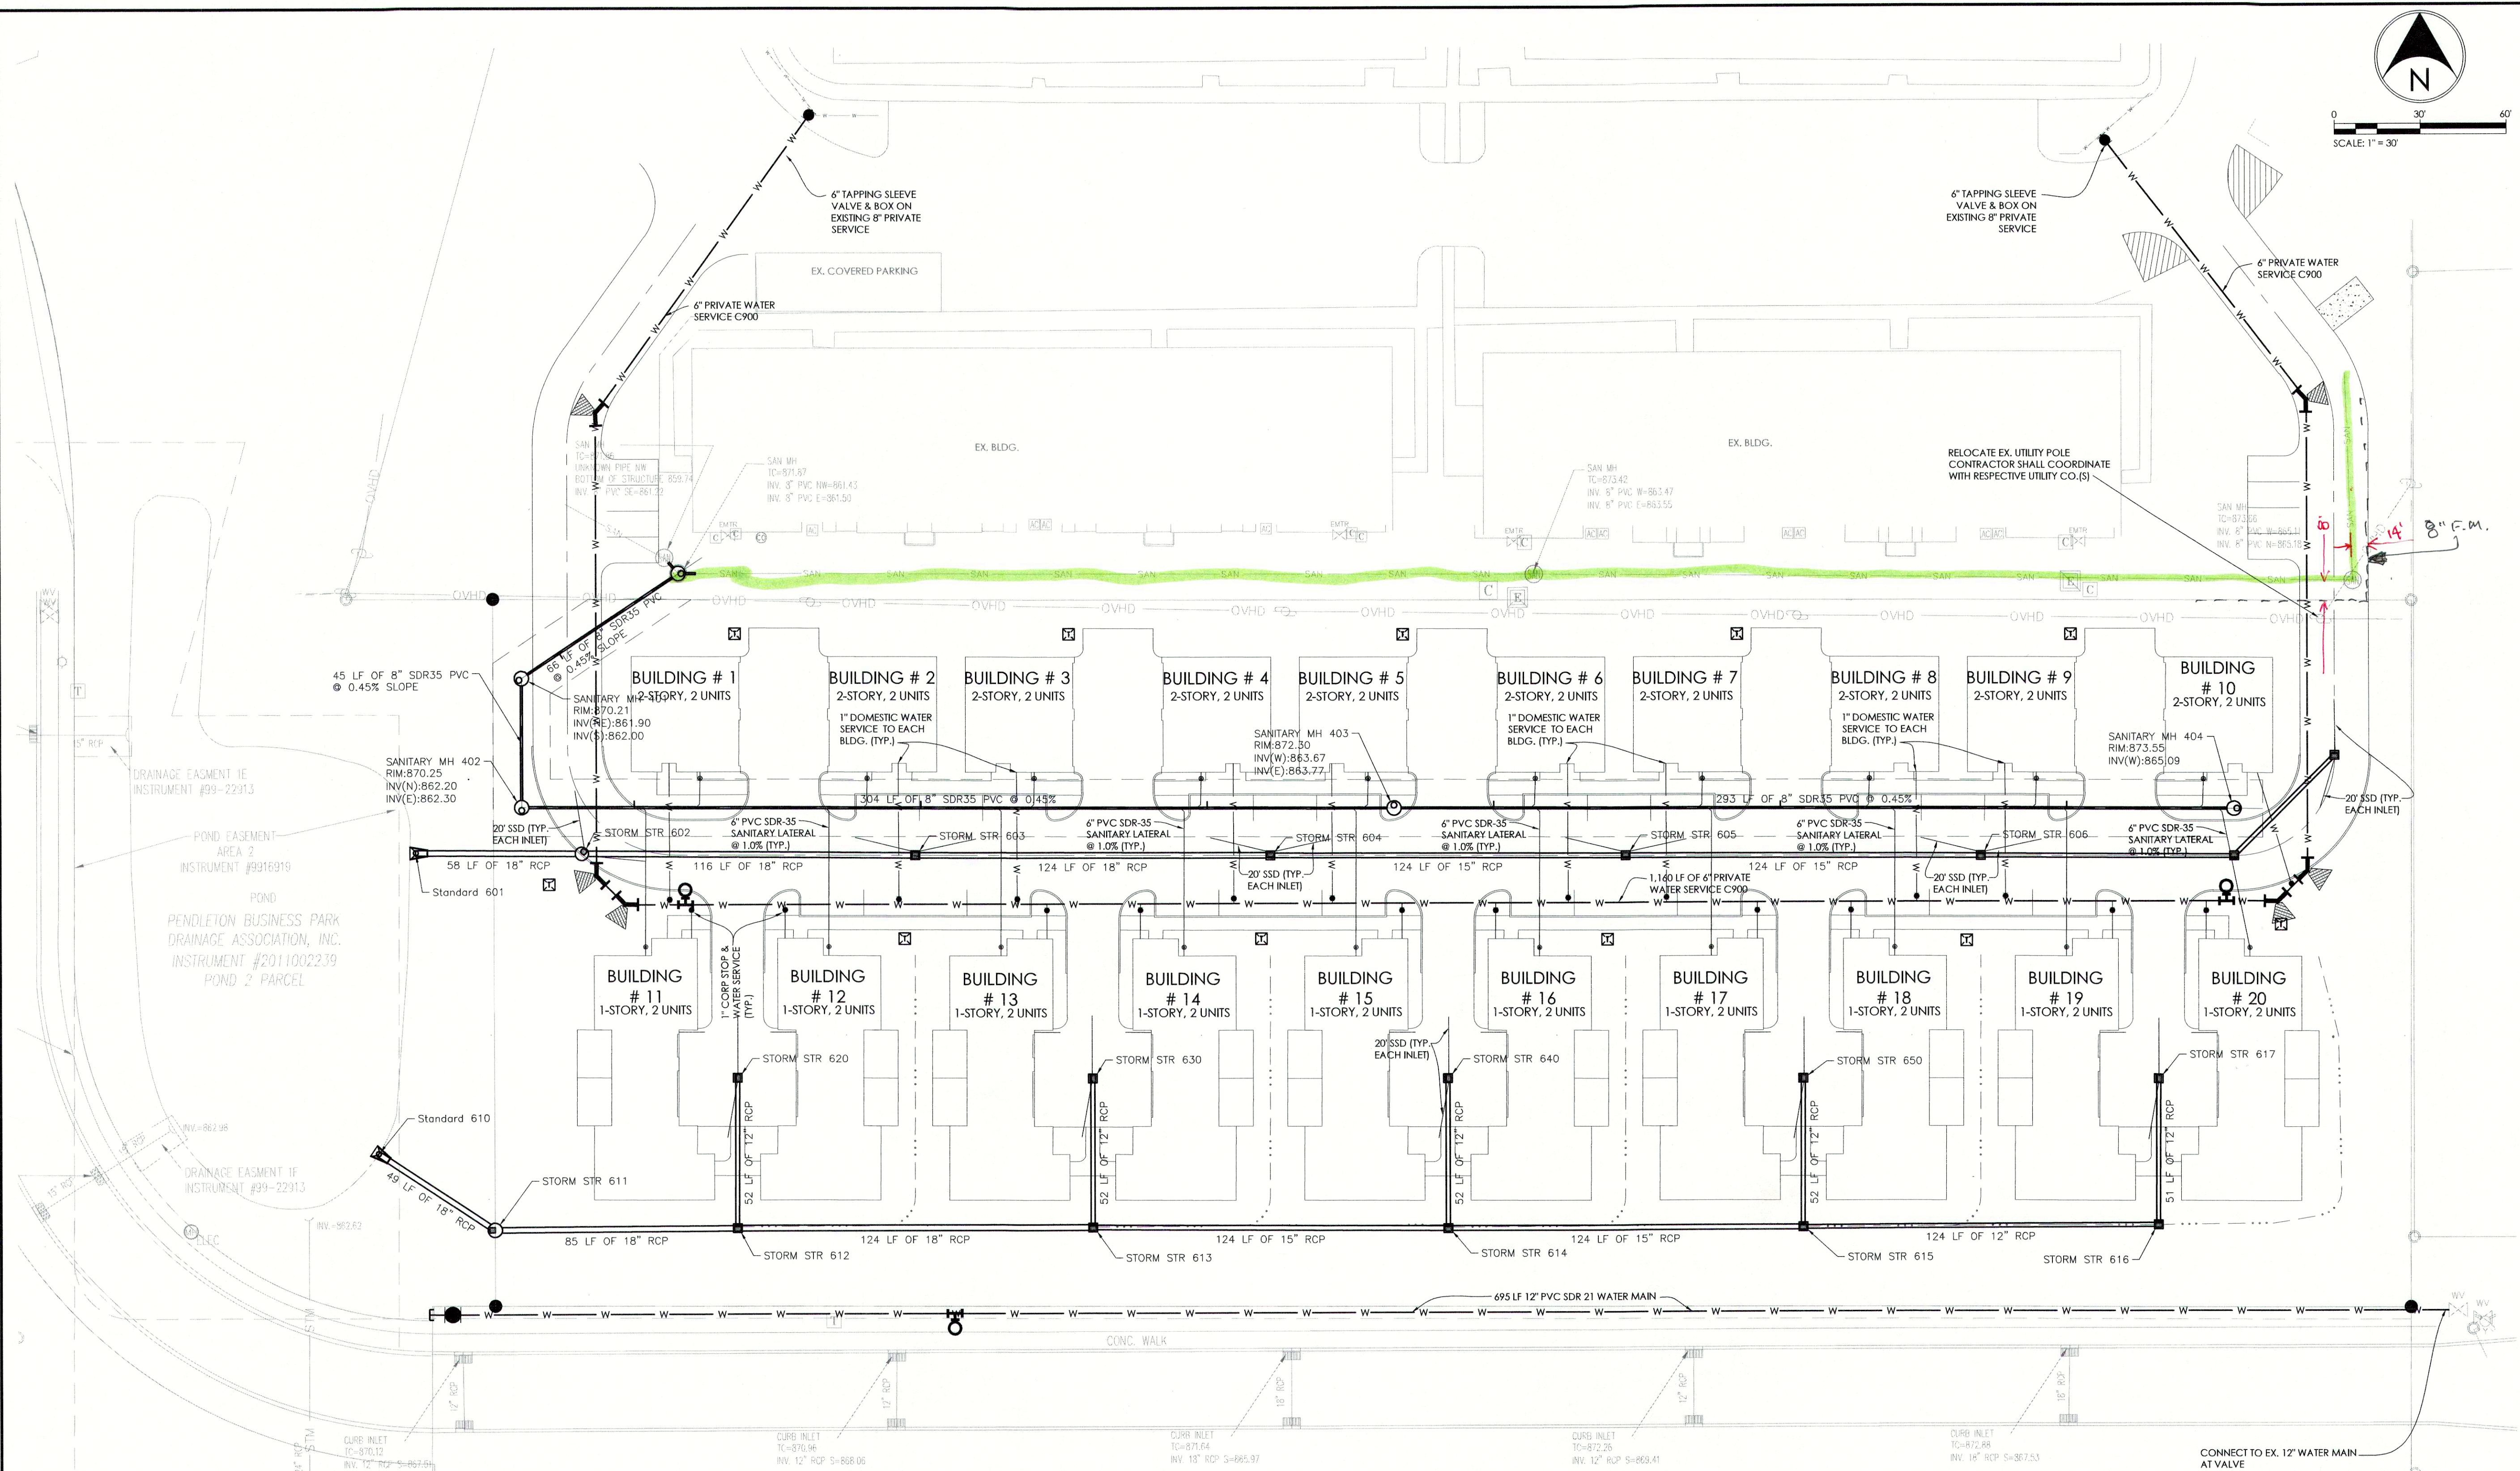

STORM STRUCTURE DATA TABLE				
STRUCTURE NO.	RIM	NEENAH CASTING DESIGNATION	STRUCTURE TYPE	NOTES
601	867.03	N/A	CONCRETE F.E.S.	Pipe End Section
602	870.46	R-3472	Standard	Manhole Type-C
603	870.89	R-3472	Standard	Inlet Type-A
604	871.26	R-3472	Standard	Inlet Type-A
605	871.63	R-3472	Standard	Inlet Type-A
606	872.00	R-3472	Standard	Inlet Type-A
607	872.90	R-3472	Standard	Inlet Type-A
608	871.80	R-3472	Standard	Inlet Type-A
610	866.64	N/A	CONCRETE F.E.S.	Pipe End Section
611	870.32	R-1772	Standard	Manhole Storm

STORM STRUCTURE DATA TABLE				
STRUCTURE NO.	RIM	NEENAH CASTING DESIGNATION	STRUCTURE TYPE	NOTES
612	870.98	R-4342	Standard	Inlet Type-A
613	871.12	R-4342	Standard	Inlet Type-A
614	871.47	R-4342	Standard	Inlet Type-A
615	871.55	R-4342	Standard	Inlet Type-A
616	871.75	R-4342	Standard	Inlet Type-A
617	872.87	R-3472	Standard	Inlet Type-A
620	871.87	R-3472	Standard	Inlet Type-A
630	872.12	R-3472	Standard	Inlet Type-A
640	872.37	R-3472	Standard	Inlet Type-A
650	872.62	R-3472	Standard	Inlet Type-A

STORM PIPE DATA TABLE					
UPSTREAM STRUCTURE NO.	DOWNSTREAM STRUCTURE NO.	L.F.	SIZE / TYPE	SLOPE %	UPSTREAM INV.
602	601	58	18" RCP	0.50%	865.61
603	602	116	18" RCP	0.35%	866.02
604	603	124	18" RCP	0.30%	866.39
605	604	124	15" RCP	0.35%	867.02
606	605	124	15" RCP	0.30%	867.39
607	606	88	12" RCP	0.30%	867.85
608	607	50	12" RCP	0.30%	868.00
611	610	49	18" RCP	0.40%	865.13
612	611	85	18" RCP	0.40%	865.97
613	612	124	18" RCP	0.25%	866.28

STORM PIPE DATA TABLE					
UPSTREAM STRUCTURE NO.	DOWNSTREAM STRUCTURE NO.	L.F.	SIZE / TYPE	SLOPE %	UPSTREAM INV.
614	613	124	15" RCP	0.35%	866.91
615	614	124	15" RCP	0.30%	867.28
616	615	124	12" RCP	0.30%	867.85
617	616	51	12" RCP	0.30%	868.00
620	612	52	12" RCP	0.30%	867.90
630	613	52	12" RCP	0.30%	868.30
640	614	52	12" RCP	0.30%	868.90
650	615	52	12" RCP	0.30%	869.00

CIVIL ENGINEERS
LAND SURVEYORS
DEVELOPMENT CONSULTANTS
GEO-TECHNICAL
ENVIRONMENTAL
CONSTRUCTION STAKING
CONSTRUCTION MAT TESTING

TERRA

SITE DEVELOPMENT

1307 W. 161st Street Westfield, IN 46074
P: 317.999.1216 F: 317.663.3049
www.TERRAlanddev.com

CONSTRUCTION PLANS FOR:
PENDLETON PLACE APTS., PHASE III

PENDLETON FALL CREEK MADISON IN 46054 S19 T18N R7E
R&B ARCHITECTS
3302 N. MERIDIAN STREET, INDIANAPOLIS, IN 46202

UTILITY PLAN

PLAN DATE: 7/5/2016

DESIGN: AF CHECK: JF DRAWING: KIG

PROJECT NO: 1601009

SHEET NO: C401