


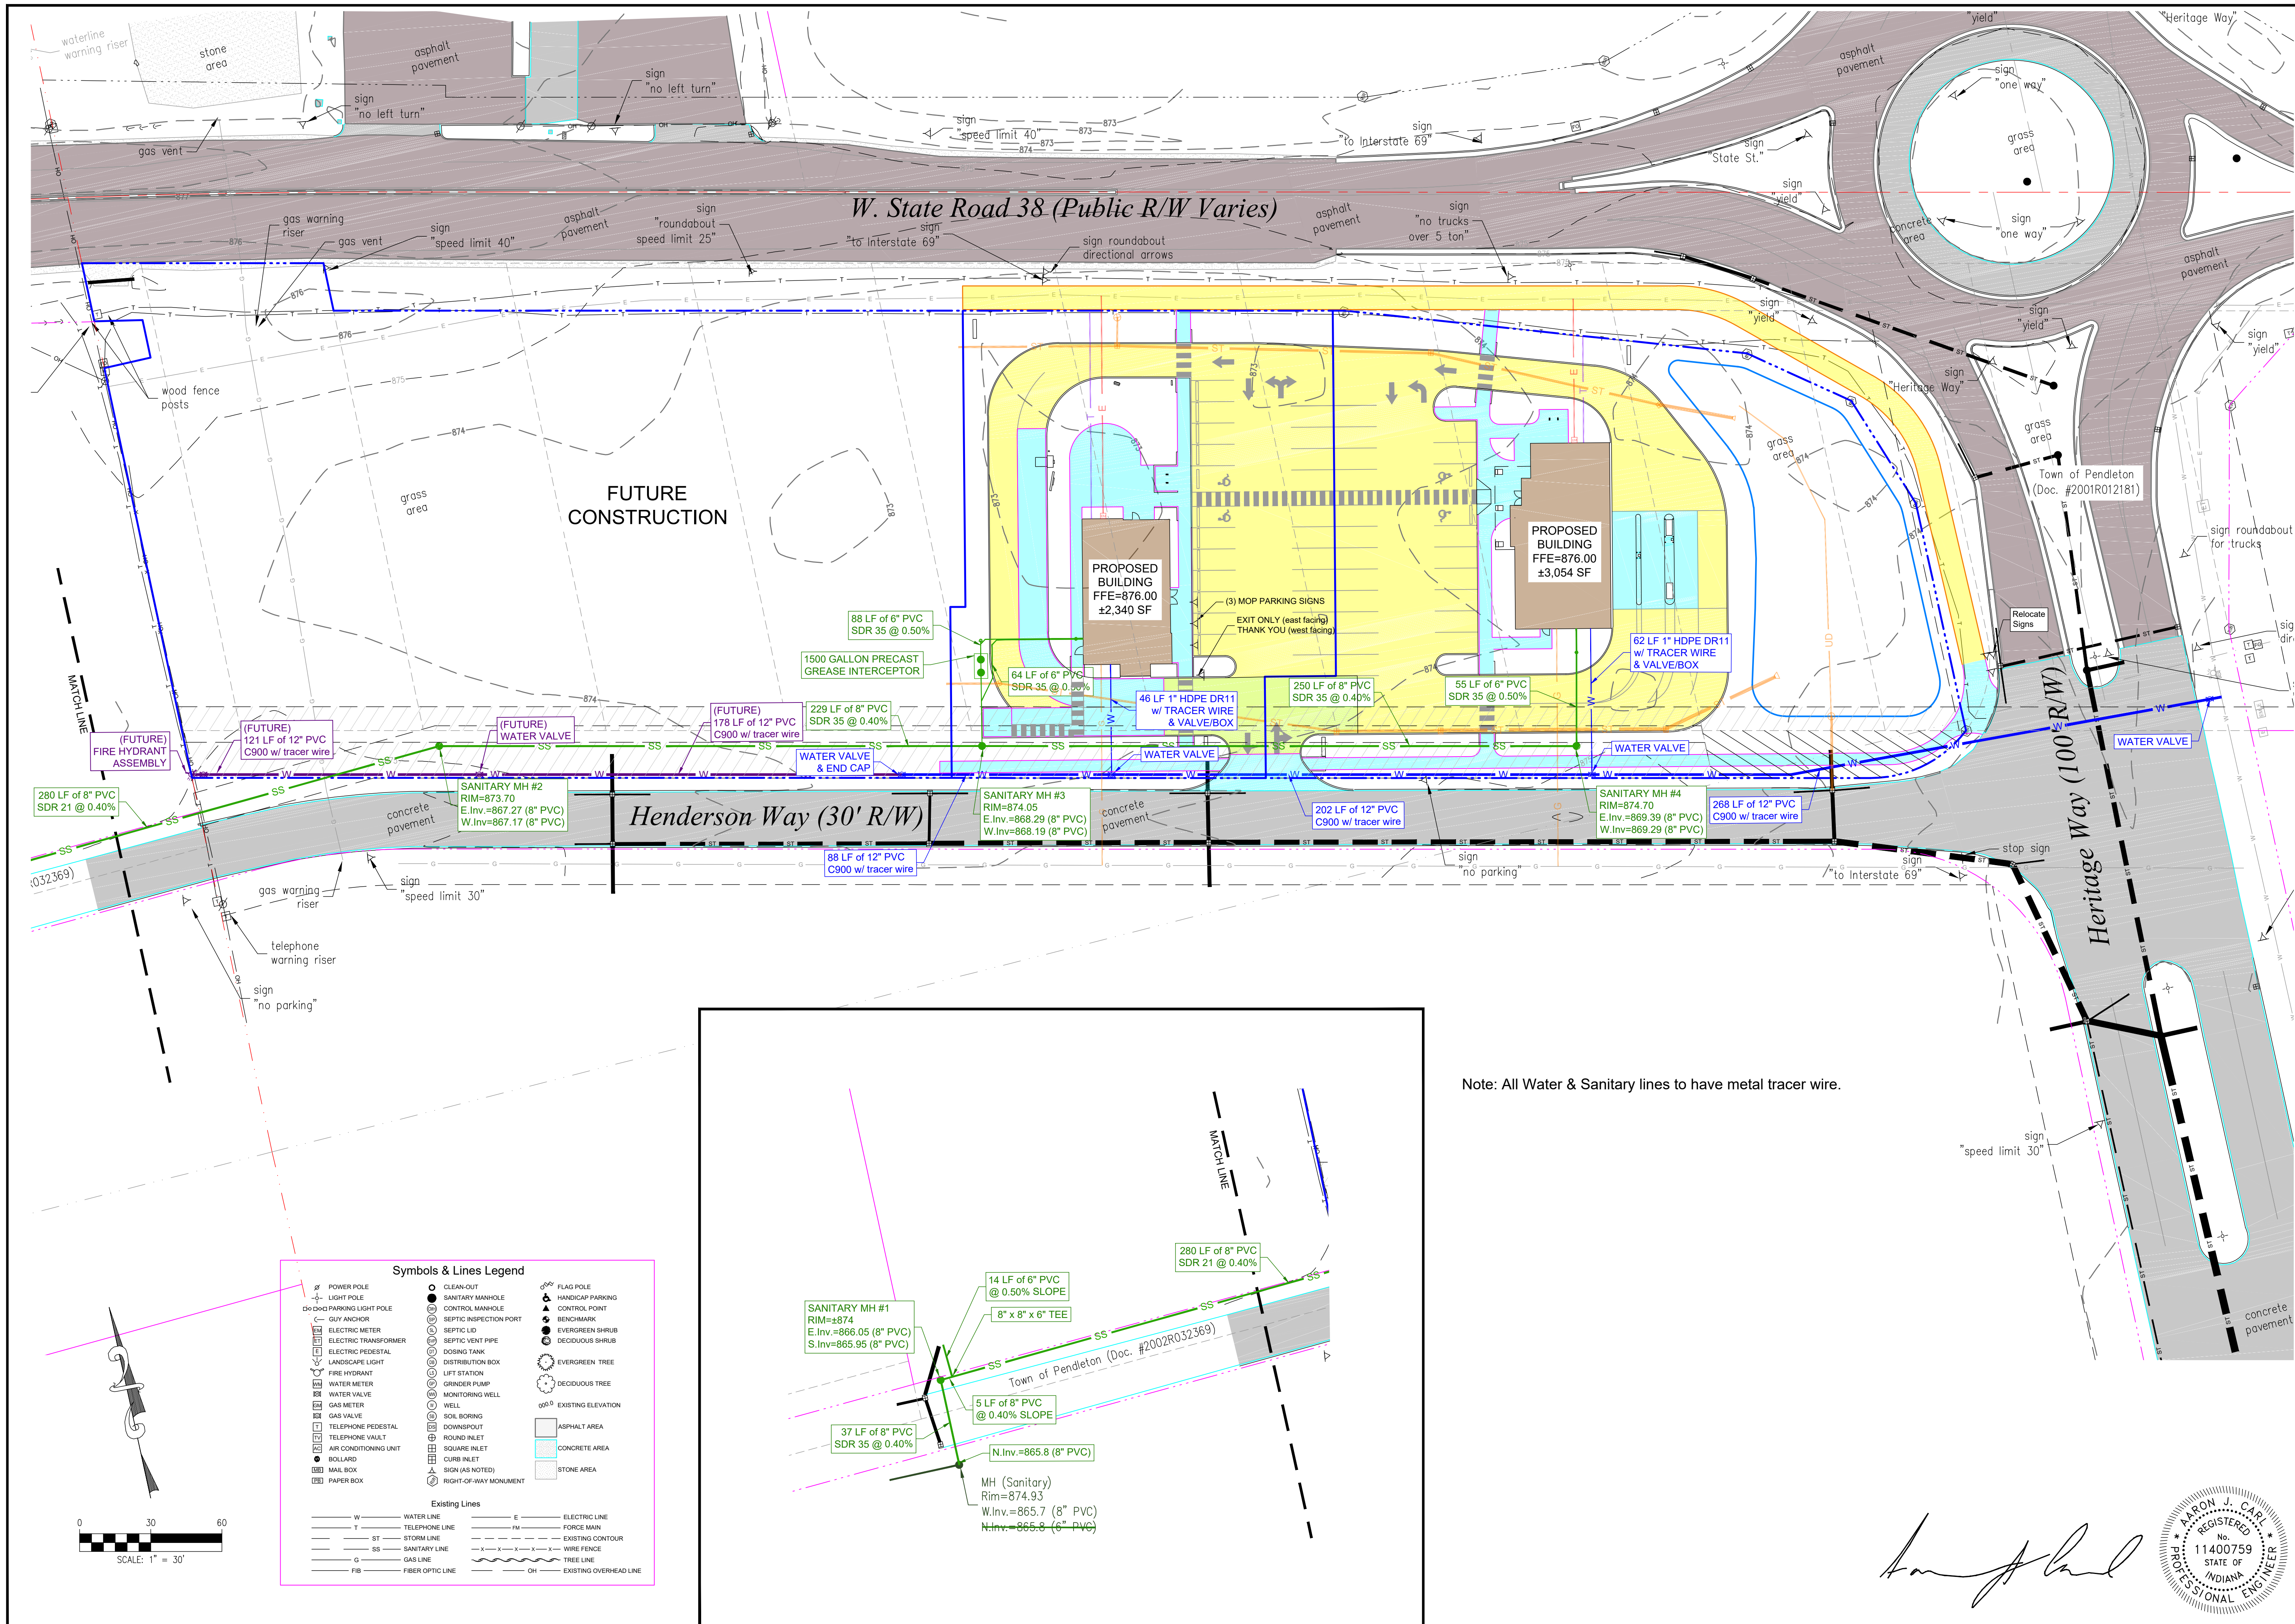

Note: All Water & Sanitary lines to have metal tracer wire.

Symbols & Lines Legend

	POWER POLE		CLEAN-OUT		FLAG POLE
	LIGHT POLE		SANITARY MANHOLE		HANDICAP PARKING
	FLAG POLE		CONTROL MANHOLE		CONTROL POINT
	GUY ANCHOR		SEPTIC INSPECTION PORT		BENCHMARK
	ELECTRIC METER		SEPTIC LID		EVERGREEN SHRUB
	ELECTRIC TRANSFORMER		SEPTIC VENT PIPE		DECIDUOUS SHRUB
	ELECTRIC PEDESTAL		DOSING TANK		EVERGREEN TREE
	LANDSCAPE LIGHT		DISTRIBUTION BOX		DECIDUOUS TREE
	FIRE HYDRANT		LIFT STATION		EXISTING ELEVATION
	WATER METER		GRINDER PUMP		
	WATER VALVE		MONITORING WELL		
	GAS METER		WELL		
	GAS VALVE		SOIL BORING		
	TELEPHONE PEDESTAL		DOWNSPOUT		
	TELEPHONE VAULT		ROUND INLET		ASPHALT AREA
	AIR CONDITIONING UNIT		SQUARE INLET		CONCRETE AREA
	BOLLARD		CURB INLET		STONE AREA
	MAIL BOX		SIGN (AS NOTED)		
	PAPER BOX		RIGHT-OF-WAY MONUMENT		

Existing Lines

	W	WATER LINE		E	ELECTRIC LINE
	T	TELEPHONE LINE		FM	FORCE MAIN
	ST	STORM LINE			EXISTING CONTOUR
	SS	SANITARY LINE			WIRE FENCE
	G	GAS LINE			TREE LINE
	FIB	FIBER OPTIC LINE		OH	EXISTING OVERHEAD LINE

T-E INCORPORATED

8620 Bluffton Road
Fort Wayne, IN 46809
Phone (260) 489-5541
FAX (260) 489-3174
Email TE@t-inc.com

The concepts, designs, plans, and details as shown on this drawing are the property of T-E INCORPORATED and were created, developed, and presented for use on this specific project. No portion may be made without the written consent of T-E INCORPORATED.

Surveying • Engineering • Asphalt • Utilities • Site Development

StrategicGrowth

ADVISORS

By:	Remarks	No.	Date:
JMS	Revisions per City Banning Comments	1	05/17/22
JMS	Revisions Sanitary & Water	2	05/23/22
JMS	Revised Signs & Spot Grades per INDOT	3	05/31/22
JMS	Revised per Starbucks Comments	4	07/07/22
JMS	Revised Trail & Sidewalk Grading	5	07/26/22
JMS	Revised Sanitary Plan & Details	6	08/12/22
JMS	Site Layout Revision	7	12/12/22

3 Rivers Federal Credit Union

Sanitary & Water Plan

Address: W. State Road 38
Pendleton, Indiana 46064
Attn: Michael Romary
110 West Main Street, Suite 2000
Fort Wayne, IN 46802

Date: 5-12-22

Drawn By: SAL

Checked By: AJC

Job No.: 21183

Scale: as shown

Sheet No.: C4.1