




FOR CONTINUATION
SEE SHEET No. 5

FOR CONTINUATION
SEE SHEET No. 5

NOTE:
ADDITIONAL RIGHT-OF-WAY OR EASEMENTS MAY
NEED TO BE ACQUIRED FOR INSTALLATION OF SEWER.

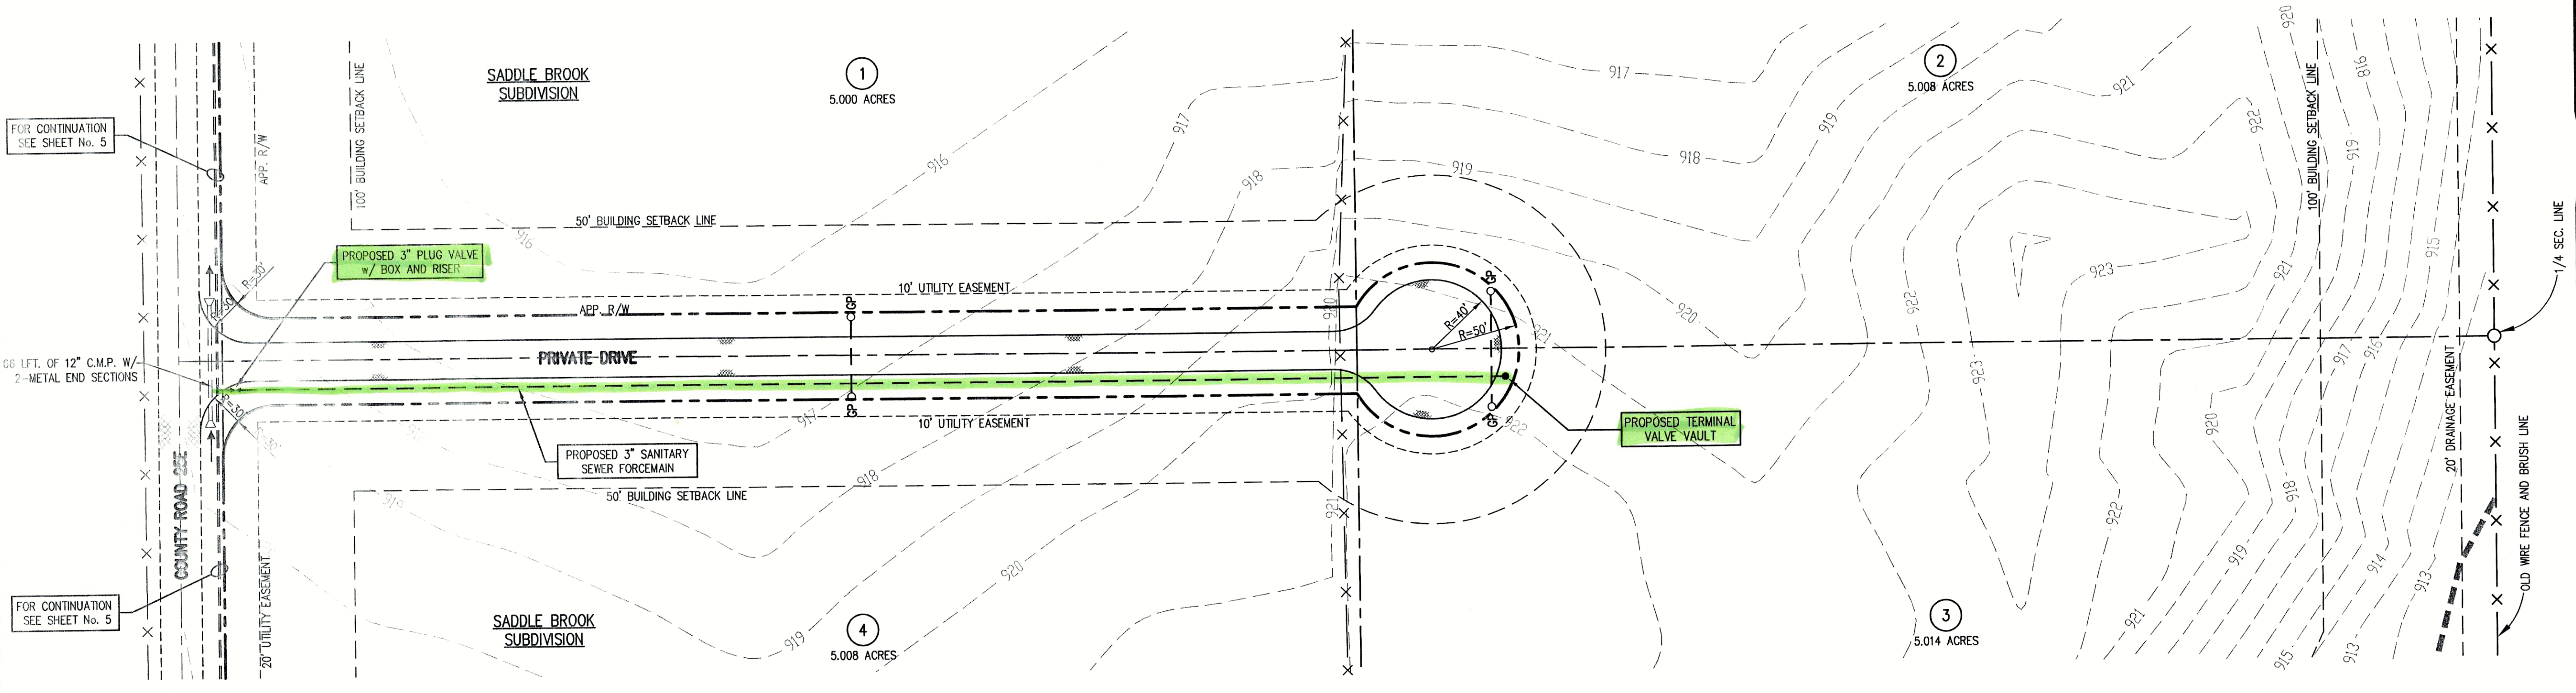

DON'T DIG BLIND
CALL BEFORE YOU DIG
1-800-372-5544
1-800-471-5200

PER INDIANA STATE LAW 15-69-1891, IT IS
AGAINST THE LAW TO EXCAVATE WITHOUT
NOTIFYING THE UNDERGROUND LOCATION SERVICE
TWO (2) WORKING DAYS BEFORE COMMENCING WORK.

NOTE: CONTRACTOR TO VERIFY ALL UTILITY LOCATIONS
PRIOR TO THE START OF CONSTRUCTION

GENERAL NOTES:

- ALL UTILITY LOCATIONS ARE APPROXIMATE. THE CONTRACTOR SHALL HAVE ALL UTILITIES FIELD VERIFIED AND MARKED PRIOR TO CONSTRUCTION.
- CONTRACTOR SHALL MAINTAIN A MINIMUM 10'-0" HORIZONTAL AND 18" VERTICAL SEPARATION BETWEEN SEWER AND WATER MAINS.
- ALL PROPOSED TOP OF CASTING ELEVATIONS ARE APPROXIMATE. THE CONTRACTOR SHALL ADJUST FINAL ELEVATIONS AS REQUIRED TO BE FLUSH WITH PAVEMENT.
- ALL SEWER TRENCHES SHALL BE BACKFILLED WITH FULL DEPTH COMPACTED GRANULAR BACKFILL ("B" BORROW) UNDER OR WITHIN 5' OF EDGE OF PAVEMENT.
- THE CONTRACTOR SHALL VISIT THE SITE PRIOR TO BID TO BECOME FAMILIAR WITH ALL SITE CONDITIONS.
- THE CONTRACTOR SHALL PROVIDE THE REQUIRED MEANS FOR MAINTAINING SAFE TRAFFIC AT ALL TIMES.
- CONTRACTOR SHALL RESTORE ALL DISTURBED LAWN AREAS, STREETS, WALKS, DRIVES, ETC. AS SHOWN ON DRAWINGS, IN THE SPECIFICATIONS, OR TO AT LEAST PRE-EXISTING CONDITIONS.
- ALL UTILITY CROSSINGS SHALL BE PROTECTED AND SUPPORTED WITH GRANULAR FILL OR CONCRETE AS REQUIRED PER THE DETAIL SHEET.


LEGEND:

- TREE
- POWER POLE
- GUY WIRE
- FIRE HYDRANT
- MAILBOX
- FLAGPOLE
- SPOT SHOT
- CONTOUR
- FENCE
- EXISTING SANITARY SEWER FORCEMAIN
- NEW SANITARY SEWER FORCEMAIN
- NEW GRINDER PUMP VAULT
- WATER LINE
- GAS LINE
- UNDERGROUND ELECTRIC LINE
- UNDERGROUND TELEPHONE LINE
- APPROX. RIGHT-OF-WAY
- APPROX. CORPORATE LIMITS
- APPROX. PROPERTY LINE
- EXISTING WATER WELL
- EXISTING SEPTIC TANK
- EXISTING TELEPHONE RISER

NOTES:
ALL GRINDER PUMP VAULTS SHALL BE
LOCATED INSIDE THE RIGHT-OF-WAY AT THE
EXISTING RIGHT-OF-WAY LINE.



SCALE:
HORIZONTAL 1" = 50'
VERTICAL 1" = 5'

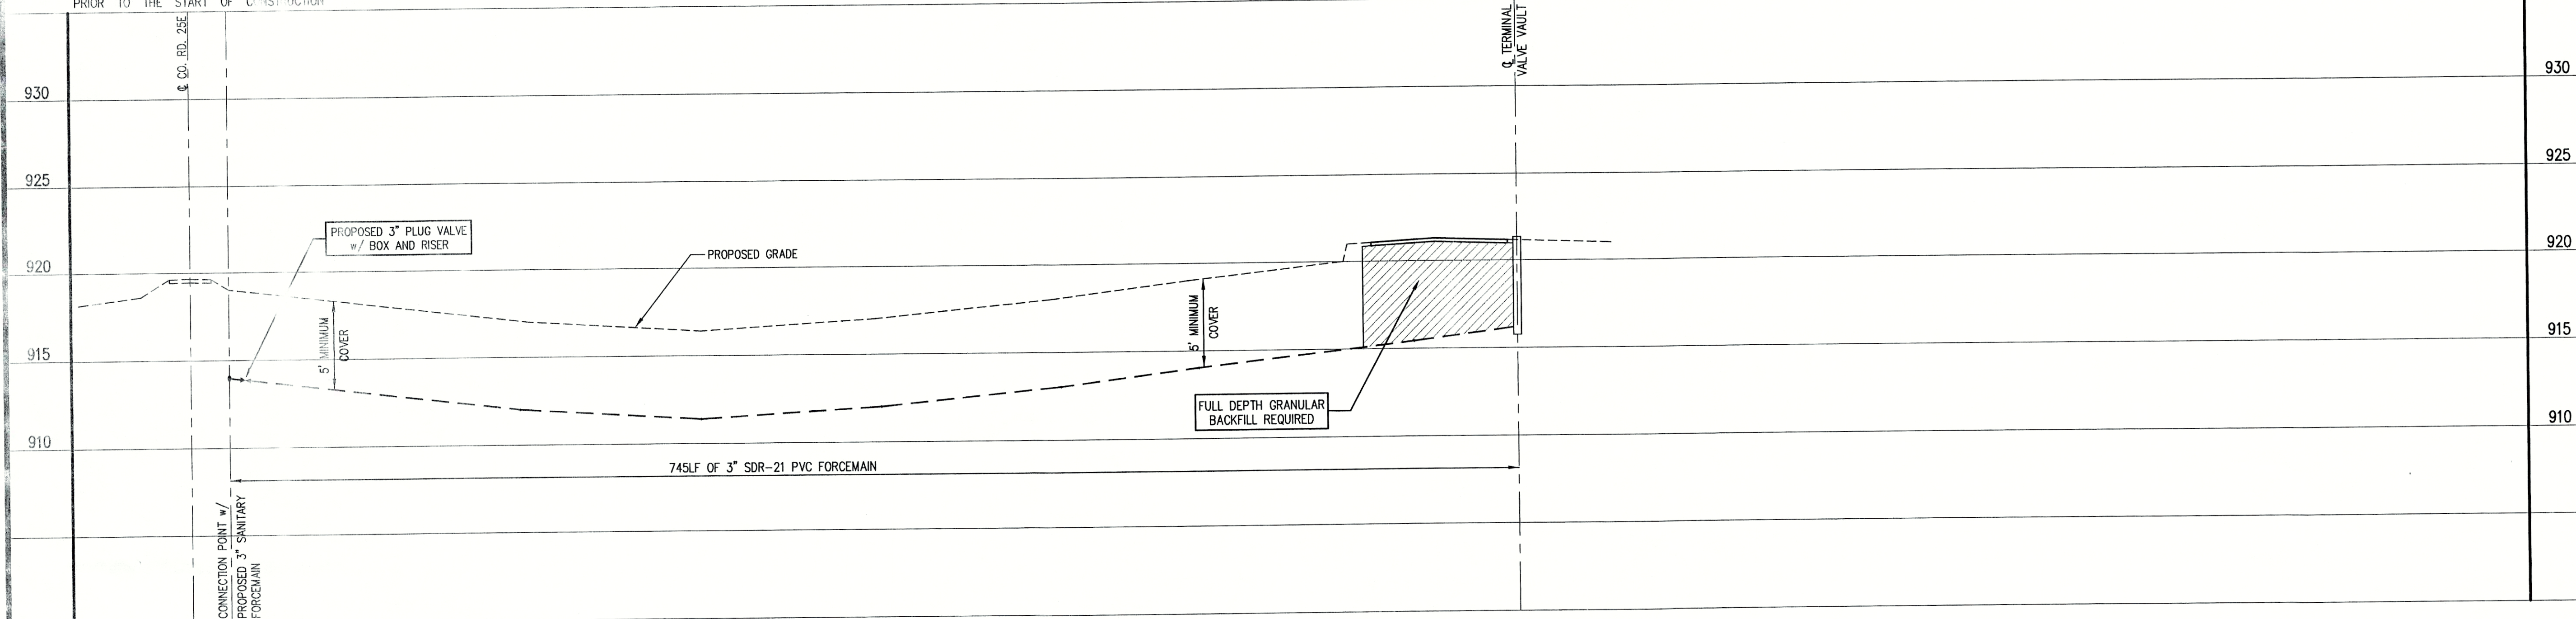

CONSULTANT:

REVISIONS:


DATE	DESCRIPTION	BY

APPROVED BY:

12-22-99



Thomas M. Schubert, P.E.

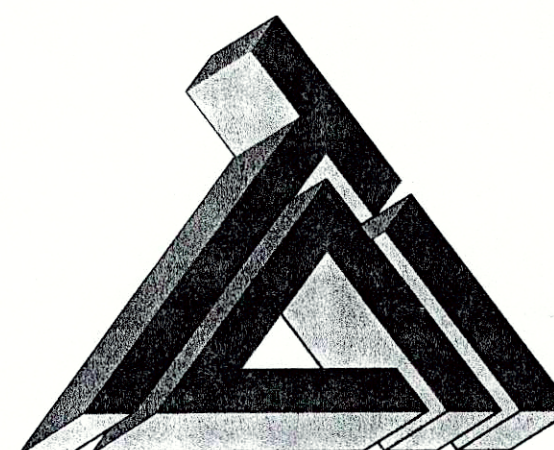

TRIAD ASSOCIATES INC.
5835 LAWTON LOOP EAST DRIVE
INDIANAPOLIS, INDIANA 46216
PHONE: 317-377-5230 FAX: 317-377-5241

DESIGNED FOR:

SADDLE BROOK ADDITION
OWNER: MR. LARRY KEESLING

SHEET TITLE:
**SANITARY SEWER COLLECTION
SYSTEM PLAN AND PROFILE**

JOB NUMBER: 980021	CHECKED BY: J.W.F.
SCALE: AS NOTED	PLOT DATE: 12/22/99
PLOT SCALE: 1"=50'	DATE: 04/12/98
DRAWN BY: DAP	DESIGNED BY: D.A. Pauling
DRAWING NAME: CR25E C4	

SHEET No.

06

OF 03