


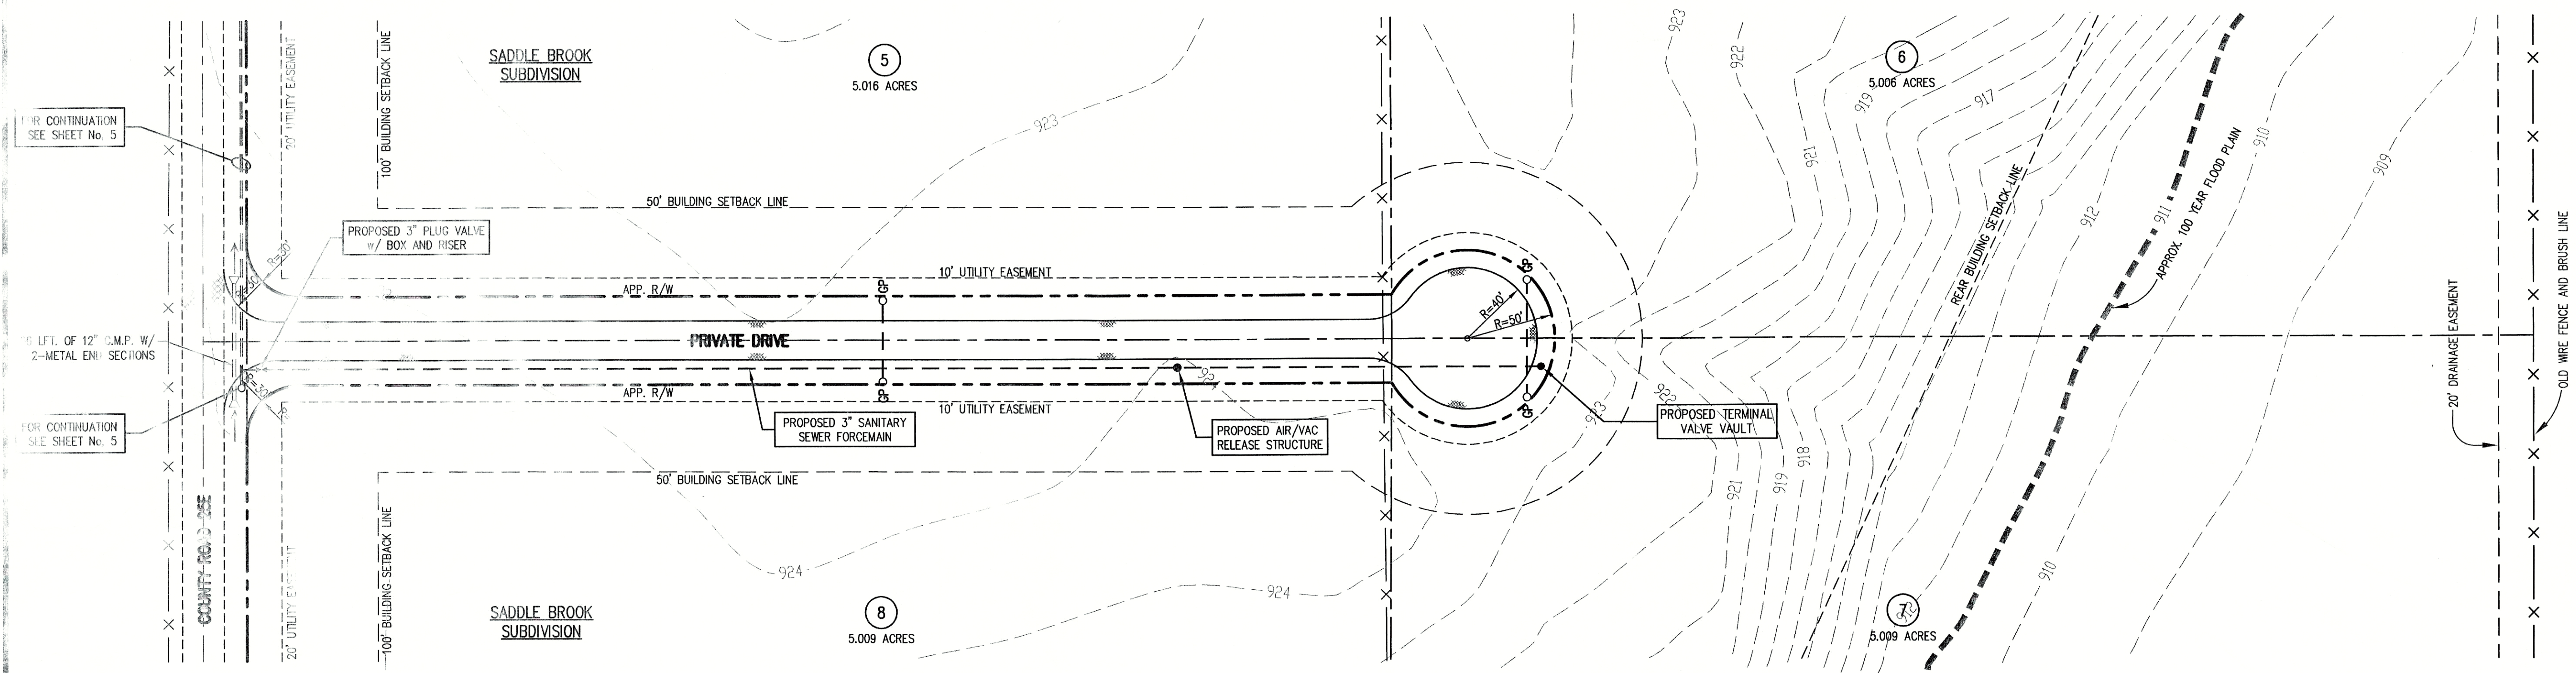

NOTE:
ADDITIONAL RIGHT-OF-WAY OR EASEMENTS MAY
NEED TO BE ACQUIRED FOR INSTALLATION OF SEWER.



DON'T DIG BLIND
CALL BEFORE YOU DIG
1-800-382-5544
1-800-428-5200

PER INDIANA STATE LAW IS-89-1991, IT IS
AGAINST THE LAW TO EXCAVATE WITHOUT
NOTIFYING THE UNDERGROUND LOCATION SERVICE
TWO (2) WORKING DAYS BEFORE COMMENCING WORK.

NOTE: CONTRACTOR TO VERIFY ALL UTILITY LOCATIONS
PRIOR TO THE START OF CONSTRUCTION

GENERAL NOTES:

1. ALL UTILITY LOCATIONS ARE APPROXIMATE. THE CONTRACTOR SHALL HAVE ALL UTILITIES FIELD VERIFIED AND MARKED PRIOR TO CONSTRUCTION.
2. CONTRACTOR SHALL MAINTAIN A MINIMUM 10'-0" HORIZONTAL AND 18" VERTICAL SEPARATION BETWEEN SEWER AND WATER MAINS.
3. ALL PROPOSED TOP OF CASTING ELEVATIONS ARE APPROXIMATE. THE CONTRACTOR SHALL ADJUST FINAL ELEVATIONS AS REQUIRED TO BE FLUSH WITH PAVEMENT.
4. ALL SEWER TRENCHES SHALL BE BACKFILLED WITH FULL DEPTH COMPACTED GRANULAR BACKFILL ("B" BORROW) UNDER OR WITHIN 5' OF EDGE OF PAVEMENT.
5. THE CONTRACTOR SHALL VISIT THE SITE PRIOR TO BID TO BECOME FAMILIAR WITH ALL SITE CONDITIONS.
6. THE CONTRACTOR SHALL PROVIDE THE REQUIRED MEANS FOR MAINTAINING SAFE TRAFFIC AT ALL TIMES.
7. CONTRACTOR SHALL RESTORE ALL DISTURBED LAWN AREAS, STREETS, WALKS, DRIVES, ETC. AS SHOWN ON DRAWINGS, IN THE SPECIFICATIONS, OR TO AT LEAST PRE-EXISTING CONDITIONS.
8. ALL UTILITY CROSSINGS SHALL BE PROTECTED AND SUPPORTED WITH GRANULAR FILL OR CONCRETE AS REQUIRED PER THE DETAIL SHEET.


- TREE
- POWER POLE
- GUY WIRE
- ⋈ FIRE HYDRANT
- ⊕ MAILBOX
- FP FLAGPOLE
- X 1085.2 SPOT SHOT

LEGEND:

- 1085 CONTOUR
- X — FENCE
- EXISTING SANITARY SEWER FORCEMAIN
- NEW SANITARY SEWER FORCEMAIN
- NEW GRINDER PUMP VAULT
- 4" W — WATER LINE
- 2" G — GAS LINE
- E — UNDERGROUND ELECTRIC LINE
- T — UNDERGROUND TELEPHONE LINE
- APPROX. RIGHT-OF-WAY
- APPROX. CORPORATE LIMITS
- APPROX. PROPERTY LINE
- W EXISTING WATER WELL
- S EXISTING SEPTIC TANK
- EXISTING TELEPHONE RISER



SCALE:
HORIZONTAL 1" = 50'
VERTICAL 1" = 5'


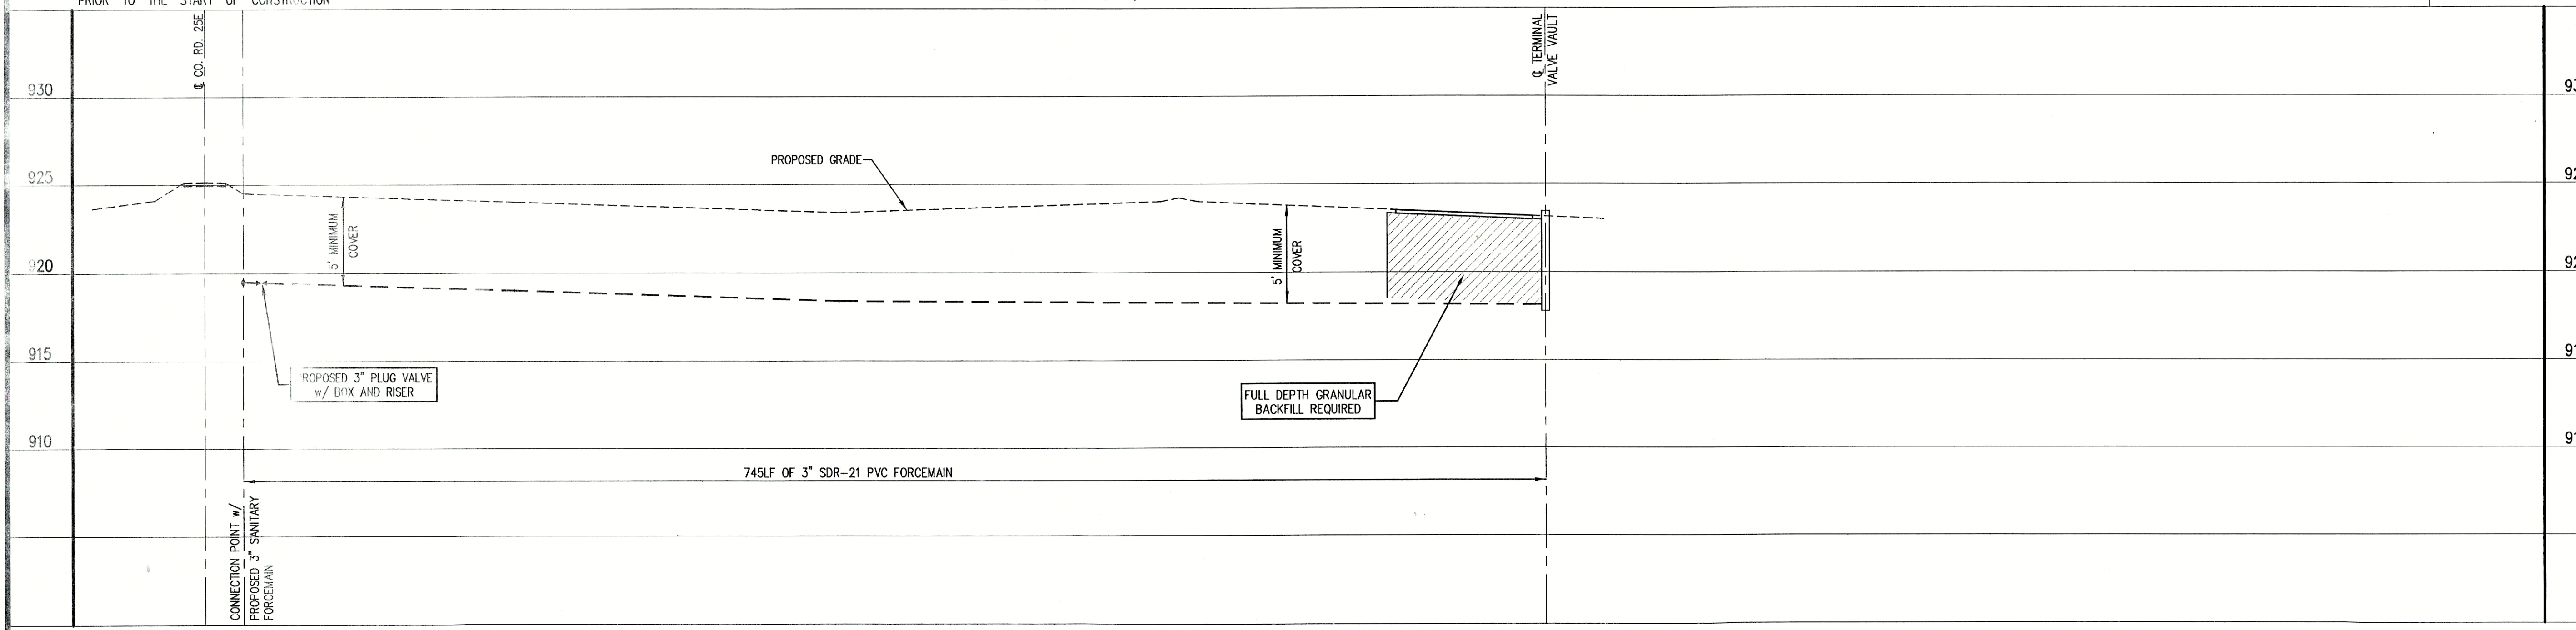


CONSULTANT:

REVISIONS:

DATE	DESCRIPTION	BY

APPROVED BY:

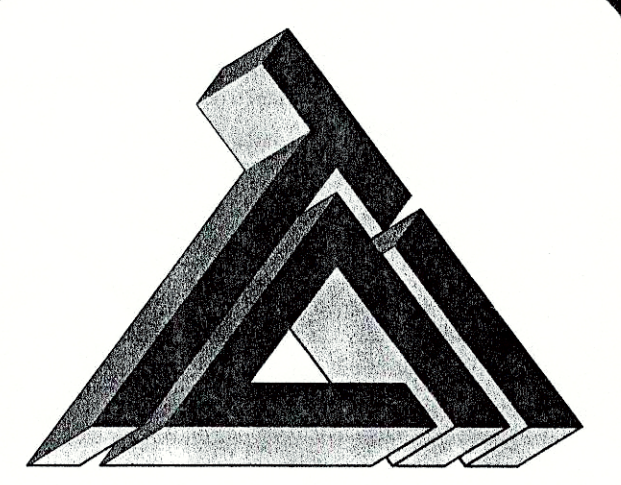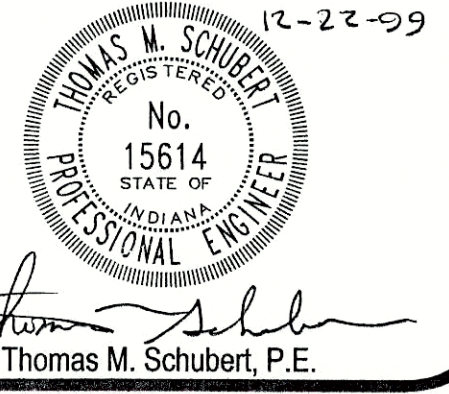

TRIAD ASSOCIATES INC.
5835 LAWTON LOOP EAST DRIVE
INDIANAPOLIS, INDIANA 46216
PHONE: 317-377-5230 FAX: 317-377-5241

DESIGNED FOR:

SADDLE BROOK ADDITION
OWNER: MR. LARRY KEESLING

SHEET TITLE:
SANITARY SEWER COLLECTION
SYSTEM PLAN AND PROFILE

JOB NUMBER: 980021	CHECKED BY: J.W.F.
SCALE: AS NOTED	PLOT DATE: 12/22/99
PLOT SCALE: 1"=50'	DATE: 04/12/98
DRAWN BY: DAP	DESIGNED BY: D.A. Pauling
DRAWING NAME: CR25E_C5	

SHEET No.

07
OF 08