
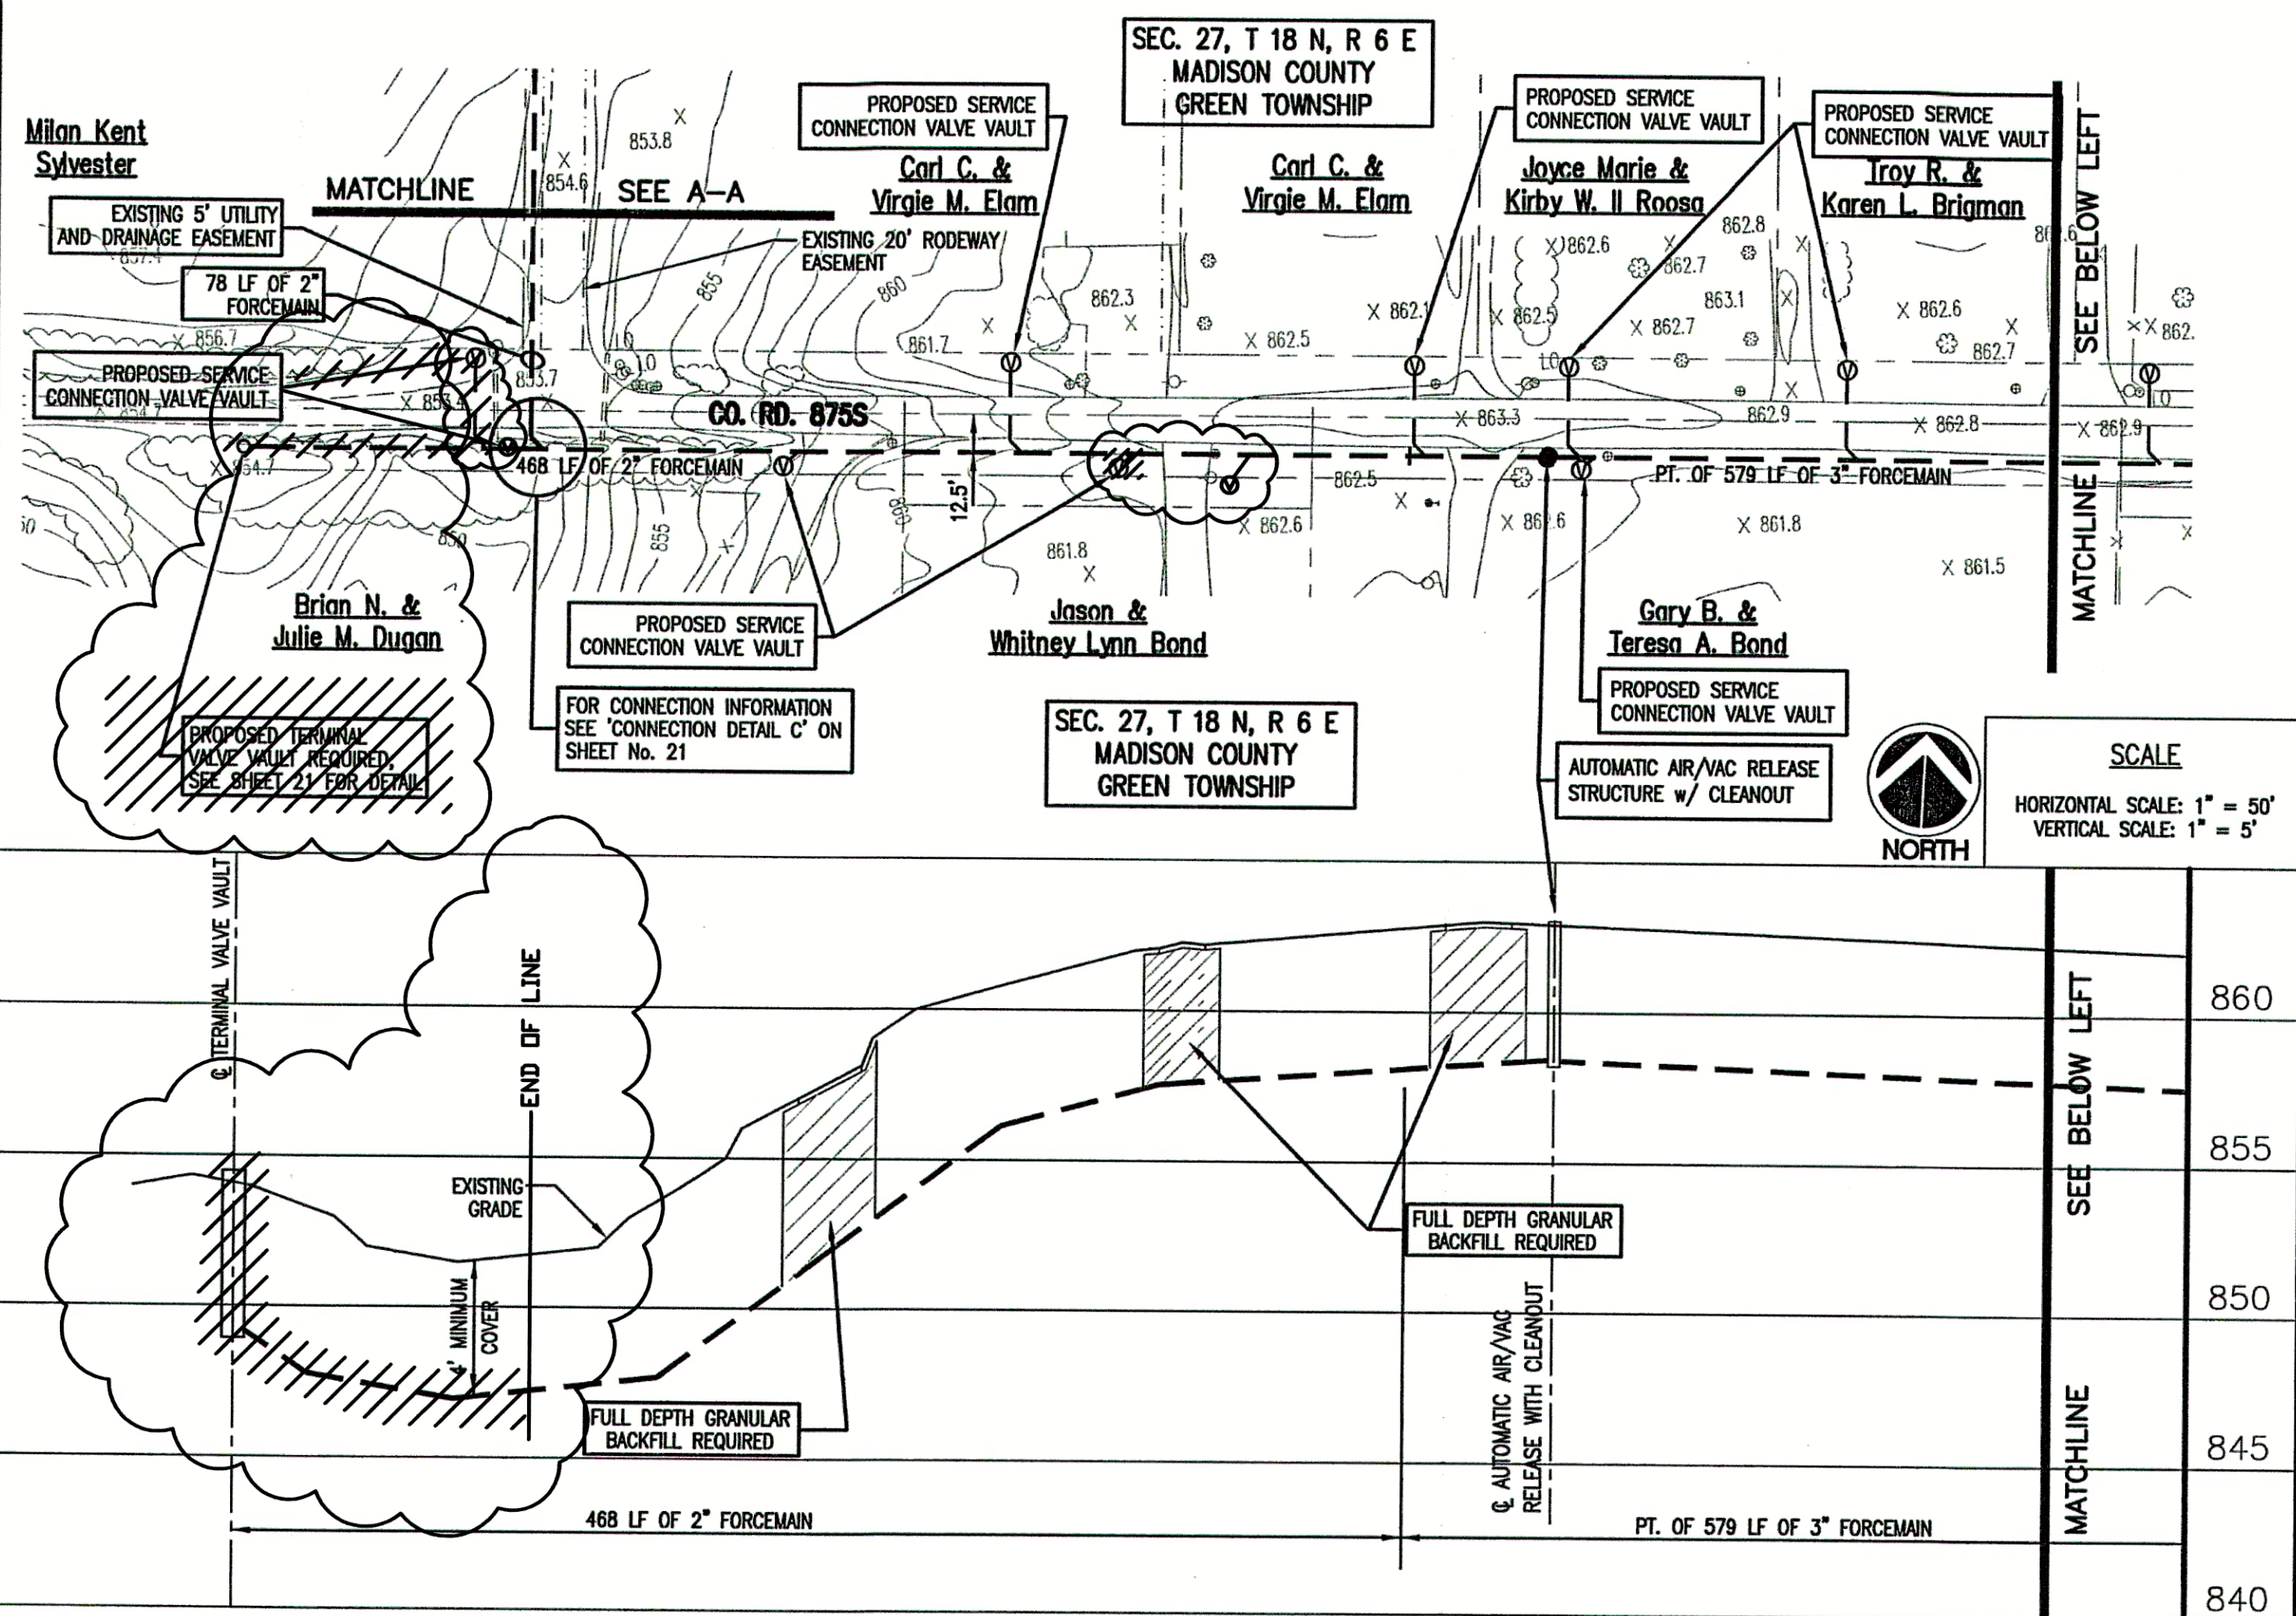
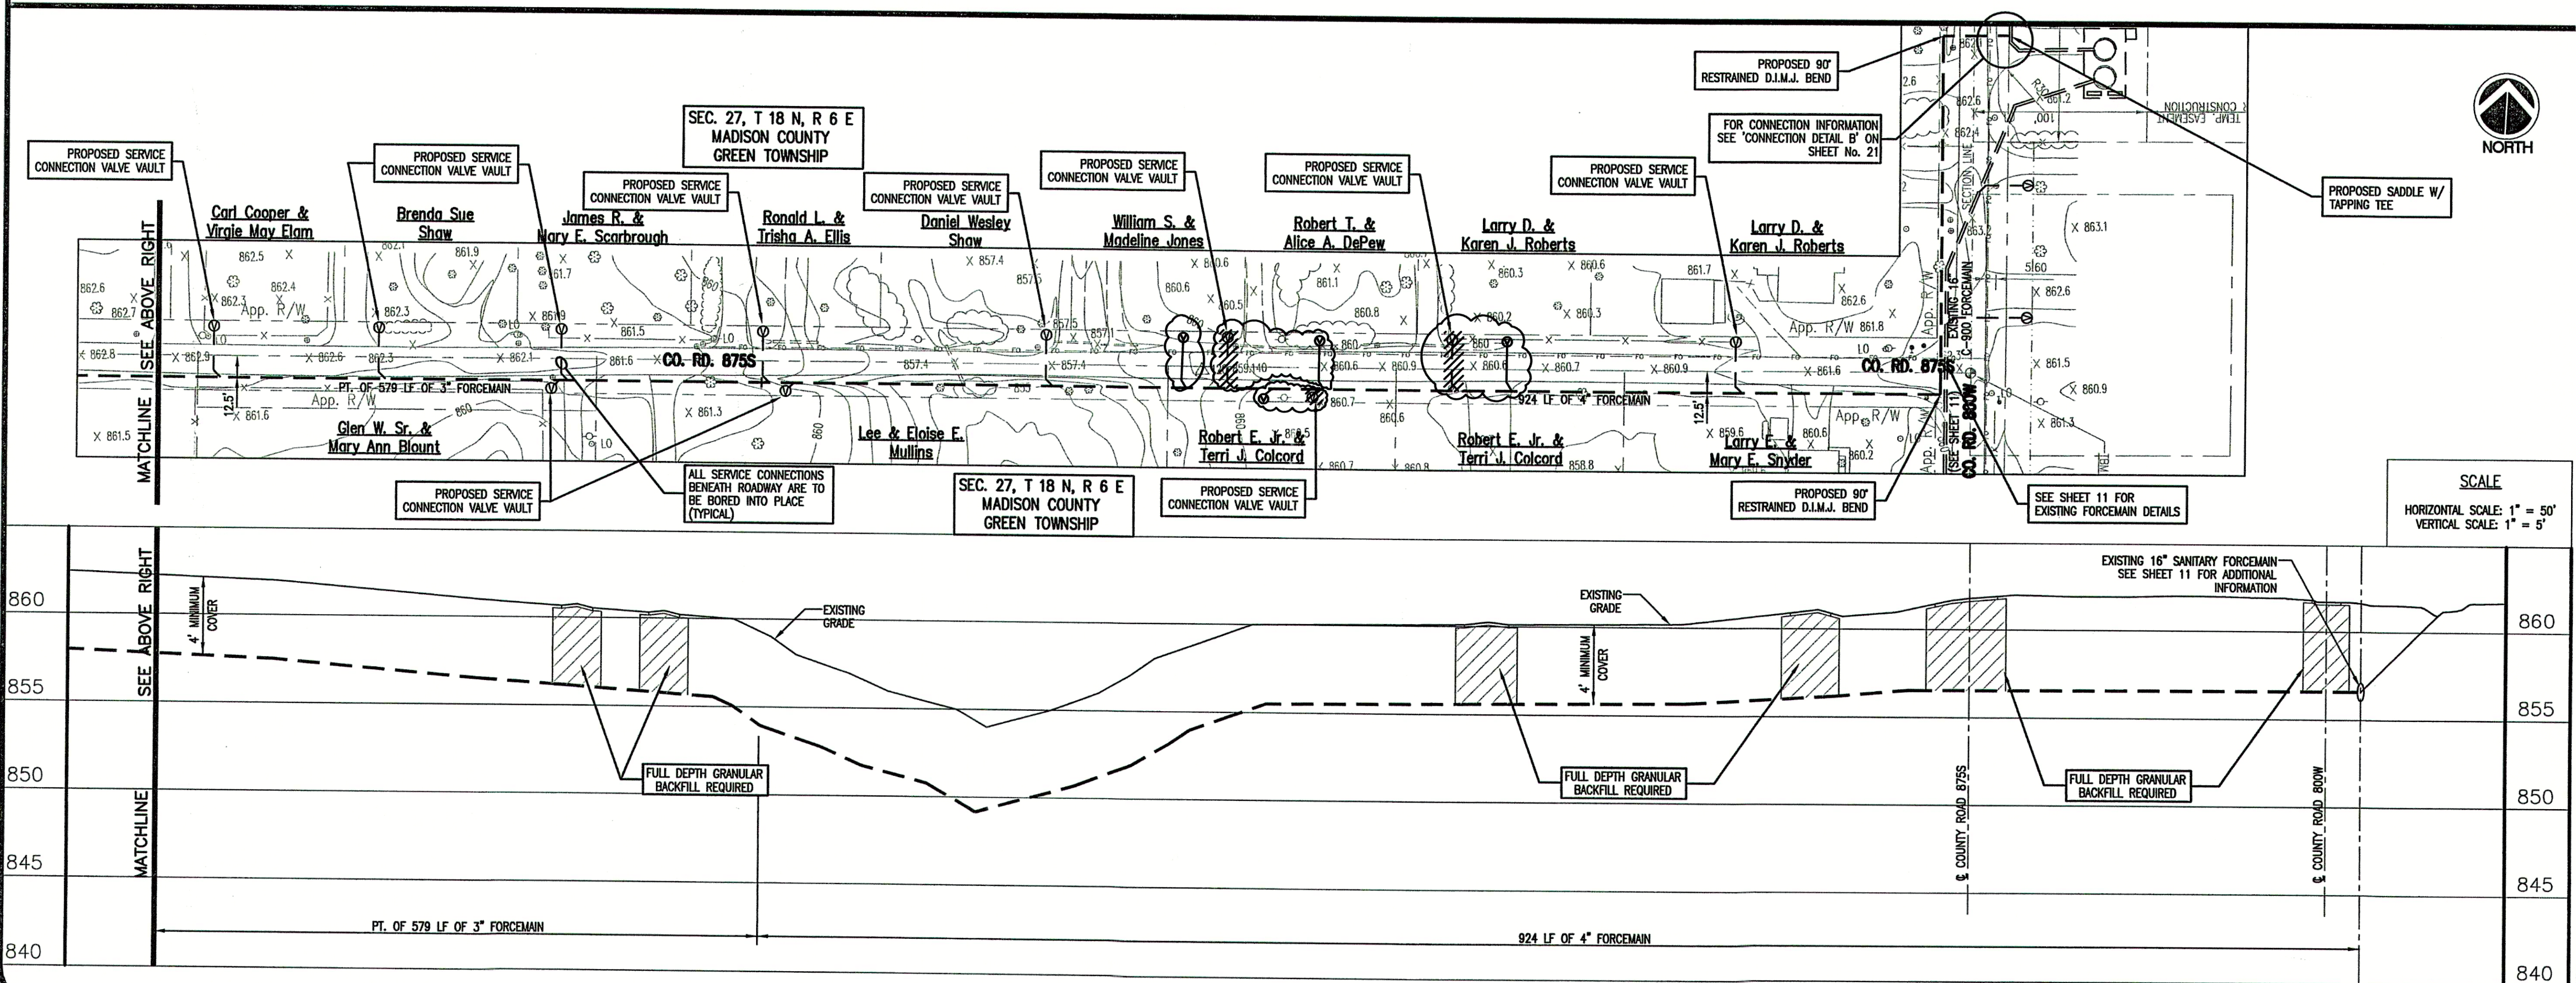


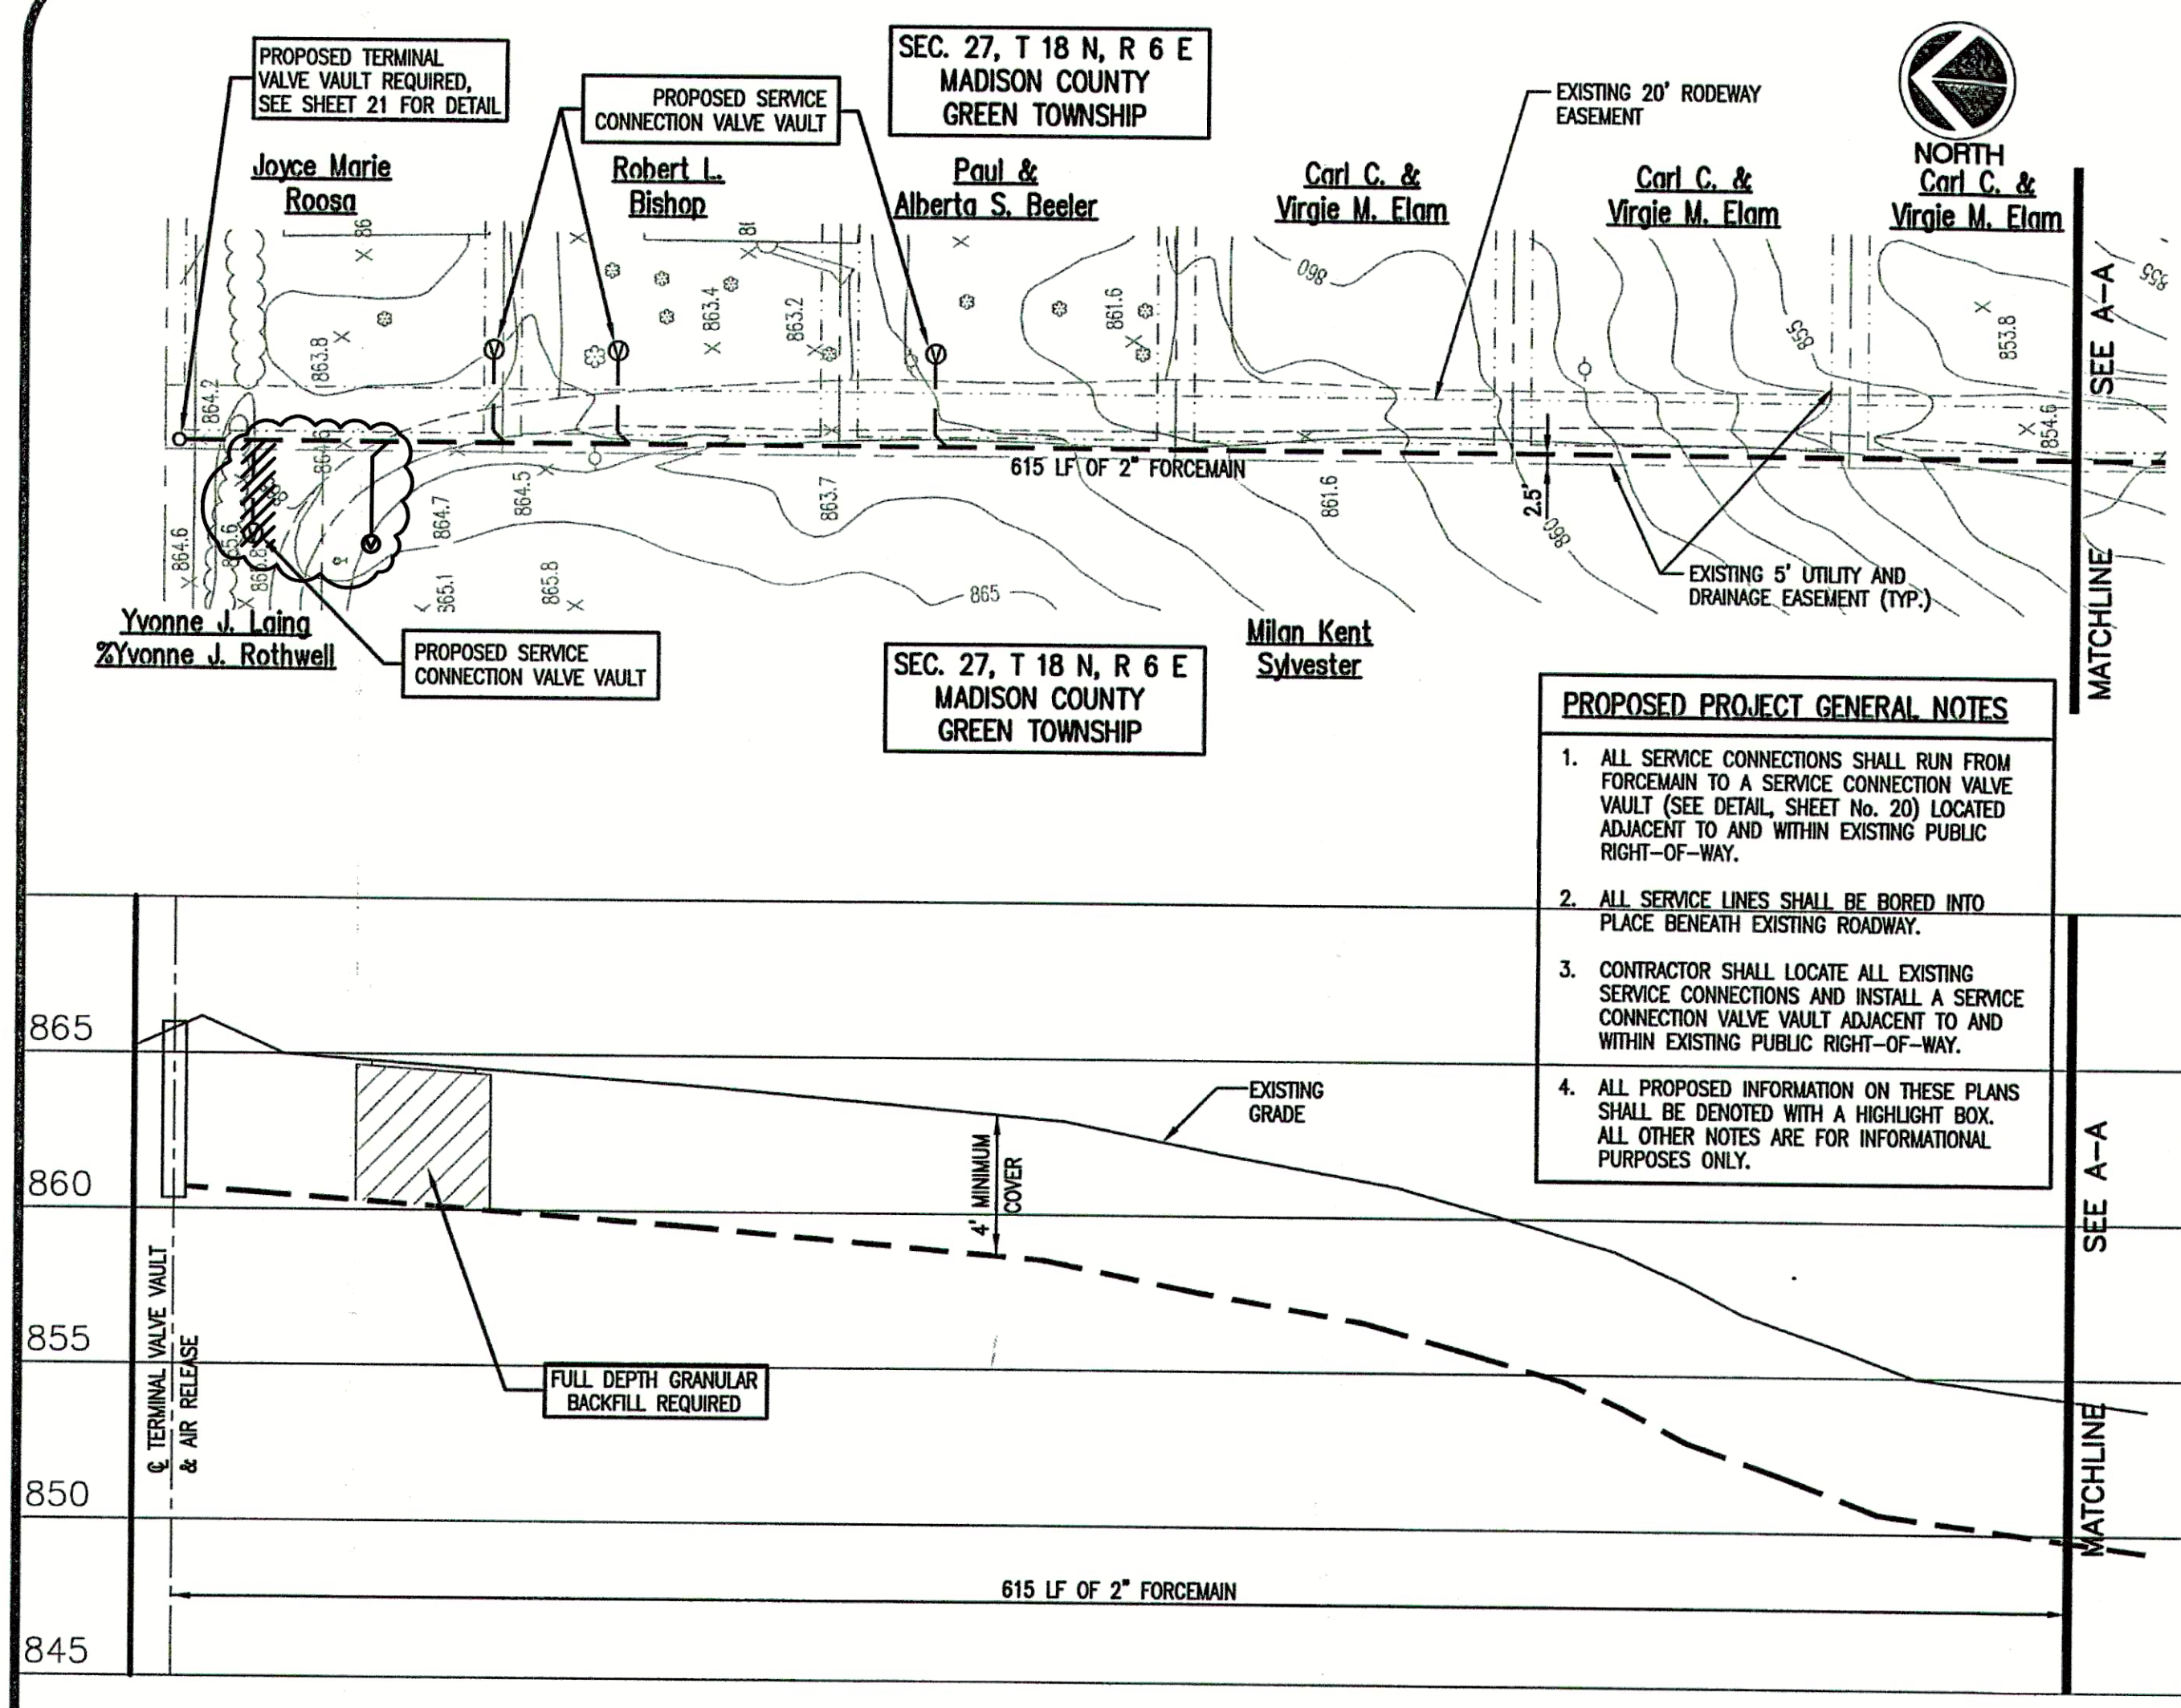

CONSULTANT:

REVISIONS:

DATE	DESCRIPTION	BY
12-8-04	REVISED PER F.C.R.W.D.	BKY
12-21-04	MISC. REVISIONS	BKY
5-18-06	RECORD DRAWINGS	CJF

APPROVED BY:




RECORD DRAWING

This drawing has been revised from the original contract drawings to show minor / major changes made during construction. This drawing is not warranted to be complete and accurate in all respects.

GRW Engineers, Inc.

Date: 5-18-06 By: CJF

THIS DRAWING AND THE IDEAS, DESIGNS AND CONCEPTS CONTAINED HEREIN ARE THE EXCLUSIVE INTELLECTUAL PROPERTY OF TRIAD ASSOCIATES, INC., AND ARE NOT TO BE USED OR REPRODUCED, IN WHOLE OR IN PART, WITHOUT THE WRITTEN CONSENT OF TRIAD ASSOCIATES, INC.

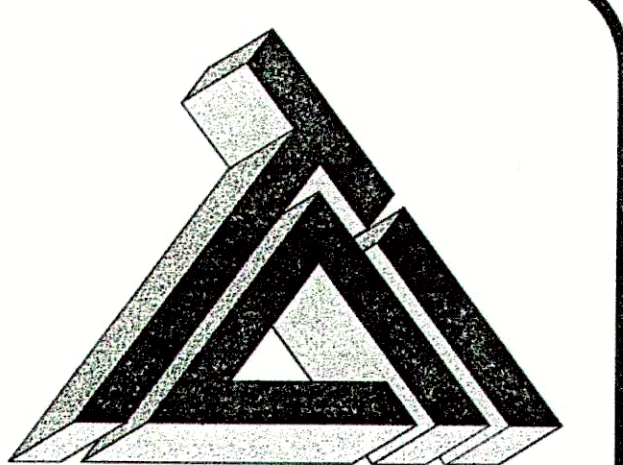

TRIAD ASSOCIATES INC.
5835 LAWTON LOOP EAST DRIVE
INDIANAPOLIS, INDIANA 46216
PHONE: 317-377-5230 FAX: 317-377-5241

DESIGNED FOR:

**FALL CREEK REGIONAL WASTE DISTRICT
SANITARY SEWER ADDITIONAL
CONNECTIONS AND SERVICE CONNECTIONS**

SHEET TITLE:
PROPOSED PLAN AND PROFILE
AND SERVICE CONNECTIONS

JOB NUMBER: 200402E	CHECKED BY: J.W.F.
SCALE: AS NOTED	PLOT DATE: 12/21/04
PLOT SCALE: 1" = 50'	DATE: NOVEMBER 2004
DRAWN BY: JEC	DESIGNED BY: Michael P. Hunter, P.E.
DRAWING NAME: 200402E-C17	

SHEET NO.

17
OF 21