
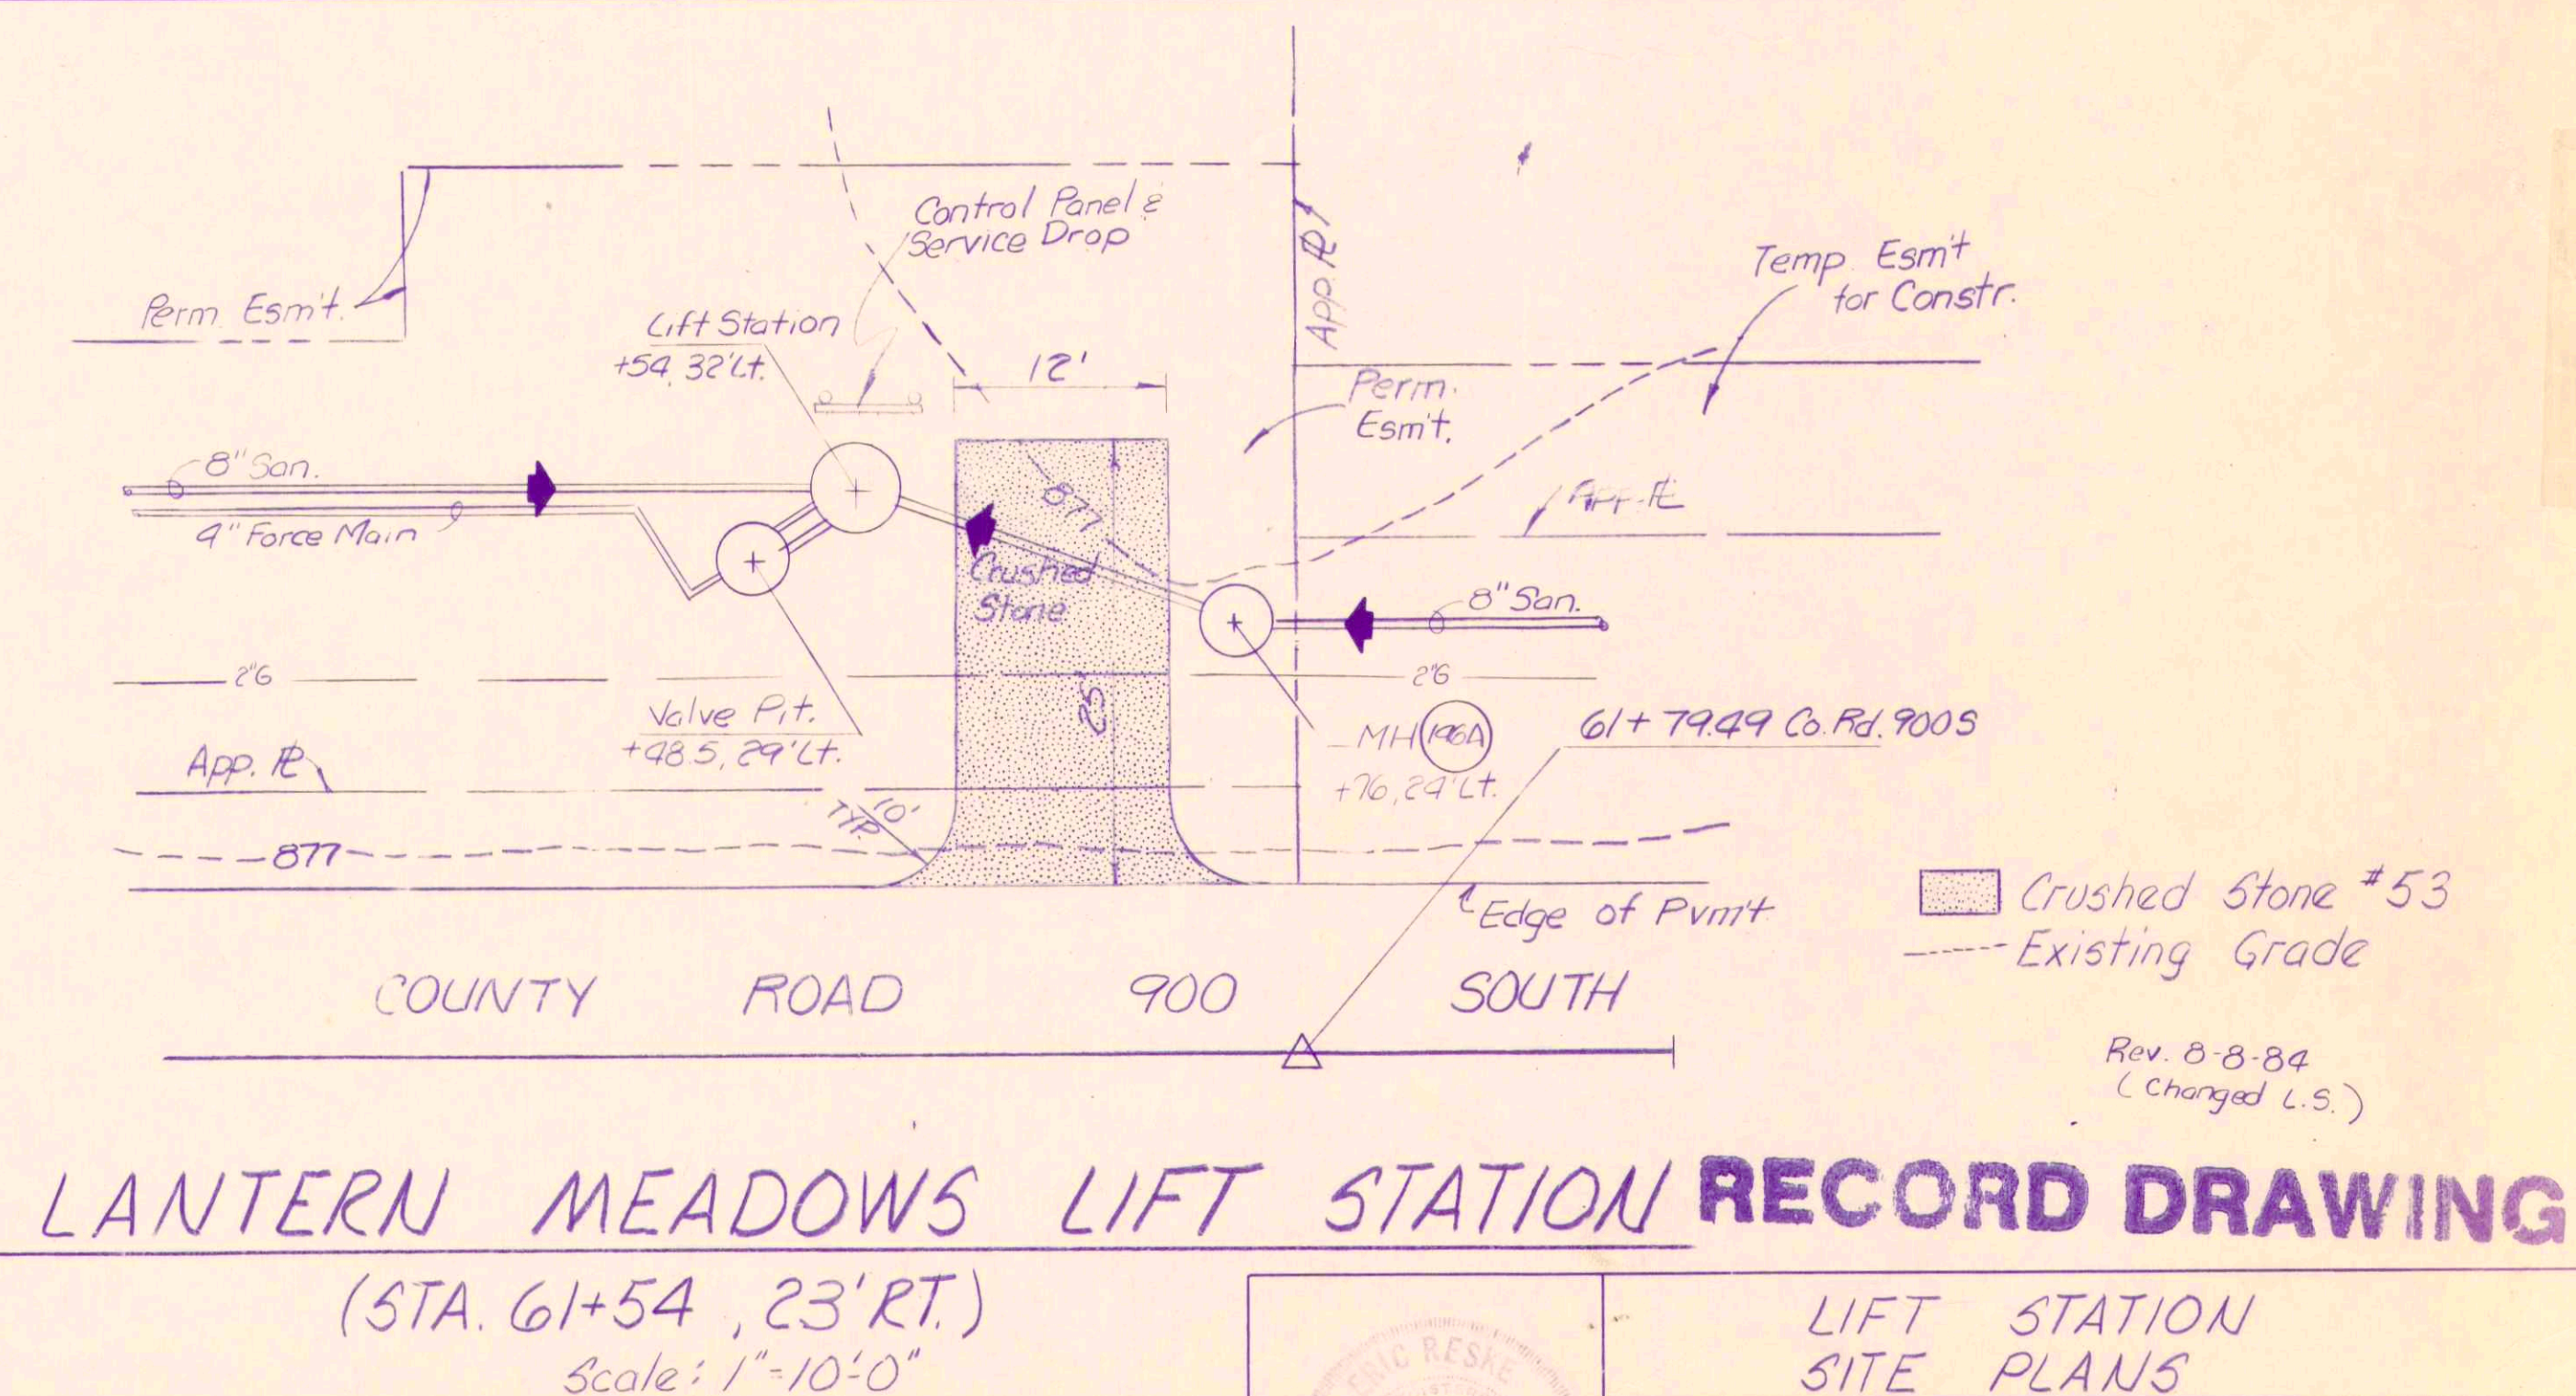
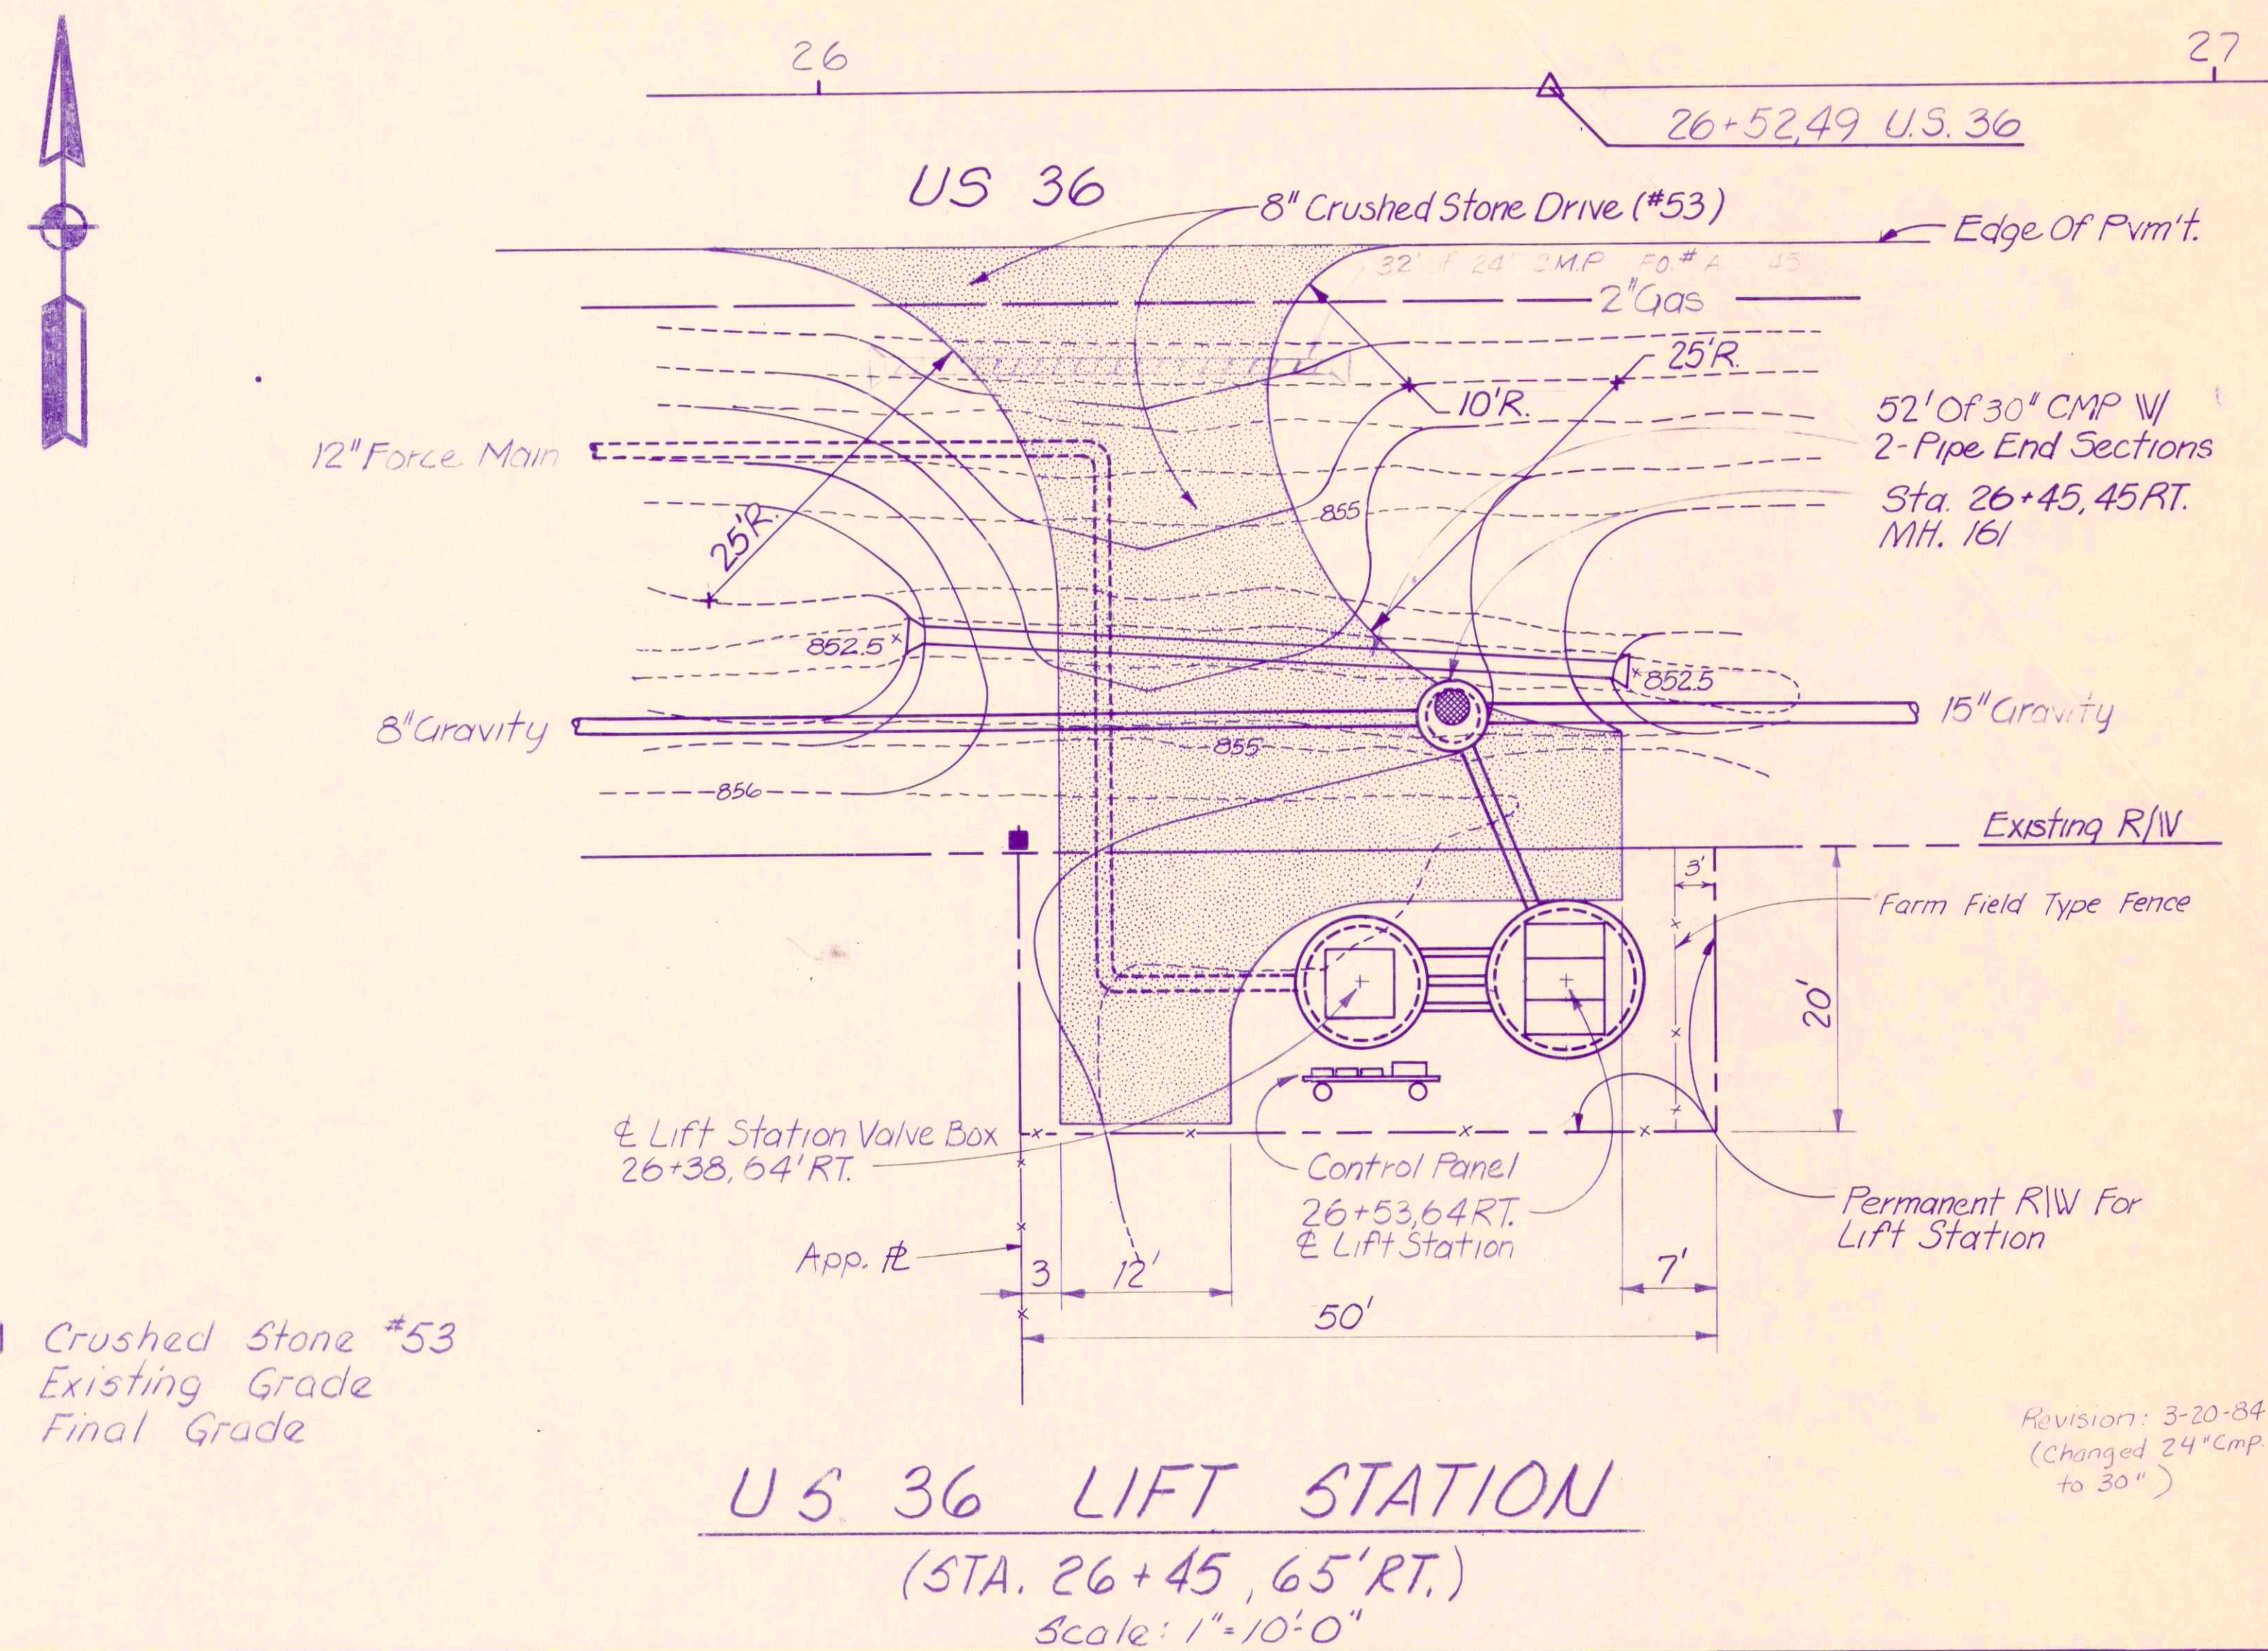
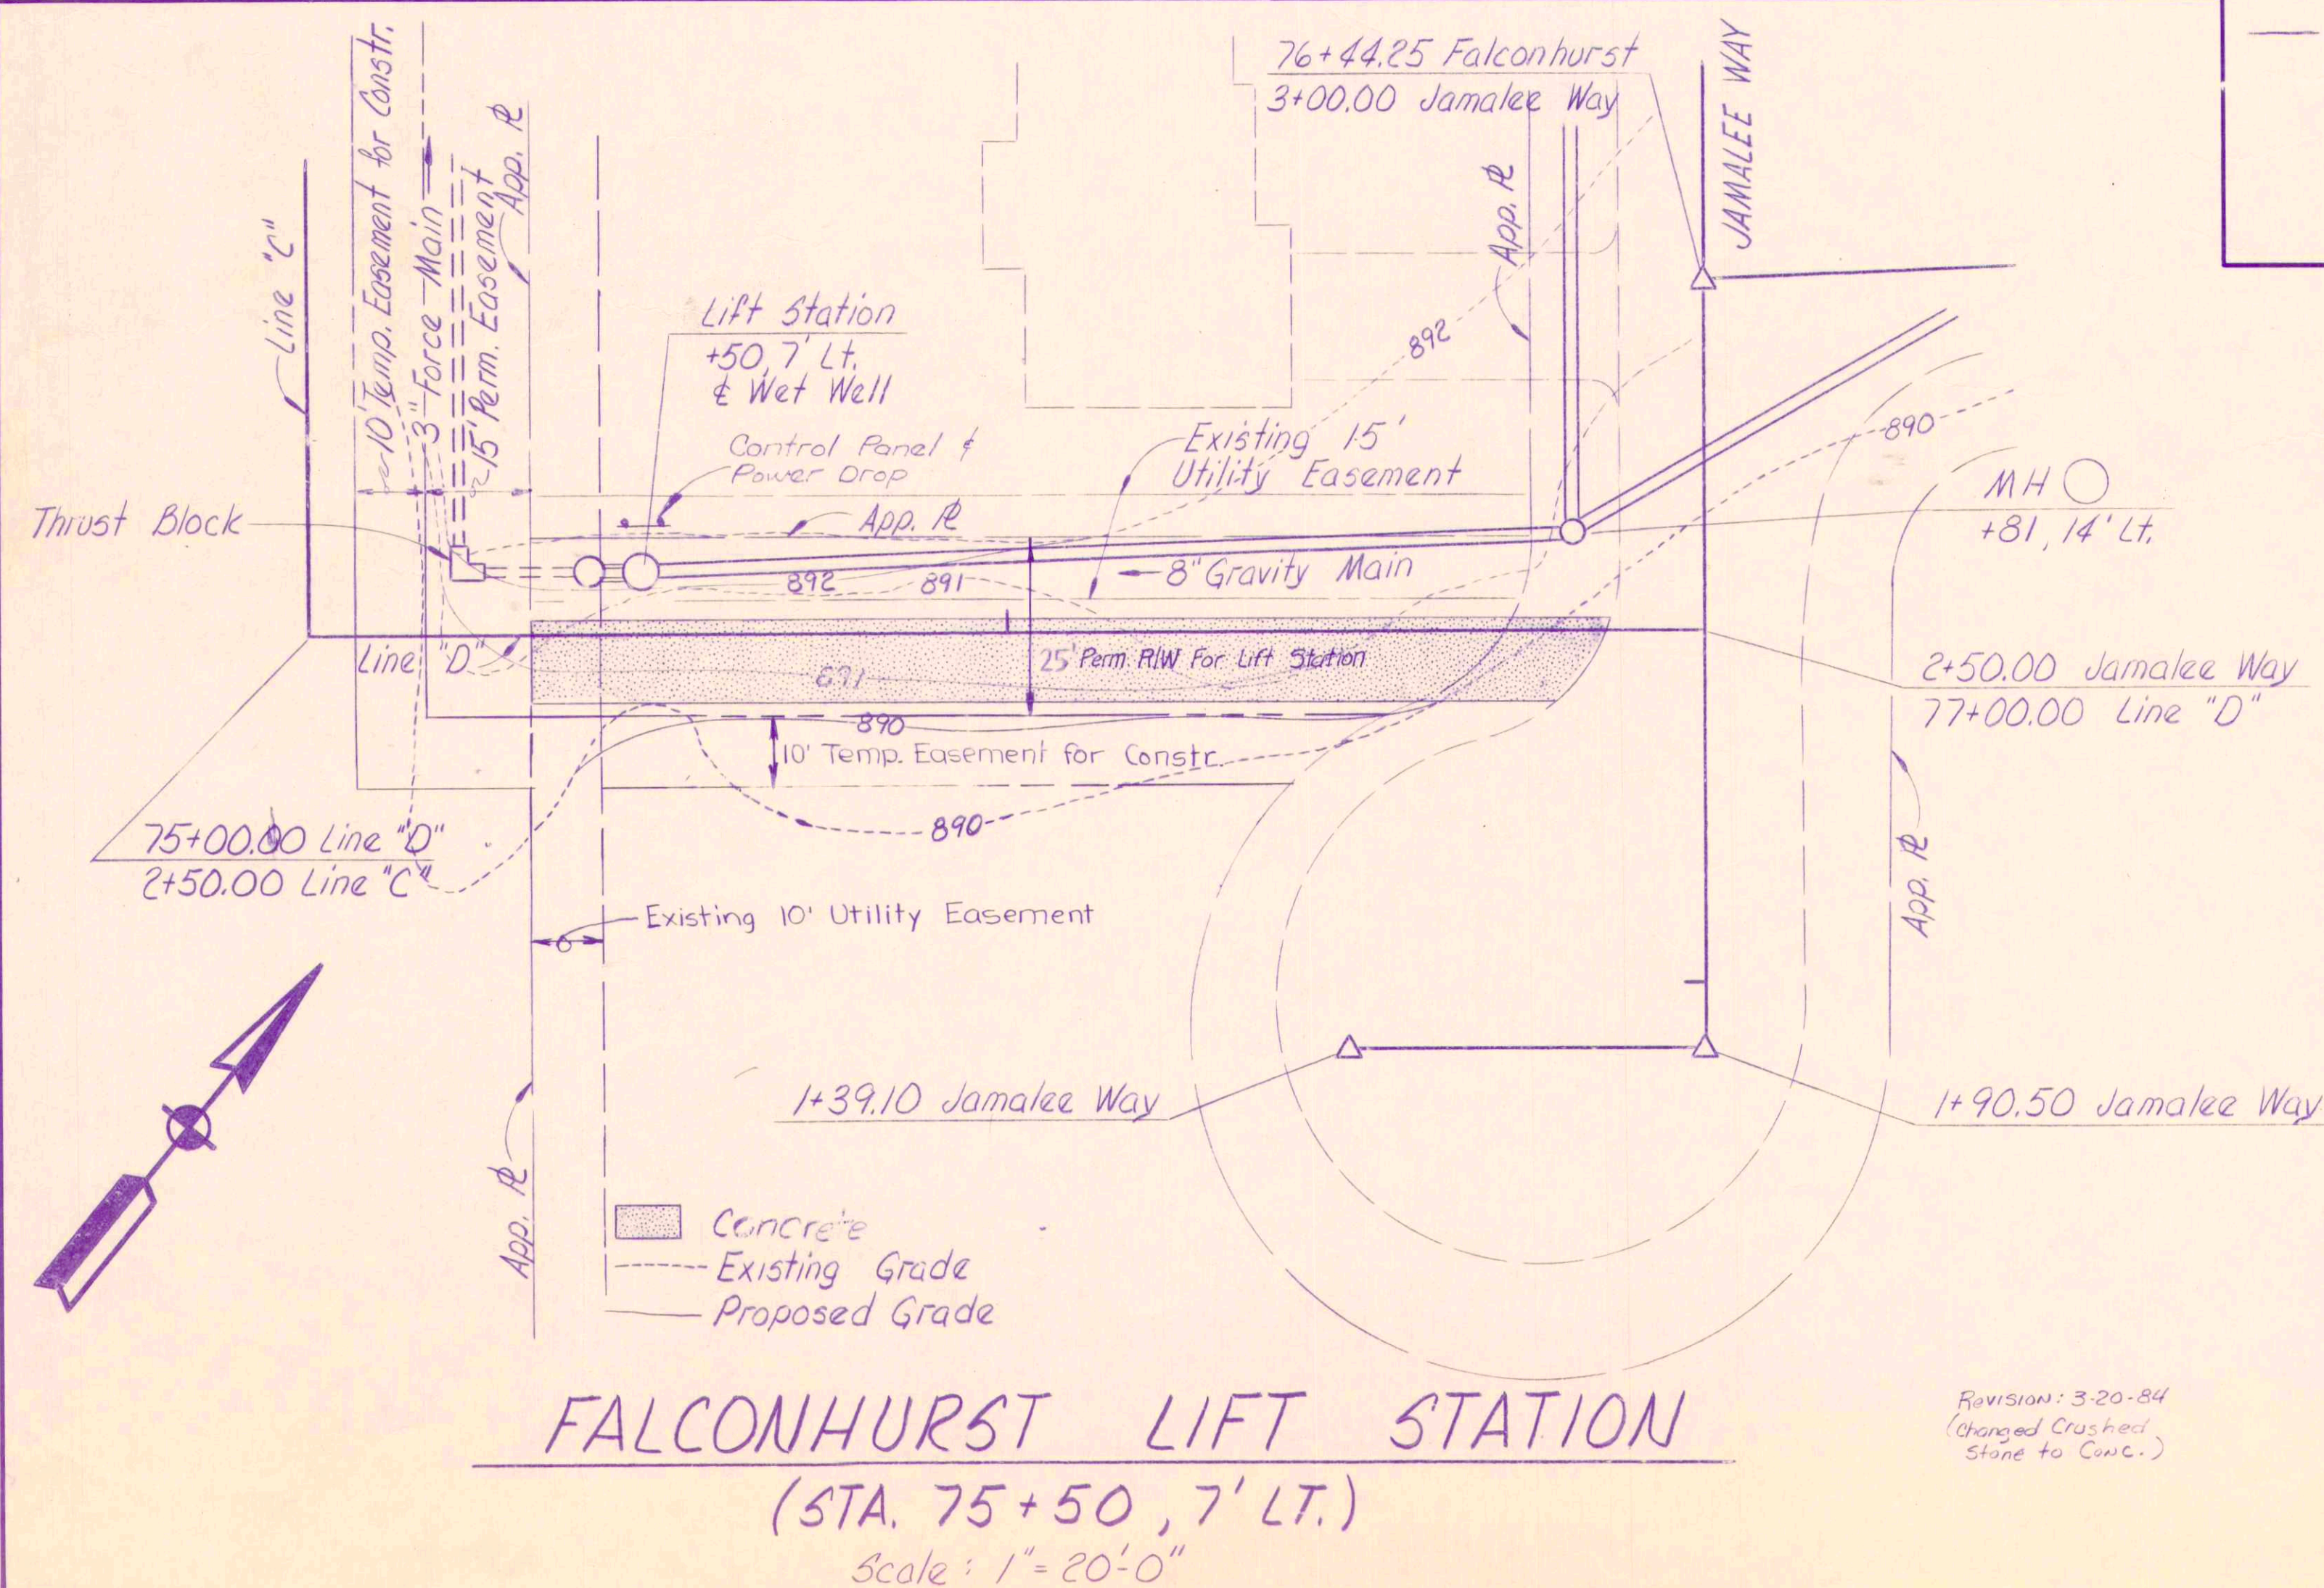


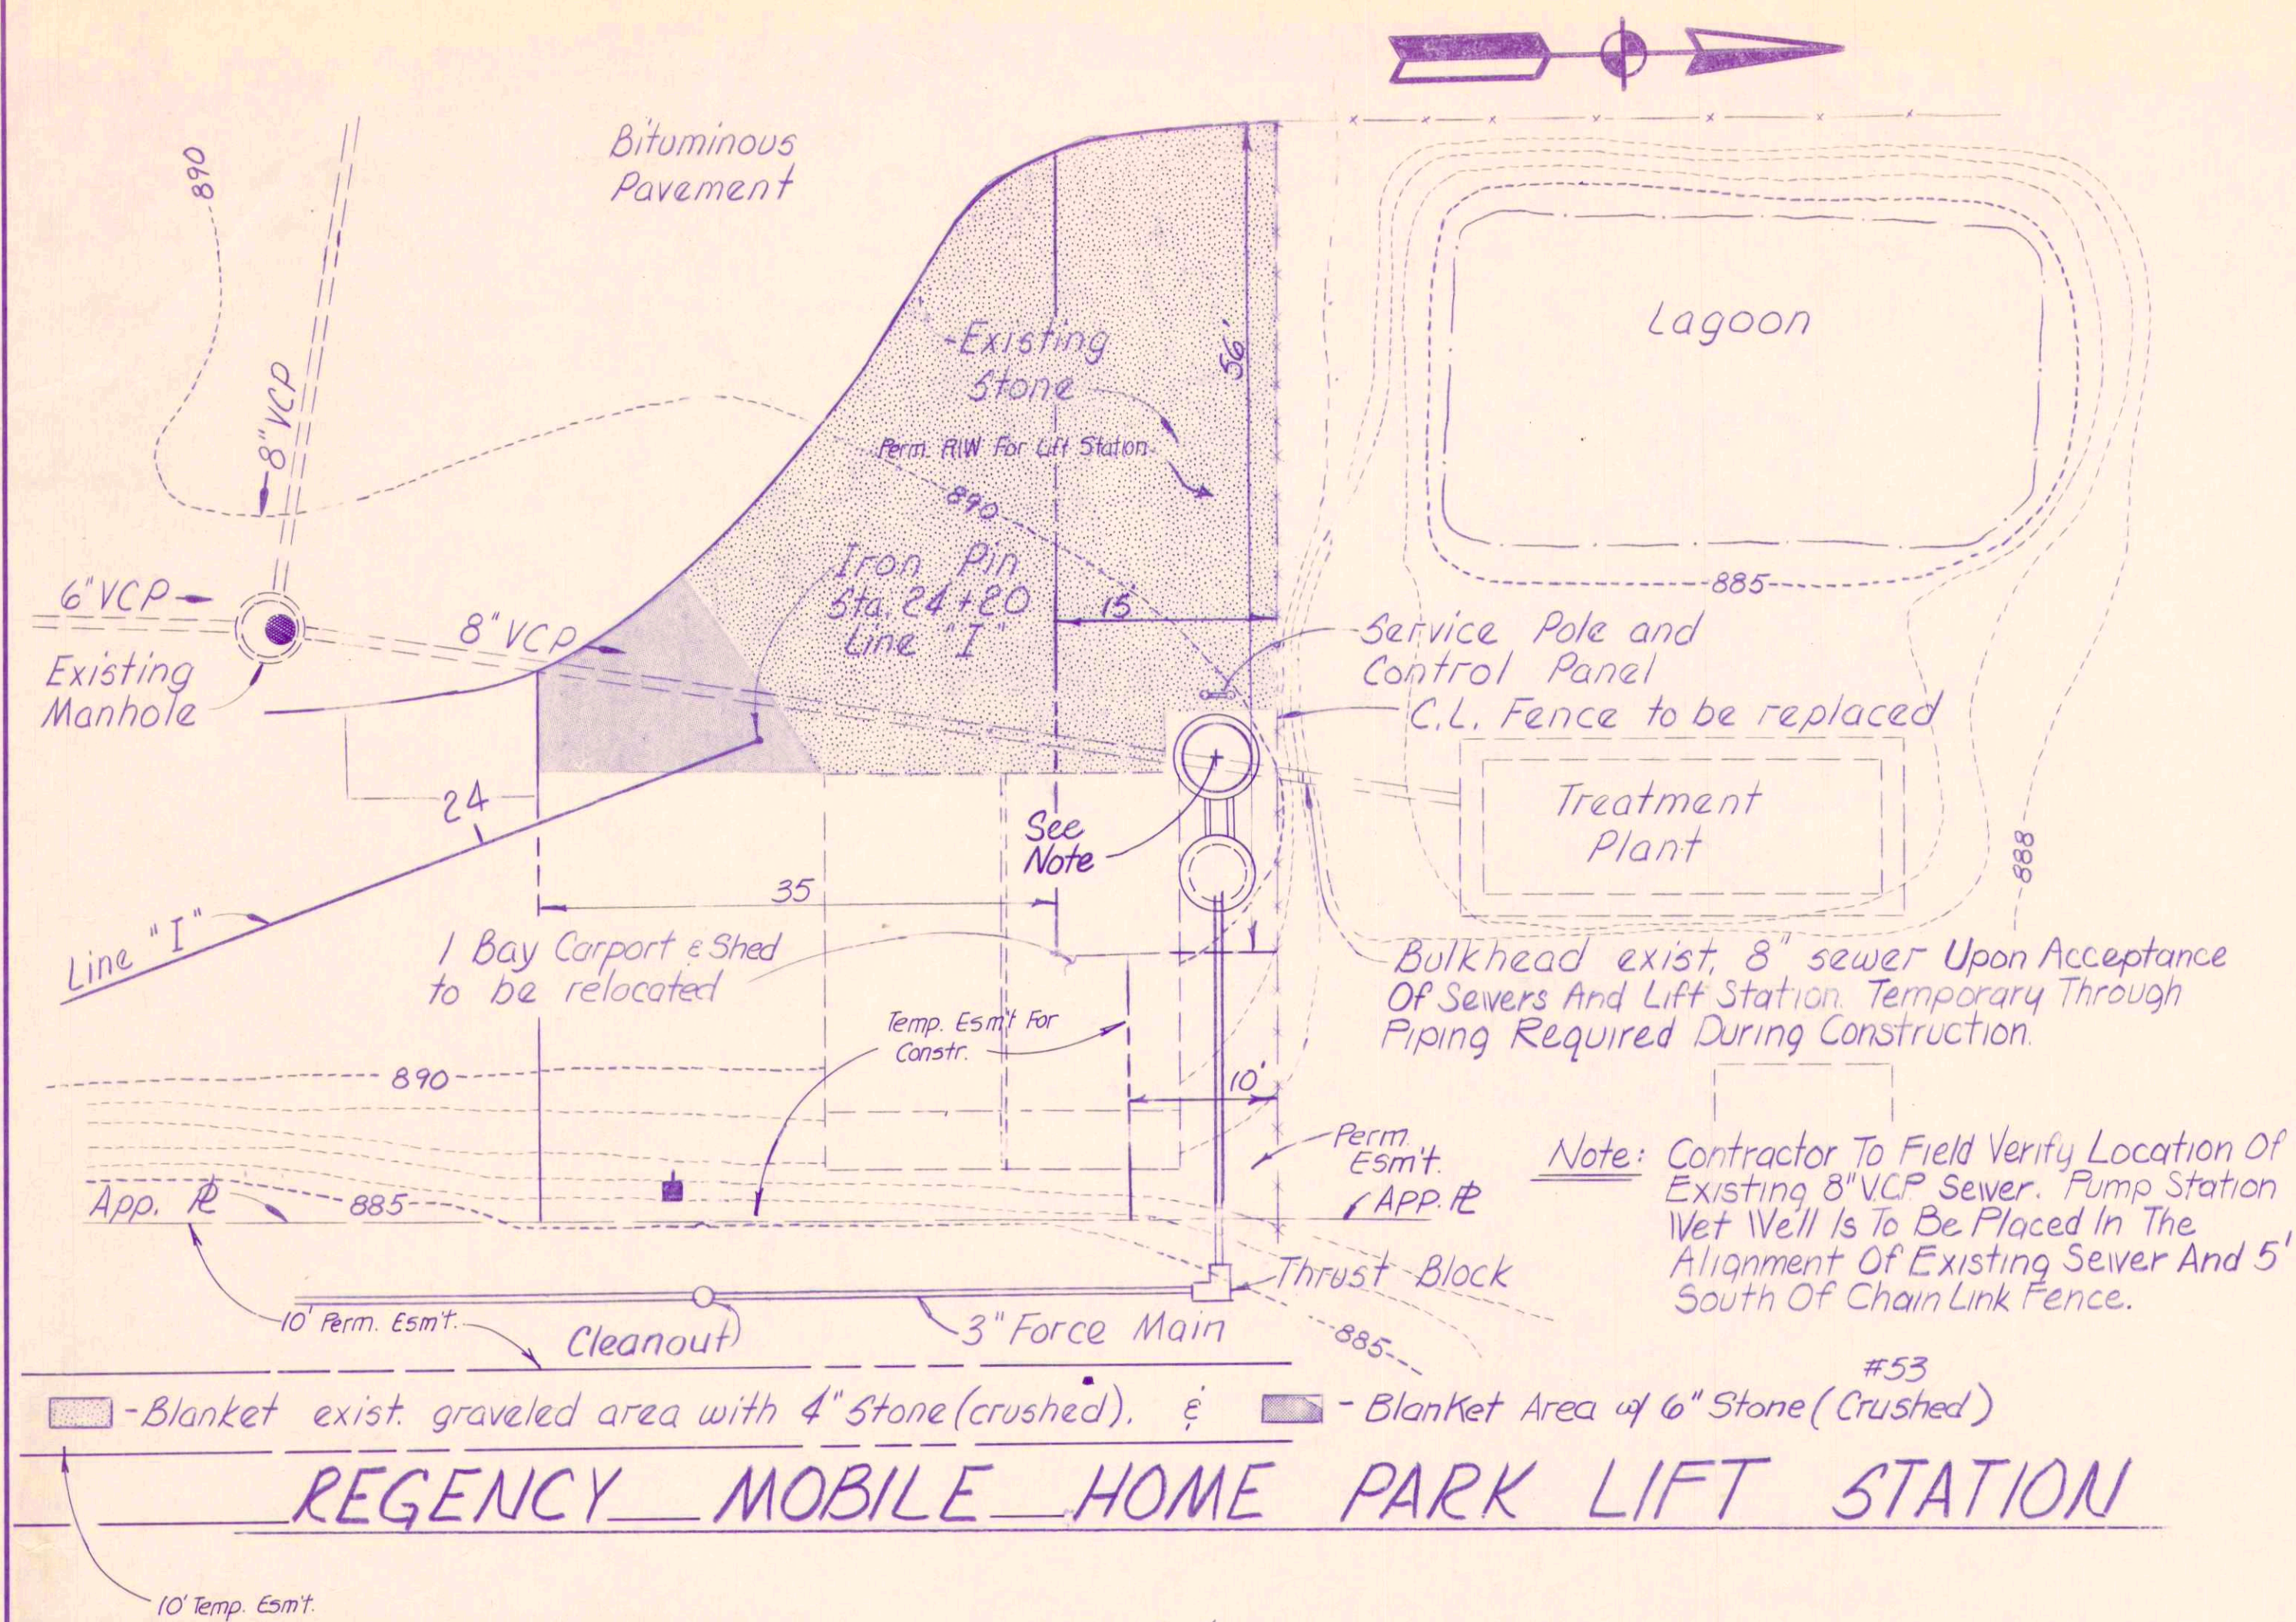

<i>LIFT STATION SITE PLANS</i>		Sheet
Scale: <i>As Noted</i>	BEAM, LONGEST & NEFF Consulting Engineers 8136 Castleton Road Indianapolis, In. 46250	78
Drawn By: <i>Charlie</i>		
Designed By:		
Certified By:		