



SUBMERSIBLE LEVEL SENSOR - STILLING
TUBE DETAIL, TYPICAL

SCALE: NONE

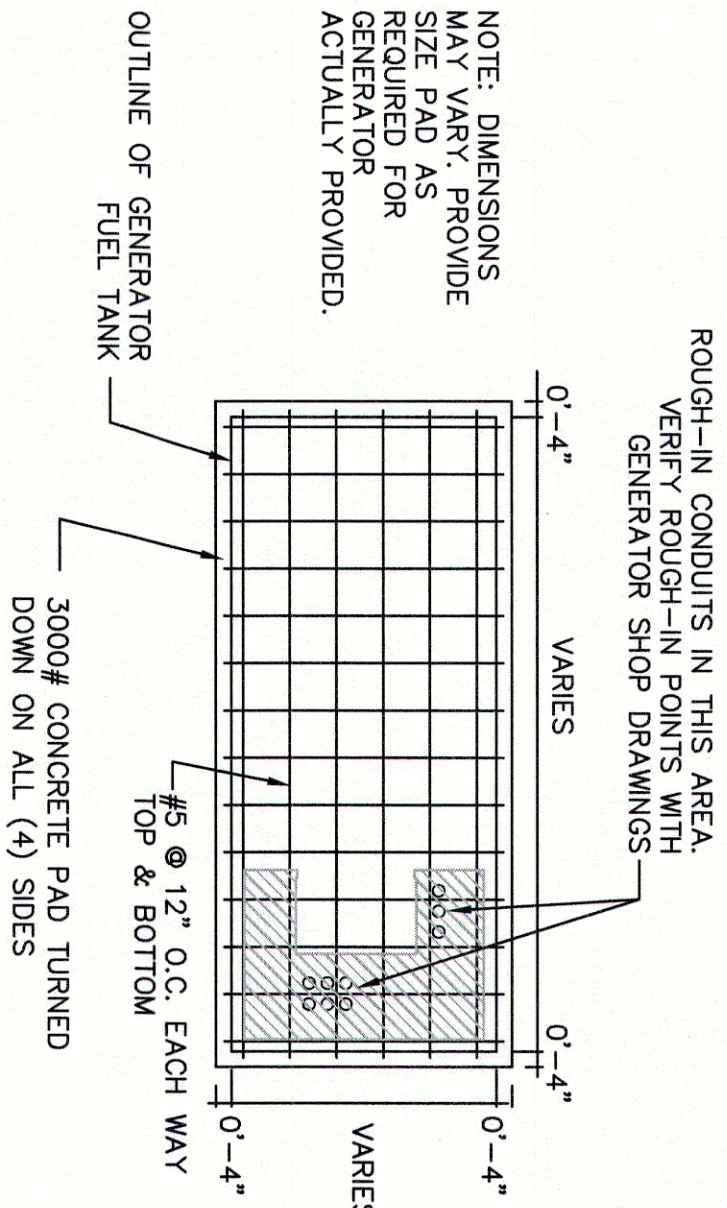


A: GENERATOR PAD PLAN VIEW

SCALE: NONE

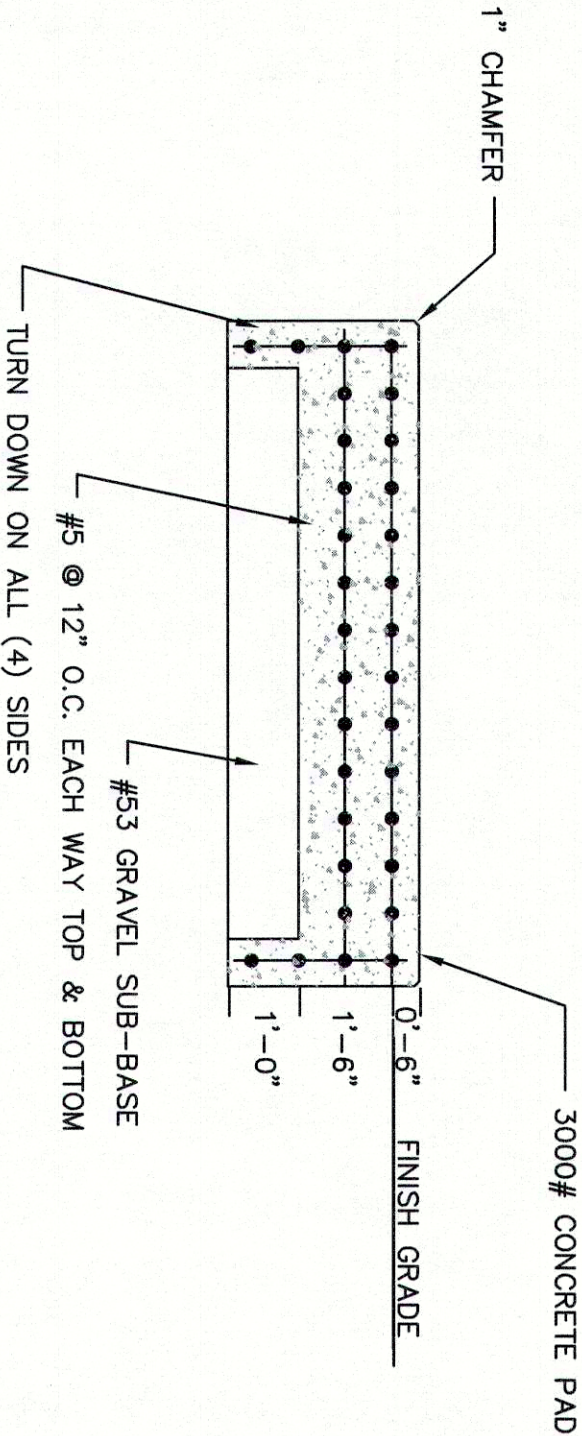

B: GENERATOR PAD SECTION VIEW

SCALE: NONE

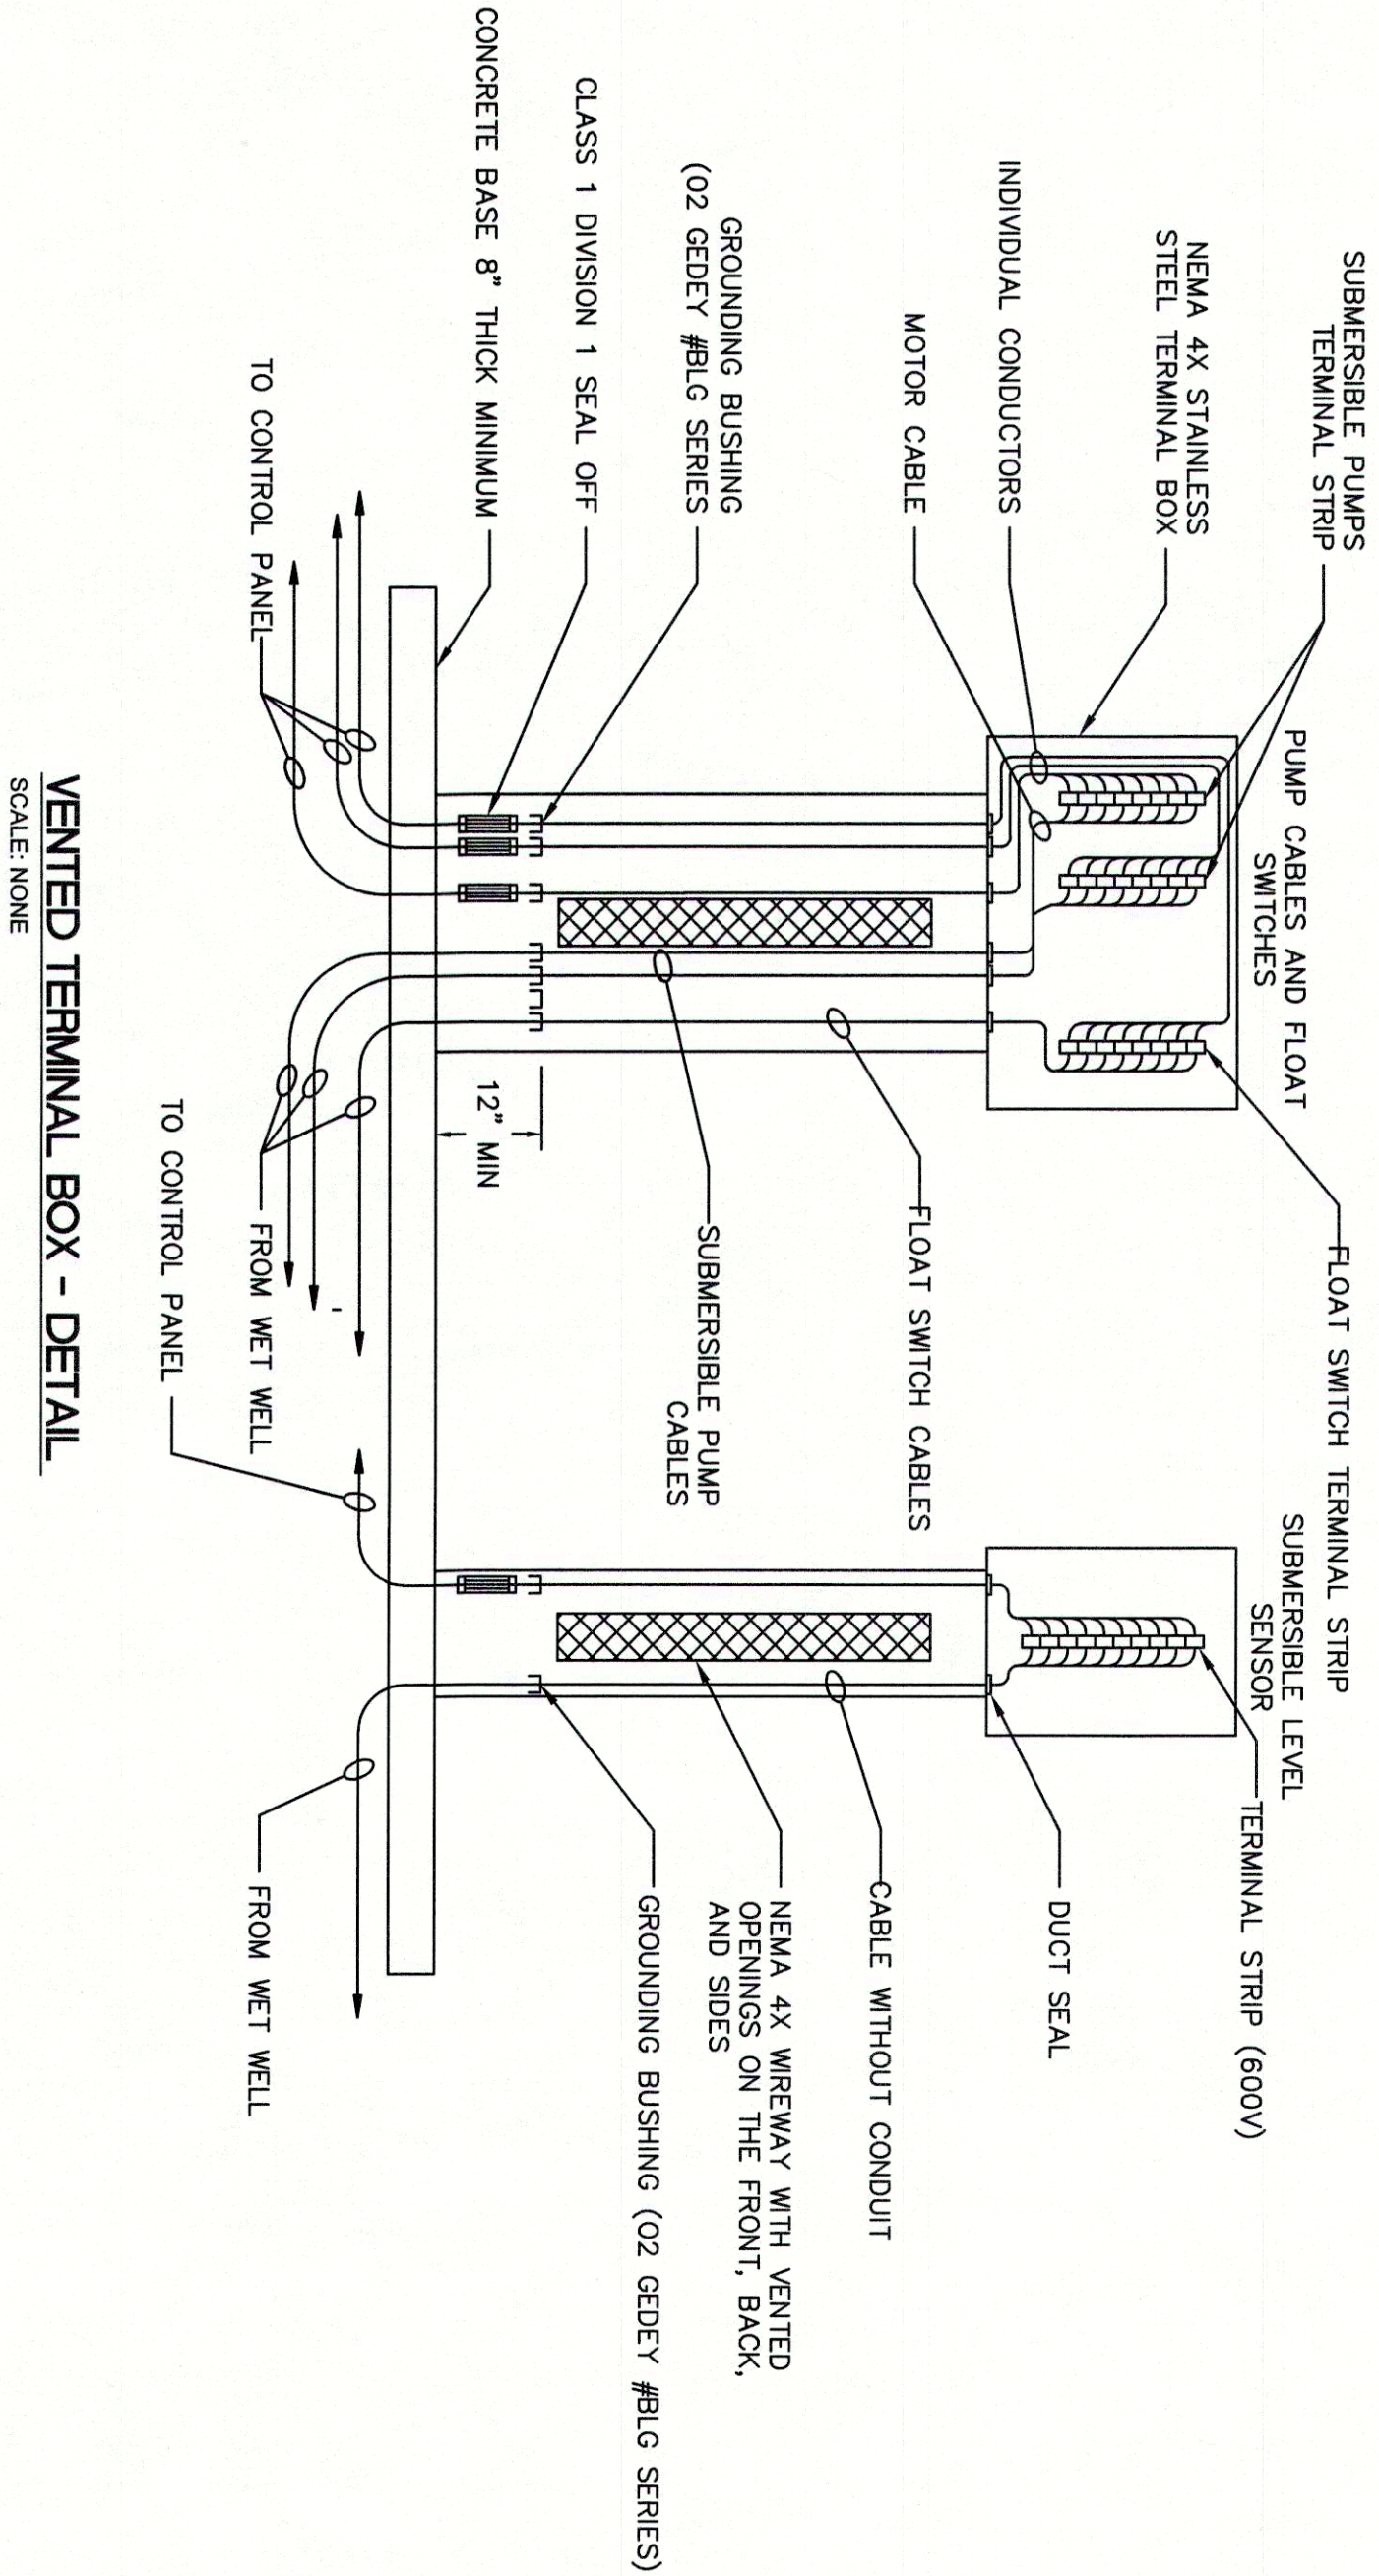

VENTED TERMINAL BOX - DETAIL

SCALE: NONE

REVISIONS		
DATE	DESCRIPTION	BY
01/16/19	REV. PER FORWD & IDEM COMMENTS	JEFF



SIMS-DURKIN ASSOCIATES
ENGINEERING COMPANY
1544 COUNTRY CLUB ROAD INDIANAPOLIS, INDIANA 46234
PHONE: (317)258-4935 WEBSITE: WWW.SIMS-DURKIN.COM

SPRINGBROOK PRELIMINARY PLAN
MADISON COUNTY, INDIANA
LIFT STATION
GENERAL ELECTRICAL DETAILS



DRAWN BY	LA. SOL
CHECKED BY	JEFF
DATE	NOVEMBER 30, 2018
SCALE	AS SHOWN
SHEET	JOB NUMBER 2017-271

C5.12
GENERAL ELECTRICAL
DETAILS