
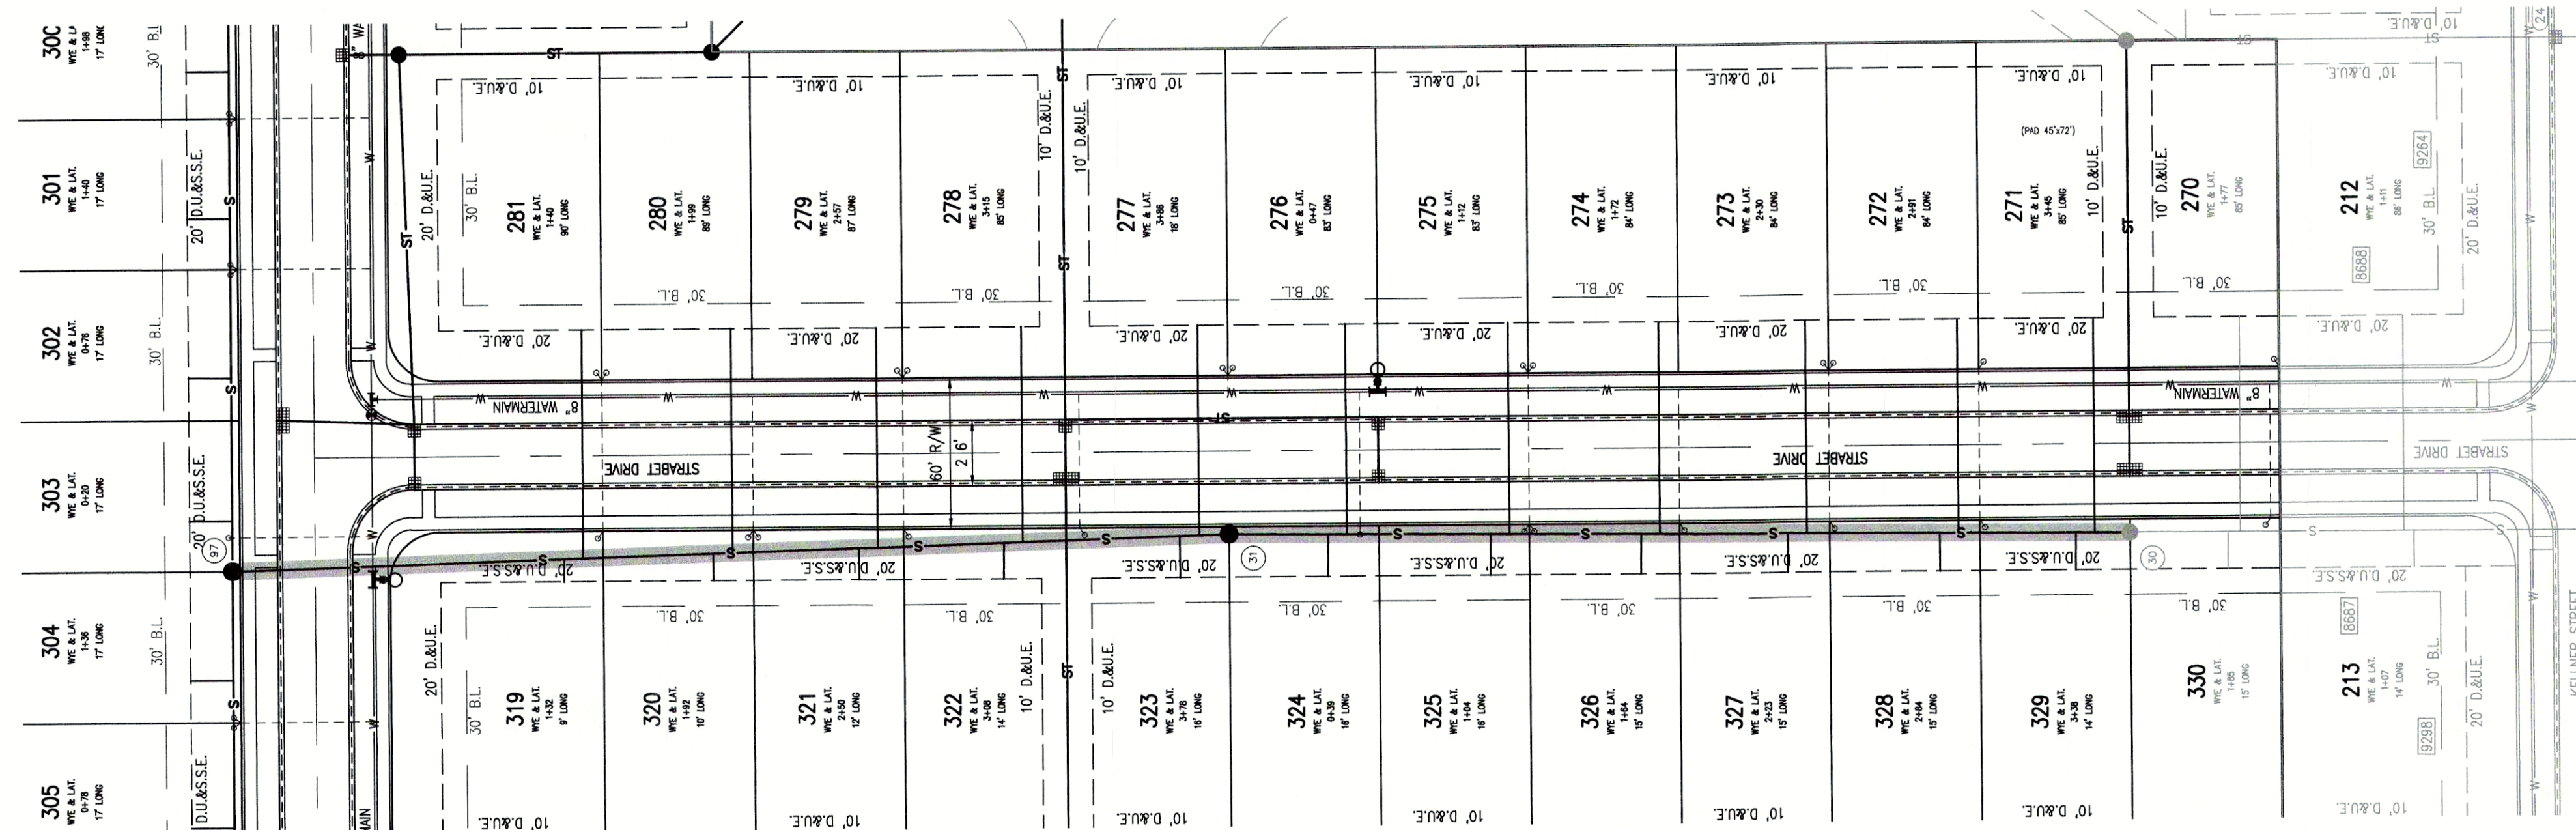



EXISTING

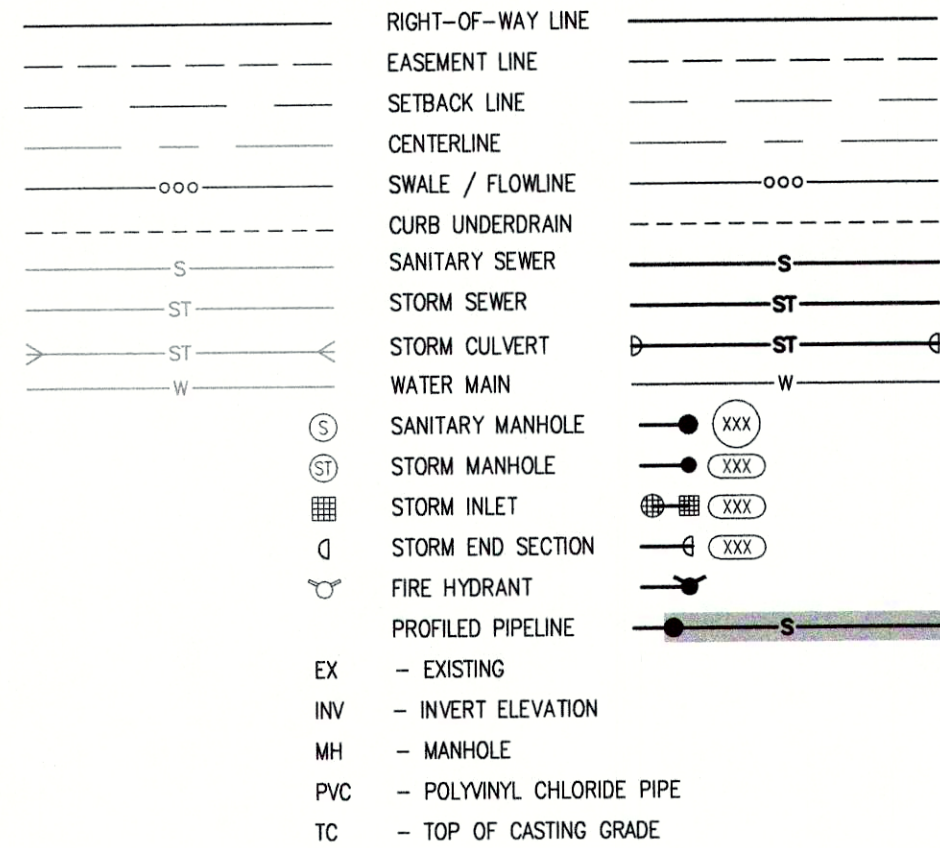

VERTICAL SCALE: 1" = 5'
HORIZONTAL SCALE: 1" = 50'

PVC GRAVITY SEWER PIPE AND FITTINGS
MUST, AT A MINIMUM, BE INSTALLED IN
ACCORDANCE WITH THE DIRECTIONS
CONTAINED IN ASTM D 2321.


NOTE:
GRANULAR BACKFILL IS REQUIRED FOR
SANITARY SEWER MAIN AND LATERAL
TRENCHES IN AND WITHIN 5' OF
EXISTING OR PROPOSED PAVEMENT OR
CURB PER THE FLEXIBLE PIPE BEDDING
DETAIL ON C8.4.

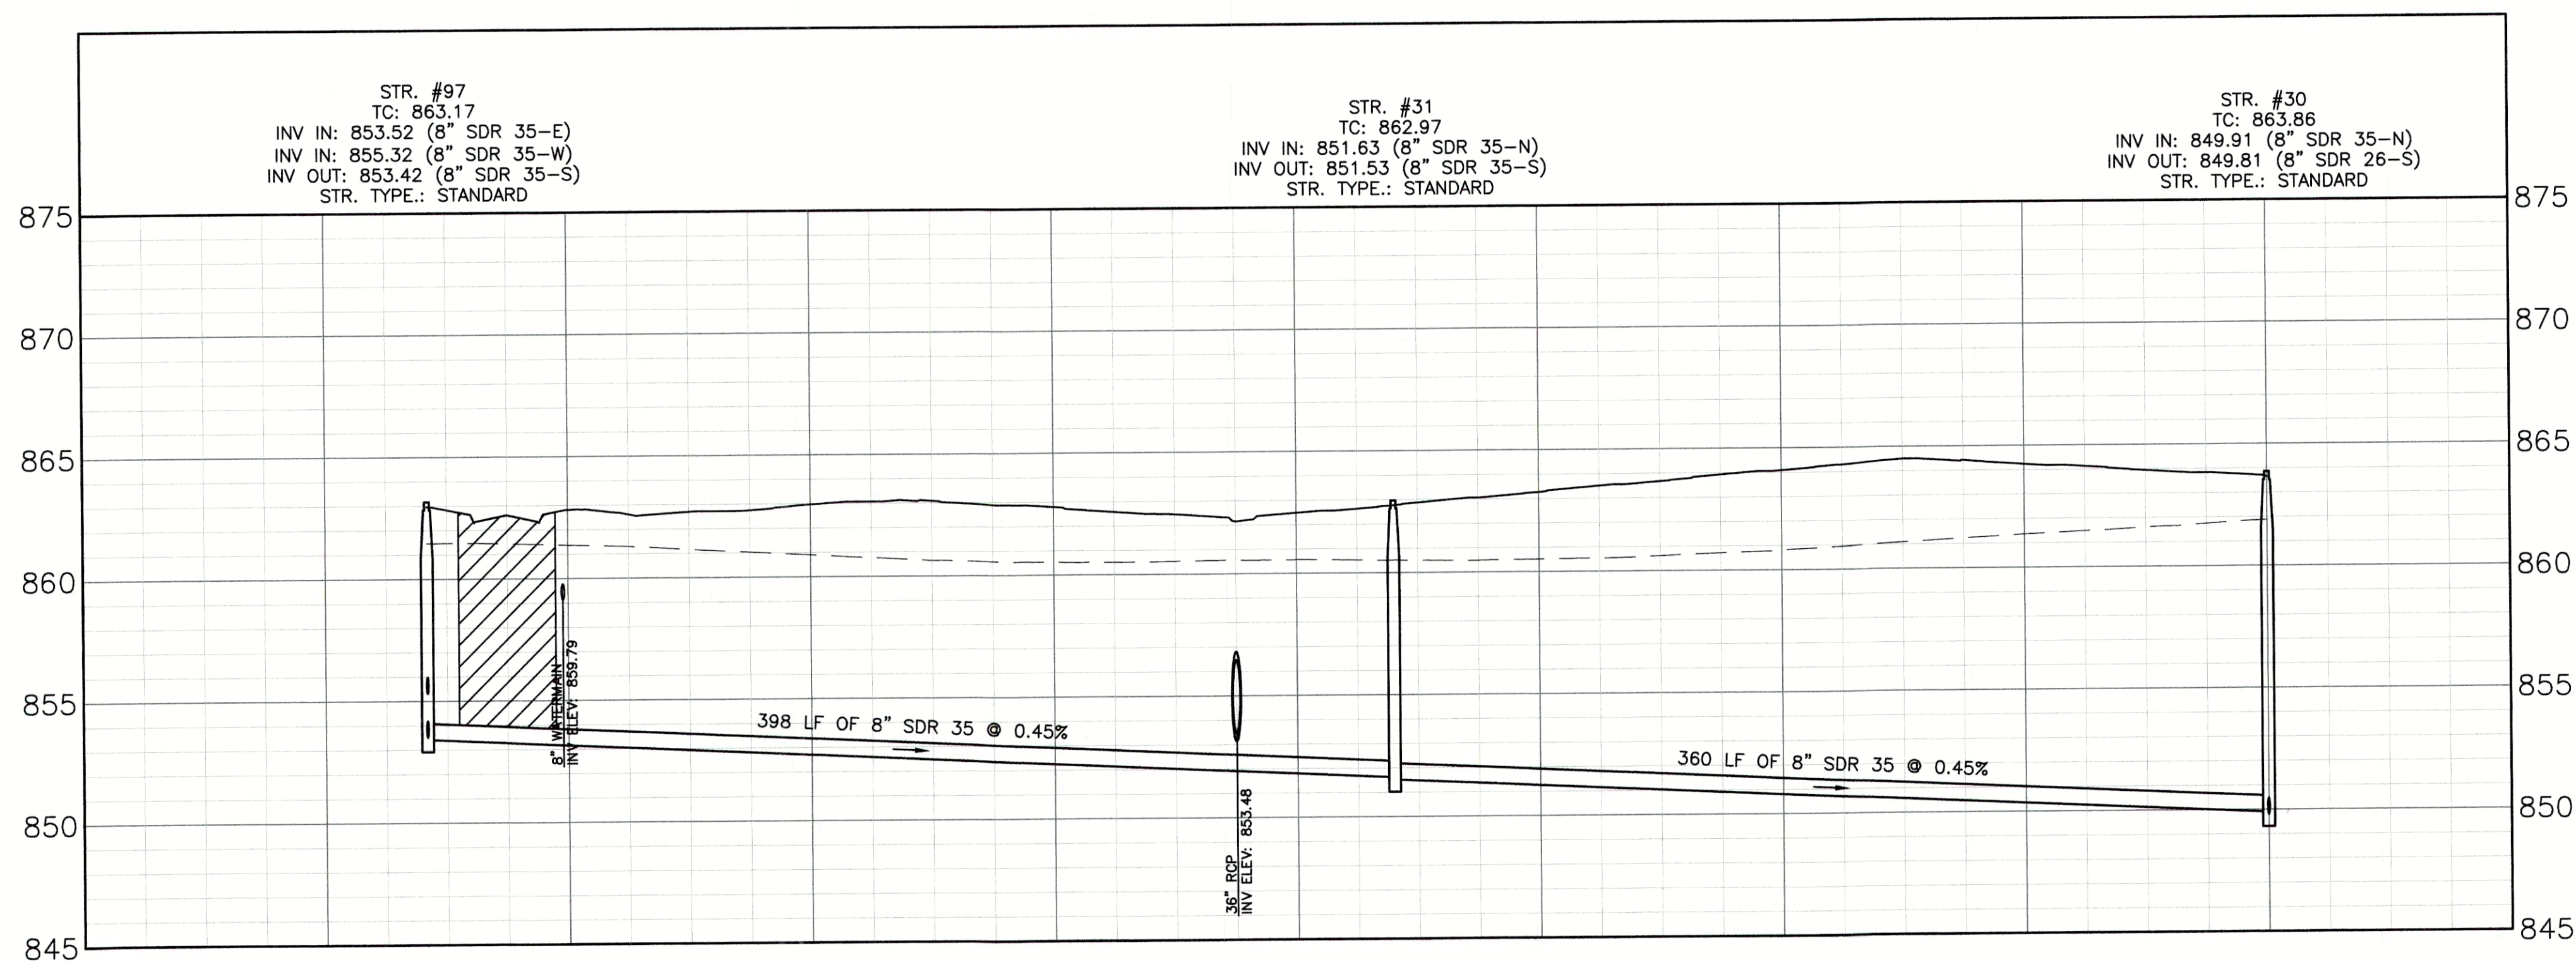

Call 811 or 800-382-5544 Before you Dig!



 GRAPHIC SCALE



(IN FEET)

ORIGINATING BENCHMARK: NGS H 236

ORIGINATING BENCHMARK: NGS H 236
NGS DISK AT SOUTHWEST QUADRANT OF STATE ROAD 13 AND
COUNTY ROAD 900 SOUTH, APPROXIMATELY 30 FEET WEST OF
CENTERLINE STATE ROAD 13 AND 30 FEET SOUTH OF
CENTERLINE COUNTY ROAD 900 SOUTH. ELEVATION PER MADISON
COUNTY STATE PLANE COORDINATE CONTROL NETWORK HELD.
ELEV = 859.96 (NAVD 88)

TBM #1
BENCH SPIKE 1' UP ON WEST SIDE OF POWER POLE #PSI
189/875 +/-100' SOUTH OF ENTRANCE TO COUNTRY LANE
KENNEL, +/-30' EAST OF CL OF SR13
ELEV = 860.60 (NAVD 88)

TBM #2
RR SPIKE 1' UP ON EAST SIDE POWER POLE #064-708 +/-30'
WEST OF CL OF SR13
ELEV = 862.74 (NAVD 88)

TBM #3
SANITARY MANHOLE ON EAST SIDE OF PADDLEBOAT LN.
ELEV = 861.80 (NAVD 88)


TBM #4
SANITARY MANHOLE ON EAST SIDE OF COMET LN.
ELEV = 861.76 (NAVD 88)

TBM #5
BENCH SPIKE 1' UP ON NORTH SIDE OF NINESTAR POLE #12660
ELEV = 862.05 (NAVD 88)

[illegible]

INDIANAPOLIS - TERRE HAUTE
LAFAYETTE - MUNCIE - NEW ALBANY
www.hwcengineering.com

SPRINGBROOK
SECTION 6
SANITARY PLAN AND PROFILES

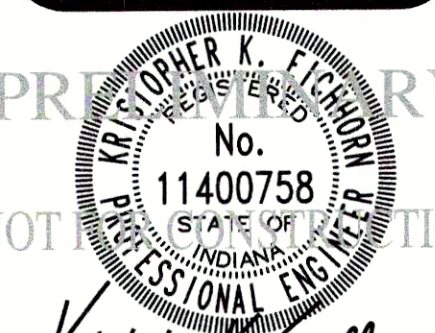

Kristopher K. Eichhorn

DRAWN BY TS/TD/GM/EW	JOB NUMBER 2017-271-F
CHECKED BY KE	
DATE SEPTEMBER 14, 2021	
SCALE AS SHOWN	
SHEET	

C4.2

SANITARY PLAN AND PROFILES