


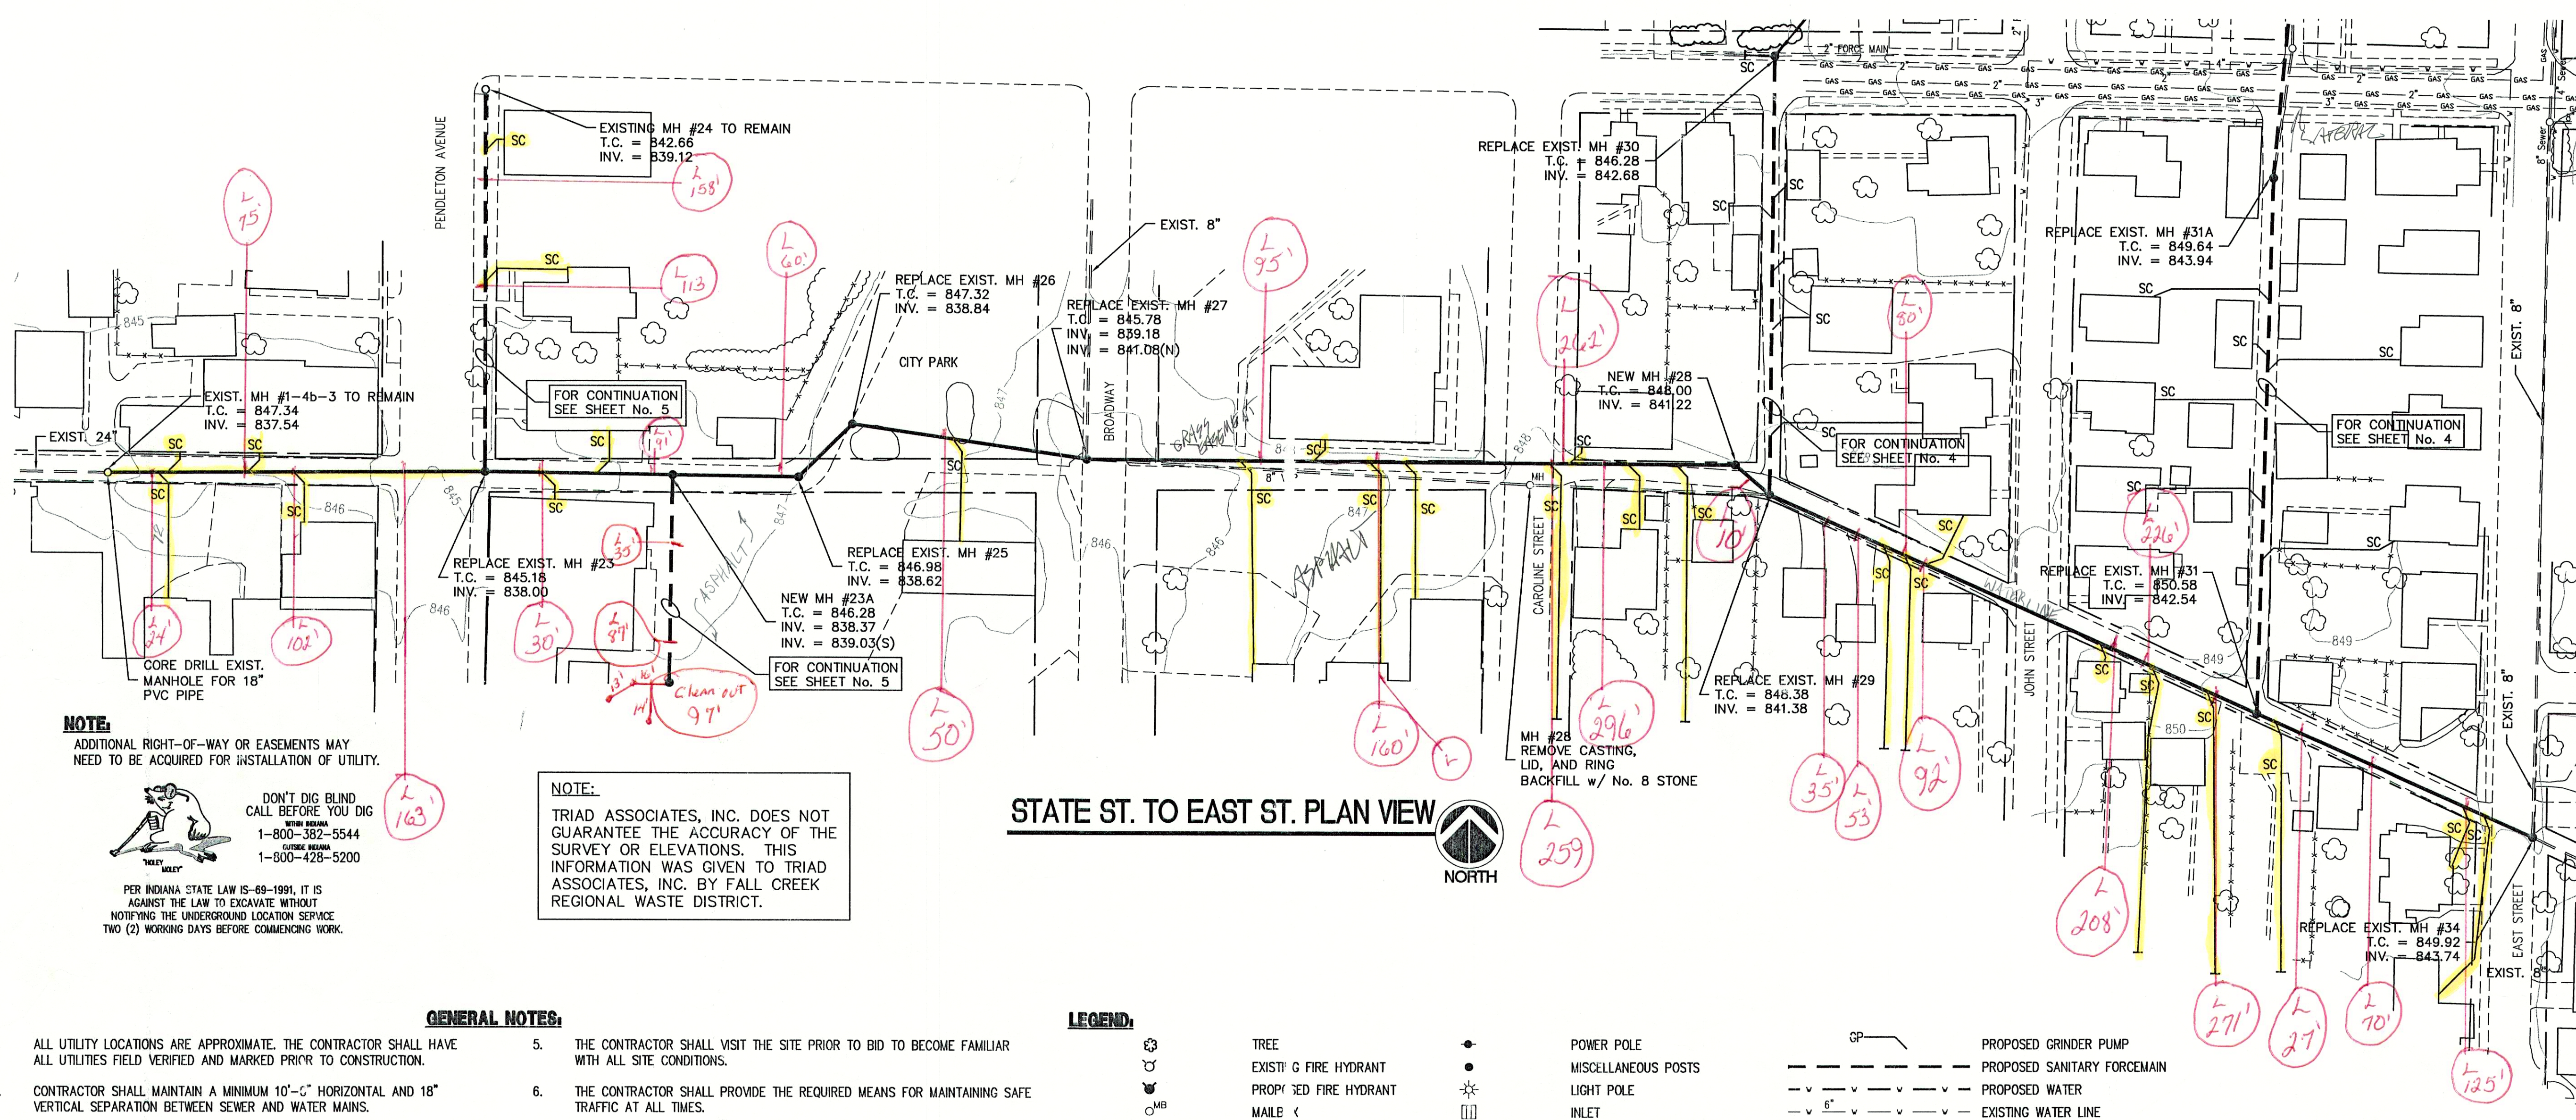

NOTE:
ADDITIONAL RIGHT-OF-WAY OR EASEMENTS MAY
NEED TO BE ACQUIRED FOR INSTALLATION OF UTILITY.

NOTE:
DON'T DIG BLIND
CALL BEFORE YOU DIG
800-382-5544
1-800-429-5200

PER INDIANA STATE LAW IS-69-1991, IT IS
AGAINST THE LAW TO EXCAVATE WITHOUT
NOTIFYING THE UNDERGROUND LOCATION SERVICE
TWO (2) WORKING DAYS BEFORE COMMENCING WORK.

NOTE:
TRIAD ASSOCIATES, INC. DOES NOT
GUARANTEE THE ACCURACY OF THE
SURVEY OR ELEVATIONS. THIS
INFORMATION WAS GIVEN TO TRIAD
ASSOCIATES, INC. BY FALL CREEK
REGIONAL WASTE DISTRICT.


STATE ST. TO EAST ST. PLAN VIEW



- GENERAL NOTES:**
- ALL UTILITY LOCATIONS ARE APPROXIMATE. THE CONTRACTOR SHALL HAVE ALL UTILITIES FIELD VERIFIED AND MARKED PRIOR TO CONSTRUCTION.
 - CONTRACTOR SHALL MAINTAIN A MINIMUM 10'-0" HORIZONTAL AND 18" VERTICAL SEPARATION BETWEEN SEWER AND WATER MAINS.
 - ALL PROPOSED TOP OF CASTING ELEVATIONS ARE APPROXIMATE. THE CONTRACTOR SHALL ADJUST FINAL ELEVATIONS AS REQUIRED TO BE FLUSH WITH PAVEMENT.
 - ALL SEWER TRENCHES SHALL BE BACKFILLED WITH FULL DEPTH COMPACTED GRANULAR BACKFILL ("B" BORROW) UNDER OR WITHIN 5' OF EDGE OF PAVEMENT.
 - THE CONTRACTOR SHALL VISIT THE SITE PRIOR TO BID TO BECOME FAMILIAR WITH ALL SITE CONDITIONS.
 - THE CONTRACTOR SHALL PROVIDE THE REQUIRED MEANS FOR MAINTAINING SAFE TRAFFIC AT ALL TIMES.
 - CONTRACTOR SHALL RESTORE ALL DISTURBED LAWN AREAS, STREETS, WALKS, DRIVES, ETC. AS SHOWN ON DRAWINGS, IN THE SPECIFICATIONS, OR TO AT LEAST PRE-EXISTING CONDITIONS.
 - ALL UTILITY CROSSINGS SHALL BE PROTECTED AND SUPPORTED WITH GRANULAR FILL OR CONCRETE AS REQUIRED PER THE DETAIL SHEET.
- LEGEND:**
- TREE
 - EXIST. G FIRE HYDRANT
 - PROPOSED FIRE HYDRANT
 - MAILE <
 - SIGN
 - SPOT HOT
 - CONT. IR
 - FENCE
 - EXIST. SANITARY SEWER w/ MANHOLE
 - POWER POLE
 - MISCELLANEOUS POSTS
 - LIGHT POLE
 - INLET
 - ASPHALT SURFACE
 - CONCRETE SURFACE
 - STONE SURFACE
 - NEW GRAVITY SERVICE CONNECTION
 - PROPOSED SANITARY GRAVITY
 - PROPOSED GRINDER PUMP
 - PROPOSED SANITARY FORCEMAIN
 - PROPOSED WATER
 - EXISTING WATER LINE
 - EXISTING ROAD DRAIN
 - GAS LINE
 - UNDERGROUND TELEPHONE LINE
 - EXISTING FIBER OPTIC LINE
 - APPROX. PROPERTY LINE
 - PROPOSED UTILITY EASEMENT
 - EXISTING UTILITY EASEMENT
 - APPROX. RIGHT-OF-WAY

BM #66 - STATE HIGHWAY MARKER, SOUTHWEST HEADWALL ON
MAIN STREET BRIDGE OVER FALL CREEK. EL. 840.35

SCALE
HORIZONTAL SCALE: 1" = 50'
VERTICAL SCALE: 1" = 5'

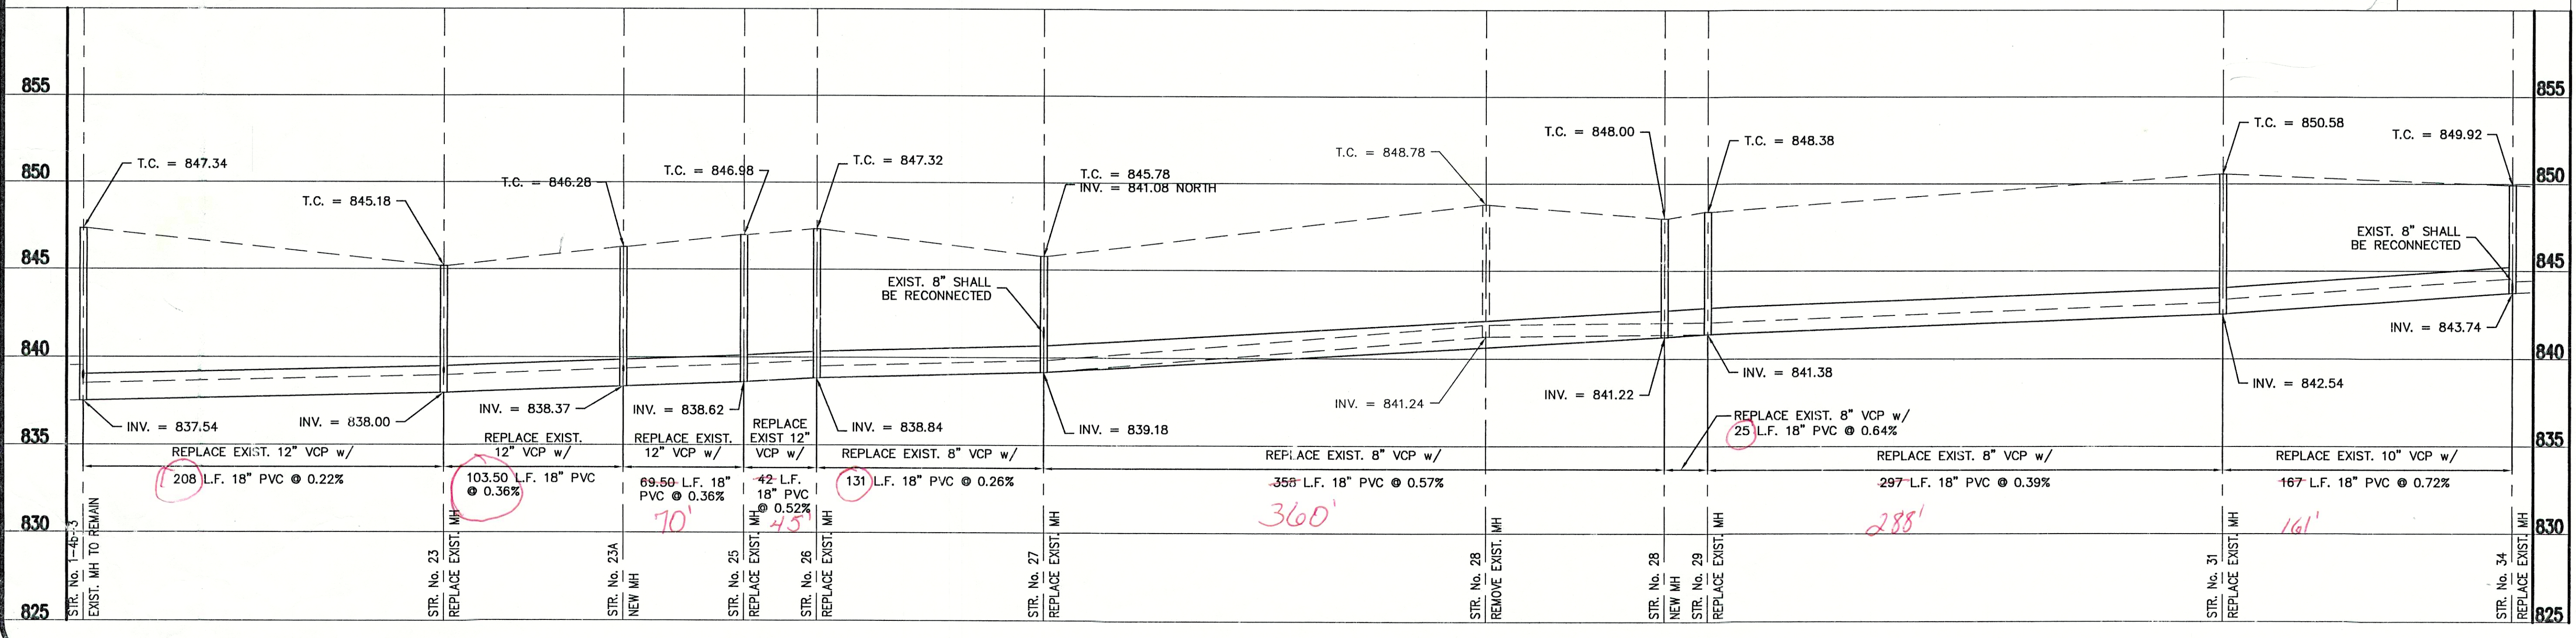

CONSULTANT:

REVISIONS:		
DATE	DESCRIPTION	BY

APPROVED BY:
09-18-03

THOMAS M. SCHUBERT
No. 15614
STATE OF INDIANA
PROFESSIONAL ENGINEER

TRIAD ASSOCIATES INC.
5835 LAWTON LOOP EAST DRIVE
INDIANAPOLIS, INDIANA 46216
PHONE: 317-377-5230 FAX: 317-377-5241

DESIGNED FOR:
**STATE STREET SANITARY SEWER
PROJECT - PHASE III**

SHEET TITLE:
STATE STREET PLAN AND PROFILE

JOB NUMBER: 200302G
SCALE: AS NOTED
PLOT SCALE: 1" = 50'
DRAWN BY: J.E.C.
DESIGNED BY: T.M.S.
DRAWING NAME: FCRWD3-BASE

CHECKED BY: T.M.S.
PLOT DATE: 09/23/03
DATE: 09/19/03

SHEET No.
3
OF 6