


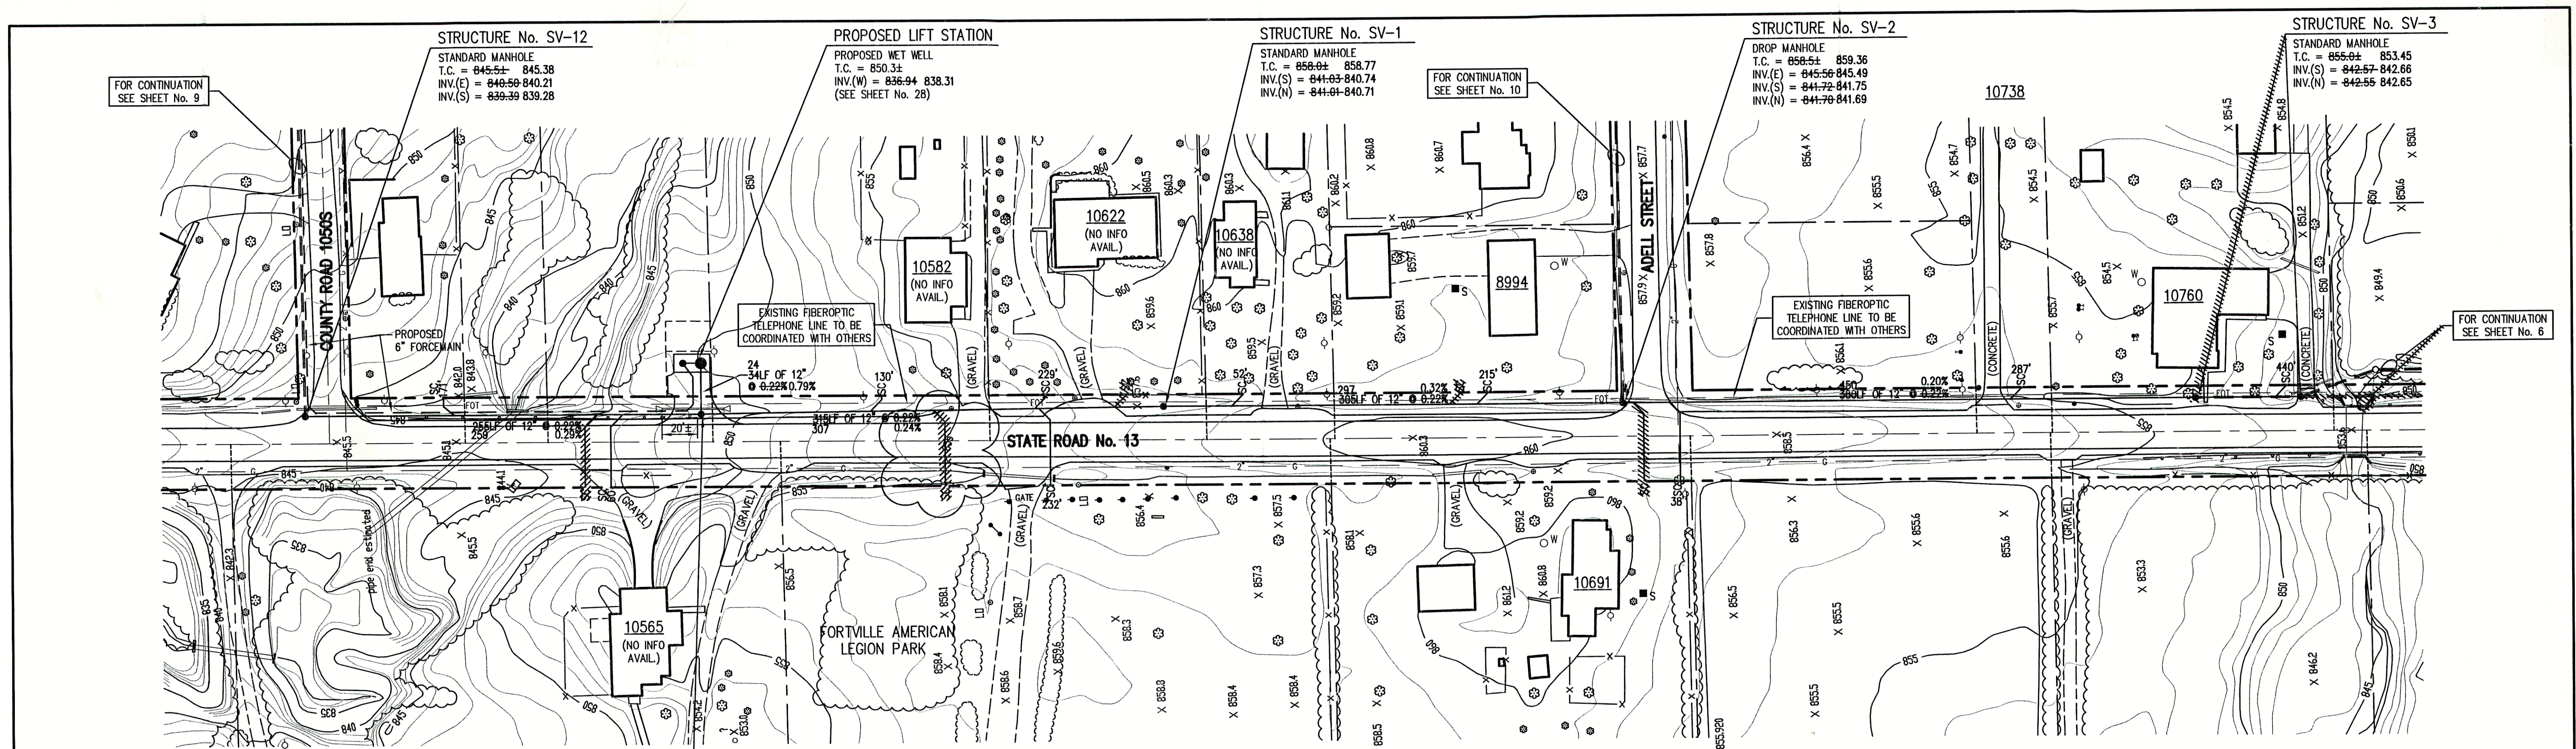

NOTE:
ADDITIONAL RIGHT-OF-WAY OR EASEMENTS MAY
NEED TO BE ACQUIRED FOR INSTALLATION OF SEWER.

**DON'T DIG BLIND
CALL BEFORE YOU DIG**
1-800-382-5544
1-800-428-5200

PER INDIANA STATE LAW IS-89-1991, IT IS
AGAINST THE LAW TO EXCAVATE WITHOUT
NOTIFYING THE UNDERGROUND LOCATION SERVICE
TWO (2) WORKING DAYS BEFORE COMMENCING WORK.


NOTE: CONTRACTOR TO VERIFY ALL UTILITY LOCATIONS
PRIOR TO THE START OF CONSTRUCTION

LEGEND:

TREE	1085	CONTOUR	---	UNDERGROUND ELECTRIC LINE
POWER POLE	X	FENCE	---	UNDERGROUND TELEPHONE LINE
GUY WIRE	WH	EXIST. SANITARY SEWER w/ MANHOLE	---	APPROX. RIGHT-OF-WAY
FIRE HYDRANT	SC	NEW SANITARY SEWER w/ MANHOLE	---	APPROX. CORPORATE LIMITS
MAILBOX	SC	NEW SANITARY SERVICE CONNECTION	---	APPROX. PROPERTY LINE
FLAGPOLE	4" W	WATER LINE	---	EXISTING WATER WELL
SPOT SHOT	2" G	GAS LINE	---	EXISTING SEPTIC TANK



SCALE:
HORIZONTAL 1" = 50'
VERTICAL 1" = 5'

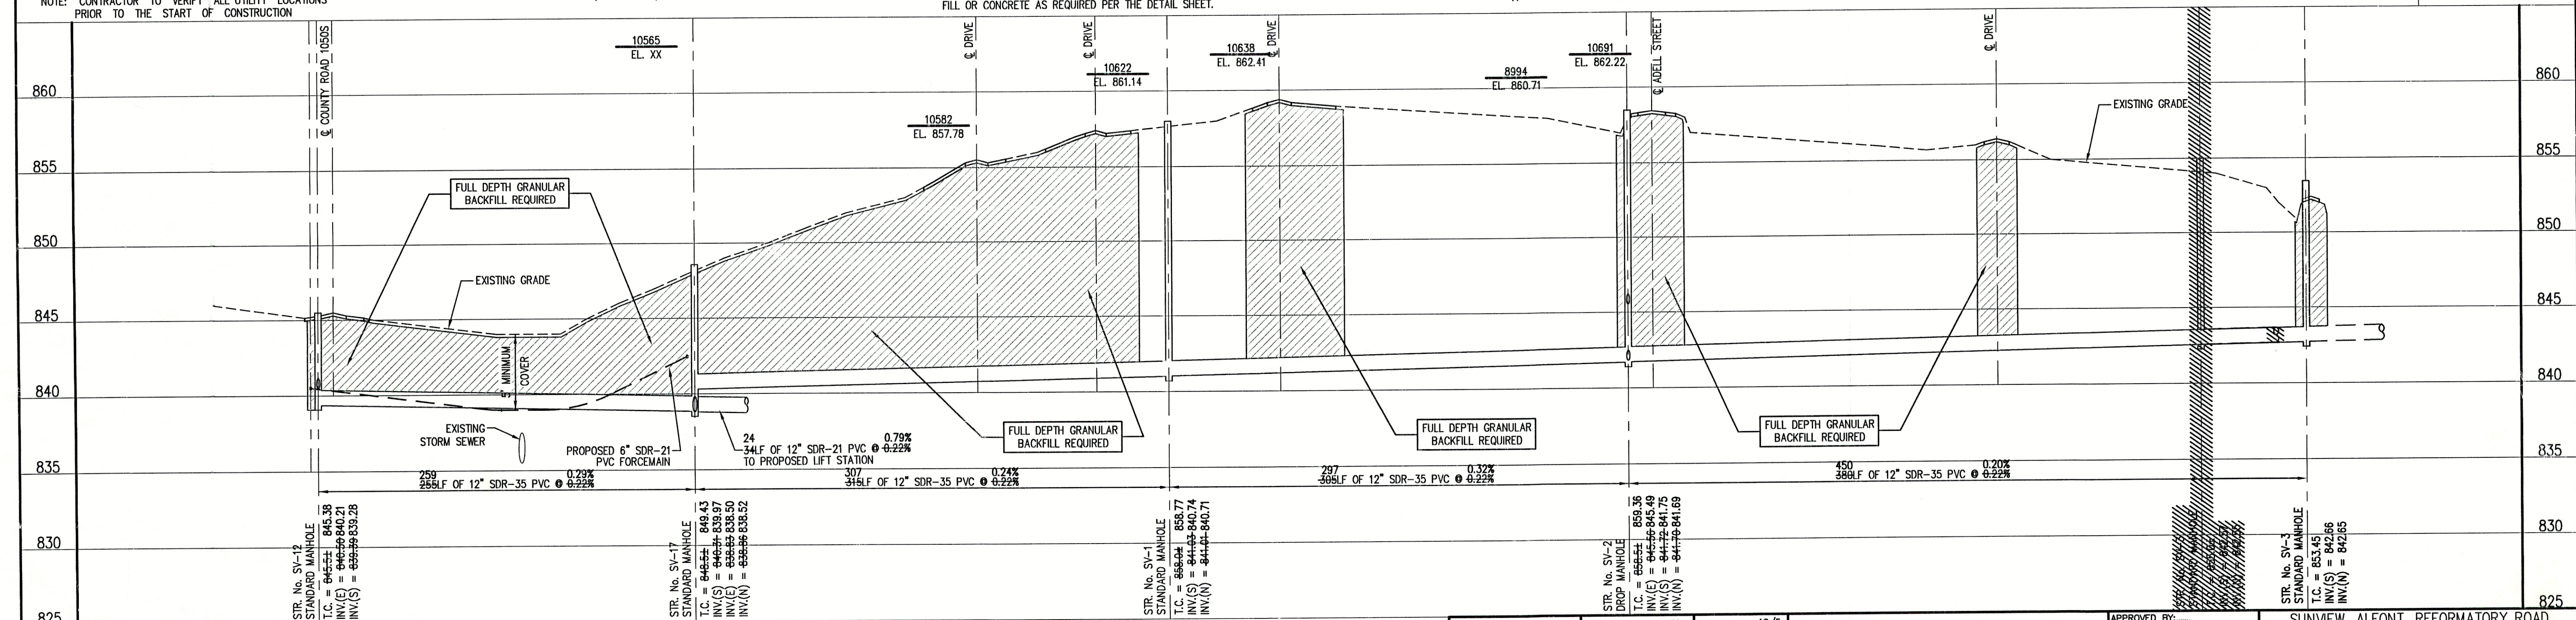

RECORD DRAWING

August 23, 2001

NOTE:

THE CONTRACTOR SHALL INCLUDE IN THE COSTS FOR SANITARY PIPE,
ALL WATER SERVICE RECONNECTIONS, STORM SEWER RECONNECTION,
WATER MAIN RELOCATIONS, CONCRETE RECONSTRUCTION, AND
SIDEWALK RECONSTRUCTION AS REQUIRED TO INSTALL NEW WORK
AS SHOWN ON THE DRAWINGS.

FILE NAME: SUN_2REV-RD		PLOT SCALE: 1=50	PLOT DATE: 12/5
NO.	DATE	DESCRIPTION	BY

**TRIAD
ASSOCIATES
INC.**
INDIANAPOLIS, INDIANA

APPROVED BY:
THOMAS M. SCHUBERT
No. 15614
STATE OF INDIANA
REGISTERED PROFESSIONAL ENGINEER
Thomas M. Schubert, P.E.

SUNVIEW, ALFONT, REFORMATORY ROAD
FALL CREEK REGIONAL WASTE DISTRICT
PLAN AND PROFILE
DRAWN BY: DAP
DATE: 04/12/98
SCALE: AS NOTED
PROJECT No. 98008A
SHEET No. 5
DESIGNED BY: D.A. Pauling
CHECKED BY: James W. Frazell, P.E.
OF 33