




NOTE:
ADDITIONAL RIGHT-OF-WAY OR EASEMENTS MAY
NEED TO BE ACQUIRED FOR INSTALLATION OF SEWER.

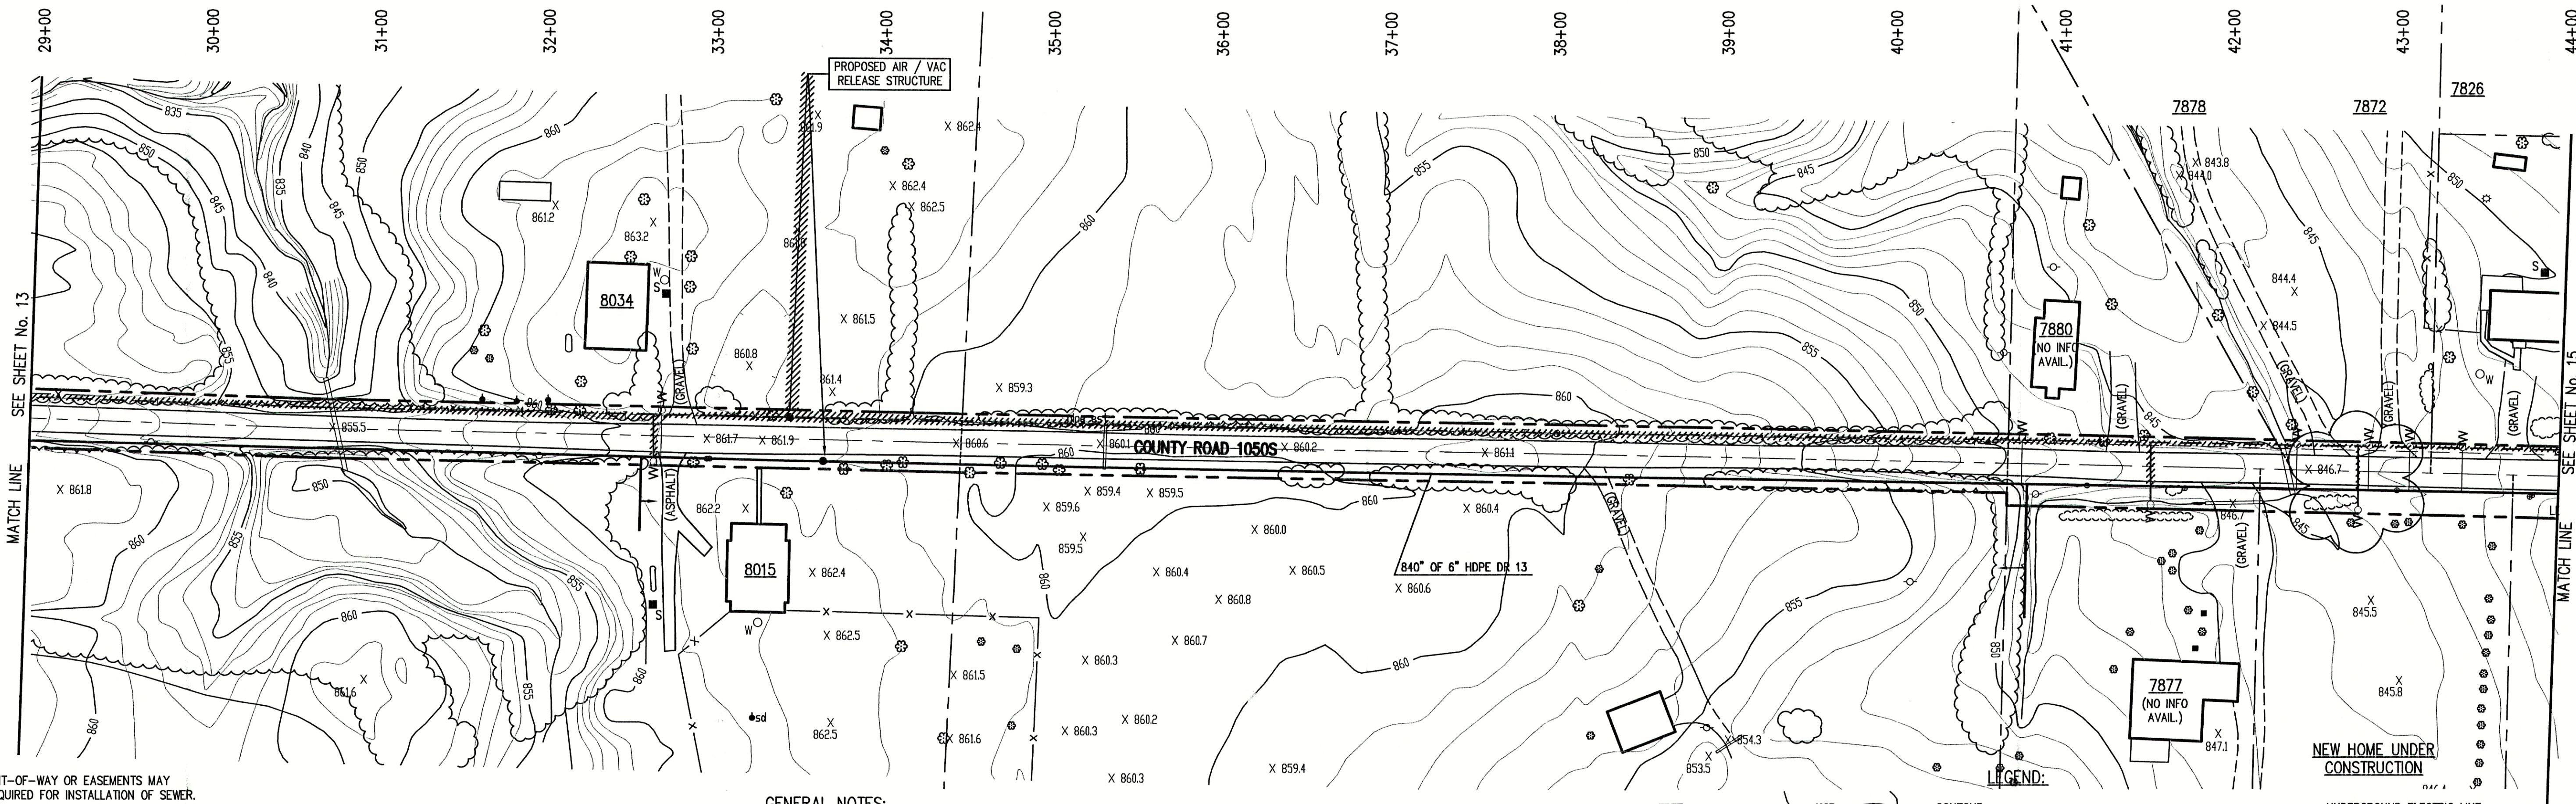

DON'T DIG BLIND
CALL BEFORE YOU DIG
TOLL FREE
1-800-382-5544
TOLL FREE
1-800-428-5200

PER INDIANA STATE LAW IS-69-1991, IT IS
AGAINST THE LAW TO EXCAVATE WITHOUT
NOTIFYING THE UNDERGROUND LOCATION SERVICE
TWO (2) WORKING DAYS BEFORE COMMENCING WORK.

NOTE: CONTRACTOR TO VERIFY ALL UTILITY LOCATIONS
PRIOR TO THE START OF CONSTRUCTION


GENERAL NOTES:

- ALL UTILITY LOCATIONS ARE APPROXIMATE. THE CONTRACTOR SHALL HAVE ALL UTILITIES FIELD VERIFIED AND MARKED PRIOR TO CONSTRUCTION.
- CONTRACTOR SHALL MAINTAIN A MINIMUM 10'-0" HORIZONTAL AND 18" VERTICAL SEPARATION BETWEEN SEWER AND WATER MAINS.
- ALL PROPOSED TOP OF CASTING ELEVATIONS ARE APPROXIMATE. THE CONTRACTOR SHALL ADJUST FINAL ELEVATIONS AS REQUIRED TO BE FLUSH WITH PAVEMENT.
- ALL SEWER TRENCHES SHALL BE BACKFILLED WITH FULL DEPTH COMPACTED GRANULAR BACKFILL ("B" BORROW) UNDER OR WITHIN 5' OF EDGE OF PAVEMENT.
- THE CONTRACTOR SHALL VISIT THE SITE PRIOR TO BID TO BECOME FAMILIAR WITH ALL SITE CONDITIONS.
- THE CONTRACTOR SHALL PROVIDE THE REQUIRED MEANS FOR MAINTAINING SAFE TRAFFIC AT ALL TIMES.
- CONTRACTOR SHALL RESTORE ALL DISTURBED LAWN AREAS, STREETS, WALKS, DRIVES, ETC. AS SHOWN ON DRAWINGS, IN THE SPECIFICATIONS, OR TO AT LEAST PRE-EXISTING CONDITIONS.
- ALL UTILITY CROSSINGS SHALL BE PROTECTED AND SUPPORTED WITH GRANULAR FILL OR CONCRETE AS REQUIRED PER THE DETAIL SHEET.

- LEGEND:
- | | | | | |
|--------------|--------|----------------------------------|-----------|------------------------------|
| TREE | 1085 | CONTOUR | — E — | UNDERGROUND ELECTRIC LINE |
| POWER POLE | X | FENCE | — T — | UNDERGROUND TELEPHONE LINE |
| GUY WIRE | — M — | EXIST. SANITARY SEWER w/ MANHOLE | — — — | APPROX. RIGHT-OF-WAY |
| FIRE HYDRANT | — SC — | NEW SANITARY SEWER w/ MANHOLE | — . . . — | APPROX. CORPORATE LIMITS |
| MAILBOX | — 4" — | NEW SANITARY SERVICE CONNECTION | — — — | APPROX. PROPERTY LINE |
| FLAGPOLE | — 2" — | WATER LINE | — — — | EXISTING WATER WELL |
| SPOT SHOT | — 2" — | GAS LINE | — — — | EXISTING SEPTIC TANK |
| | | | — — — | NEW GRINDER PUMP VALVE VAULT |




SCALE:
HORIZONTAL 1" = 50'
VERTICAL 1" = 5'

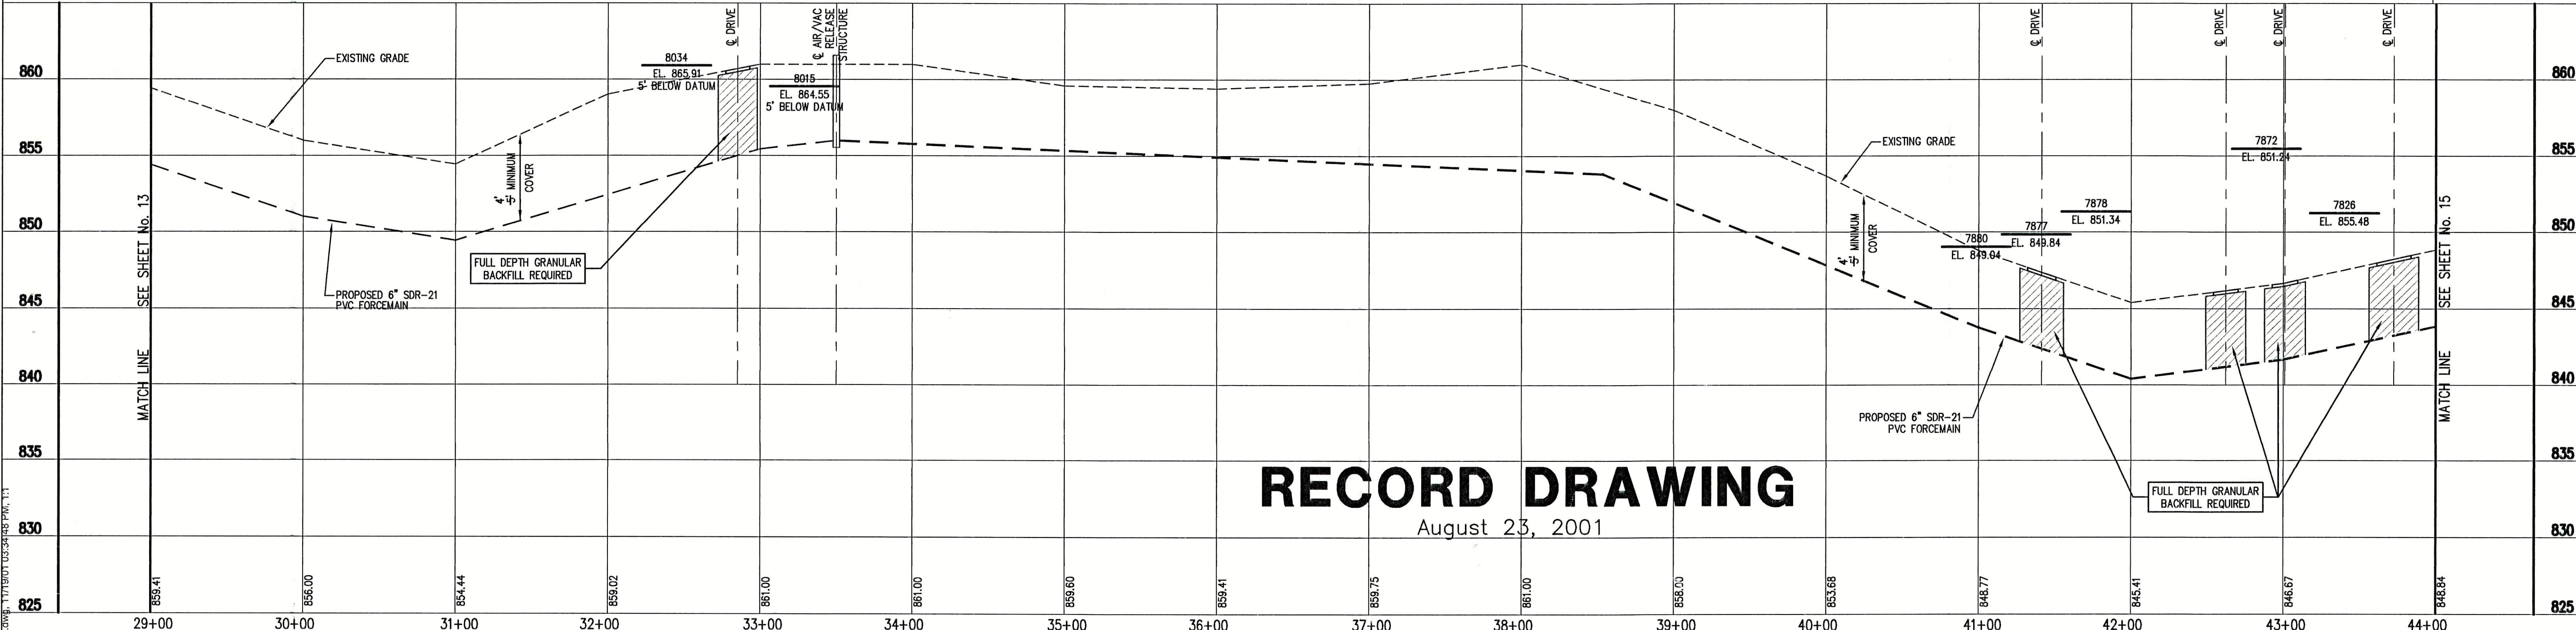

RECORD DRAWING
August 23, 2001

FILE NAME:	RCP03001-RD	PLOT SCALE:	1=1	PLOT DATE:	11/19
NO.	DATE	DESCRIPTION	BY		

TRIAD ASSOCIATES INC.
INDIANAPOLIS, INDIANA

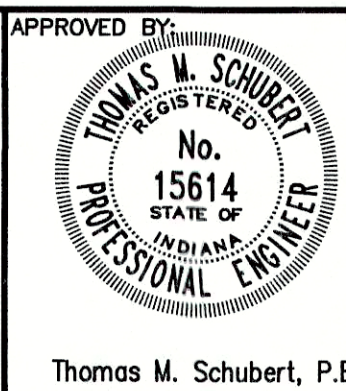

SUNVIEW, ALFONT, REFORMATORY ROAD FALL CREEK REGIONAL WASTE DISTRICT			
PLAN AND PROFILE			
DRAWN BY:	DATE: 04/12/98	PROJECT No.:	SHEET No.:
DAP	SCALE: AS NOTED	98008A	14
DESIGNED BY:	D.A. Pauling		
CHECKED BY:	James W. Frazell, P.E.		
			33