

NOTE:  
ADDITIONAL RIGHT-OF-WAY OR EASEMENTS MAY  
NEED TO BE ACQUIRED FOR INSTALLATION OF SEWER.



DON'T DIG BLIND  
CALL BEFORE YOU DIG  
800-382-5544  
1-800-428-5200

PER INDIANA STATE LAW IS-69-1991, IT IS  
AGAINST THE LAW TO EXCAVATE WITHOUT  
NOTIFYING THE UNDERGROUND LOCATION SERVICE  
TWO (2) WORKING DAYS BEFORE COMMENCING WORK.

NOTE: CONTRACTOR TO VERIFY ALL UTILITY LOCATIONS  
PRIOR TO THE START OF CONSTRUCTION

#### GENERAL NOTES:

- ALL UTILITY LOCATIONS ARE APPROXIMATE. THE CONTRACTOR SHALL VISIT THE SITE PRIOR TO BID TO BECOME FAMILIAR WITH ALL SITE CONDITIONS.
- CONTRACTOR SHALL MAINTAIN A MINIMUM 10'-0" HORIZONTAL AND 18" VERTICAL SEPARATION BETWEEN SEWER AND WATER MAINS.
- ALL PROPOSED TOP OF CASTING ELEVATIONS ARE APPROXIMATE. THE CONTRACTOR SHALL ADJUST FINAL ELEVATIONS AS REQUIRED TO BE FLUSH WITH PAVEMENT.
- ALL SEWER TRENCHES SHALL BE BACKFILLED WITH FULL DEPTH COMPACTED GRANULAR BACKFILL ("B" BORROW) UNDER OR WITHIN 5' OF EDGE OF PAVEMENT.
- THE CONTRACTOR SHALL VISIT THE SITE PRIOR TO BID TO BECOME FAMILIAR WITH ALL SITE CONDITIONS.
- THE CONTRACTOR SHALL PROVIDE THE REQUIRED MEANS FOR MAINTAINING SAFE TRAFFIC AT ALL TIMES.
- CONTRACTOR SHALL RESTORE ALL DISTURBED LAWN AREAS, STREETS, WALKS, DRIVES, ETC. AS SHOWN ON DRAWINGS, IN THE SPECIFICATIONS, OR TO AT LEAST PRE-EXISTING CONDITIONS.
- ALL UTILITY CROSSINGS SHALL BE PROTECTED AND SUPPORTED WITH GRANULAR FILL OR CONCRETE AS REQUIRED PER THE DETAIL SHEET.


- LEGEND:
- |              |        |                                  |     |                            |
|--------------|--------|----------------------------------|-----|----------------------------|
| TREE         | —X—X—  | CONTOUR                          | —E— | UNDERGROUND ELECTRIC LINE  |
| POWER POLE   | —X—X—  | FENCE                            | —T— | UNDERGROUND TELEPHONE LINE |
| GUY WIRE     | —MH—   | EXIST. SANITARY SEWER w/ MANHOLE | —   | APPROX. RIGHT-OF-WAY       |
| FIRE HYDRANT | —      | NEW SANITARY SEWER w/ MANHOLE    | —   | APPROX. CORPORATE LIMITS   |
| MAILBOX      | —SC—   | NEW SANITARY SERVICE CONNECTION  | —   | APPROX. PROPERTY LINE      |
| FLAGPOLE     | —4"—W— | WATER LINE                       | —   | EXISTING WATER WELL        |
| SPOT SHOT    | —2"—G— | GAS LINE                         | —   | EXISTING SEPTIC TANK       |
- W/O — NEW GRINDER PUMP VALVE VAULT



SCALE:  
HORIZONTAL 1" = 50'  
VERTICAL 1" = 5'

## RECORD DRAWING

August 23, 2001

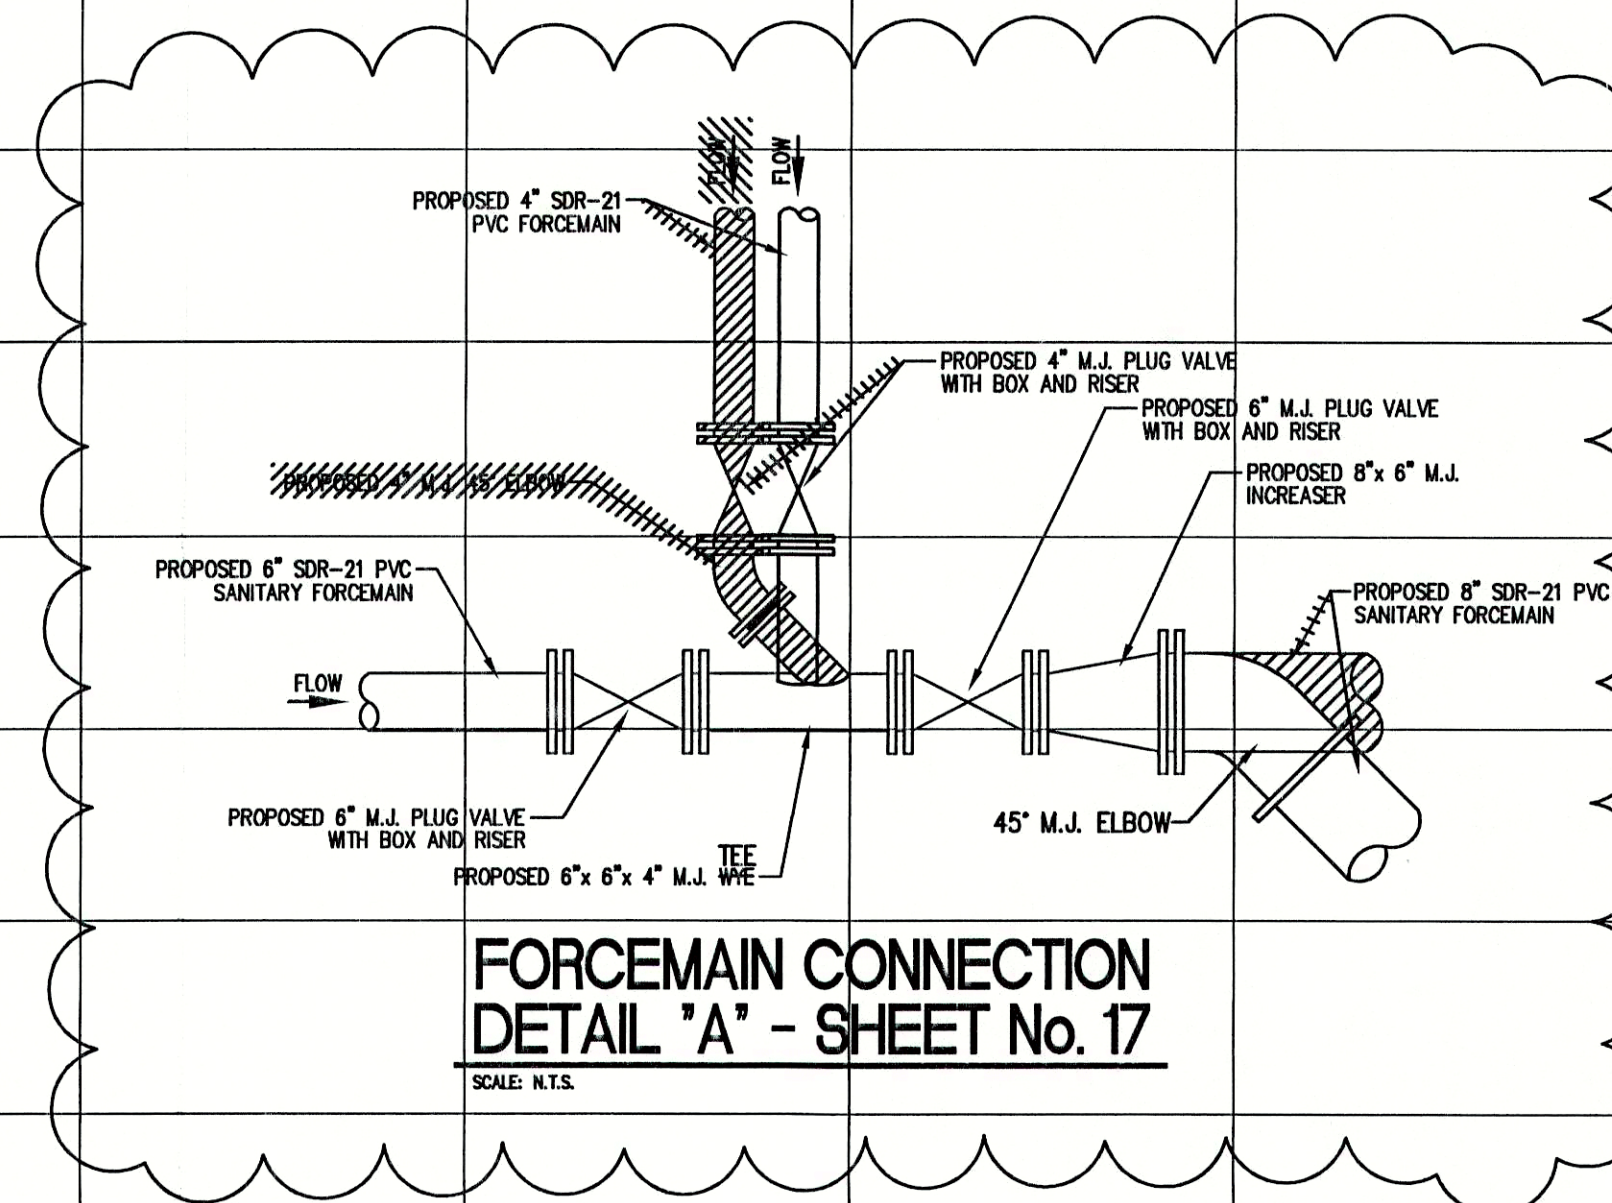

### FORCEMAIN CONNECTION DETAIL 'A' - SHEET No. 17

SCALE: N.T.S.

FILE NAME: RCP08001-RD PLOT SCALE: 1=1 PLOT DATE: 12/5

NO.	DATE	DESCRIPTION	BY

**TRIAD  
ASSOCIATES  
INC.**  
INDIANAPOLIS, INDIANA

APPROVED BY:  
**THOMAS M. SCHUBERT**  
REGISTERED  
No. 15614  
STATE OF INDIANA  
PROFESSIONAL ENGINEER  
Thomas M. Schubert, P.E.

SUNVIEW, ALFONT, REFORMATORY ROAD  
FALL CREEK REGIONAL WASTE DISTRICT  
PLAN AND PROFILE  
DRAWN BY: DAP DATE: 04/12/98 PROJECT No. 98008A SHEET No. 19  
SCALE: AS NOTED  
DESIGNED BY: D.A. Pauling  
CHECKED BY: James W. Frazell, P.E.

33