


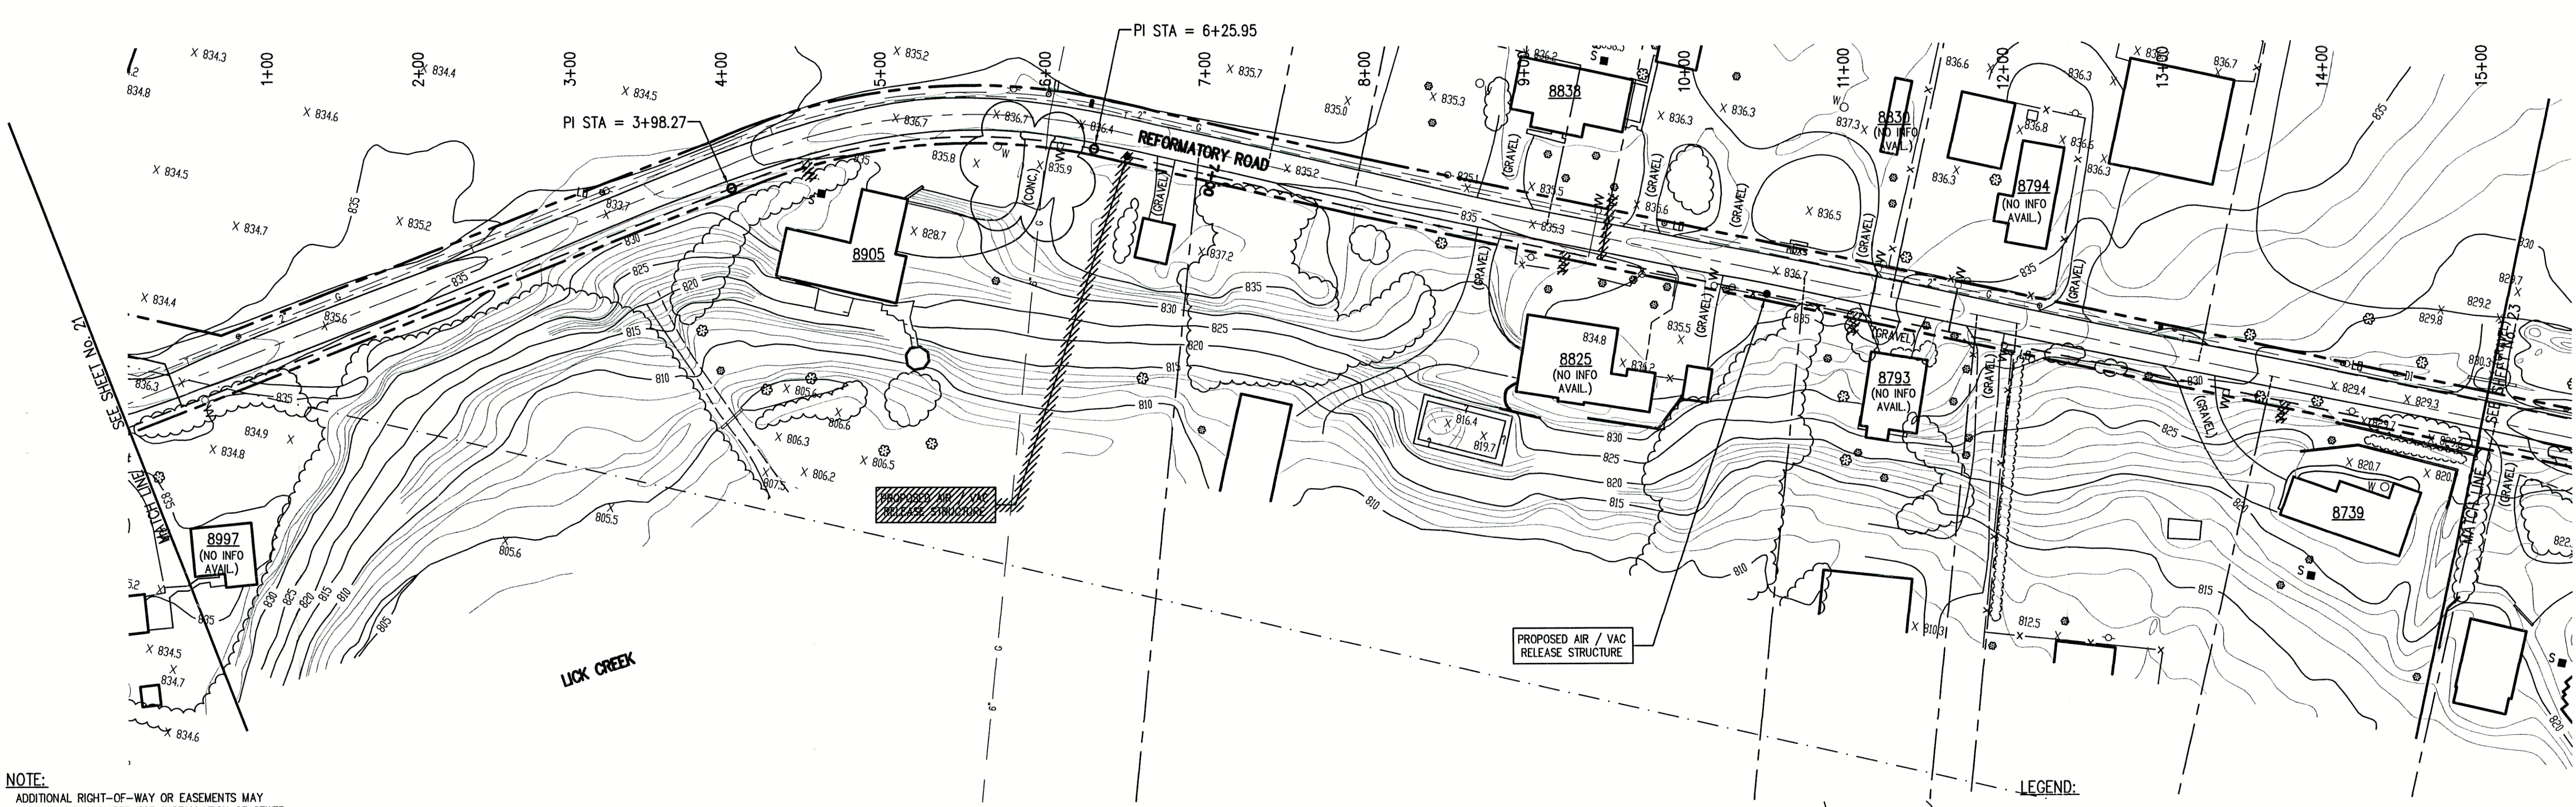

NOTE:
ADDITIONAL RIGHT-OF-WAY OR EASEMENTS MAY
NEED TO BE ACQUIRED FOR INSTALLATION OF SEWER.

GENERAL NOTES:

- ALL UTILITY LOCATIONS ARE APPROXIMATE. THE CONTRACTOR SHALL HAVE ALL UTILITIES FIELD VERIFIED AND MARKED PRIOR TO CONSTRUCTION.
- CONTRACTOR SHALL MAINTAIN A MINIMUM 10'-0" HORIZONTAL AND 18" VERTICAL SEPARATION BETWEEN SEWER AND WATER MAINS.
- ALL PROPOSED TOP OF CASTING ELEVATIONS ARE APPROXIMATE. THE CONTRACTOR SHALL ADJUST FINAL ELEVATIONS AS REQUIRED TO BE FLUSH WITH PAVEMENT.
- ALL SEWER TRENCHES SHALL BE BACKFILLED WITH FULL DEPTH COMPACTED GRANULAR BACKFILL ("B" BORROW) UNDER OR WITHIN 5' OF EDGE OF PAVEMENT.
- THE CONTRACTOR SHALL VISIT THE SITE PRIOR TO BID TO BECOME FAMILIAR WITH ALL SITE CONDITIONS.
- THE CONTRACTOR SHALL PROVIDE THE REQUIRED MEANS FOR MAINTAINING SAFE TRAFFIC AT ALL TIMES.
- CONTRACTOR SHALL RESTORE ALL DISTURBED LAWN AREAS, STREETS, WALKS, DRIVES, ETC. AS SHOWN ON DRAWINGS, IN THE SPECIFICATIONS, OR TO AT LEAST PRE-EXISTING CONDITIONS.
- ALL UTILITY CROSSINGS SHALL BE PROTECTED AND SUPPORTED WITH GRANULAR FILL OR CONCRETE AS REQUIRED PER THE DETAIL SHEET.

- LEGEND:
- TREE
 - POWER POLE
 - GUY WIRE
 - FIRE HYDRANT
 - MAILBOX
 - FLAGPOLE
 - SPOT SHOT
 - CONTOUR
 - FENCE
 - EXIST. SANITARY SEWER w/ MANHOLE
 - NEW SANITARY SEWER w/ MANHOLE
 - NEW SANITARY SERVICE CONNECTION
 - WATER LINE
 - GAS LINE
 - UNDERGROUND ELECTRIC LINE
 - UNDERGROUND TELEPHONE LINE
 - APPROX. RIGHT-OF-WAY
 - APPROX. CORPORATE LIMITS
 - APPROX. PROPERTY LINE
 - EXISTING WATER WELL
 - EXISTING SEPTIC TANK
 - NEW GRINDER PUMP VALVE VAULT




SCALE:
HORIZONTAL 1" = 50'
VERTICAL 1" = 5'

DON'T DIG BLIND
CALL BEFORE YOU DIG
TOLL FREE
1-800-382-5544
1-800-428-5200

PER INDIANA STATE LAW IS-69-1991, IT IS
AGAINST THE LAW TO EXCAVATE WITHOUT
NOTIFYING THE UNDERGROUND LOCATION SERVICE
TWO (2) WORKING DAYS BEFORE COMMENCING WORK.

NOTE: CONTRACTOR TO VERIFY ALL UTILITY LOCATIONS
PRIOR TO THE START OF CONSTRUCTION

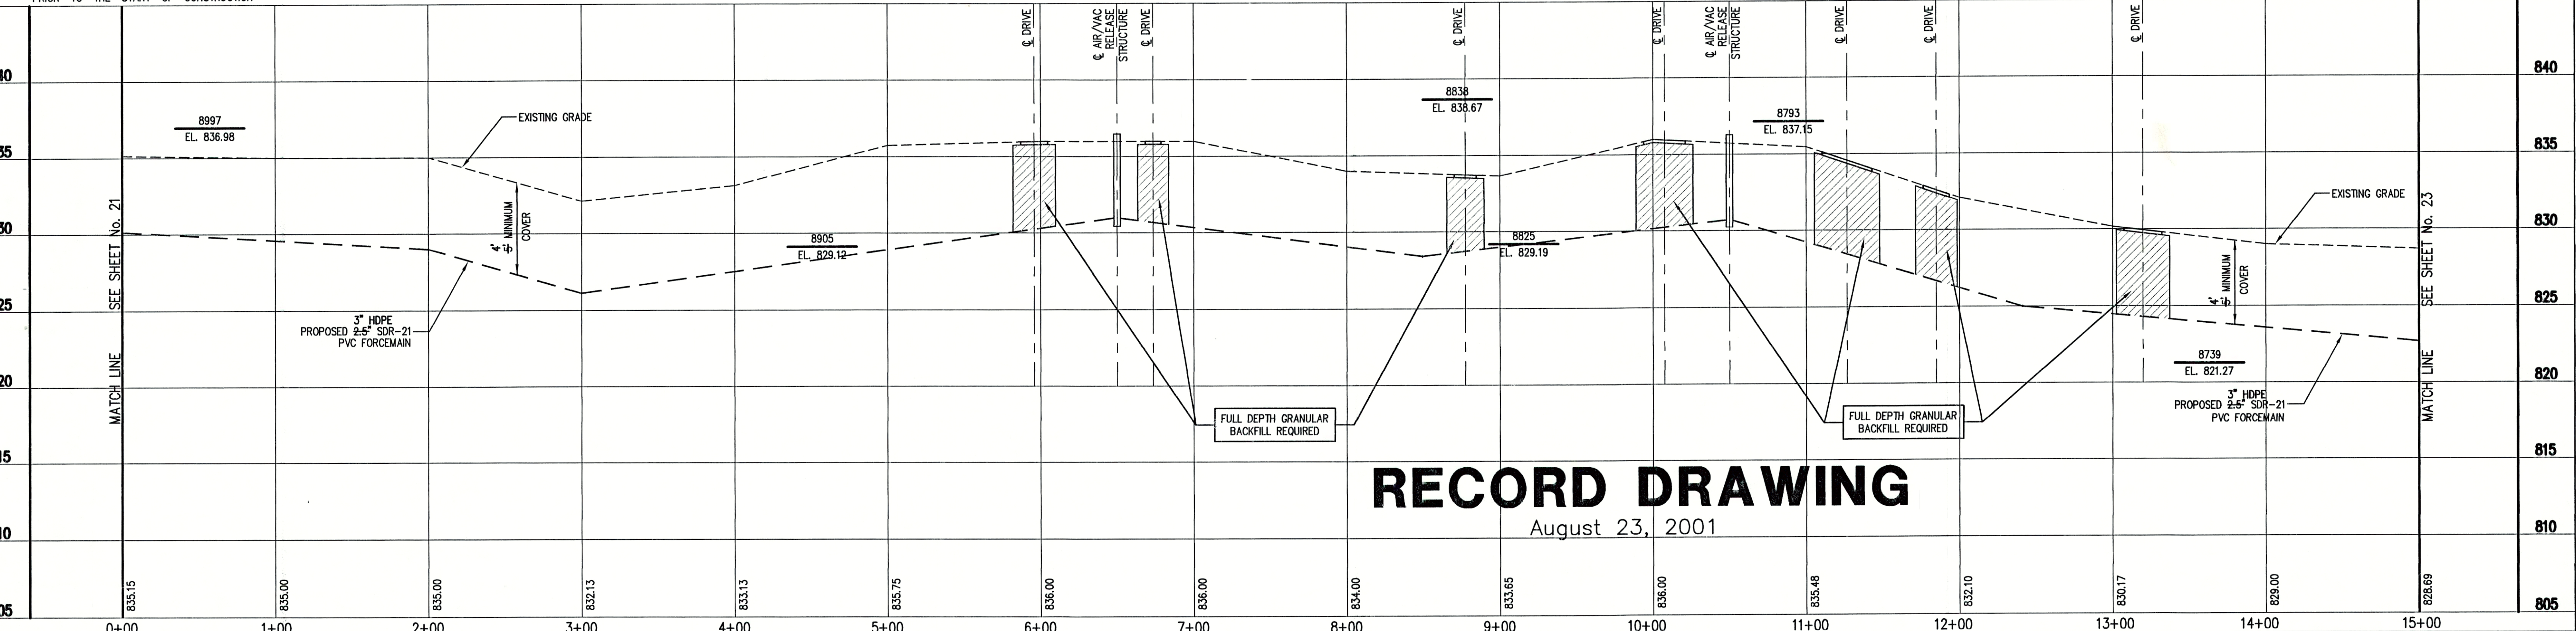

RECORD DRAWING
August 23, 2001

FILE NAME: RCP01002-RD		PLOT SCALE: 1=1	PLOT DATE: 11/20
NO.	DATE	DESCRIPTION	BY

TRIAD ASSOCIATES INC.

INDIANAPOLIS, INDIANA

APPROVED BY:

THOMAS M. SCHUBERT
REGISTERED
No. 15614
STATE OF INDIANA
PROFESSIONAL ENGINEER

Thomas M. Schubert, P.E.

SUNVIEW, ALFONT, REFORMATORY ROAD
FALL CREEK REGIONAL WASTE DISTRICT

PLAN AND PROFILE

DRAWN BY: DATE 04/12/98 PROJECT No. 98008A SHEET No. 22
DAP SCALE AS NOTED
DESIGNED BY: D.A. Pauling
CHECKED BY: James W. Frazell, P.E.

33