




RECORD DRAWING

August 23, 2001

NOTE:
ADDITIONAL RIGHT-OF-WAY OR EASEMENTS MAY
NEED TO BE ACQUIRED FOR INSTALLATION OF SEWER.

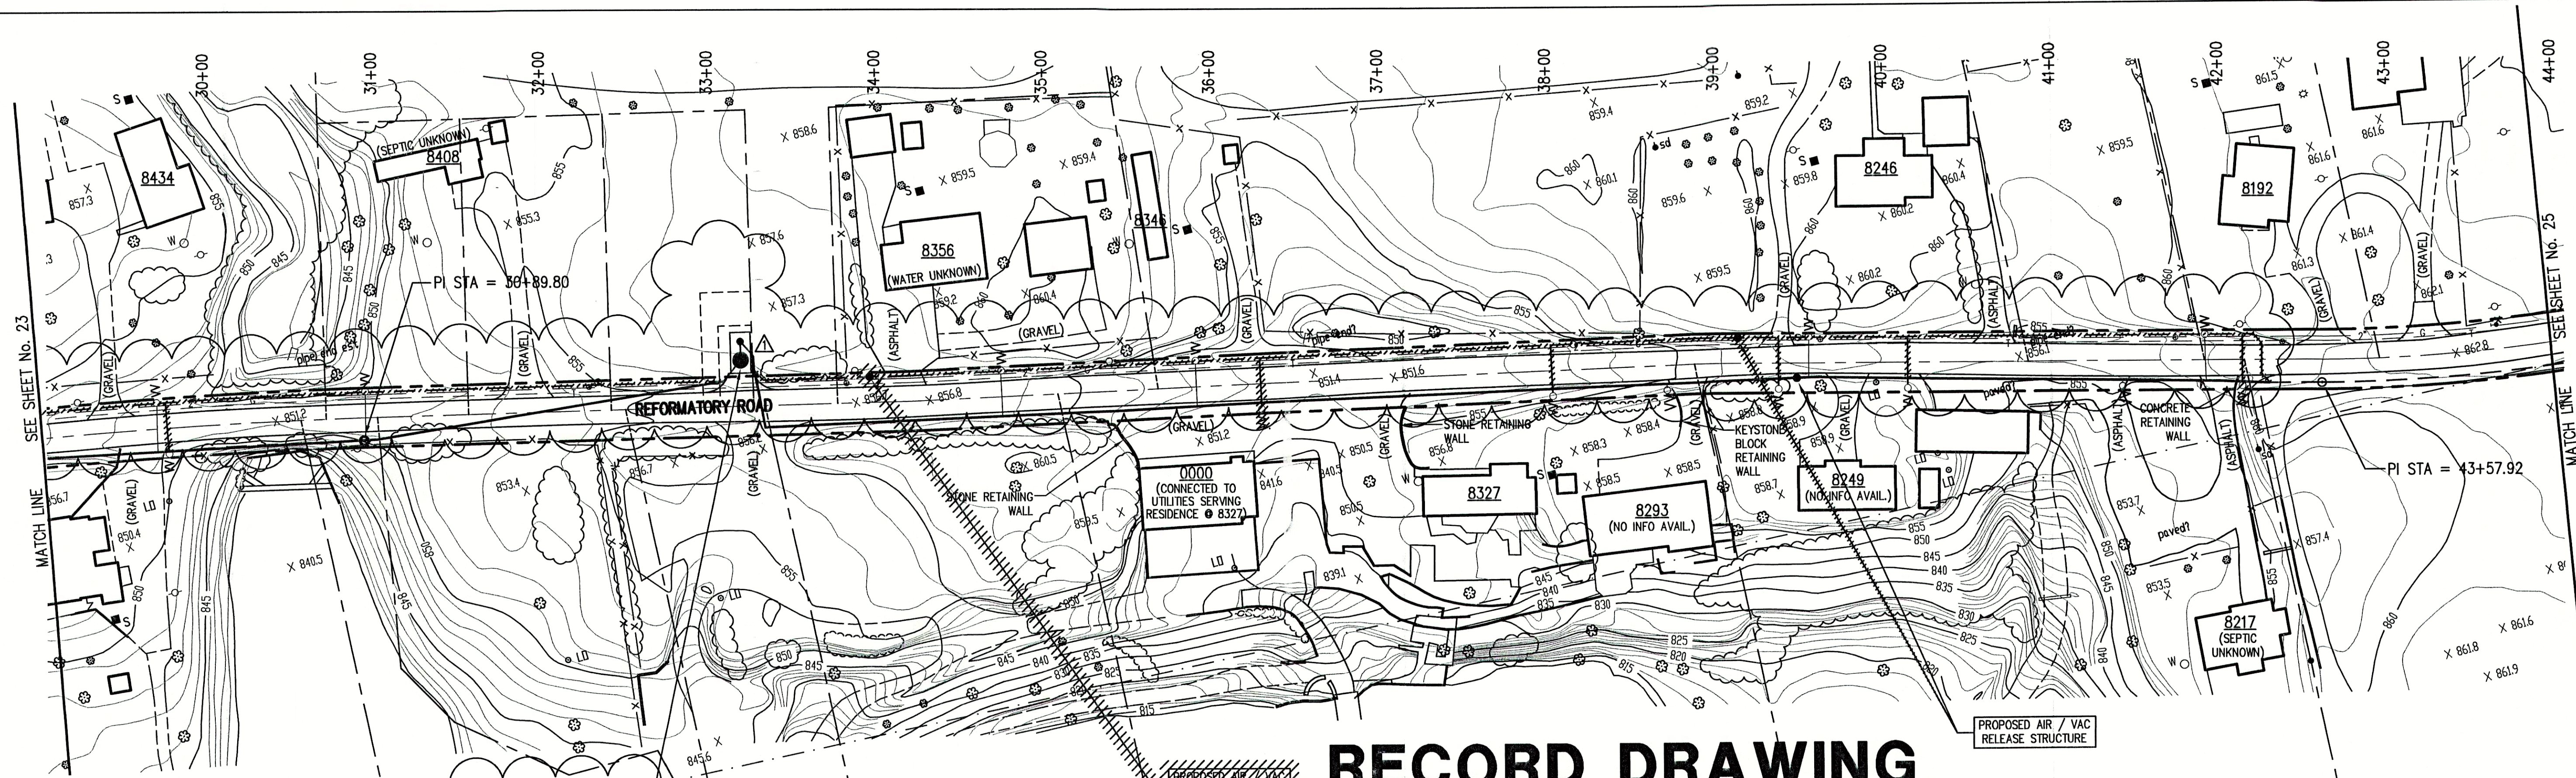

DON'T DIG BLIND
CALL BEFORE YOU DIG
1-800-382-5544
1-800-428-5200

PER INDIANA STATE LAW IS-69-1991, IT IS
AGAINST THE LAW TO EXCAVATE WITHOUT
NOTIFYING THE UNDERGROUND LOCATION SERVICE
TWO (2) WORKING DAYS BEFORE COMMENCING WORK.

NOTE: CONTRACTOR TO VERIFY ALL UTILITY LOCATIONS
PRIOR TO THE START OF CONSTRUCTION

GENERAL NOTES:


- ALL UTILITY LOCATIONS ARE APPROXIMATE. THE CONTRACTOR SHALL VISIT THE SITE PRIOR TO BID TO BECOME FAMILIAR WITH ALL SITE CONDITIONS.
- CONTRACTOR SHALL MAINTAIN A MINIMUM 10'-0" HORIZONTAL AND 18" VERTICAL SEPARATION BETWEEN SEWER AND WATER MAINS.
- ALL PROPOSED TOP OF CASTING ELEVATIONS ARE APPROXIMATE. THE CONTRACTOR SHALL ADJUST FINAL ELEVATIONS AS REQUIRED TO BE FLUSH WITH PAVEMENT.
- ALL SEWER TRENCHES SHALL BE BACKFILLED WITH FULL DEPTH COMPACTED GRANULAR BACKFILL ("B" BORROW) UNDER OR WITHIN 3' OF EDGE OF PAVEMENT.
- THE CONTRACTOR SHALL VISIT THE SITE PRIOR TO BID TO BECOME FAMILIAR WITH ALL SITE CONDITIONS.
- THE CONTRACTOR SHALL PROVIDE THE REQUIRED MEANS FOR MAINTAINING SAFE TRAFFIC AT ALL TIMES.
- CONTRACTOR SHALL RESTORE ALL DISTURBED LAWN AREAS, STREETS, WALKS, DRIVES, ETC. AS SHOWN ON DRAWINGS, IN THE SPECIFICATIONS, OR TO AT LEAST PRE-EXISTING CONDITIONS.
- ALL UTILITY CROSSINGS SHALL BE PROTECTED AND SUPPORTED WITH GRANULAR FILL OR CONCRETE AS REQUIRED PER THE DETAIL SHEET.

LEGEND:

- | | | | |
|----------|--------------|------------|----------------------------------|
| • | TREE | 1085 | CONTOUR |
| ○ | POWER POLE | — X — X — | FENCE |
| — | GUY WIRE | — MH — | EXIST. SANITARY SEWER w/ MANHOLE |
| • | FIRE HYDRANT | — SC — | NEW SANITARY SEWER w/ MANHOLE |
| MB | MAILBOX | — 4" — W — | NEW SANITARY SERVICE CONNECTION |
| FP | FLAGPOLE | — 2" — G — | WATER LINE |
| X 1085.2 | SPOT SHOT | | GAS LINE |
| — E — | | | UNDERGROUND ELECTRIC LINE |
| — T — | | | UNDERGROUND TELEPHONE LINE |
| — | | | APPROX. RIGHT-OF-WAY |
| — | | | APPROX. CORPORATE LIMITS |
| — | | | APPROX. PROPERTY LINE |
| ○ W | | | EXISTING WATER WELL |
| ■ S | | | EXISTING SEPTIC TANK |
| WO | | | NEW GRINDER PUMP VALVE VAULT |



SCALE:
HORIZONTAL 1" = 50'
VERTICAL 1" = 5'

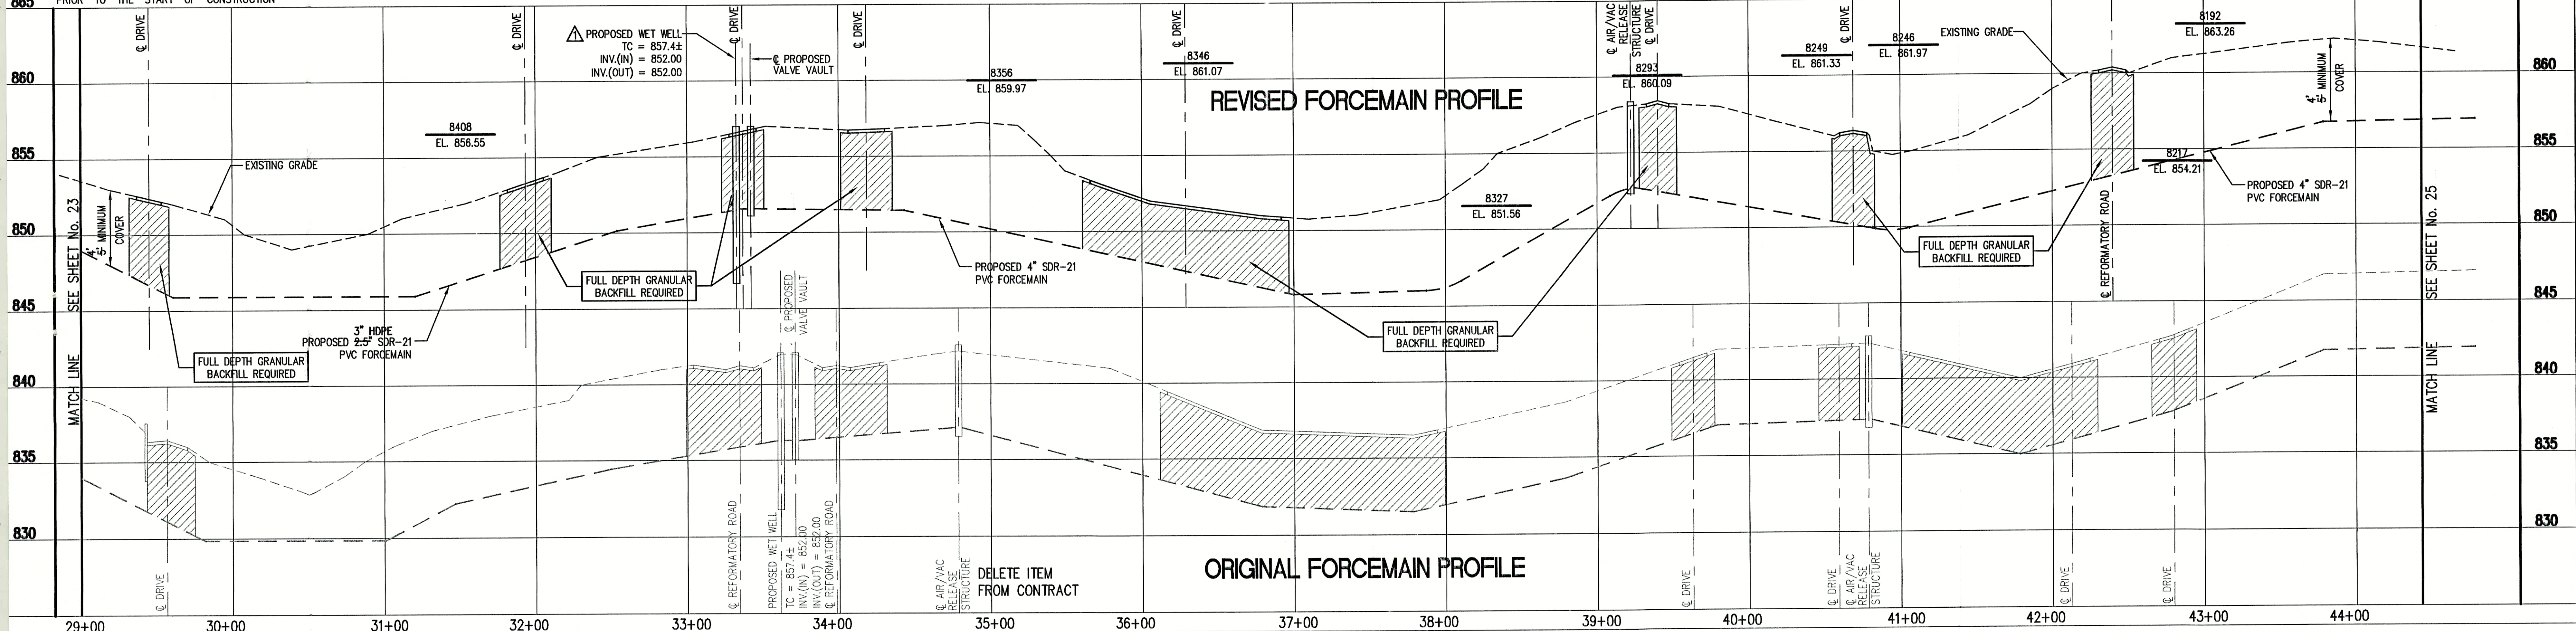

FILE NAME: RCP03002-RD		PLOT SCALE: 1=1	PLOT DATE: 12/6
	07/14/99	LIFT STATION RELOCATED	D.A.P.
NO.	DATE	DESCRIPTION	BY

TRIAD ASSOCIATES INC.
INDIANAPOLIS, INDIANA

APPROVED BY:
THOMAS M. SCHUBERT
REGISTERED
No. 15614
STATE OF INDIANA
PROFESSIONAL ENGINEER
Thomas M. Schubert, P.E.

SUNVIEW, ALFONT, REFORMATORY ROAD
FALL CREEK REGIONAL WASTE DISTRICT
PLAN AND PROFILE
DRAWN BY: DATE 04/12/98 PROJECT No. SHEET No.
DAP SCALE AS NOTED 98008A 24
DESIGNED BY: D.A. Pauling
CHECKED BY: James W. Frazell, P.E.
33