


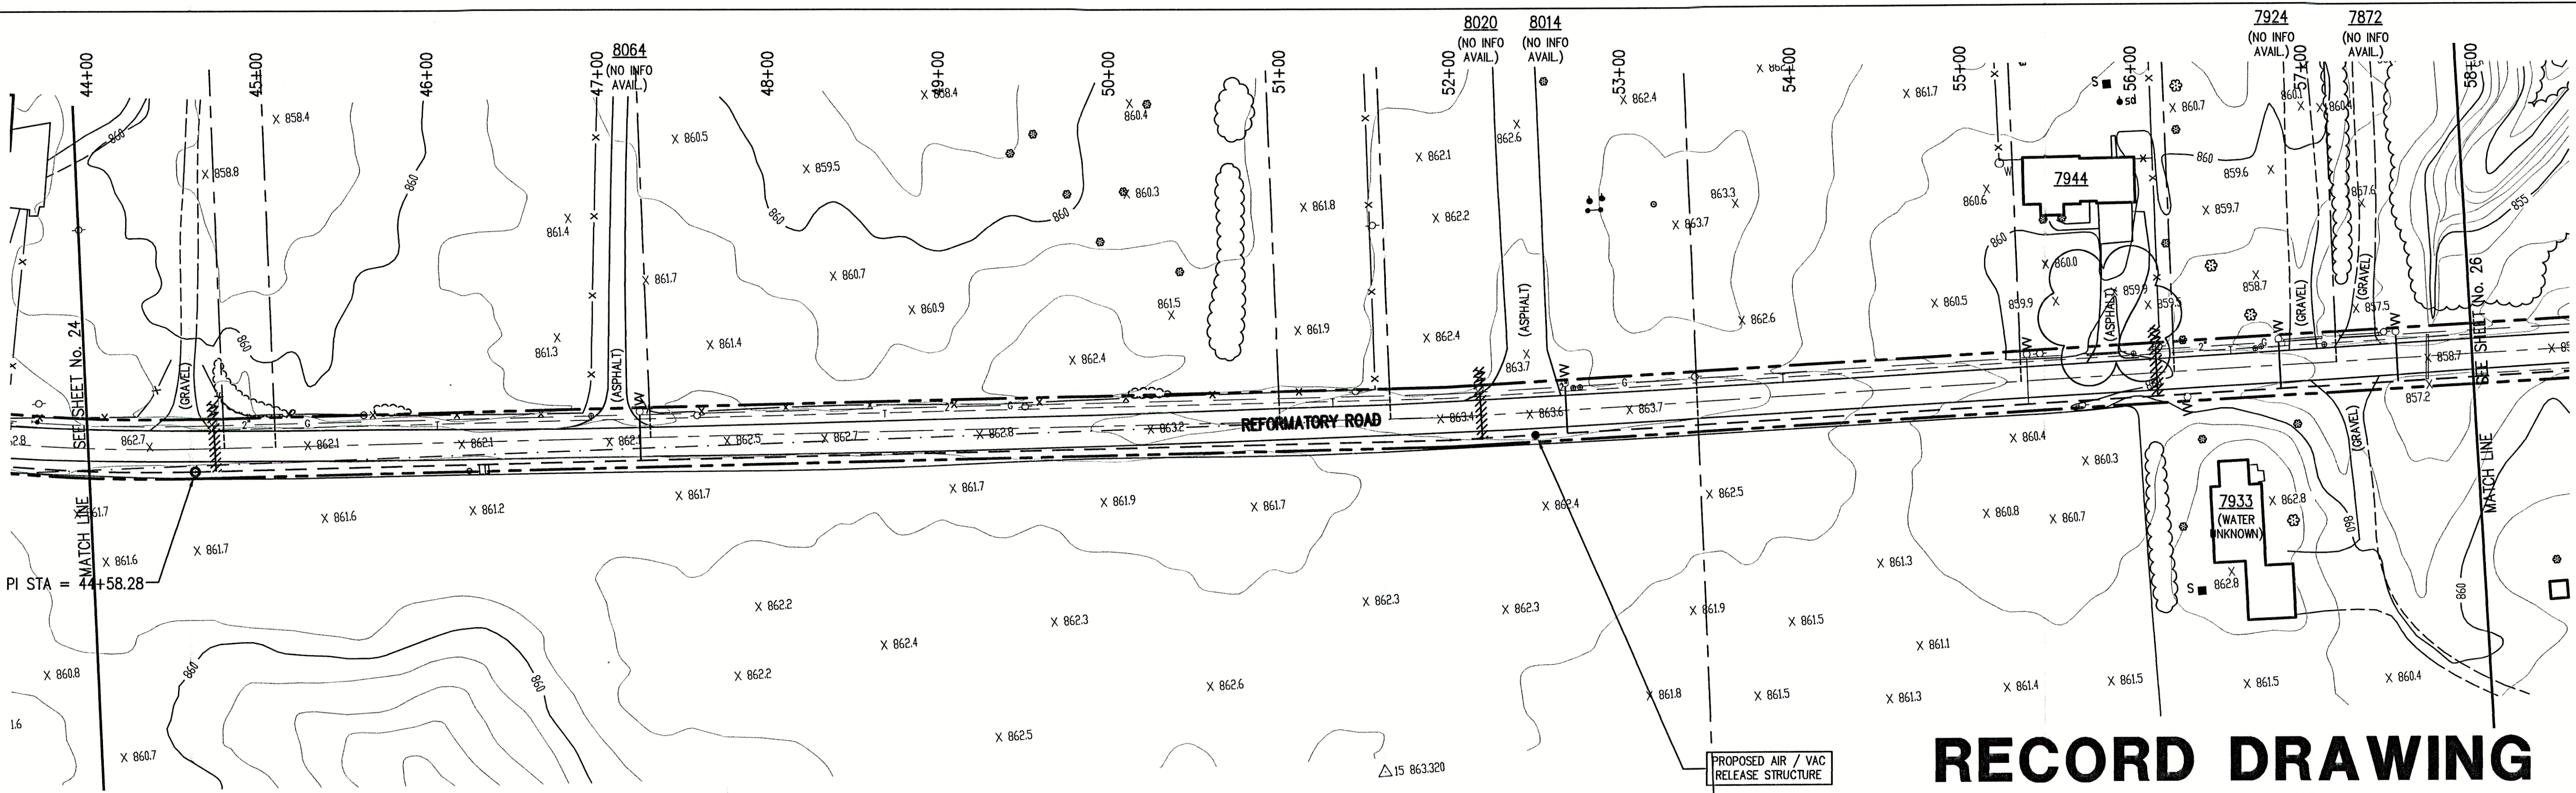

RECORD DRAWING

August 23, 2001

NOTE:
ADDITIONAL RIGHT-OF-WAY OR EASEMENTS MAY
NEED TO BE ACQUIRED FOR INSTALLATION OF SEWER.

PER INDIANA STATE LAW IS-68-1981, IT IS
AGAINST THE LAW TO EXCAVATE WITHOUT
NOTIFYING THE UNDERGROUND LOCATION SERVICE
TWO (2) WORKING DAYS BEFORE COMMENCING WORK.

DON'T DIG BLIND
CALL BEFORE YOU DIG
1-800-382-5544
1-800-428-5200

NOTE: CONTRACTOR TO VERIFY ALL UTILITY LOCATIONS
PRIOR TO THE START OF CONSTRUCTION

GENERAL NOTES:


- ALL UTILITY LOCATIONS ARE APPROXIMATE. THE CONTRACTOR SHALL HAVE ALL UTILITIES FIELD VERIFIED AND MARKED PRIOR TO CONSTRUCTION.
- CONTRACTOR SHALL MAINTAIN A MINIMUM 10'-0" HORIZONTAL AND 18" VERTICAL SEPARATION BETWEEN SEWER AND WATER MAINS.
- ALL PROPOSED TOP OF CASTING ELEVATIONS ARE APPROXIMATE. THE CONTRACTOR SHALL ADJUST FINAL ELEVATIONS AS REQUIRED TO BE FLUSH WITH PAVEMENT.
- ALL SEWER TRENCHES SHALL BE BACKFILLED WITH FULL DEPTH COMPACTED GRANULAR BACKFILL ("B" BORROW) UNDER OR WITHIN 5' OF EDGE OF PAVEMENT.
- THE CONTRACTOR SHALL VISIT THE SITE PRIOR TO BID TO BECOME FAMILIAR WITH ALL SITE CONDITIONS.
- THE CONTRACTOR SHALL PROVIDE THE REQUIRED MEANS FOR MAINTAINING SAFE TRAFFIC AT ALL TIMES.
- CONTRACTOR SHALL RESTORE ALL DISTURBED LAWN AREAS, STREETS, WALKS, DRIVES, ETC. AS SHOWN ON DRAWINGS, IN THE SPECIFICATIONS, OR TO AT LEAST PRE-EXISTING CONDITIONS.
- ALL UTILITY CROSSINGS SHALL BE PROTECTED AND SUPPORTED WITH GRANULAR FILL OR CONCRETE AS REQUIRED PER THE DETAIL SHEET.

LEGEND:

TREE	1085	CONTOUR	UNDERGROUND ELECTRIC LINE
POWER POLE	X	FENCE	UNDERGROUND TELEPHONE LINE
GUY WIRE	—X—	EXIST. SANITARY SEWER w/ MANHOLE	APPROX. RIGHT-OF-WAY
FIRE HYDRANT	SC	NEW SANITARY SEWER w/ MANHOLE	APPROX. CORPORATE LIMITS
MAILBOX	—X—	NEW SANITARY SERVICE CONNECTION	APPROX. PROPERTY LINE
FLAGPOLE	—X—	WATER LINE	EXISTING WATER WELL
SPOT SHOT	—X—	GAS LINE	EXISTING SEPTIC TANK
			NEW GRINDER PUMP VALVE VAULT



SCALE:
HORIZONTAL 1" = 50'
VERTICAL 1" = 5'

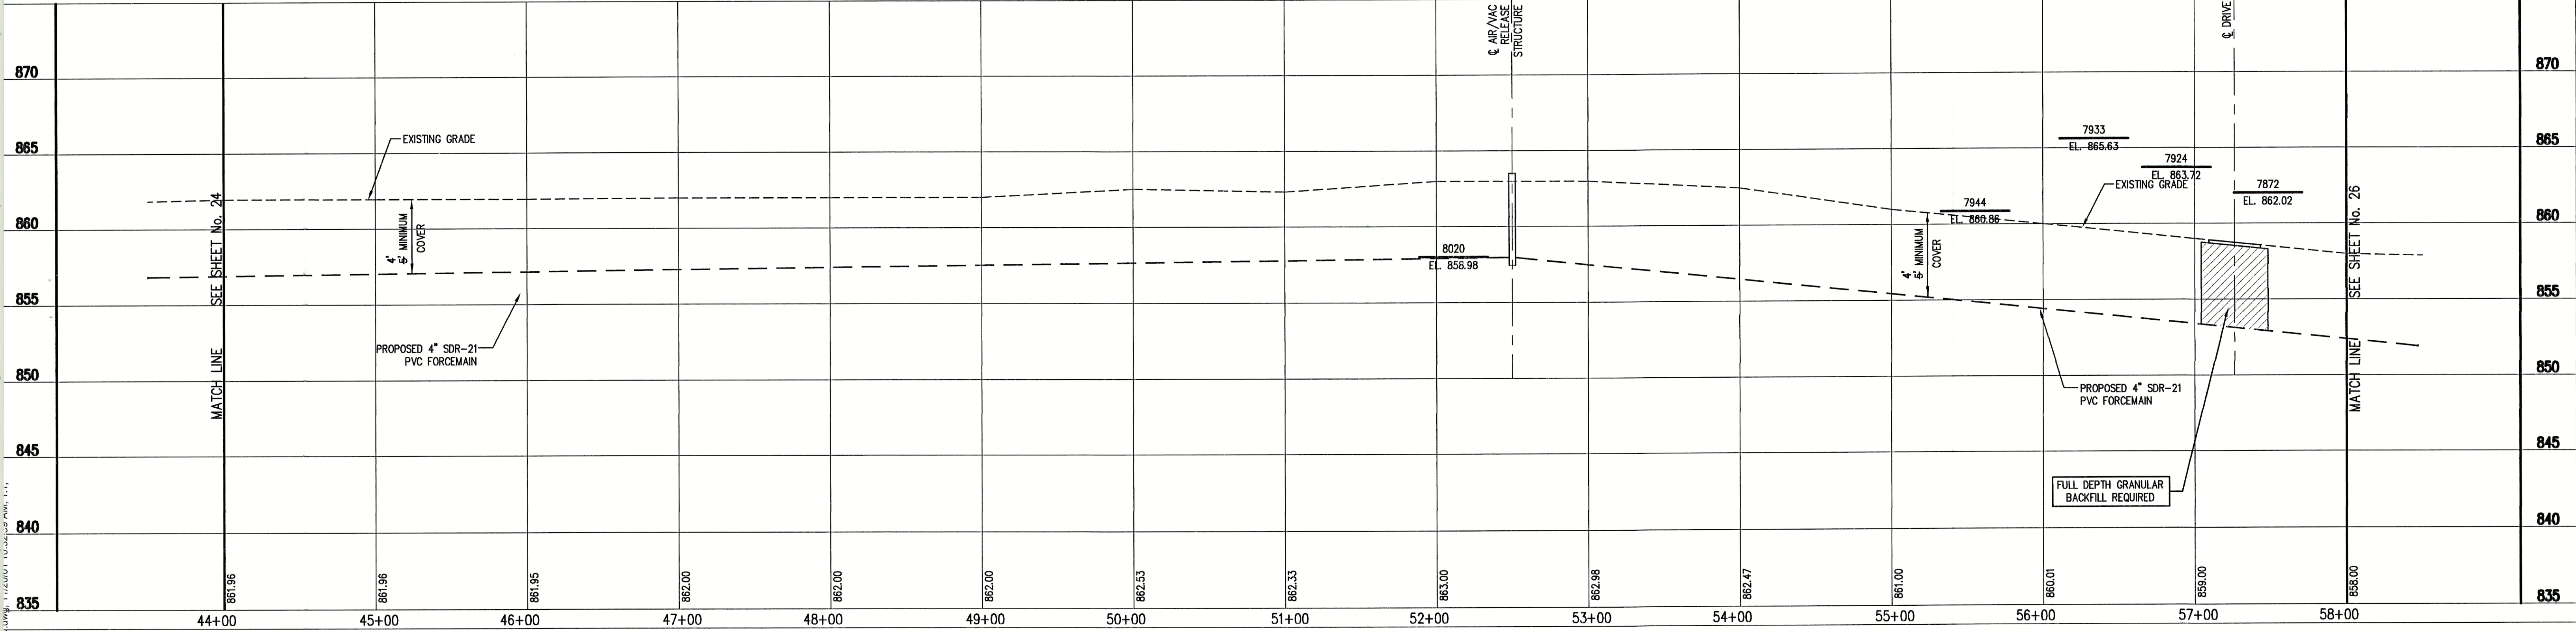

FILE NAME: RCP04002-RD PLOT SCALE: 1=1 PLOT DATE: 11/20			
NO.	DATE	DESCRIPTION	BY

TRIAD ASSOCIATES INC.

INDIANAPOLIS, INDIANA

APPROVED BY:

THOMAS M. SCHUBERT
No. 15614
STATE OF INDIANA
PROFESSIONAL ENGINEER

Thomas M. Schubert, P.E.

SUNVIEW, ALFONT, REFORMATORY ROAD
FALL CREEK REGIONAL WASTE DISTRICT

PLAN AND PROFILE

DRAWN BY:	DATE	04/12/98	PROJECT No.	98008A	SHEET No.	25
DESIGNED BY:	SCALE	AS NOTED	DESIGNED BY:	D.A. Pauling	CHECKED BY:	James W. Frazell, P.E.

33